



FINISH LEGEND

FINISH	MANUFACTURER	STYLE	COLOR	NUMBER	COMMENTS
PT-1 DARK GRAY	DUNN EDWARDS	FLAT	BOAT ANCHOR	DE6311	SUBJECT TO OWNER CHANGE
PT-2 MED GRAY	DUNN EDWARDS	FLAT	WALRUS	DE 368	SUBJECT TO OWNER CHANGE
PT-3 LIGHT GRAY	DUNN EDWARDS	FLAT	SILVER LINED	DE655	SUBJECT TO OWNER CHANGE
PT-4 BLUE	MODERN MASTERS THEME PAINT	FLAT	BEHR - SONG BIRD	SG 540	G.C. TO MATCH BEHR PAINT USING MODERN MASTERS THEME PAINT NO EXCEPTIONS
PT-5 ORANGE	MODERN MASTERS THEME PAINT	FLAT	BEHR - PUMPKIN PATCH	SH 250	G.C. TO MATCH BEHR PAINT USING MODERN MASTERS THEME PAINT NO EXCEPTIONS

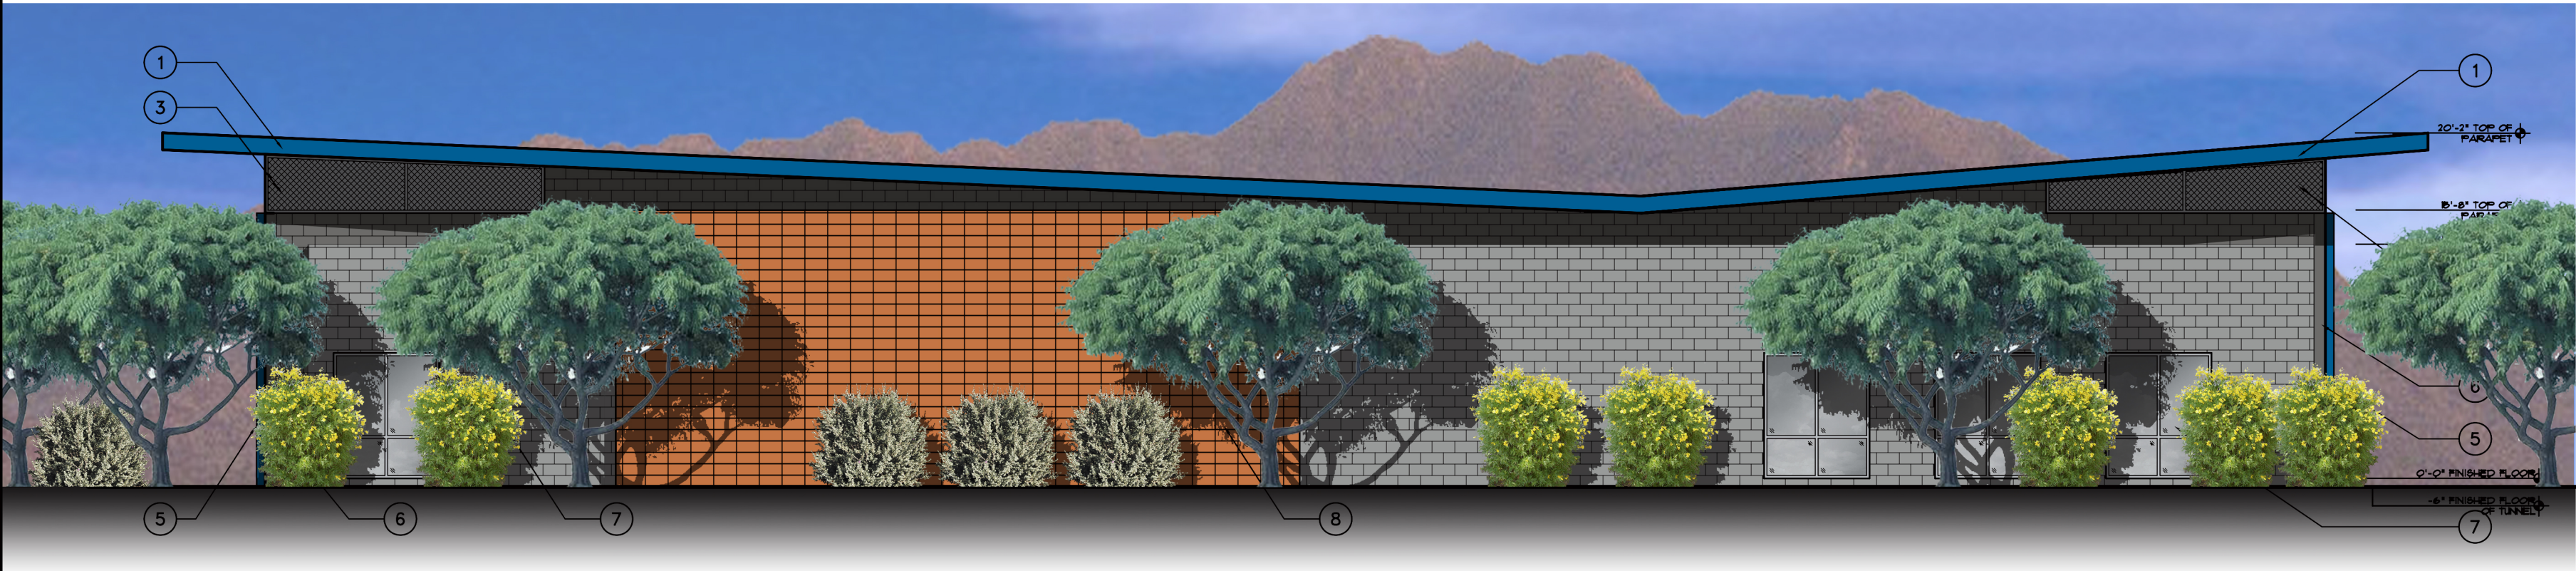


1 SOUTH ELEVATION
SCALE: 1/8"=1'-0"

X-ELEV

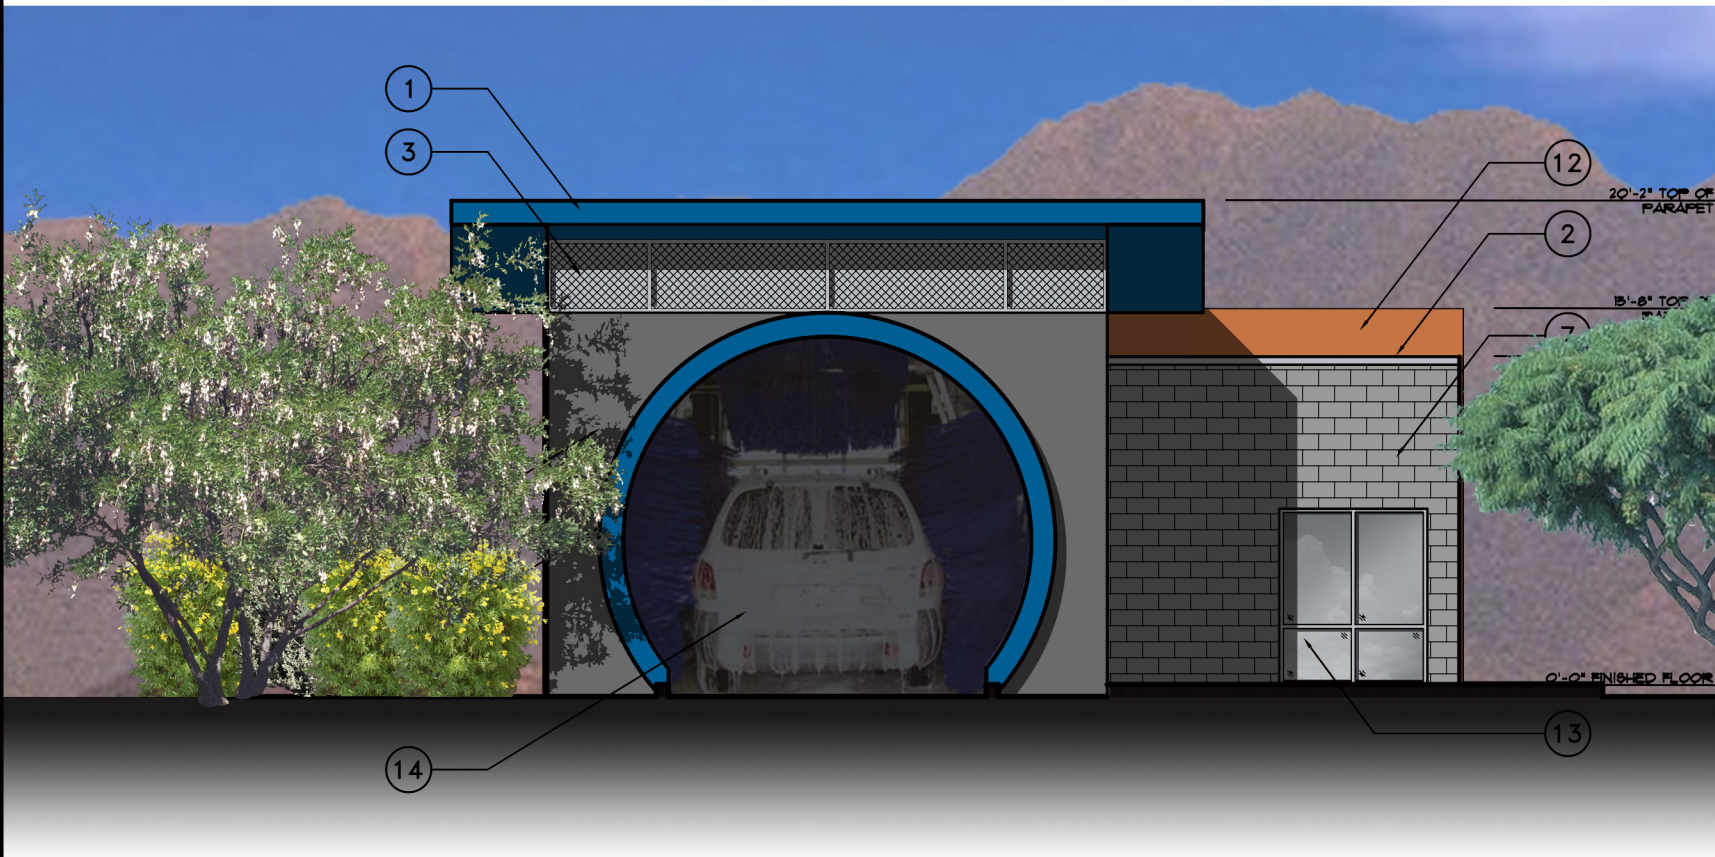

2 EAST ELEVATION
SCALE: 1/8"=1'-0"

X-ELEV

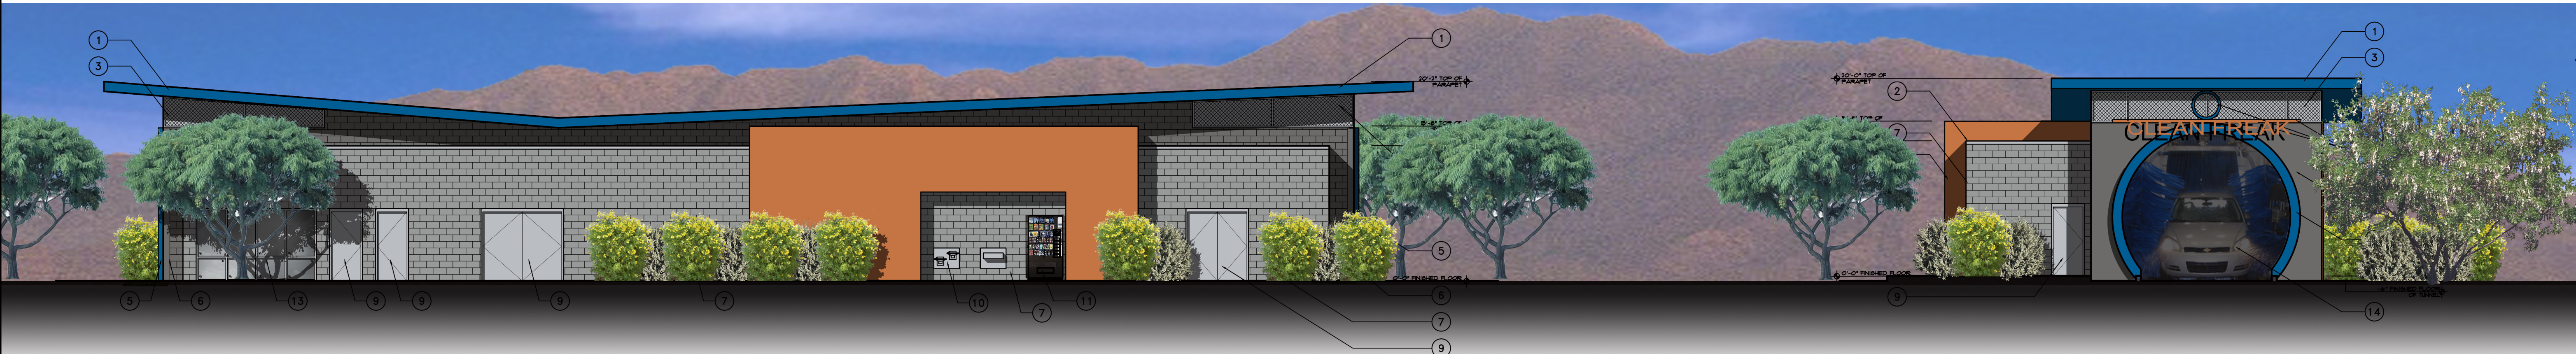

3 NORTH ELEVATION
SCALE: 1/8"=1'-0"

X-ELEV

4 WEST ELEVATION
SCALE: 1/8"=1'-0"

X-ELEV

ELEVATION KEYNOTES


- METAL PARAPET CAP PAINTED PT-4
- METAL PARAPET CAP PAINTED PT-3
- ALUM. PERFORATED METAL SCREEN TO BE CLIP ON OUT SIDE SURFACE OF CMU WALL - CLEAR ANODIZED
- SIGNAGE INSTALLED PER SEPARATE SIGNAGE PERMIT - G.C. TO ENSURE BLOCKING AND POWER AS REQUIRED TO ACCOMMODATE SIGNAGE
- ACCENT COLOR CIRCLE - PAINTED PT-4
- 8" CONCRETE TILT PANEL - PAINTED ACCENT COLOR PT-1
- TYPICAL 8X8X16 CMU RUNNING BOND RACKED JOINTS PAINTED FIELD COLOR PT-2
- TYPICAL 12X8X16 CMU STACKED BOND RACKED HORIZONTAL JOINTS, FLUSH VERTICAL PT-5
- HOLLOW METAL DOORS PER DOOR LEGEND - PAINTED PT-3
- STAINLESS STEEL DRINKING FOUNTAIN - SEE PLUMBING PLANS
- VENDING MACHINES - G.C. TO ENSURE POWER AND DATA TO VENDING MACHINE LOCATION
- STUCCO OVER EXTERIOR GRADE GYP. OR PLYWOOD PAINTED OR TYPICAL 12X8X16 CMU STACKED BOND RACKED HORIZONTAL JOINTS, FLUSH VERTICAL PT-5
- CLEAR ANODIZED ALUM WINDOW FRAMES WITH GRAY TINTED LOW-E GLAZING G.C. TO ENSURE "SG" WHERE REQUIRED BY CODE PT-1
- CAR WASH TUNNEL TO BE ENCLOSED WITH ROLL UP GARAGE DOOR DURING OFF HOURS - TO BE PAINTED
- STAINLESS STEEL, EXTERIOR GRADE UTILITY SINK

Associates Architects, Inc.
Larson

3807 North 24th Street,
Suite 100
Phoenix, AZ 85016
602.955.9929
602.954.4790 FAX
design@larson-architects.com

Larson

CLEAN FREAK CAR WASH
POWER ROAD & GALVESTON STREET
MESA, AZ
APN: 304-31-023R

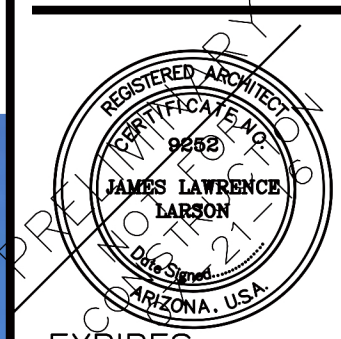

EXPIRES: 6/30/2018
Drawing Name:
EXTERIOR ELEVATIONS

Revisions

Date: 10/18/2016

Project Number:

Drawing No:

A2.0