

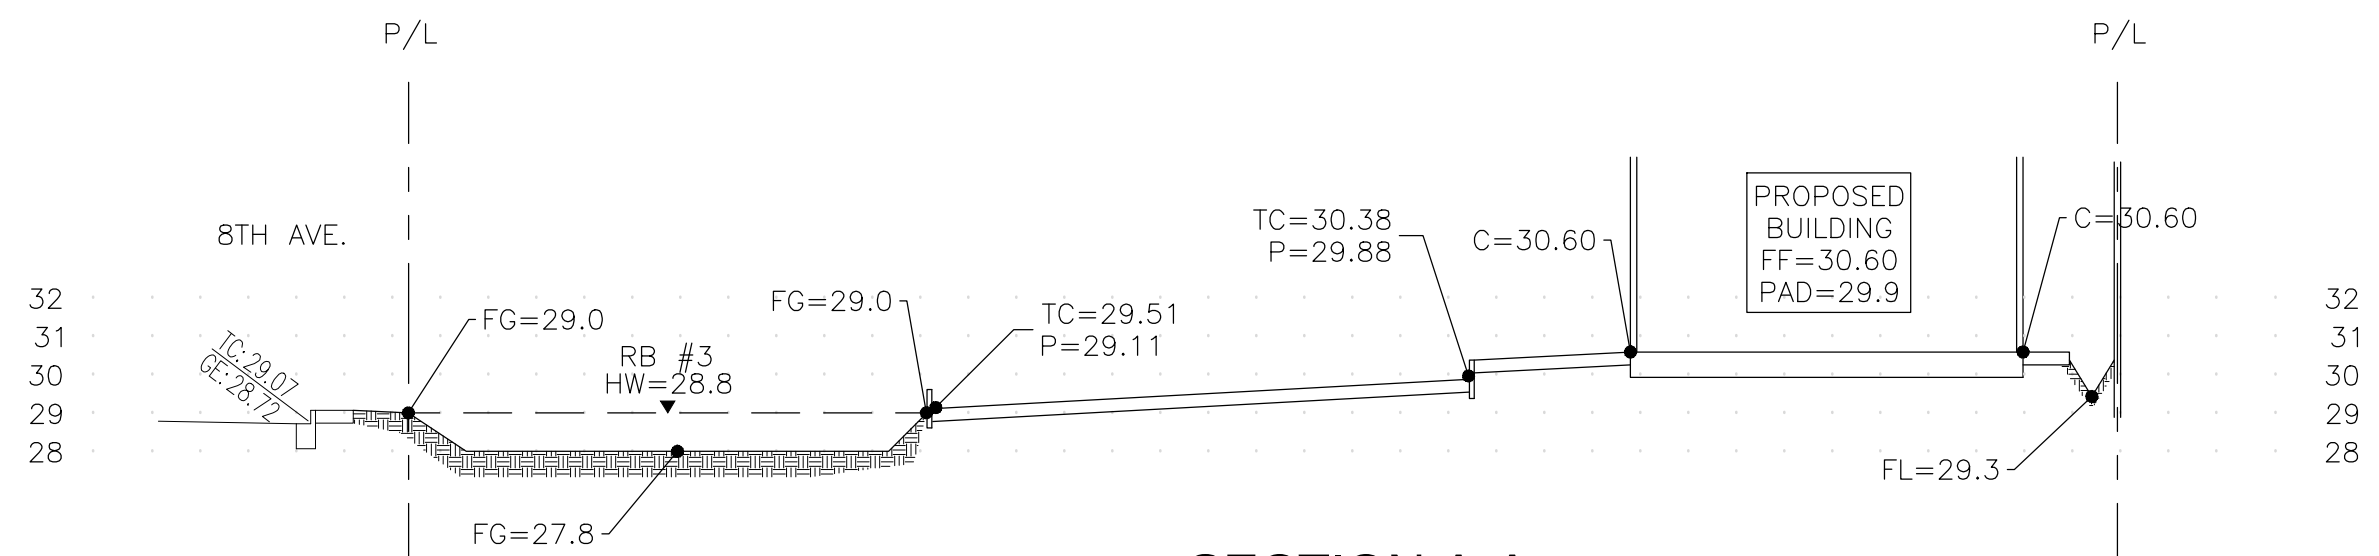


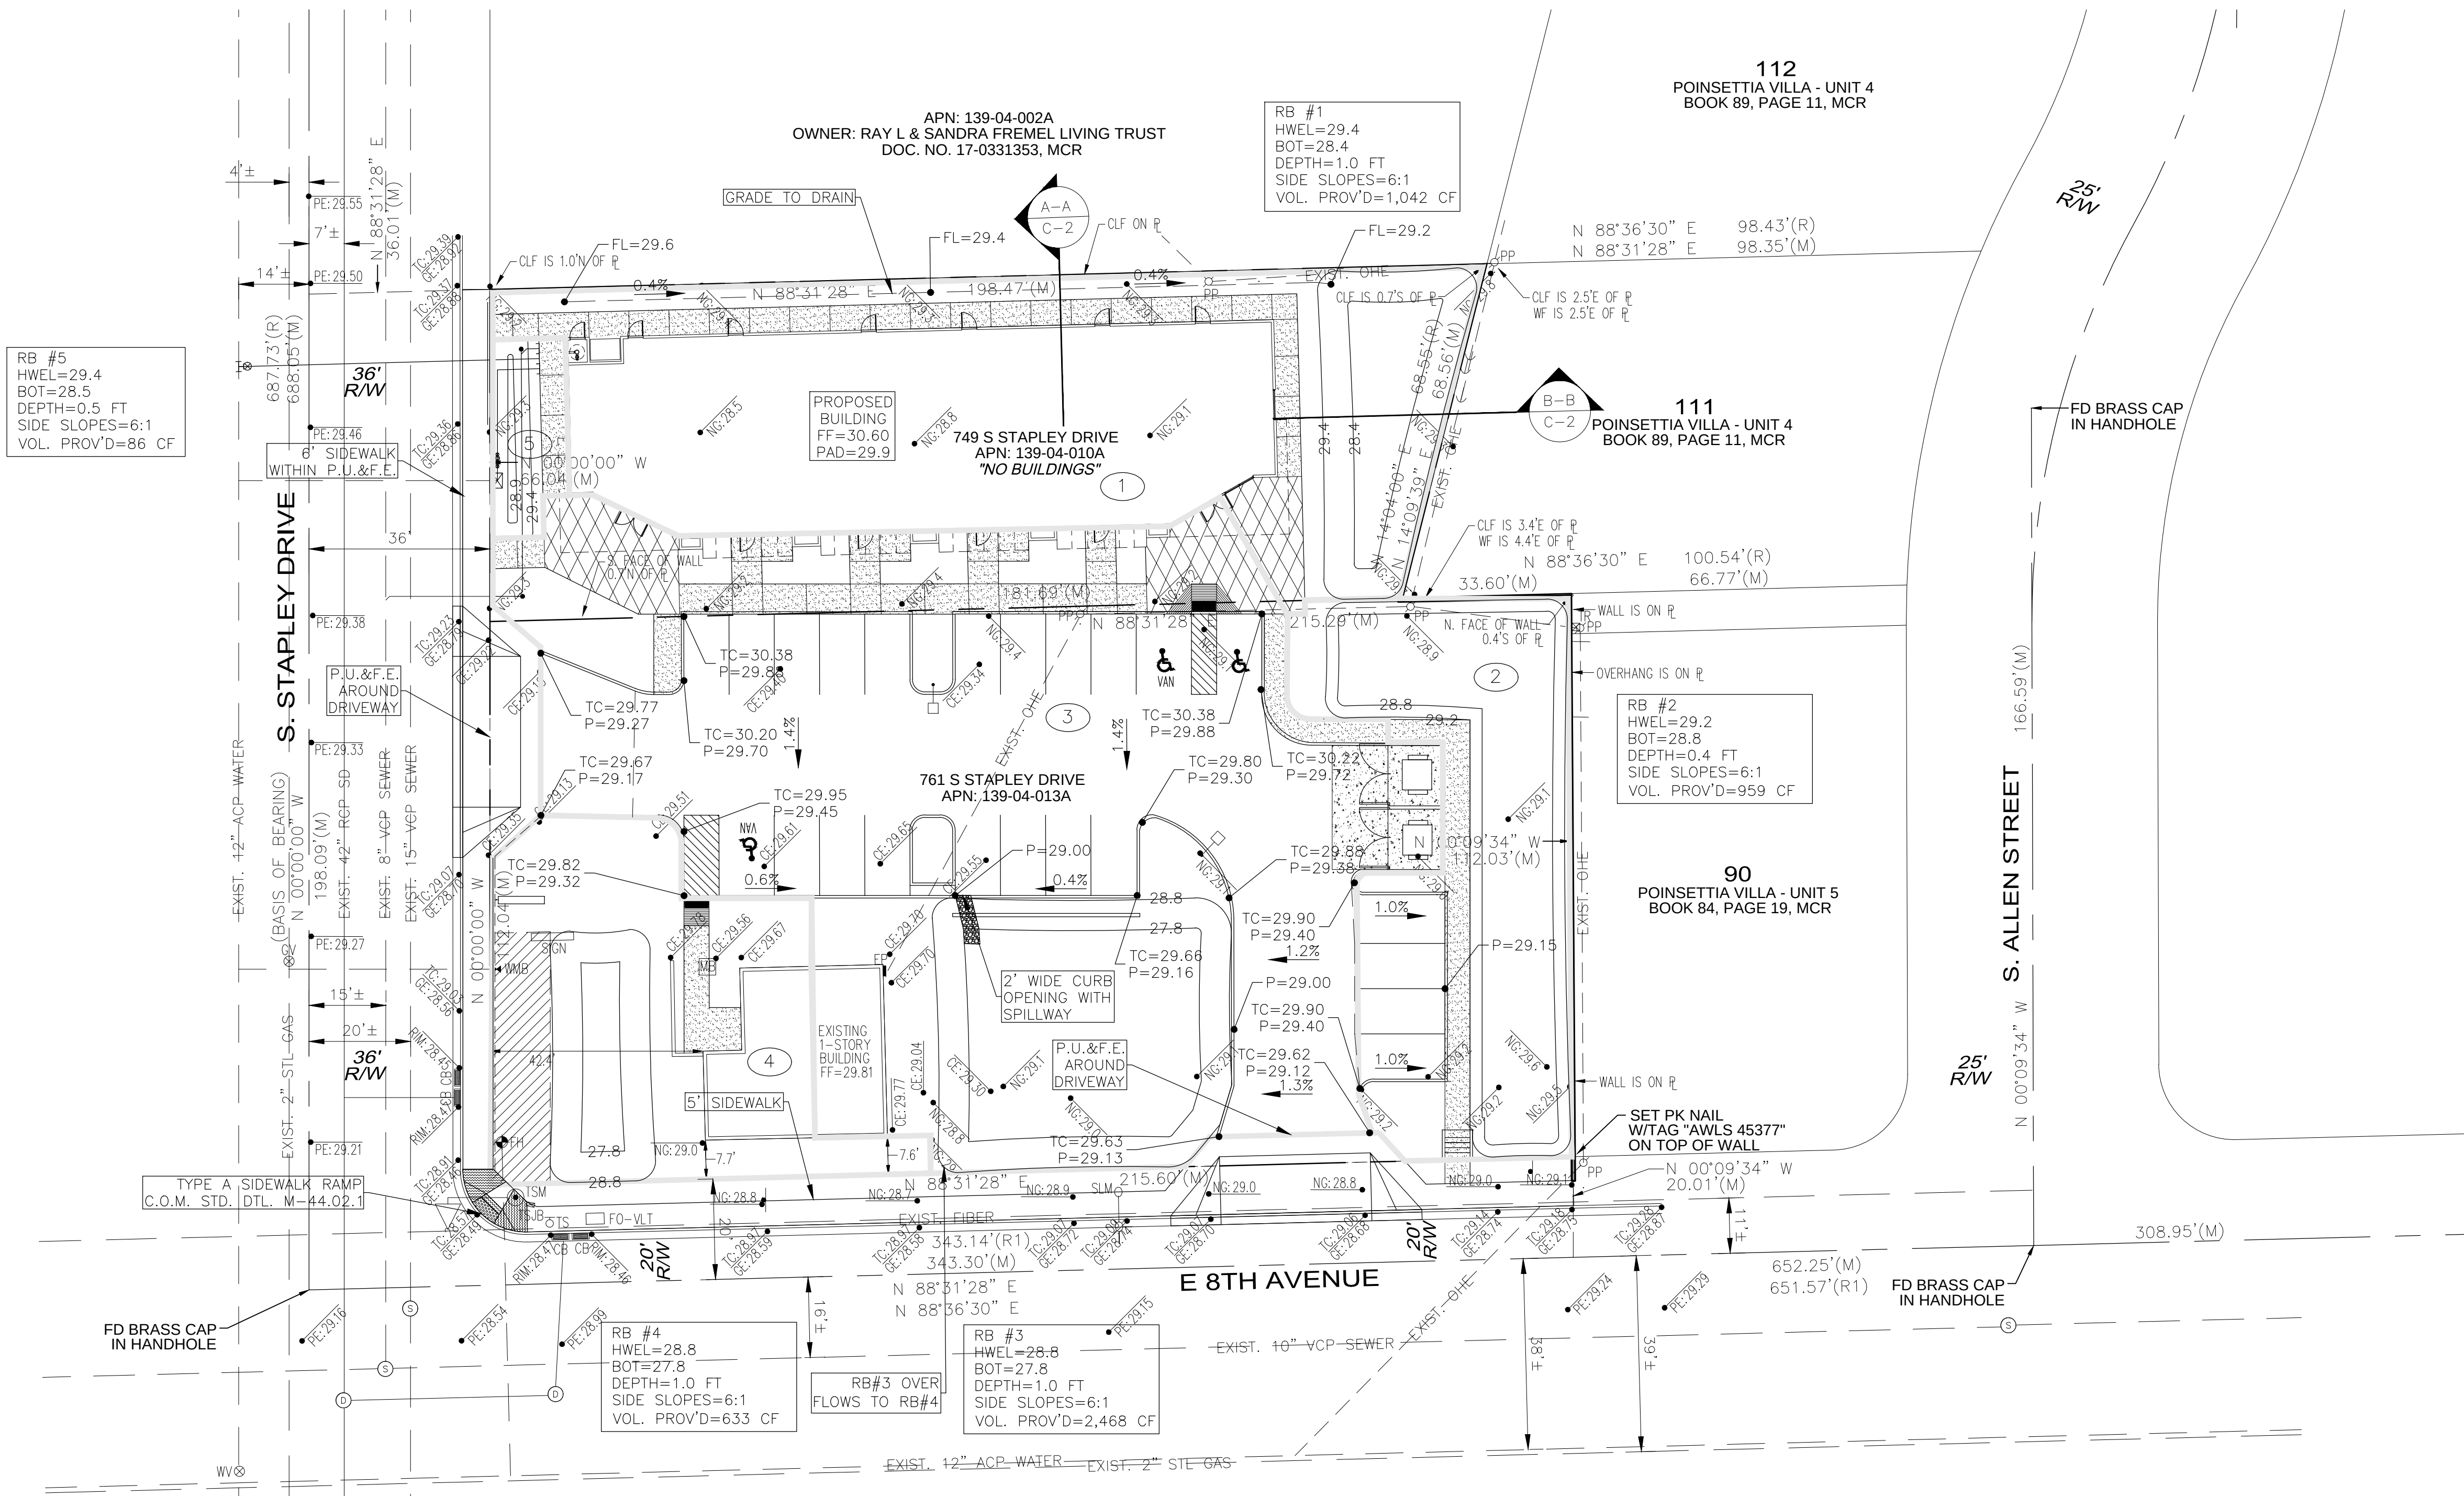

SECTION A-A


HORIZ. SCALE: 1"=20'
VERT. SCALE: 1"=5'


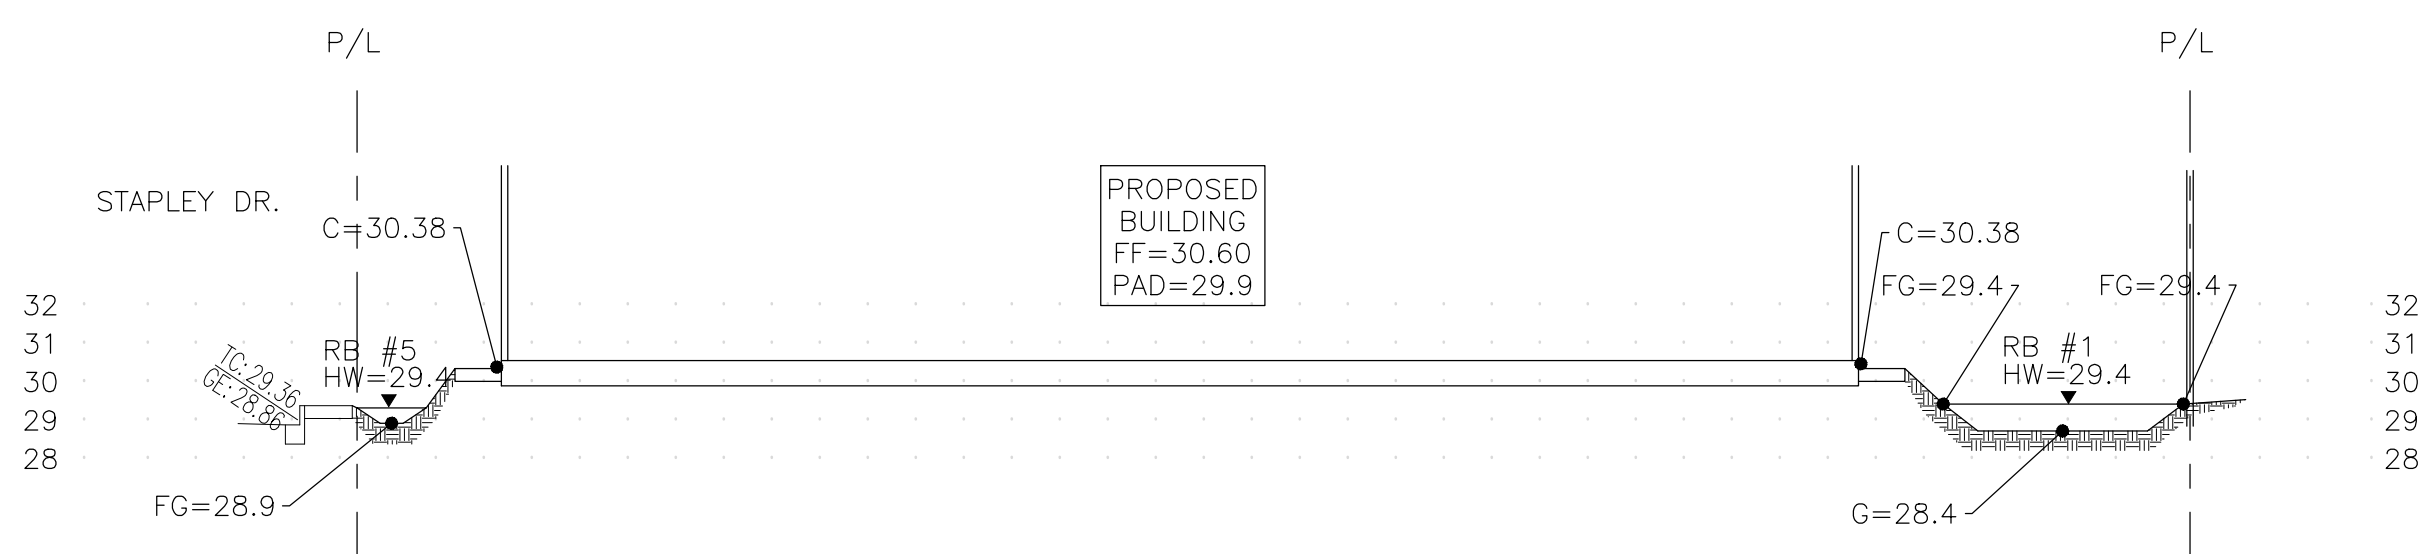


SECTION B-B

HORIZ. SCALE: 1"=20'
VERT. SCALE: 1"=5'

③ = DRAINAGE AREA

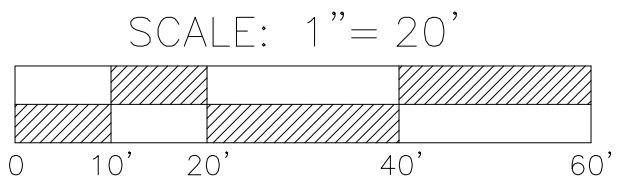

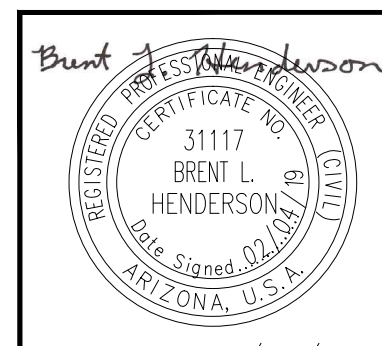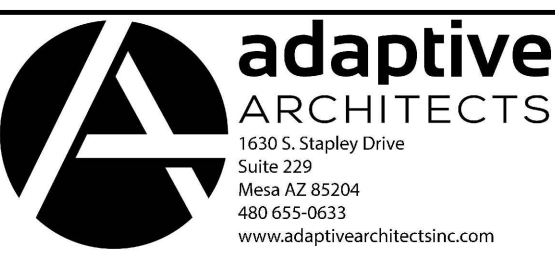 BRENT L. HENDERSON 31117 No. 31117 BRENT L. HENDERSON 31117 No. 31117 BRENT L. HENDERSON 31117 No. 31117	 adaptive ARCHITECTS 1030 S. Stapley Drive Suite 239 Mesa, AZ 85204 480.655.9033 www.adaptivearchitectsinc.com
	Phase SCHEMATIC DESIGN
STAPLEY DR. & 8TH AVENUE RETAIL MESA, AZ 85204	
PRELIM. GRADING & DRAINAGE PLAN	
Project Number: 1808	Revision Date: 02/04/19
Date: 02/04/19	Sheet Number: C-2

HEG #181002


Henderson Engineering Group, LLC
Site Development • Storm Water • Planning • Transportation/Traffic
Structural • Forensics • Project Management • Water/Wastewater

1533 S. PARCKCREST CIRCLE
MESA, ARIZONA 85206
WWW.HEG-LLC.COM (480) 334-7507

Contact Arizona 811 at least two full working days before you begin excavation

ARIZONA 811
Call 811 or click Arizona811.com