


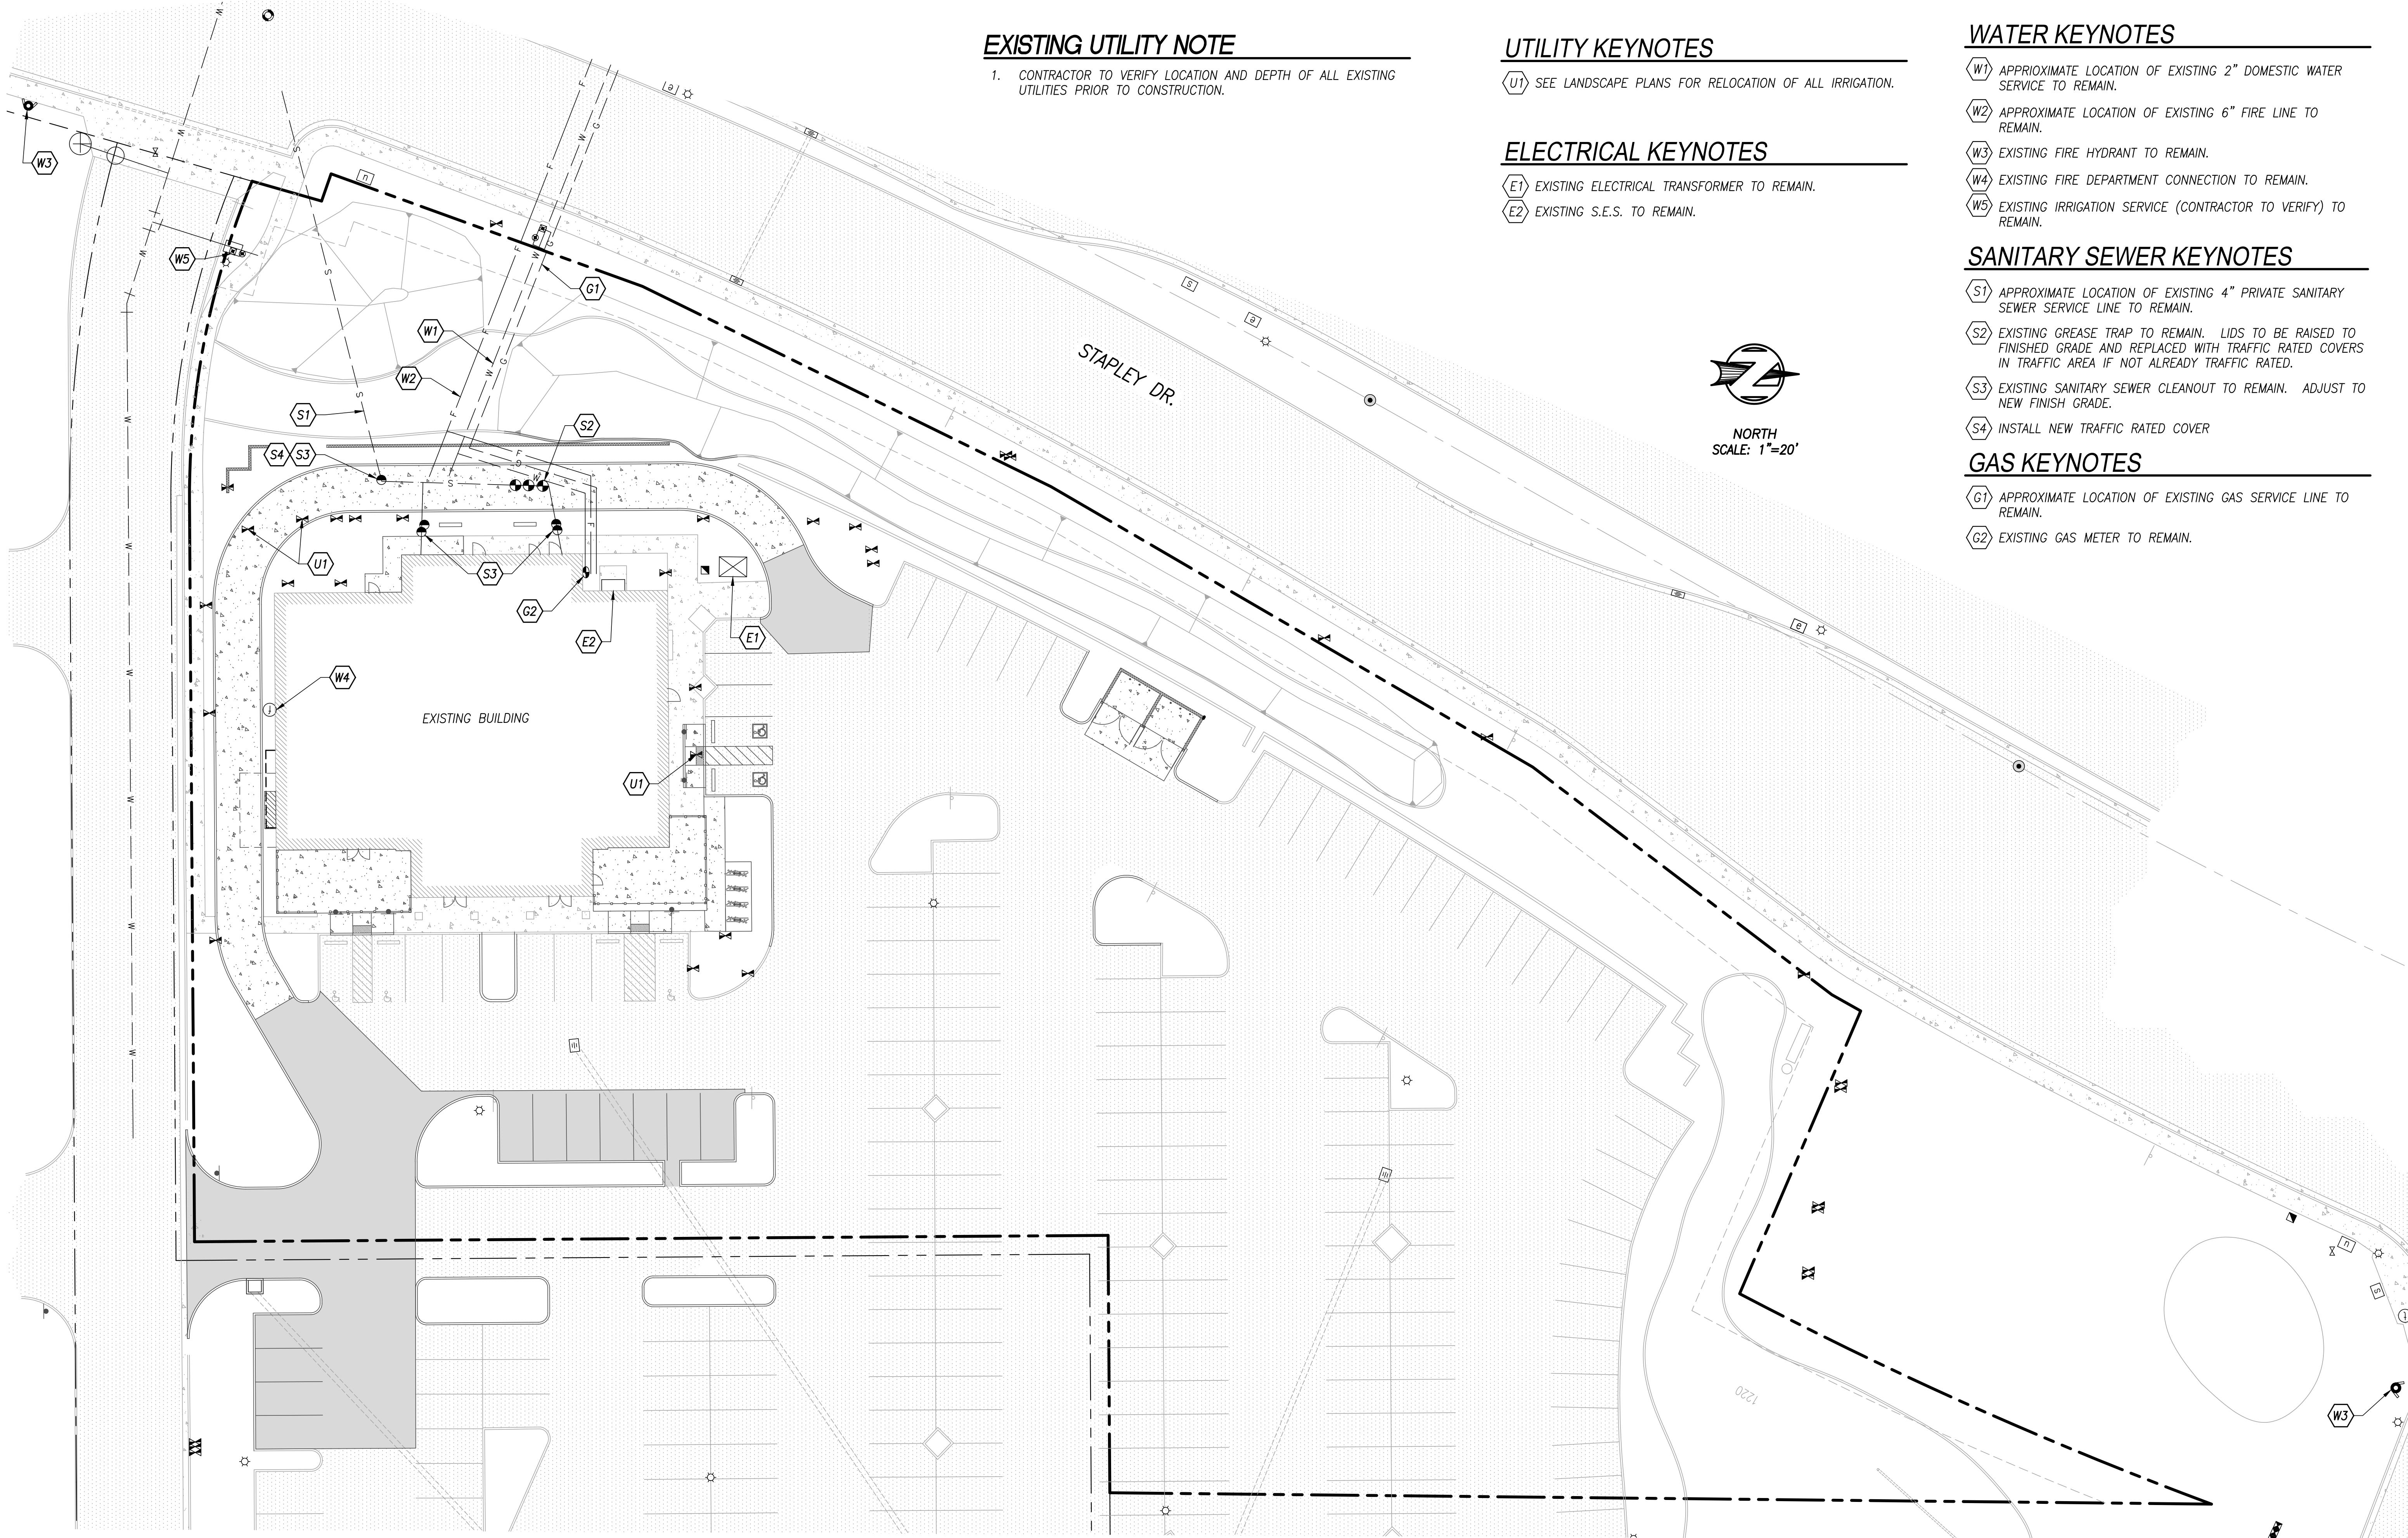

EXISTING UTILITY NOTE

1. CONTRACTOR TO VERIFY LOCATION AND DEPTH OF ALL EXISTING UTILITIES PRIOR TO CONSTRUCTION.

UTILITY KEYNOTES

- U1 SEE LANDSCAPE PLANS FOR RELOCATION OF ALL IRRIGATION.

ELECTRICAL KEYNOTES

- E1 EXISTING ELECTRICAL TRANSFORMER TO REMAIN.
E2 EXISTING S.E.S. TO REMAIN.

WATER KEYNOTES


- W1 APPROXIMATE LOCATION OF EXISTING 2" DOMESTIC WATER SERVICE TO REMAIN.
W2 APPROXIMATE LOCATION OF EXISTING 6" FIRE LINE TO REMAIN.
W3 EXISTING FIRE HYDRANT TO REMAIN.
W4 EXISTING FIRE DEPARTMENT CONNECTION TO REMAIN.
W5 EXISTING IRRIGATION SERVICE (CONTRACTOR TO VERIFY) TO REMAIN.

SANITARY SEWER KEYNOTES

- S1 APPROXIMATE LOCATION OF EXISTING 4" PRIVATE SANITARY SEWER SERVICE LINE TO REMAIN.
S2 EXISTING GREASE TRAP TO REMAIN. LIDS TO BE RAISED TO FINISHED GRADE AND REPLACED WITH TRAFFIC RATED COVERS IN TRAFFIC AREA IF NOT ALREADY TRAFFIC RATED.
S3 EXISTING SANITARY SEWER CLEANOUT TO REMAIN. ADJUST TO NEW FINISH GRADE.
S4 INSTALL NEW TRAFFIC RATED COVER

GAS KEYNOTES

- G1 APPROXIMATE LOCATION OF EXISTING GAS SERVICE LINE TO REMAIN.
G2 EXISTING GAS METER TO REMAIN.

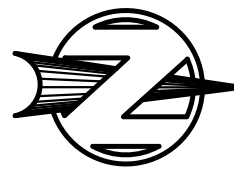

NORTH
SCALE: 1"=20'

REVISIONS:	BY:
COPYRIGHT ©	

MESA SPECTRUM - PAD 8

MESA, ARIZONA

PRIVATE UTILITY PLAN



Grenier Engineering, Inc.
Professional Engineering Consultants
The first thing we design is your confidence
6300 E. EL DORADO PLAZA, SUITE A120, TUCSON, ARIZONA 85715 TEL (520) 326-7082 FAX (520) 326-7508
THIS DRAWING IS NOT TO BE USED FOR CONSTRUCTION PURPOSES UNTIL SEALED AND SIGNED BY ENGINEER OF RECORD.
REUSE OR REPRODUCTION WITHOUT WRITTEN PERMISSION IS PROHIBITED. ©

DRAWN S.L./A.R.
CHECKED J.G./J.R.M.
DATE 3/27/19
SCALE AS SHOWN
JOB NO. 18139
C5.0

FOR REVIEW
NOT FOR
CONSTRUCTION

