


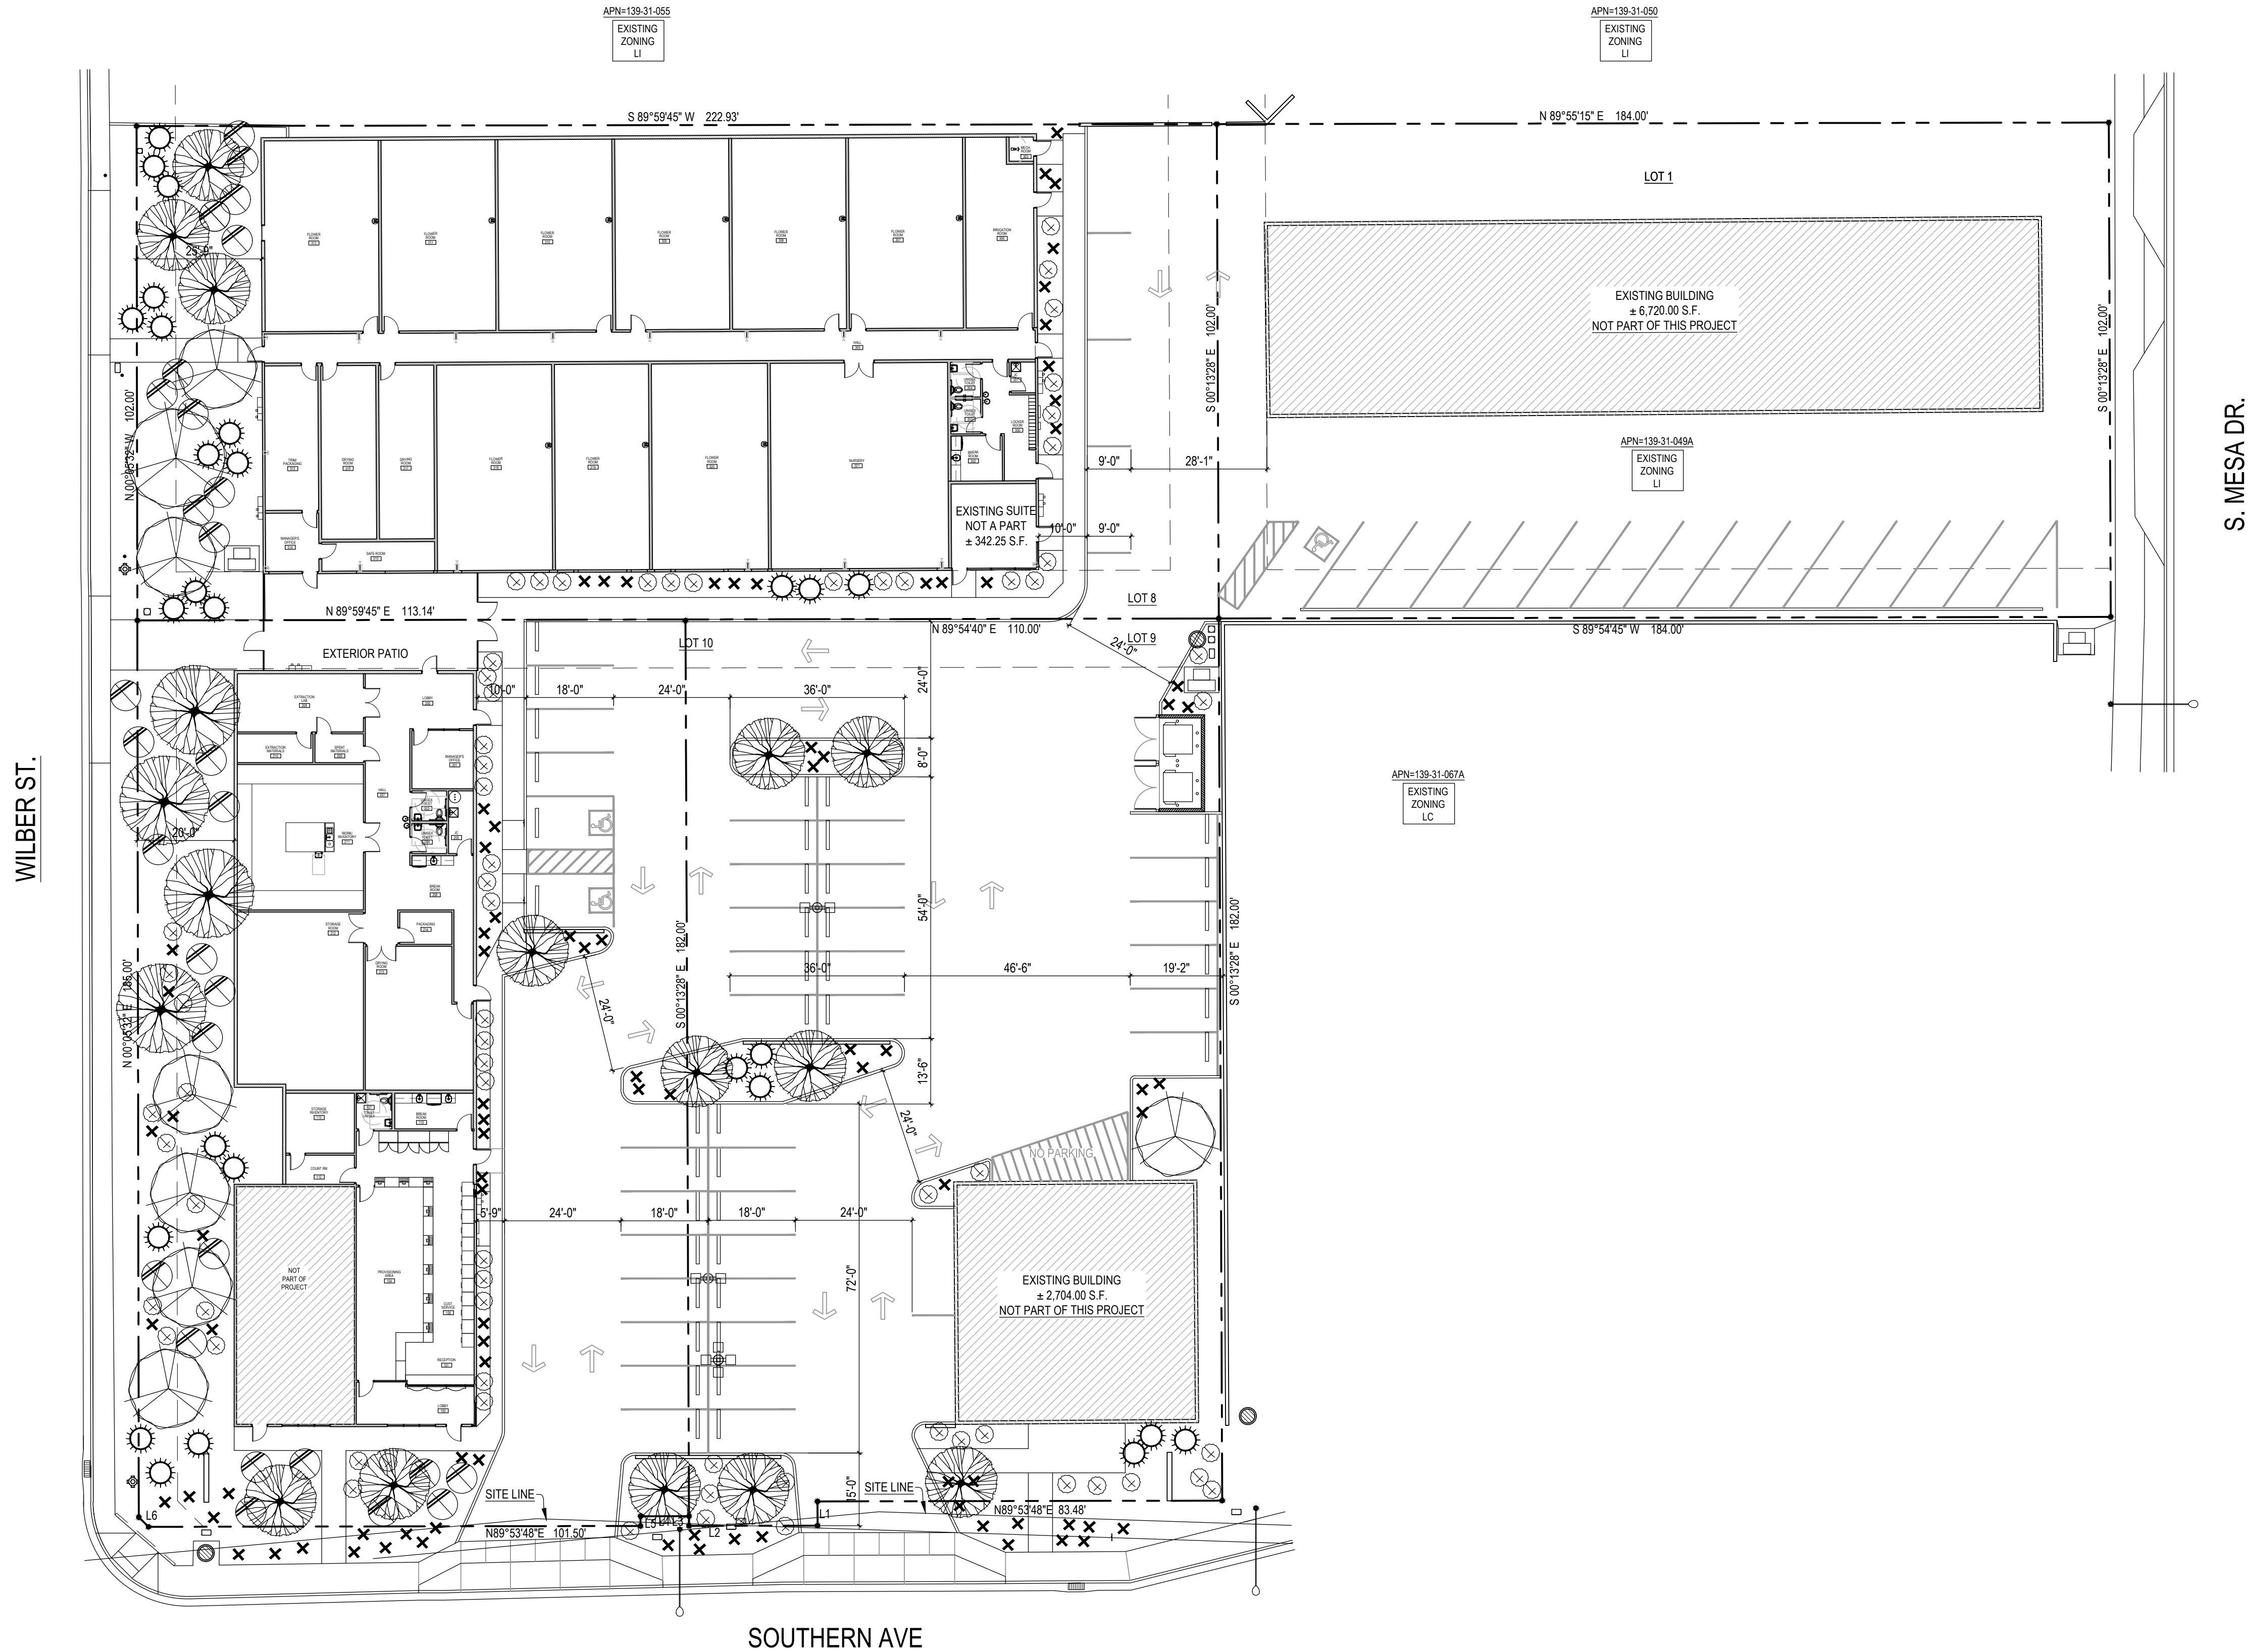

WILBER ST.

S. MESA DR.

SOUTHERN AVE

1 LANDSCAPE PLAN
1" = 20'-0"

 
 


ALL LANDSCAPE MATERIAL INSTALLED SHALL BE MAINTAINED BY OWNER/OR LESSEE IN ACCORDANCE WITH THE APPROVED LANDSCAPE PLAN. ALL TREES AND SHRUBS LOCATED IN THE SIGHT TRIANGLES WILL BE MAINTAINED FOR A CLEAR AREA BETWEEN 2' TO 8'. TREE HEIGHTS AND CALIPERS WILL COMPLY WITH "ARIZONA NURSERY ASSOCIATION" SPECIFICATIONS FOR THAT TYPE AND SIZE OF TREE.

SYMBOL

- WATER METER, SEE PLUMBING PLAN FOR P.O.C.
- FEBCO 825-YA-1" R.P. ASSEMBLY
- HARDIE 700-1" CONTROL VALVE
- SENNINGER PMR-MF PRESSURE REGULATOR W/ AG. PRODUCTS "Y" STRAINER GATE VALVE
- IRRITROL MC STATION CONTROLLER
- SCHEDULE 40-1" MAINLINE
- CLASS 200-3/4" LATERAL LINE
- SCH 40 PVC SLEEVE 4" AT MAINLINE 2" AT LATERAL LINE

3 SPRINKLER LEGEND

BOTANICAL NAMES		COMMON NAMES	
SIZES			
TREES:			
	PITHECELLOBIUM FLEXICAULE	TEXAS EBONY	2" CALIPER 1/24" BOX
	PROSOPIS CHILENSIS	CHILEAN MESQUITE	2" CALIPER 1/24" BOX
SHRUBS:			
	BOUGAINVILLEA 'TEMPLE FIRE'	BUSH BOUGAINVILLEA	5 GAL
	CAESALPINIA PULCHERRIMA MEXICANA	MEXICAN BIRD OF PARADISE	5 GAL
	CONVOLVULUS CNEORUM	MORNING GLORY BUSH	5 GAL
	DODONEA VISCOSA	GREEN HOPSEED	5 GAL
	LANTANA 'GOLD MOUND'	GOLD MOUND LANTANA	5 GAL
	LANTANA MONTEVIDENSIS	PURPLE TRAILING LANTANA	5 GAL

GROUND COVER:
1/2" SCREENED MADISON GOLD DECOMPOSED GRANITE - 2" THICK LAYER ON ALL LANDSCAPE AREAS

Arc
ONE
ASSOCIATES

1427 N. 3rd Street
Phoenix, Arizona 85004
Phone: 602 241 7871
Fax: 602 241 7874
info@arconeassociates.com




THE MINT DISPENSARY
330 E SOUTHERN AVE.
MESA AZ. 85210

design: RDO
drawn: JO
check: JDO

revisions:

COPYRIGHT 2011. ALL RIGHTS RESERVED.
arc one associates, LLC.
THIS DRAWING IS AN INSTRUMENT OF SERVICE
AND MAY NOT BE REPRODUCED, COPIED, OR CHANGED
HERE, WITHOUT PERMISSION OF THE ARCHITECT.

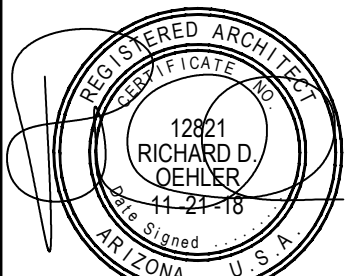

EXPIRES 12/31/21
date: 11/21/18

SHEET

LP100

of
PROJECT: A0100218