

SYMBOL	DESCRIPTION
	EXISTING TO BE REMOVED
	HEAVY LINEWEIGHT INDICATES NEW WORK
	LIGHT LINEWEIGHT INDICATES EXISTING INFORMATION
	POINT OF CONNECTION (POC) BETWEEN NEW AND EXISTING
	EQUIPMENT IDENTIFIER (XX = ABBREVIATION Y = EQUIPMENT SCHEDULE NUMBER)
	DRAWING CONSTRUCTION ('FLAG') NOTE
	EQUIPMENT IDENTIFIER
	RACEWAY/CABLE/CONDUCTOR ROUTING IDENTIFIER-REFER TO RACEWAY/CABLE/CONDUCTOR SCHEDULE
	MATCHLINE
	REVISION CLOUD (ENCIRCLES DRAWING CHANGES MADE SINCE THE PREVIOUS RELEASE)
	REVISION REFERENCE
	DETAIL REFERENCE DETAIL IDENTIFICATION NUMBER SHEET WHERE DETAIL IS DRAWN
	ELEVATION REFERENCE ELEVATION IDENTIFICATION NUMBER SHEET WHERE ELEVATION IS DRAWN
	SECTION REFERENCE SECTION IDENTIFICATION NUMBER SHEET WHERE SECTION IS DRAWN
	NORTH REFERENCE

SYMBOL	DESCRIPTION
	CONDUIT CONCEALED IN CEILING SPACE OR IN WALL. PROVIDE MINIMUM 3/4" WITH #12 AWG CONDUCTORS AND DEDICATED NEUTRAL EACH CIRCUIT UNLESS OTHERWISE NOTED ON PLAN. PROVIDE EQUIPMENT GROUNDING CONDUCTORS SIZED PER NFPA 70.
	FLEXIBLE METAL CONDUIT
	CONDUIT - CONCEALED IN OR UNDER FLOOR
	CONDUIT - ROUTED UNDERGROUND
	LOW-VOLTAGE WIRING (CLASS B)
	CONDUIT OR CABLE VERTICAL DOWN
	CONDUIT OR CABLE VERTICAL UP
	CONDUIT STUB - TERMINATE WITH BUSHING OR CAP IF UNDERGROUND
	BREAK LINE
	CONDUIT SEAL
	EXPANSION FITTING
	BRANCH CIRCUIT NUMBERS
	PANEL DESIGNATION
	HOME RUN TO SOURCE OF SUPPLY
	CONDUCTORS - CONNECTED
	CONDUCTORS - NOT CONNECTED
	JUNCTION BOX
	PULLBOX - SIZE AS INDICATED OR AS REQUIRED BY CODE
	HANDHOLE
	MANHOLE

SYMBOL	DESCRIPTION
	TRANSFORMER
	POLE-MOUNTED TRANSFORMER
	POLE
	DELTA
	WYE
	MEDIUM VOLTAGE CABLE TERMINATOR
	LIGHTNING ARRESTORS
	SURGE ARRESTORS
	NEUTRAL GROUNDING RESISTOR
	METER
	MICROPROCESSOR CONTROLLED MONITOR REFER TO SPECIFICATIONS FOR METERING VALUES AND PROTECTIVE FUNCTIONS
	CURRENT TRANSFORMER
	POTENTIAL TRANSFORMER
	INDICATING INSTRUMENT AM-AMMETER; VM-VOLTMETER; FM-FREQUENCY METER; KVAR-KILOVAR METER; KWH-KILOWATT HOUR METER; KWH-D-KILOWATT HOUR DEMAND METER
	INSTRUMENT SWITCH AS-AMMETER SWITCH; VS-VOLTMETER SWITCH; SS-SYNCHRONIZING SWITCH; SV-SUPERVISORY (LOCAL-REMOTE) SWITCH
	SEPARABLE CONNECTOR
	DRAWOUT AC TYPE POWER CIRCUIT BREAKER

SYMBOL	DESCRIPTION
	480Y/277V, 3Ø, 4W PANELBOARD
	2Ø8Y/12ØV, 3Ø, 4W PANELBOARD
	EQUIPMENT CABINET - TYPE AS NOTED
	PANELBOARD
	TRANSFER SWITCH (AUTO)
	AMPERES SHORT CIRCUIT AVAILABLE (SYMMETRICAL)
	FEEDER TAG - REFER TO FEEDER SCHEDULE

SYMBOL	DESCRIPTION
	GROUND CONNECTION
	GROUND ROD
	GROUND WELL
	AIR TERMINAL

SYMBOL	DESCRIPTION
	CIRCUIT BREAKER
	ST - INDICATES SHUNT TRIP
	ENCLOSED CIRCUIT BREAKER (PLAN VIEW) xxxANP - AMPS/POLES
	ENCLOSED CIRCUIT BREAKER (ONE-LINE DIAGRAM) xxxANP - AMPS/POLES
	BREAKER WITH EXTERNAL GROUND FAULT RELAY AND CT
	CIRCUIT BREAKER WITH INTEGRAL GROUND FAULT PROTECTION
	MOTOR-OPERATED CIRCUIT BREAKER
	SWITCH WITH EXTERNAL GROUND FAULT RELAY AND CT
	MOV SURGE PROTECTION
	RESISTOR
	FUSE
	MOTOR THERMAL OVERLOADS - (3) UNLESS OTHERWISE NOTED
	NORMALLY OPEN CONTACT
	NORMALLY CLOSED CONTACT
	SOLENOID VALVE
	MOTOR-OPERATED VALVE
	THERMOSTAT
	TERMINAL BLOCK
	INDICATING LIGHT - TYPE AS NOTED A-AMBER; B-BLUE; G-GREEN; R-RED; W-WHITE
	BATTERY

SYMBOL	DESCRIPTION
	SINGLE-POLE WALL SWITCH MOUNT SWITCHES AT 48" AFF. TO TOP, UON.
	WALL SWITCH - SUBSCRIPT 2 = 2-POLE 3 = 3-WAY 4 = 4-WAY K = KEYED
	LOWER CASE LETTER INDICATES SWITCHING GROUP
	MOUNT SWITCHES AT 48" AFF. TO TOP, UON. ANY COMBINATION OF SWITCH TYPES CAN BE USED (IE. 3K = 3-WAY KEYED SWITCH)
	SPECIAL PURPOSE RECEPTACLE TYPE AS SHOWN ON PLANS
	SINGLE SERVICE OR COMBINATION FLUSH MOUNTED FLOOR BOX. REFER TO FLOOR PLANS FOR DEVICES.
	SINGLE SERVICE OR COMBINATION FLUSH FLOOR POKE THRU. REFER TO FLOOR PLANS FOR DEVICES.
	POWER/COMM POLE - FLOOR TO CEILING.
	SURFACE MOUNTED FLOOR BOX (PEDESTAL TYPE).
	PUSH BUTTON
	SIMPLEX RECEPTACLE NEMA 5-2ØR, 1Ø" AFF UON
	NEMA 5-2ØR, 1Ø" AFF UON
	TAMPER RESISTANT, NEMA 5-2ØR, 1Ø" AFF UON
	SWITCHED, NEMA 5-2ØR, 1Ø" AFF UON
	ISOLATED GROUND, NEMA 5-2ØR, 1Ø" AFF UON
	NEMA 5-2ØR W/ GROUND FAULT CIRCUIT INTERRUPTER, 1Ø" AFF UON
	SPLIT WIRED, NEMA 5-2ØR, 1Ø" AFF UON
	CONTROLLED, NEMA 5-2ØR, 1Ø" AFF UON
	NEMA 5-2ØR, ABOVE COUNTER
	NEMA 5-2ØR WITH GROUND FAULT CIRCUIT INTERRUPTER, ABOVE COUNTER. COORDINATE WITH CASEWORK SHOP DRAWINGS AND ARCHITECTURAL DRAWINGS.
	TAMPER RESISTANT, NEMA 5-2ØR WITH GROUND FAULT CIRCUIT INTERRUPTER, ABOVE COUNTER. COORDINATE WITH CASEWORK SHOP DRAWINGS AND ARCHITECTURAL DRAWINGS.
	NEMA 5-2ØR, CONNECTED TO EMERGENCY CIRCUIT, 1Ø" AFF UON
	NEMA 5-2ØR ON EMERGENCY CIRCUIT MOUNTED ABOVE COUNTER. COORDINATE WITH CASEWORK SHOP DRAWINGS AND ARCHITECTURAL DRAWINGS.
	CEILING-MOUNTED, NEMA 5-2ØR
	NEMA 5-2ØR WITH USB CHARGER - (2) TYPE A USB PORTS
	TAMPER RESISTANT, NEMA 5-2ØR WITH USB CHARGER - (2) TYPE A USB PORTS

SYMBOL	DESCRIPTION
	2-POSITION SELECTOR SWITCH
	3-POSITION SELECTOR SWITCH HAND-OFF-AUTOMATIC
	ON-OFF SELECTOR SWITCH
	2-CIRCUIT PUSHBUTTON
	PUSHBUTTON SWITCH MOMENTARY CONTACT
	EQUIPMENT CONNECTION
	GENERATOR
	MOTOR CONNECTION
	SMOKE DAMPER
	FIRE SMOKE DAMPER
	STARTER 3-POLE, NEMA SIZE 1 MINIMUM UNLESS NOTED OTHERWISE
	COMBINATION STARTER HP-RATED, 3-POLE, NEMA SIZE 1 MINIMUM, UNLESS NOTED OTHERWISE - OVERCURRENT PROTECTION AS REQUIRED BY EQUIPMENT MANUFACTURER OR AS NOTED
	DISCONNECT SWITCH 3-POLE UNLESS NOTED OTHERWISE
	FUSED DISCONNECT SWITCH 3-POLE UNLESS NOTED OTHERWISE - OVERCURRENT PROTECTION AS REQUIRED BY EQUIPMENT MANUFACTURER OR AS NOTED
	CONTACTOR
	RELAY COIL
	CR-CONTROL RELAY; TD-TIME DELAY RELAY;
	UV-UNDERVOLTAGE RELAY; M-MOTOR CONTACTOR;
	MOTOR-RATED SWITCH - SIZE OL PER MOTOR REQUIREMENTS
	EQUIPMENT EMERGENCY SHUTDOWN SWITCH

SYMBOL	DESCRIPTION
	LIGHT FIXTURE IDENTIFIER - REFER TO LIGHTING FIXTURE SCHEDULE
	PANEL NAME - CIRCUIT NUMBER
	SWITCH DESIGNATION
	SUBSCRIPT (IF APPLICABLE)
	* IF LABEL IS ORIENTED HORIZONTALLY A SLASH WILL SEPARATE THIS INFORMATION. EX: RL1/1 A-1/1 & 1/1
	SHADING INDICATES LUMINAIRE ON EMERGENCY CIRCUIT OR WITH BATTERY BACKUP
	2x4 LUMINAIRE
	1x4 LUMINAIRE
	2x2 LUMINAIRE
	LINEAR LUMINAIRE
	LINEAR WALL WASH LUMINAIRE
	WALL MOUNTED LUMINAIRE
	UNDER CABINET LUMINAIRE
	STRIP LUMINAIRE
	DOWNLIGHT
	WALL WASH DOWNLIGHT LUMINAIRE
	WALL MOUNTED LUMINAIRE
	WALL MOUNTED DIRECTIONAL LUMINAIRE
	FLUSH OR PENDANT MOUNTED LIGHTING FIXTURE
	TRACK LIGHT - LENGTH AS INDICATED ON PLANS;
	NUMBER OF LUMINAIRES AS SHOWN
	POLE-MOUNTED LUMINAIRE - NUMBER OF LUMINAIRES AS SHOWN ON PLANS
	STREET LIGHT
	IN-GROUND LANDSCAPE LUMINAIRE
	ILLUMINATED EXIT SIGN - SINGLE FACE; ARROW INDICATES DIRECTION OF EGRESS, UNIVERSAL MOUNT
	ILLUMINATED EXIT SIGN - DOUBLE FACE; ARROW INDICATES DIRECTION OF EGRESS, UNIVERSAL MOUNT
	BATTERY-POWERED EMERGENCY WALLPACK
	COMBINATION BATTERY POWERED EMERGENCY WALLPACK AND ILLUMINATED EXIT SIGN
	CEILING MOUNTED NURSE CALL LIGHT
	TIME CLOCK - TYPE AS NOTED
	LIGHTING CONTROL SYSTEM POWER PACK
	SWITCH BYPASS DEVICE
	ILLUMINATION CONTROL STATION
	CEILING MOUNTED OCCUPANCY SENSOR WITH POWER PACK-PASSIVE
	INFRARED TYPE UNLESS NOTED: U = ULTRASONIC DT = DUAL TECHNOLOGY
	PHOTOELECTRIC CONTROL CEILING MOUNTED
	OCCUPANCY SENSOR WALL MOUNTED
	PHOTOELECTRIC CONTROL WALL MOUNTED

THESE DRAWINGS AND SPECIFICATIONS ARE THE PROPERTY AND COPYRIGHT OF WARE MALCOMB AND SHALL NOT BE USED ON ANY OTHER WORK EXCEPT BY AGREEMENT WITH WARE MALCOMB. WRITTEN DIMENSIONS SHALL TAKE PRECEDENCE OVER SCALED DIMENSIONS AND SHALL BE EMPLOYED ON THE JOB SITE. ANY DISCREPANCY SHALL BE BROUGHT TO THE NOTICE OF WARE MALCOMB PRIOR TO THE COMMENCEMENT OF ANY WORK.

GENERAL NOTES, ABBREVIATIONS, & DRAWING INDEX

DATE

REMARKS

PA/PM: M. RETZLAFF

DRAWN BY: Author

JOB NO.: PHX22-0015-00

SHEET

E0.01

6/27/2023 4:13:12 PM

XXXXXXX - 85% CD SET

SAZAN GROUP

311 E. Veterans Way, Ste. 102

Tempe, Az 85281

Tel 480.530.9101

Fax 206.267.1701

SAZAN # 837-23093

2777 E. Camelback Rd. Suite 4025

Phoenix, AZ 85016

P.480.767.1001

2777 E. Camelback Rd. Suite 4025

Phoenix, AZ 85016

P.480.767.1001

2777 E. Camelback Rd. Suite 4025

Luminaire Schedule									
Symbol	Qty	Label	Arrangement	Description	LLF	Luminaire Lumens	Luminaire Watts	[MANUFAC]	
	64	S1	Single	GALN-SA4C-740-U-T4FT-WM-B2	0.900	27751	213	MCGRAW EDISON	
	2	S2	Single	GALN-SA4C-740-U-SL3-WM-B2	0.900	27566	213	MCGRAW EDISON	
	6	S3	Back-Back	GALN-SA3C-740-U-T3-B2/ SSS.	0.900	20812	160	MCGRAW EDISON	
	8	S4	Single	GALN-SA3C-740-U-SL3-B2/ SSS.	0.900	21966	160	MCGRAW EDISON	
	9	S5	Single	GALN-SA3C-740-U-SL3-B2/ SSS.	0.900	17361	160	MCGRAW EDISON	
	2	S6	Back-Back	GALN-SA3C-740-U-SL3-B2/ SSS.	0.900	21966	160	MCGRAW EDISON	
	3	S7	Single	GALN-SA3C-740-U-T3-B2/ SSS.	0.900	20812	160	MCGRAW EDISON	
	78	S8	Single	AXCS1A-CBP	0.900	1806	13.5	LUMARK	

Calculation Summary									
Label	CalcType	Units	Avg	Max	Min	Avg/Min	Max/Min		
PROPERTY LINE AT 3' AFG	Illuminance	Fc	0.14	0.5	0.0	N.A.	N.A.		
SITE	Illuminance	Fc	2.04	17.6	0.0	N.A.	N.A.		

TYPE: S1, S2, S3, S4, S5, S6,S7

Project

Catalog #

Type

Prepared by

Notes

Date



McGraw-Edison
GALN Galleon II
Area / Site Luminaire
Product Features
Light Management
BAA

Interactive Menu

- Ordering Information page 2
- Mounting Details page 3
- Optical Distributions page 5
- Product Specifications page 5
- Energy and Performance Data page 6
- Control Options page 10

Product Certifications

- ISU
- DLC ULISTED
- DLC ETL
- 3G VIB
- IP66
- UL
- IEC
- YEAR



Quick Facts

- Lumen packages range from 3,300 - 73,500 (33W - 552W)
- 16 optical distributions
- Efficacy up to 159 lumens per watt

Connected Systems

- WaveLinX Lite
- WaveLinX


Dimensional Details
Standard Arm

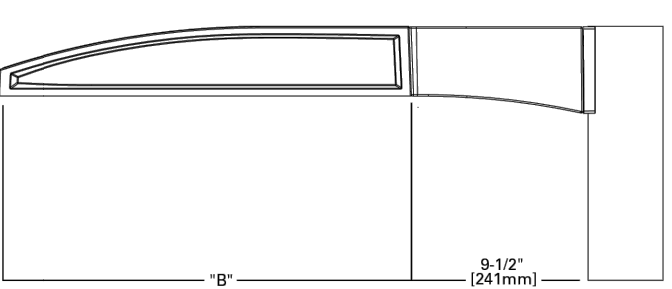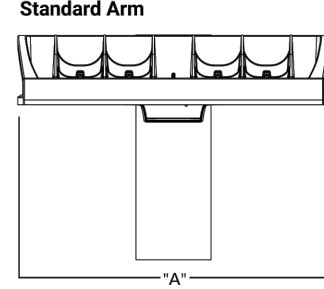

Number of Light Sources	Width "A"	Housing Length "B"	Weight with Standard or DM Arm	EPA with Standard or DM Arm
1-4	16"	22"	29 lb	0.95
5-6	22"	22"	39 lb	0.99
7-9	22"	28 1/8"	48 lb	1.1


NOTES:
1. For arm selection requirements and additional line art, see Mounting Details section.
2. For arm selection (2000-02) and arm selection only, see Mounting Details section.

Pole Drilling Patterns
Type "N"

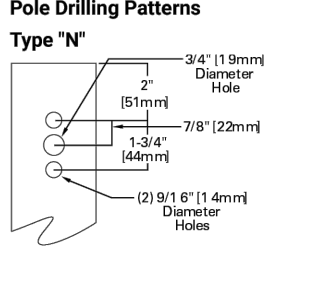

COOPER Lighting Solutions

PH0300022EN page 1
January 30, 2023 11:17 AM

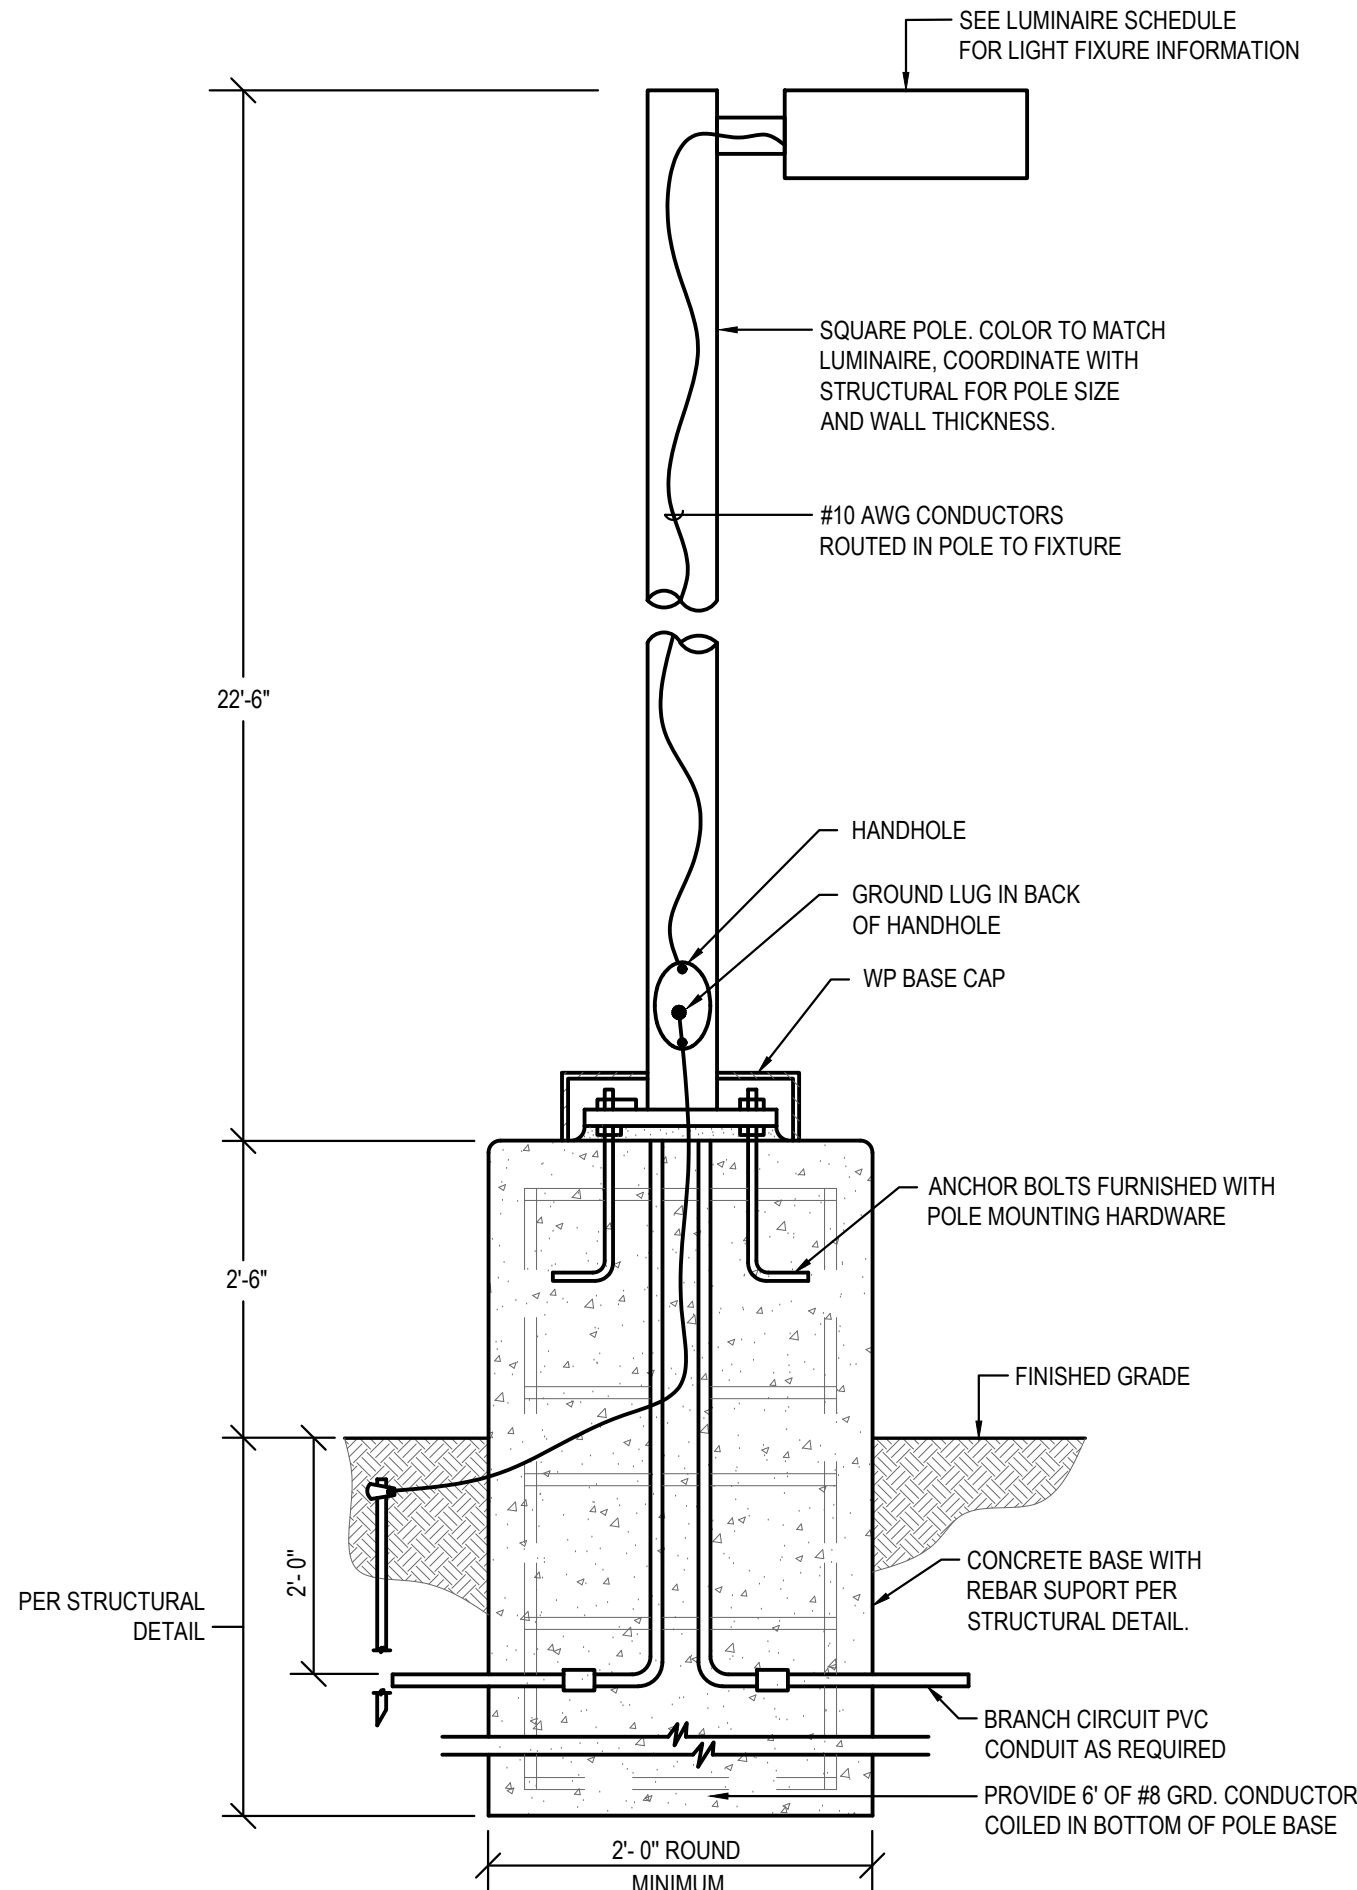

NOTE: THE POLE MANUFACTURER SHALL PROVIDE AN ENGINEERED POLE BASE DESIGN FOR 100 MPH WIND LOADING WITH A 1.3 GUST FACTOR. THE POLE BASE DESIGN SHALL BE FROM A STRUCTURAL ENGINEER REGISTERED IN THE STATE OF ARIZONA. THE STRUCTURAL ENGINEER SHALL VERIFY THE WIND LOADING AND GUST FACTOR CRITERIA ABOVE ARE ADEQUATE FOR THE AREA OF INSTALLATION.

TYPE: S8

Project

Catalog #

Type

Prepared by

Notes

Date



Lumark
Axcent
Wall Mount Luminaire
Product Features
Light Management
BAA

Interactive Menu

- Ordering Information page 2
- Mounting Details page 3
- Product Specifications page 4
- Energy and Performance Data page 4
- Control Options page 5

Product Certifications

- ISU
- DLC ULISTED
- DLC ETL
- 3G VIB
- IP66
- UL
- IEC
- YEAR



Quick Facts

- Available in 14W - 123W (1,800 - 17,000 lumens) models
- Full cutoff and refractive lens models available
- Energy and maintenance savings up to 95% compared to HID
- Energy efficient illumination results in up to 144 LPW
- Replaces 70W up to 450W HID equivalents

Connected Systems

- WaveLinX Lite
- Enlighted

Dimensional Details
Full Cutoff

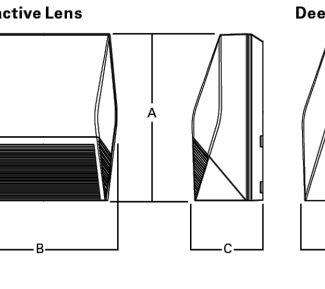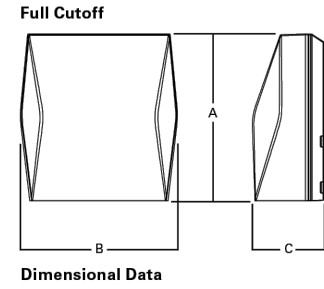

Dimensional Data	AXCS1A-CBP	AXCS1A-CBP
A	8" [203mm]	11 1/2" [292mm]
B	7 1/2" [190mm]	10 3/4" [273mm]
C	3 5/8" [94mm]	4 7/8" [124mm]
D	6 1/8" [155mm]	7 1/8" [181mm]

COOPER Lighting Solutions

PH0141022EN page 1
January 30, 2023 11:17 AM

SÄZÄN GROUP
311 E. Veterans Way, Ste. 102
Tempe, Az 85281
Tel 480.530.9101
Fax 206.267.1701
SAZAN # 837-23093




MERIDIAN 24 INDUSTRIAL
6450 S MERIDIAN RD
MESA, ARIZONA 85212

ELECTRICAL LIGHTING SCHEDULE	
DATE	REMARKS


PA/PM:	M. RETZLAFF
DRAWN BY:	Author
JOB NO.:	PHX22-0015-00

SHEET
E2.00

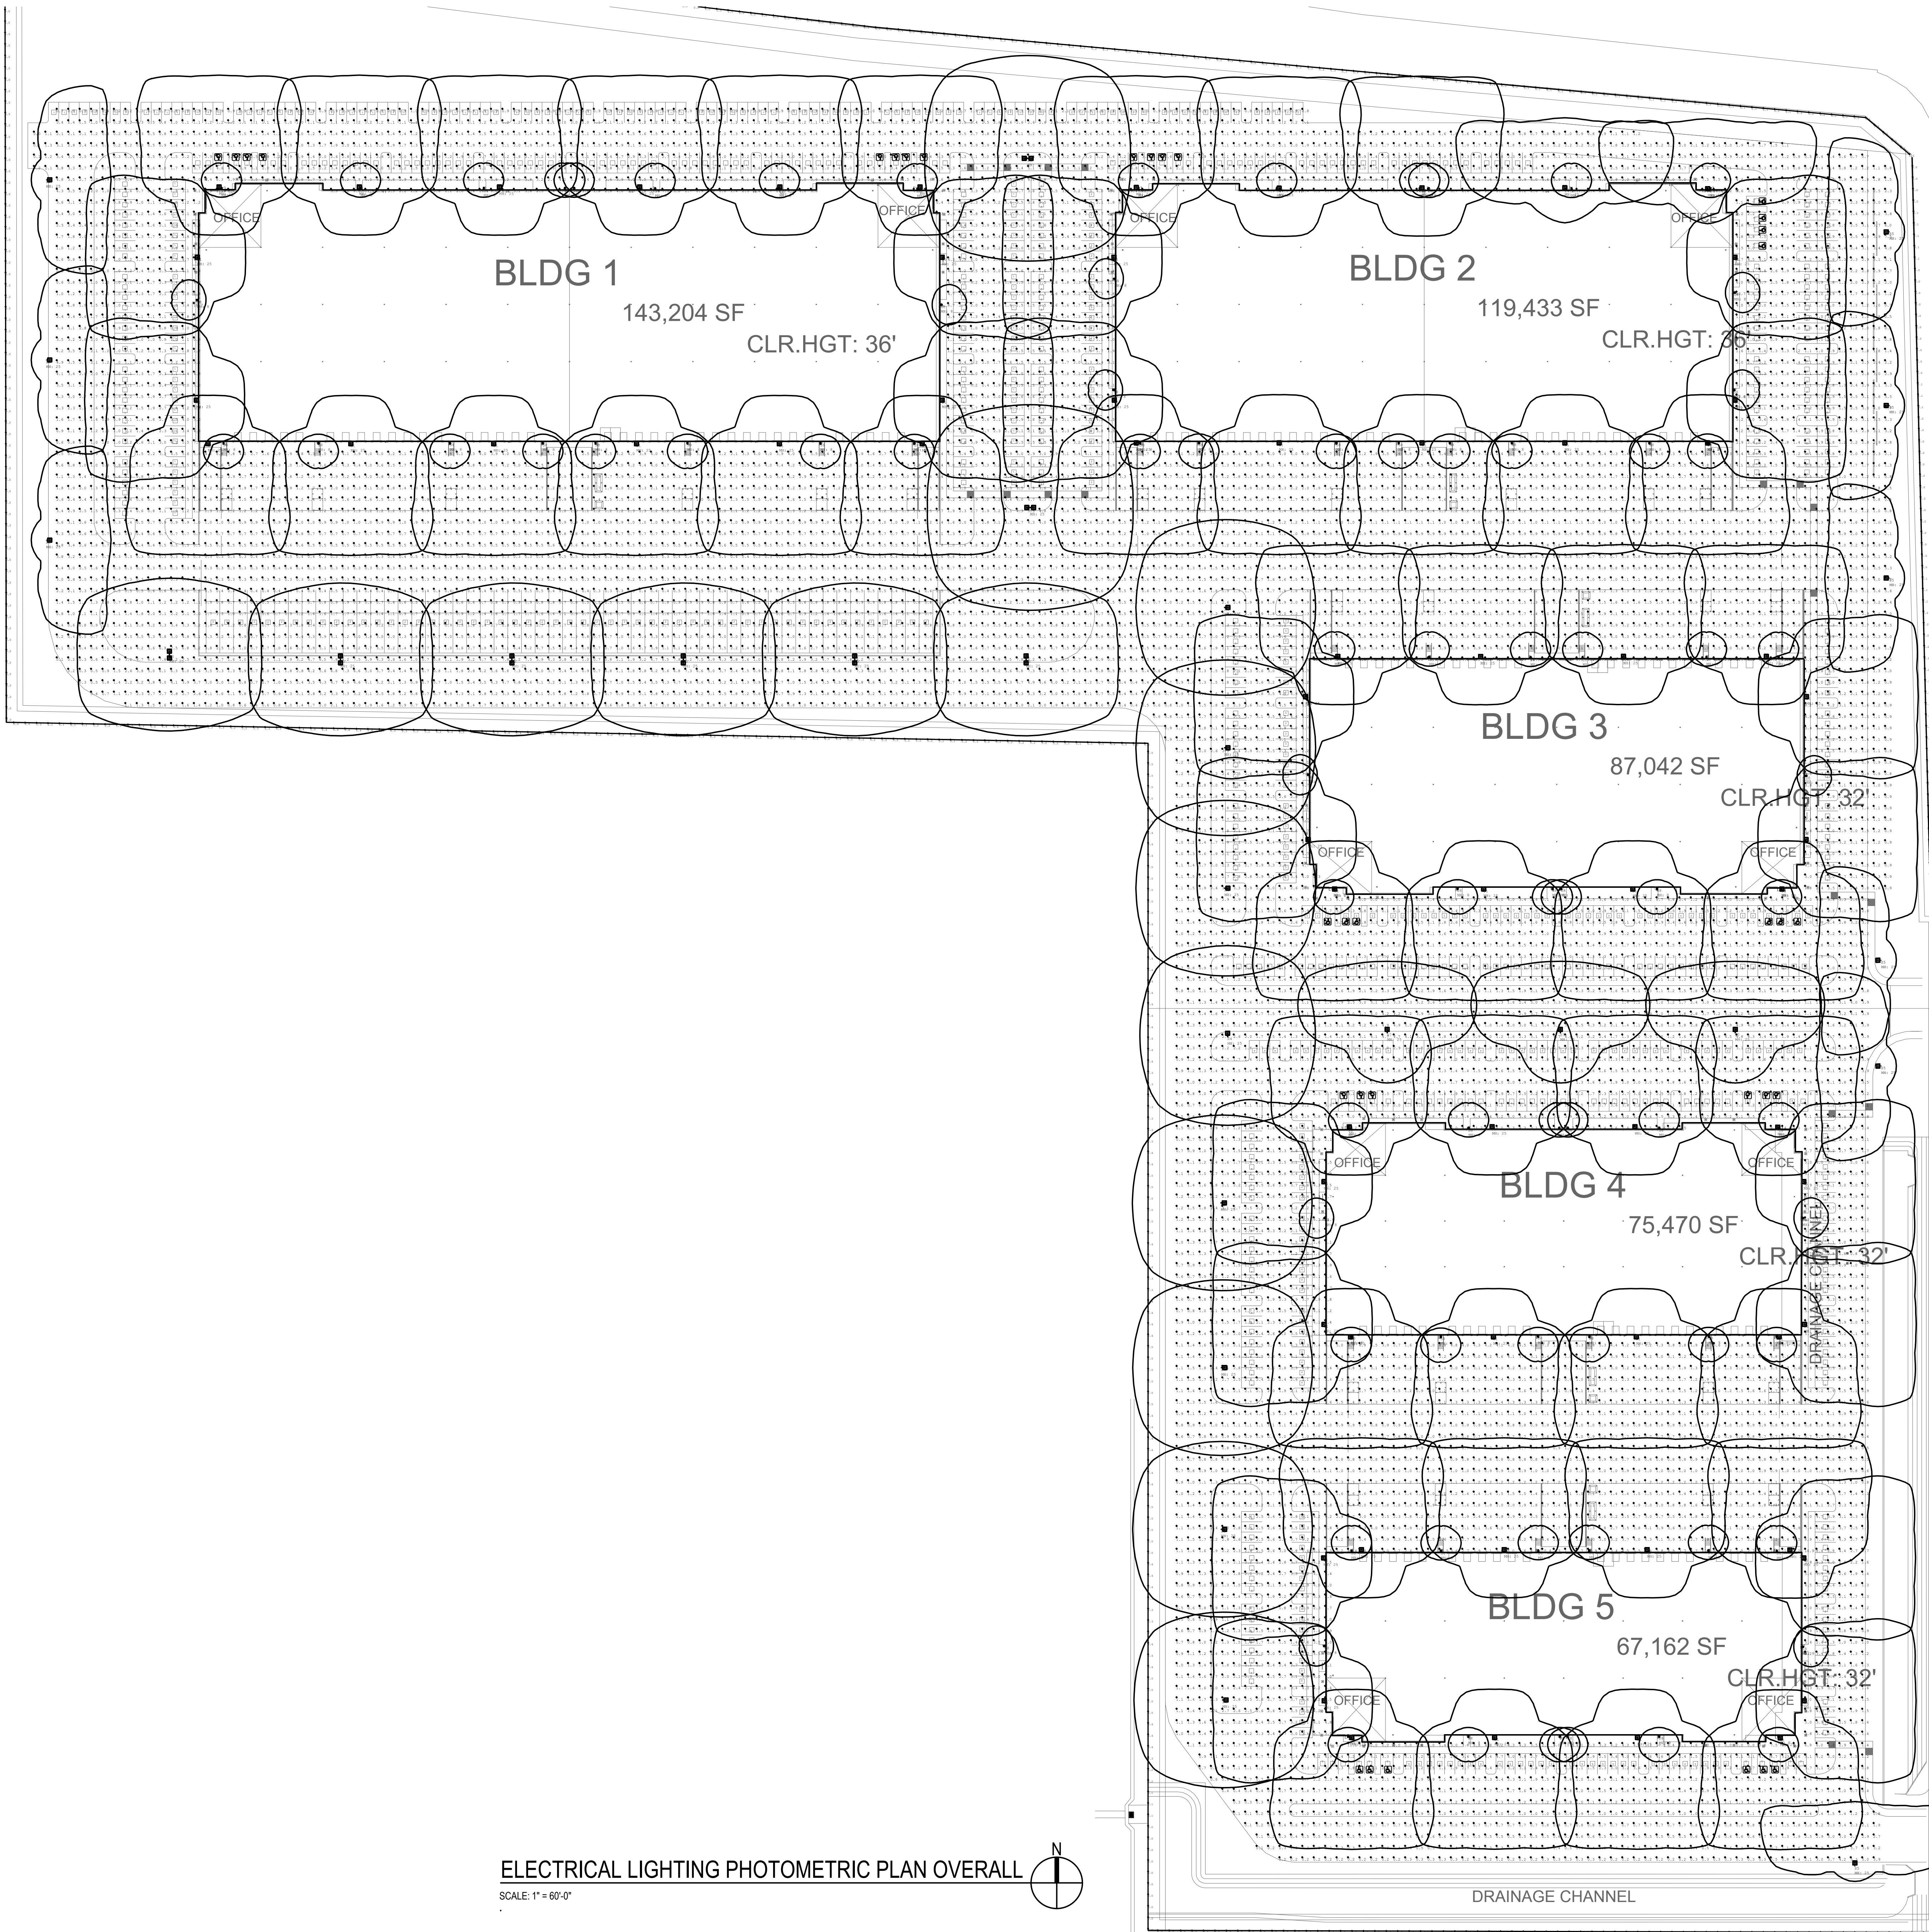

ELECTRICAL LIGHTING PHOTOMETRIC PLAN OVERALL

SCALE: 1" = 60'-0"

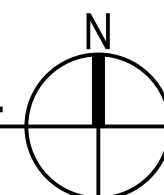

SÄZAN
GROUP

311 E. Veterans Way, Ste. 102
Tempe, Az 85281

Tel 480.530.9101
Fax 206.267.1701
SAZAN # 837-23093

ELECTRICAL SITE LIGHTING PHOTOMETRIC PLAN

DATE	REMARKS

PA/PM: M. RETZLAFF
DRAWN BY: Author
JOB NO.: PHX22-0015-00

SHEET

E3.00

MERIDIAN 24 INDUSTRIAL

6450 S MERIDIAN RD
MESA, ARIZONA 85212



2777 E. Camelback Rd. Suite 4025
Phoenix, AZ 85016
P 480.757.1001

THESE DRAWINGS AND SPECIFICATIONS ARE THE PROPERTY AND COPYRIGHT OF WARE MALCOMB AND SHALL NOT BE USED ON ANY OTHER WORK EXCEPT BY AGREEMENT WITH WARE MALCOMB. WRITTEN DIMENSIONS SHALL TAKE PRECEDENCE OVER SCALED DIMENSIONS AND SHALL BE EMPLOYED ON THE JOB SITE. ANY DISCREPANCY SHALL BE BROUGHT TO THE NOTICE OF WARE MALCOMB PRIOR TO THE COMMENCEMENT OF ANY WORK.

6/27/2023 4:13:12 PM
XXXXXXX - 85% CD SET



MERIDIAN 24 INDUSTRIAL

6450 S MERIDIAN RD
MESA, ARIZONA 85212

ELECTRICAL PHOTOMETRIC PLAN - BUILDING 1


[illegible]

PA/PM:	M. RETZLAFF
--------	-------------

SHEET


E3.01

6/27/2023 4:13:12 PM XX/XX/XXXX - 85% CD SET

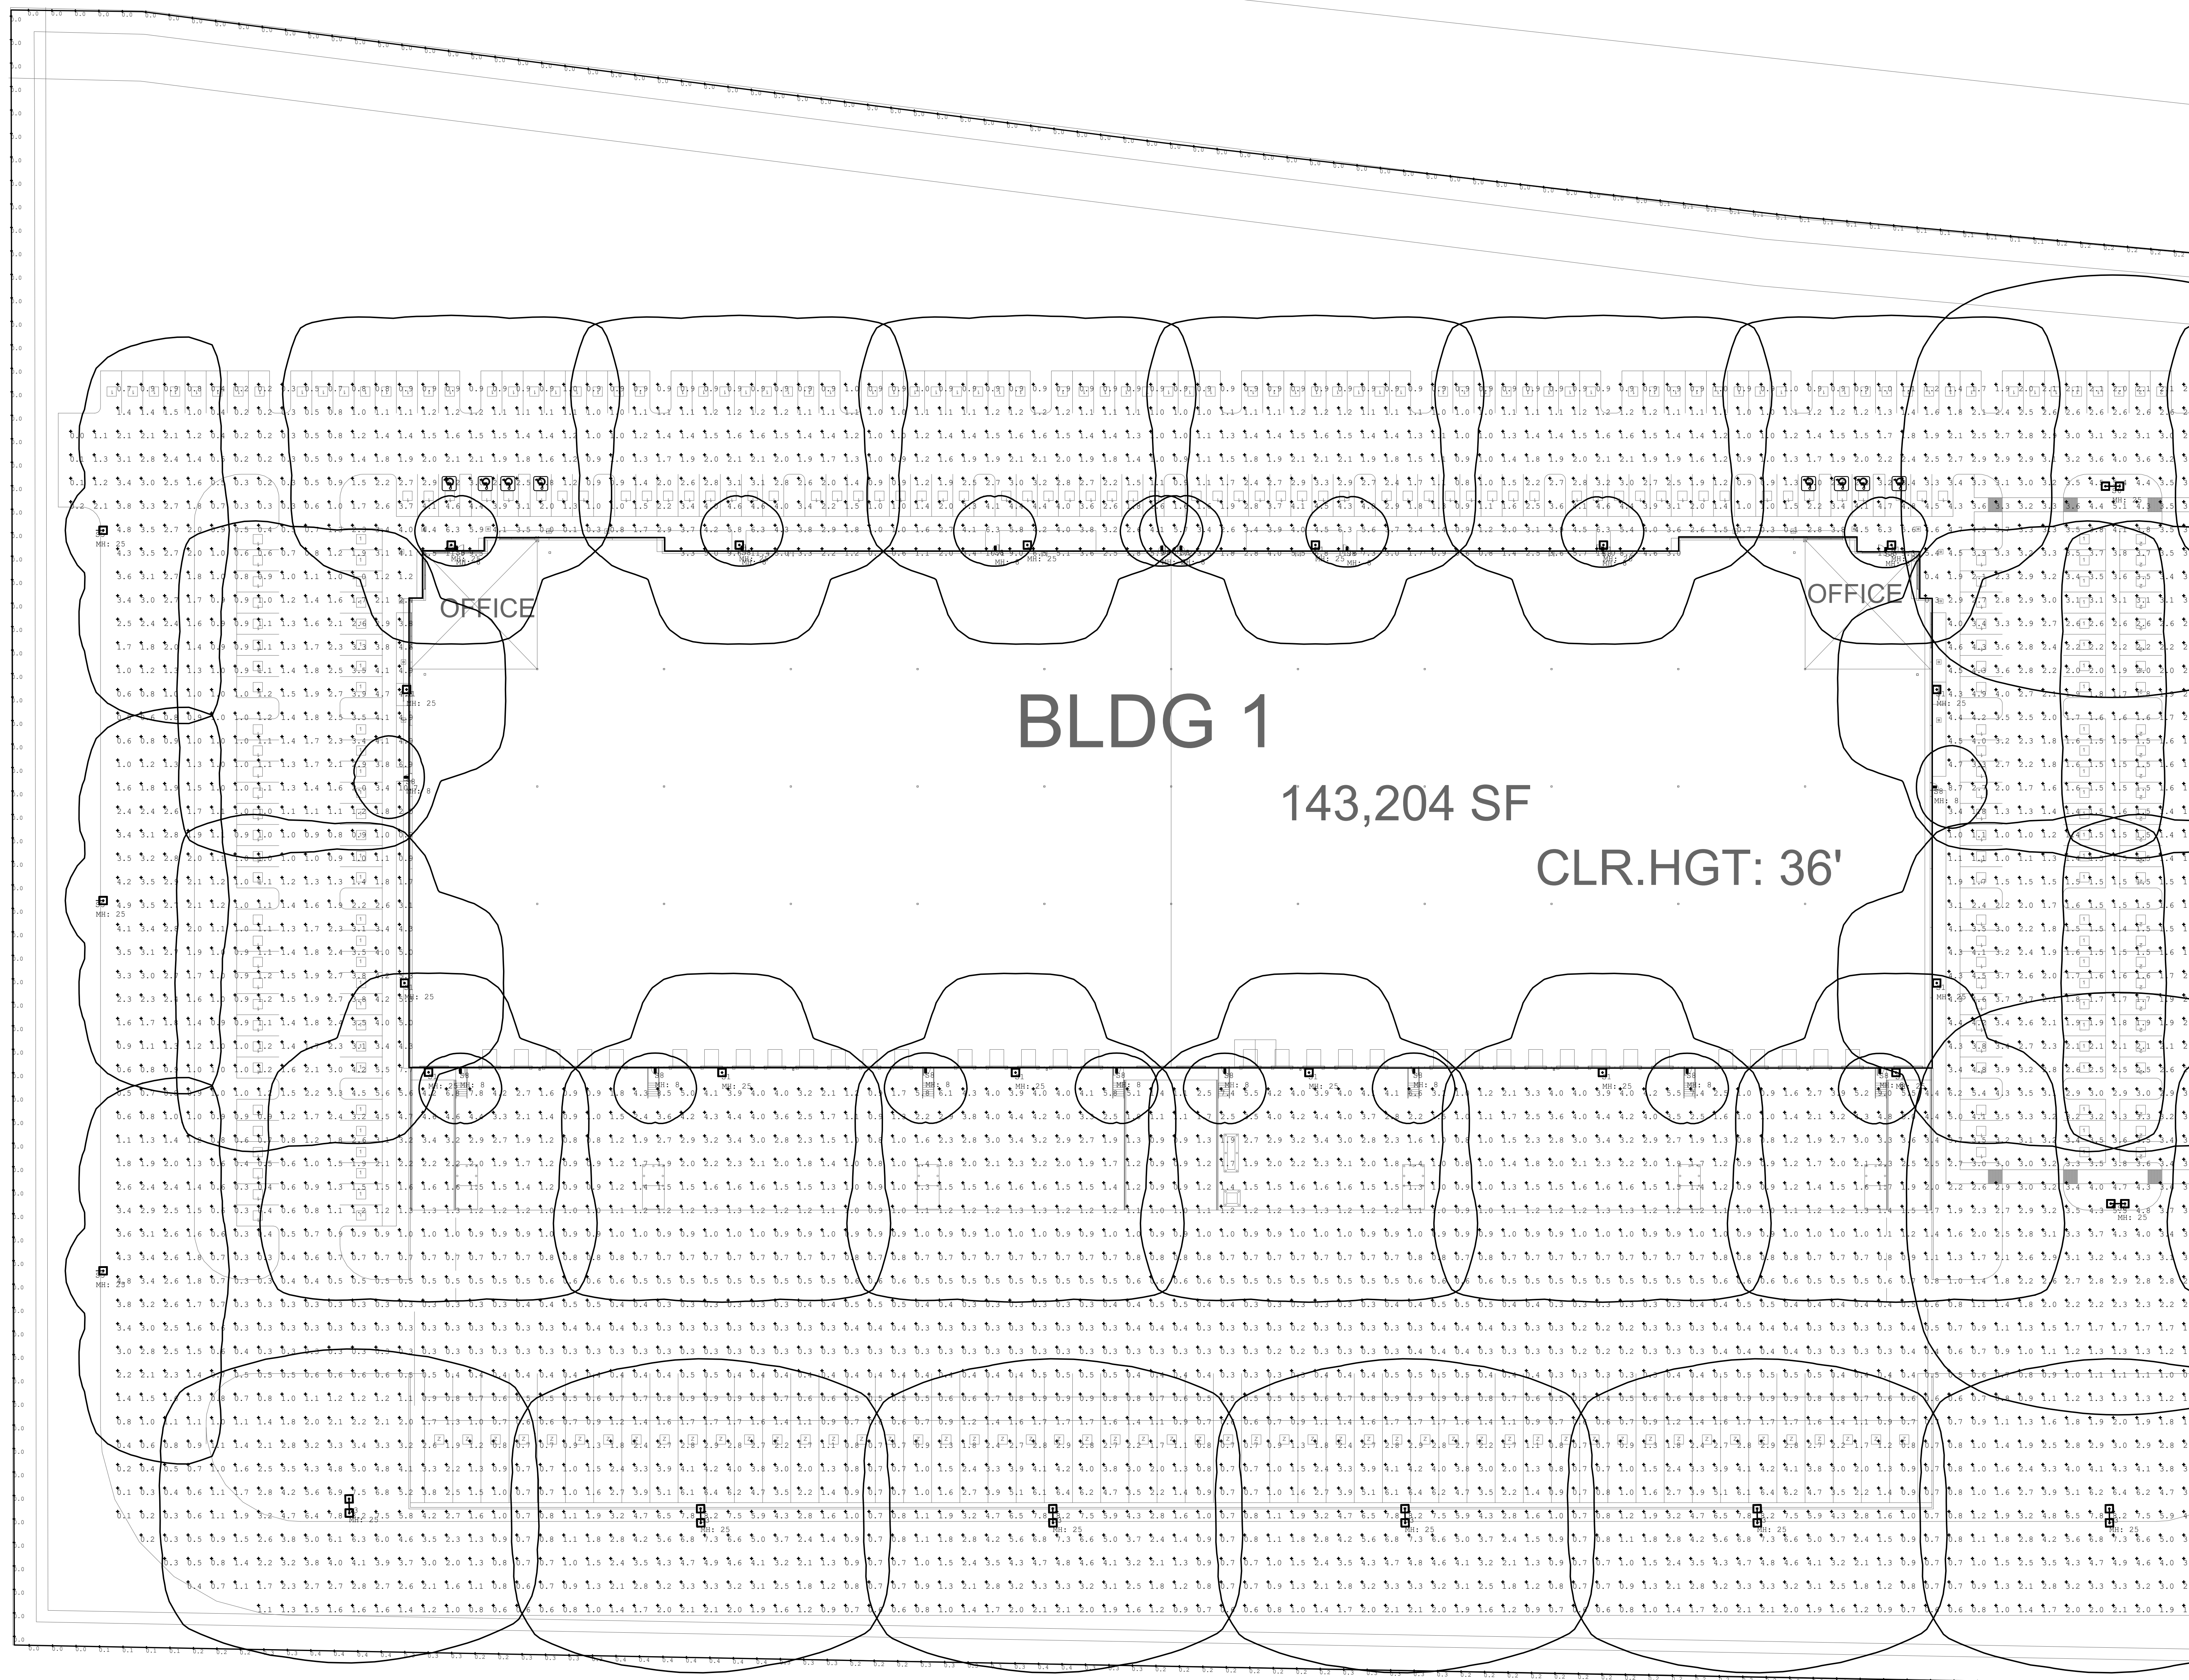

ELECTRICAL PHOTOMETRIC PLAN - BUILDING 1

SCALE: 1" = 30'-0"

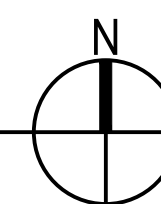

SÄZÄN
GROUP

311 E. Veterans Way, Ste. 102
Tempe, Az 85281

 Tel 480.530.9101
Fax 206.267.1701
SAZAN # 837-23093

SAZAN # 837-23093



MERIDIAN 24 INDUSTRIAL

6450 S MERIDIAN RD
MESA, ARIZONA 85212


[illegible]

PA/PM:	M. RETZLAFF
DRAWN BY.:	Author
JOB NO.:	PHX22-0015-00

SHEET


E3.02

6/27/2023 4:13:12 PM XX/XX/XXXX - 85% CD SET

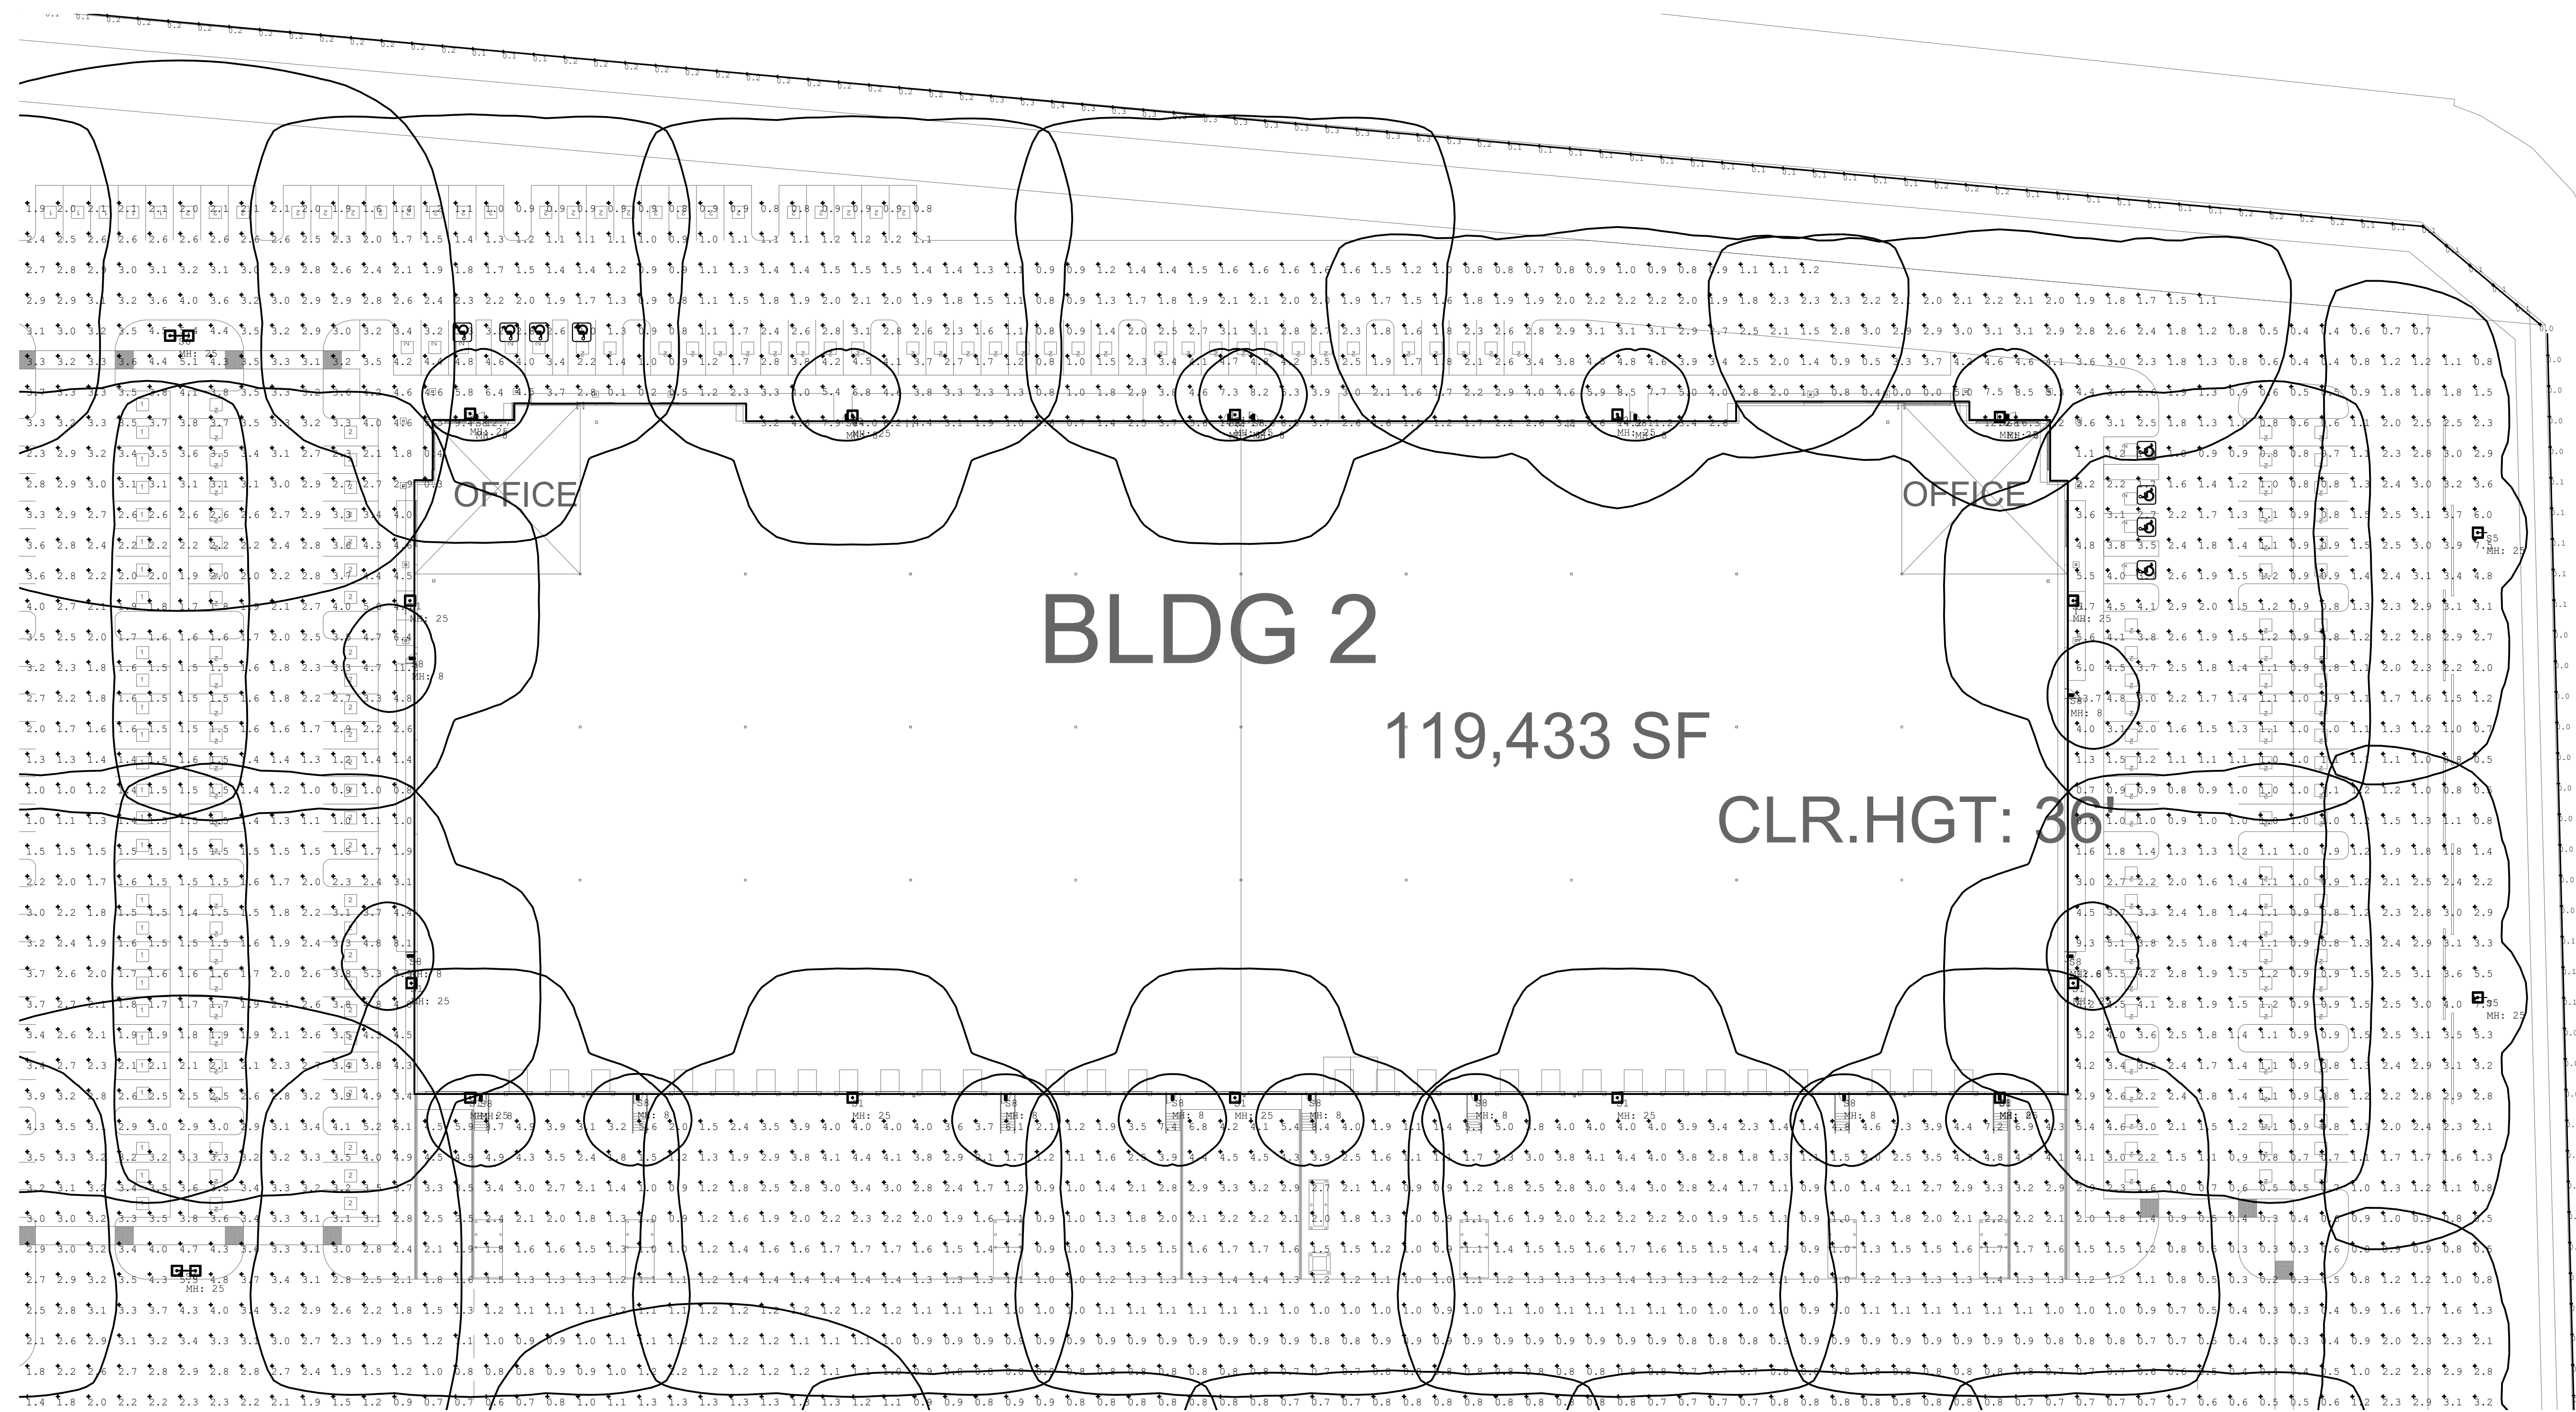

ELECTRICAL PHOTOMETRIC PLAN - BUILDING 2

SCALE: 1" = 60'-0"

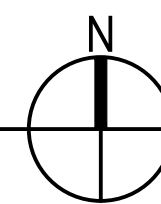

SÄZÄN
GROUP

311 E. Veterans Way, Ste. 102
Tempe, Az 85281

 Tel 480.530.9101
Fax 206.267.1701
SAZAN # 837-23093

2777 E. Camelback Rd. Suite 4025
Phoenix, AZ 85016
P 480.757.1001



THESE DRAWINGS AND SPECIFICATIONS ARE THE PROPERTY AND COPYRIGHT OF WARE MALCOMB AND SHALL NOT BE USED ON ANY OTHER WORK EXCEPT BY AGREEMENT WITH WARE MALCOMB. WRITTEN DIMENSIONS SHALL TAKE PRECEDENCE OVER SCALED DIMENSIONS AND SHALL BE EMPLOYED TO THE NOTICE OF WARE MALCOMB PRIOR TO THE COMMENCEMENT OF ANY WORK.

MERIDIAN 24 INDUSTRIAL

6450 S MERIDIAN RD
MESA, ARIZONA 85212

ELECTRICAL PHOTOMETRIC PLAN - BUILDING 3

DATE

REMARKS


PA/PM: M. RETZLAFF
DRAWN BY: Author
JOB NO.: PHX22-0015-00

SHEET

E3.03


XXXXXXX - 85% CD SET

SAZAN GROUP
311 E. Veterans Way, Ste. 102
Tempe, Az 85281
Tel 480.530.9101
Fax 206.267.1701
SAZAN # 837-23093

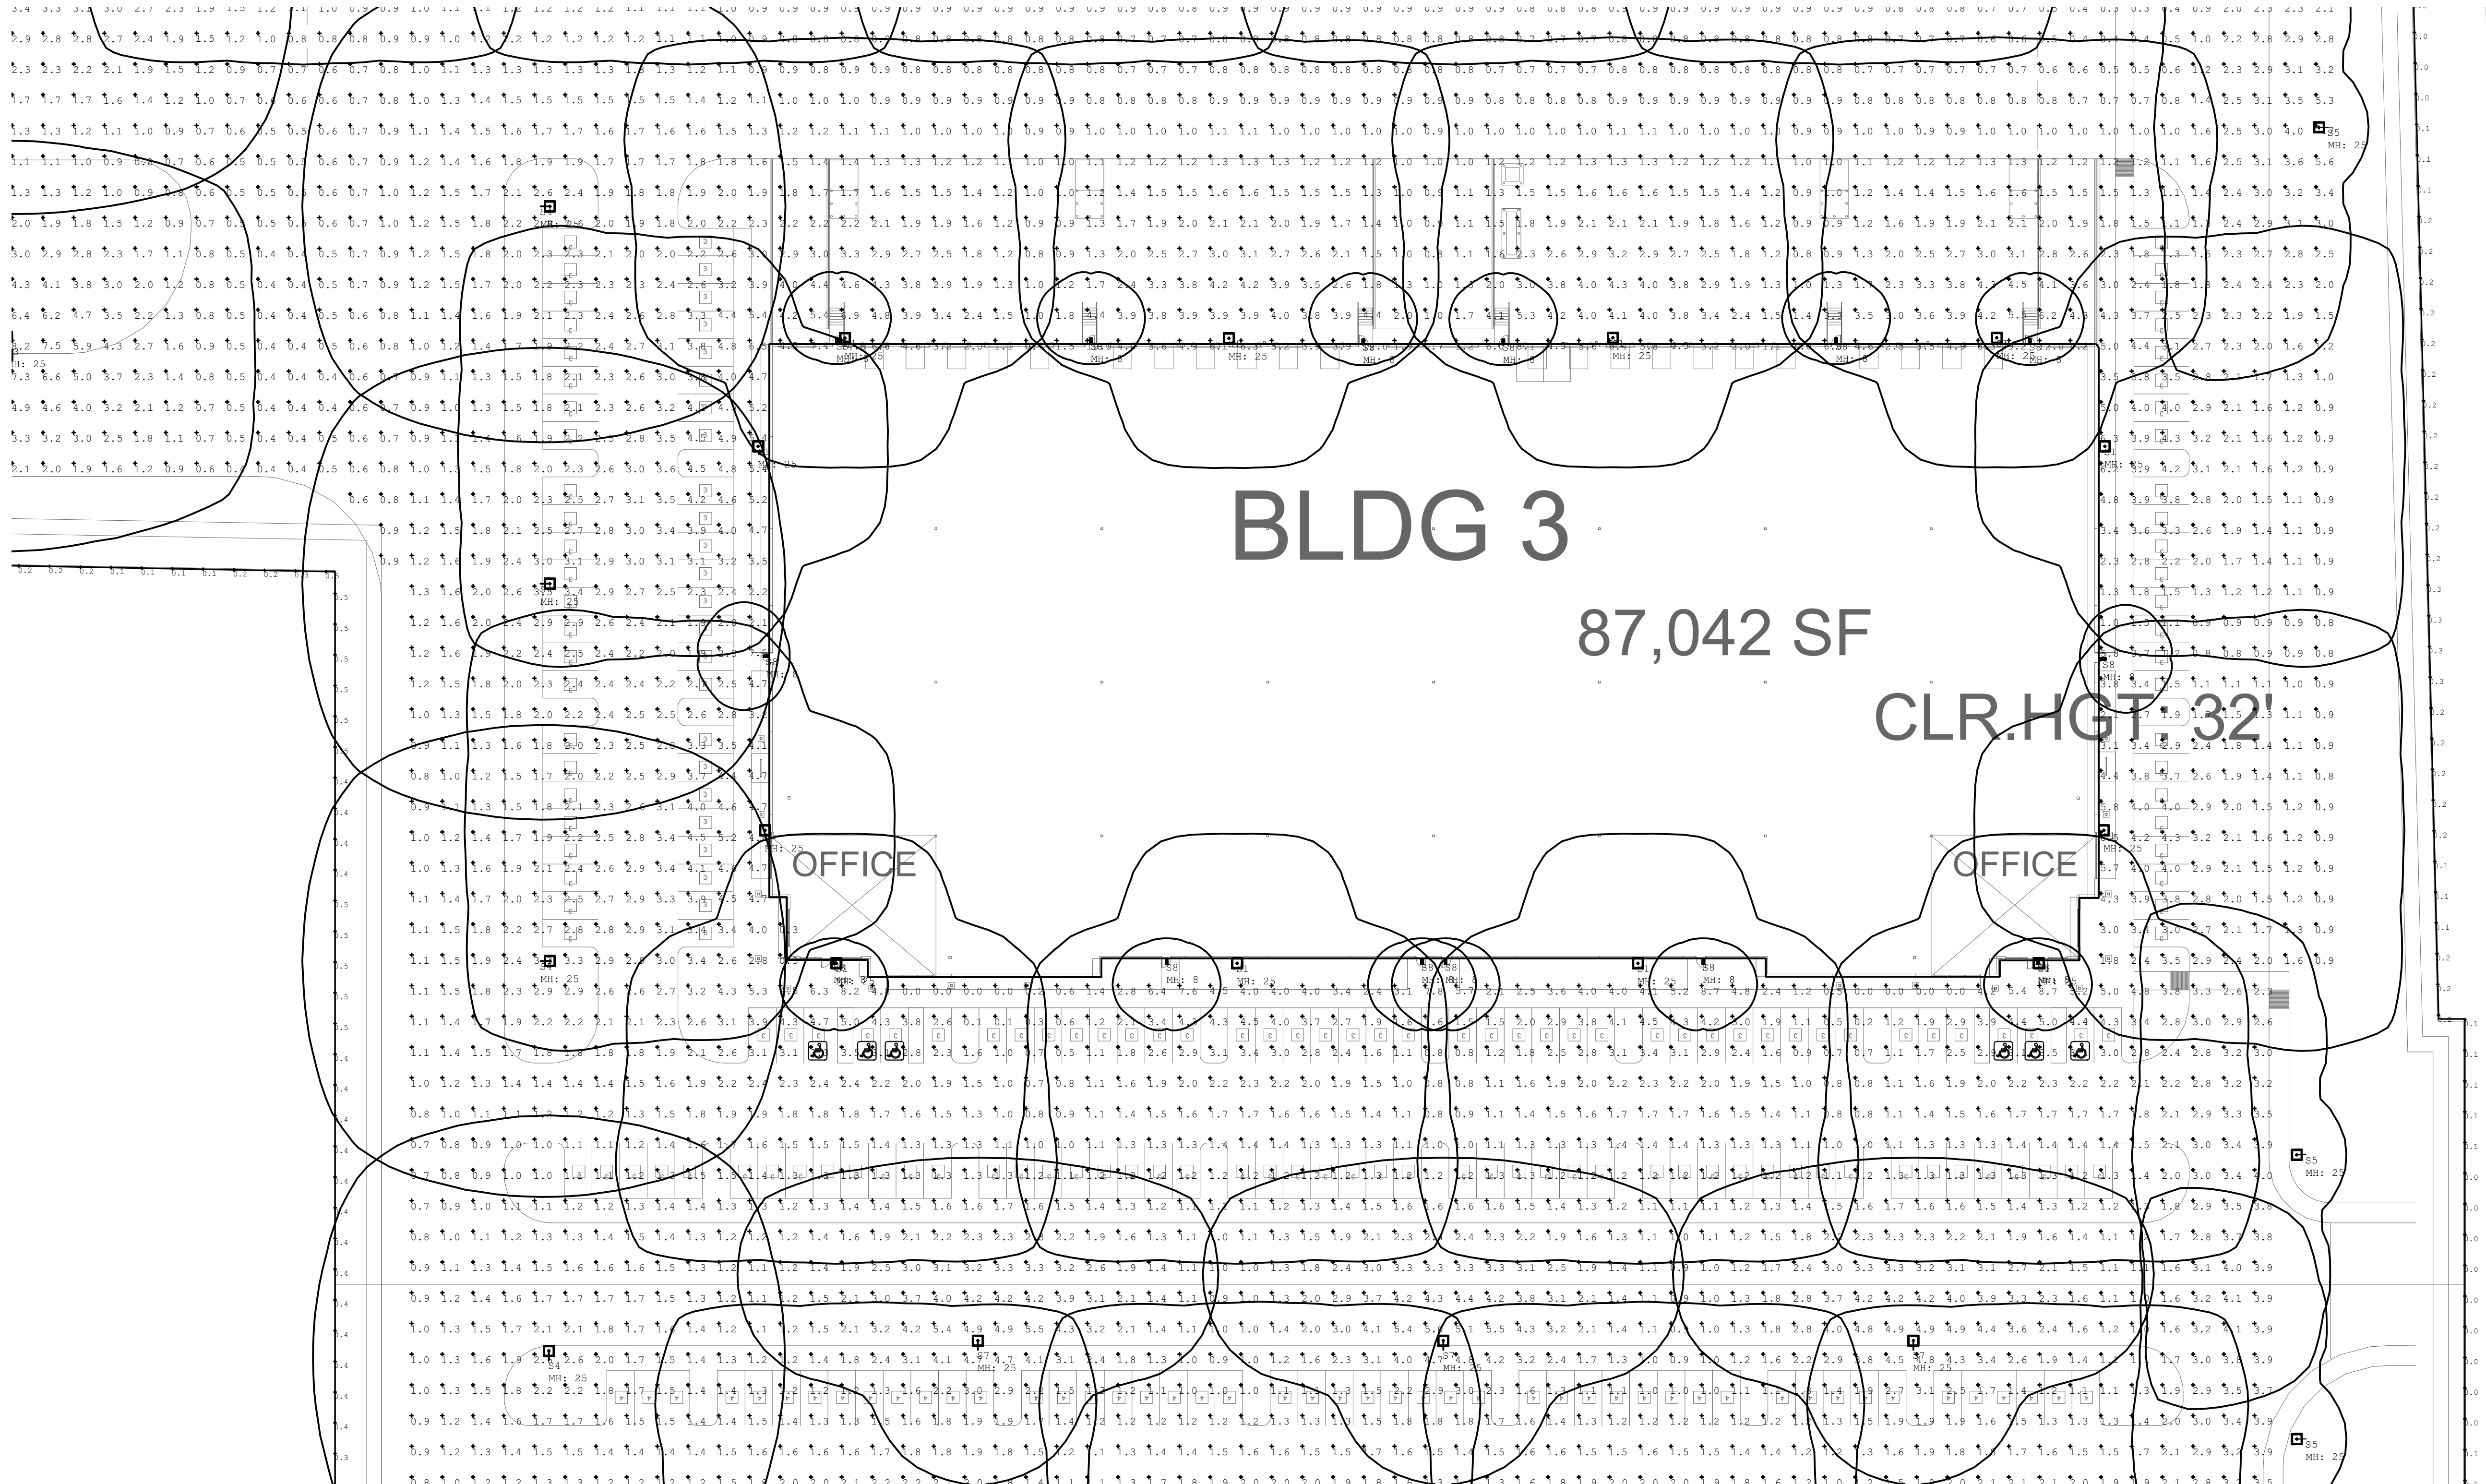

ELECTRICAL PHOTOMETRIC PLAN - BUILDING 3

SCALE: 1" = 60'-0"

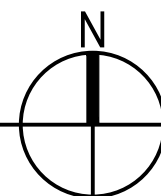

2777 E. Camelback Rd. Suite 4025
Phoenix, AZ 85016
P 480.757.1001



THESE DRAWINGS AND SPECIFICATIONS ARE THE PROPERTY AND COPYRIGHT OF WARE MALCOMB AND SHALL NOT BE USED ON ANY OTHER WORK EXCEPT BY AGREEMENT WITH WARE MALCOMB. WRITTEN DIMENSIONS SHALL TAKE PRECEDENCE OVER SCALED DIMENSIONS AND SHALL BE BROUGHT TO THE NOTICE OF WARE MALCOMB PRIOR TO THE COMMENCEMENT OF ANY WORK.

MERIDIAN 24 INDUSTRIAL

6450 S MERIDIAN RD
MESA, ARIZONA 85212

ELECTRICAL PHOTOMETRIC PLAN - BUILDING 4


DATE		REMARKS	

PA/PM:	M. RETZLAFF
DRAWN BY:	Author
JOB NO.:	PHX22-0015-00

SHEET

E3.04

6/27/2023 4:13:12 PM XXXXXXXX - 85% CD SET

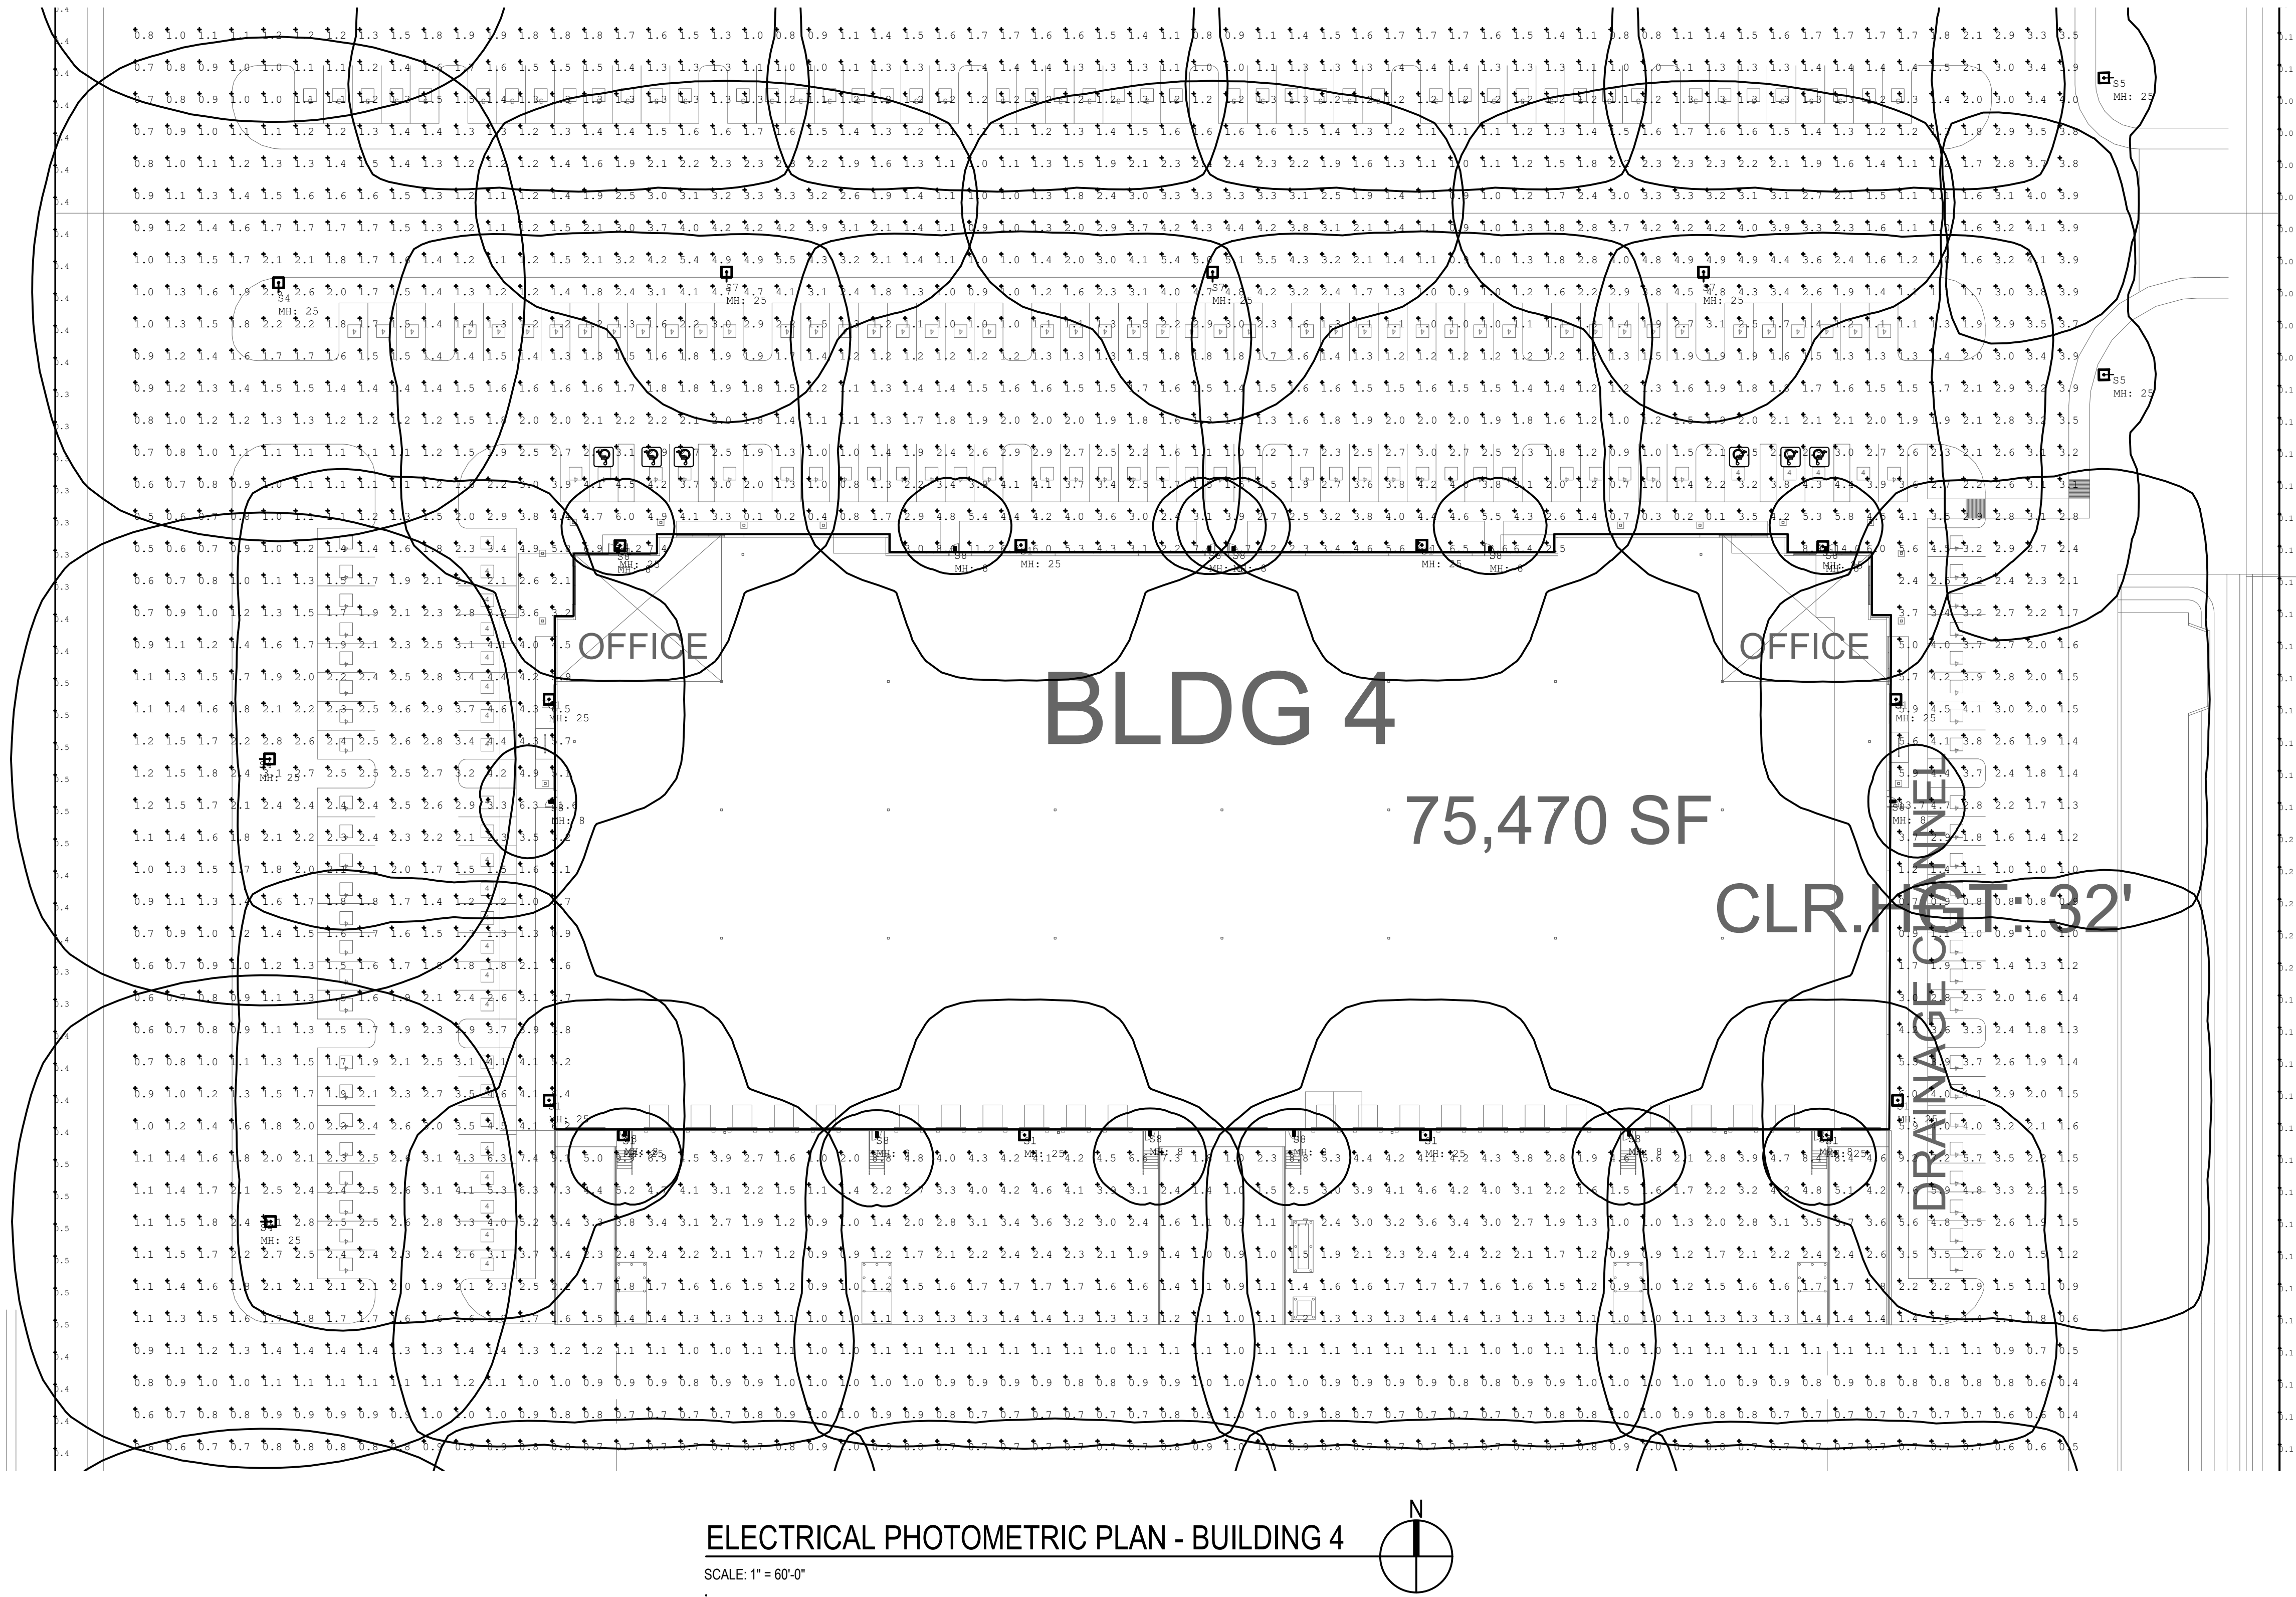

SÄZÄN GROUP
311 E. Veterans Way, Ste. 102
Tempe, Az 85281
Tel 480.530.9101
Fax 206.267.1701
SAZAN # 837-23093

2777 E Camelback Rd. Suite 4025
Phoenix, AZ 85016
P:480.757.1001



THESE DRAWINGS AND SPECIFICATIONS ARE THE PROPERTY AND COPYRIGHT OF WARE MALCOMB AND SHALL NOT BE USED ON ANY OTHER WORK EXCEPT BY AGREEMENT WITH WARE MALCOMB. WRITTEN DIMENSIONS SHALL TAKE PRECEDENCE OVER SCALED DIMENSIONS AND SHALL BE EMPLOYED TO THE NOTICE OF WARE MALCOMB PRIOR TO THE COMMENCEMENT OF ANY WORK.

MERIDIAN 24 INDUSTRIAL

6450 S MERIDIAN RD
MESA, ARIZONA 85212

ELECTRICAL PHOTOMETRIC PLAN - BUILDING 5

PA/PM: M. RETZLAFF
DRAWN BY: Author
JOB NO.: PHX22-0015-00

SHEET


E3.05

6/27/2023 4:13:12 PM XXXXXXXX - 85% CD SET

SÄZÄN GROUP

311 E. Veterans Way, Ste. 102
Tempe, Az 85281

Tel 480.530.9101
Fax 206.267.1701
SAZAN # 837-23093

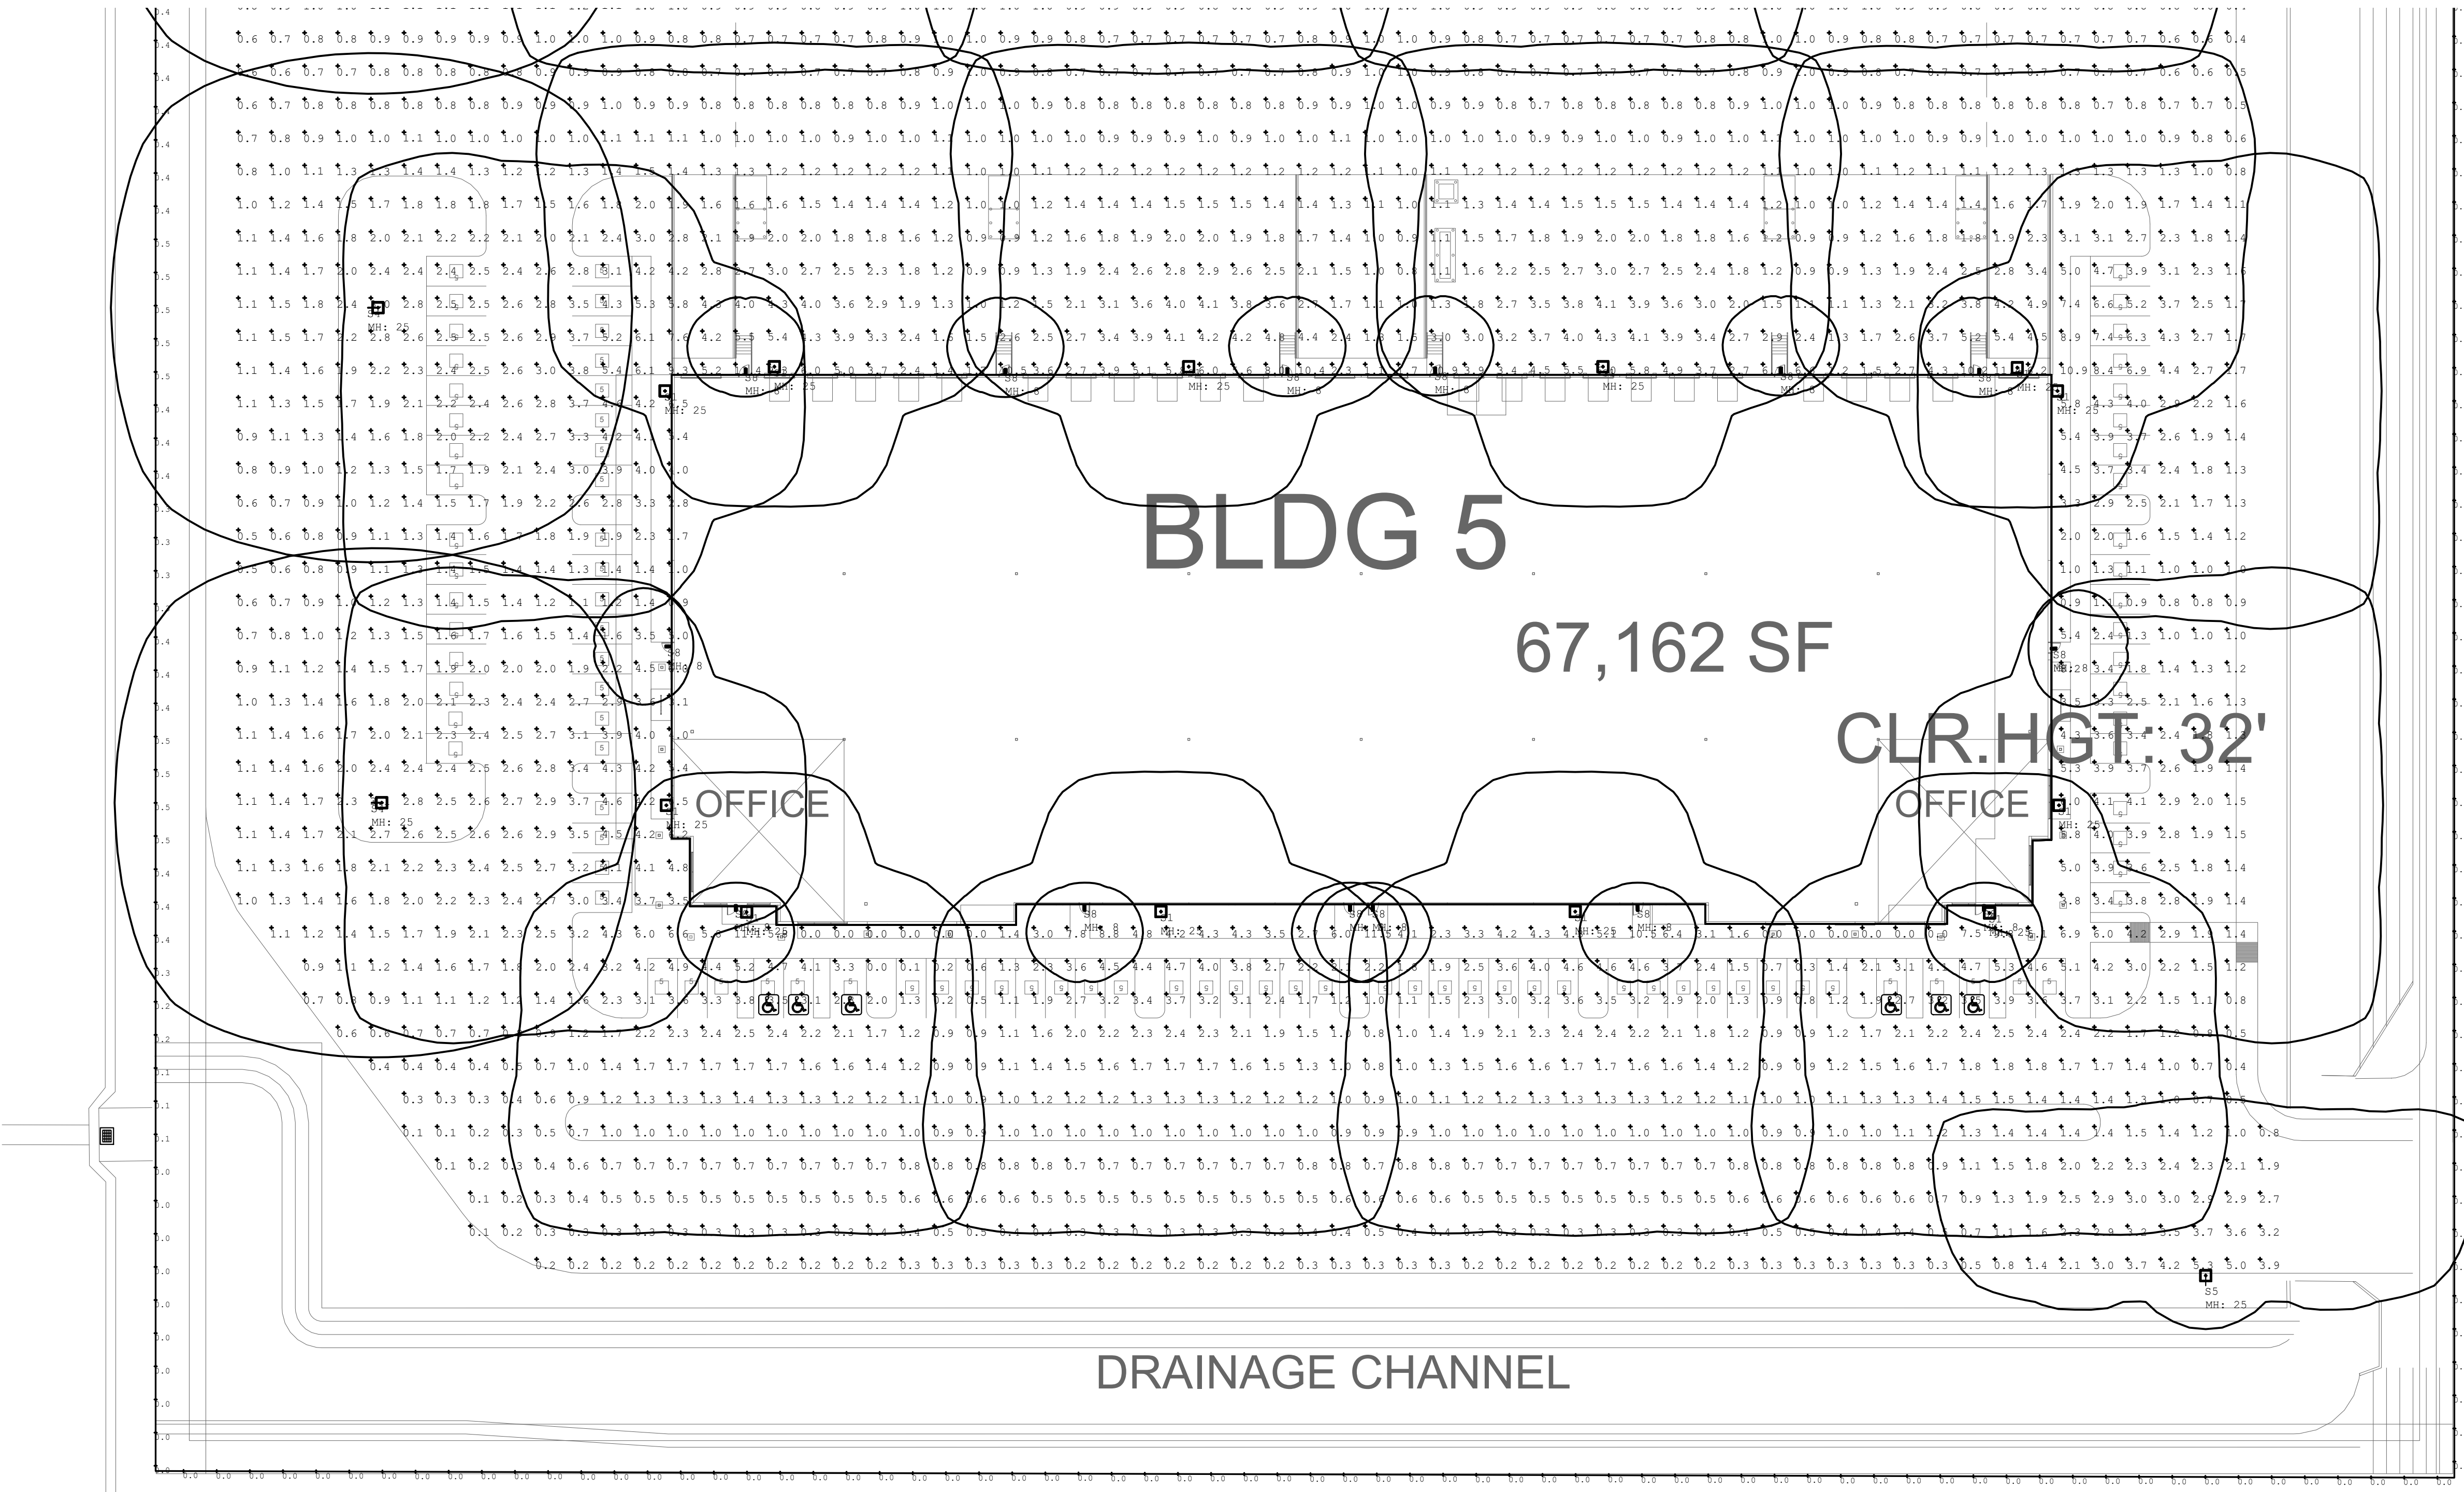

ELECTRICAL PHOTOMETRIC PLAN - BUILDING 5

SCALE: 1" = 60'-0"

