

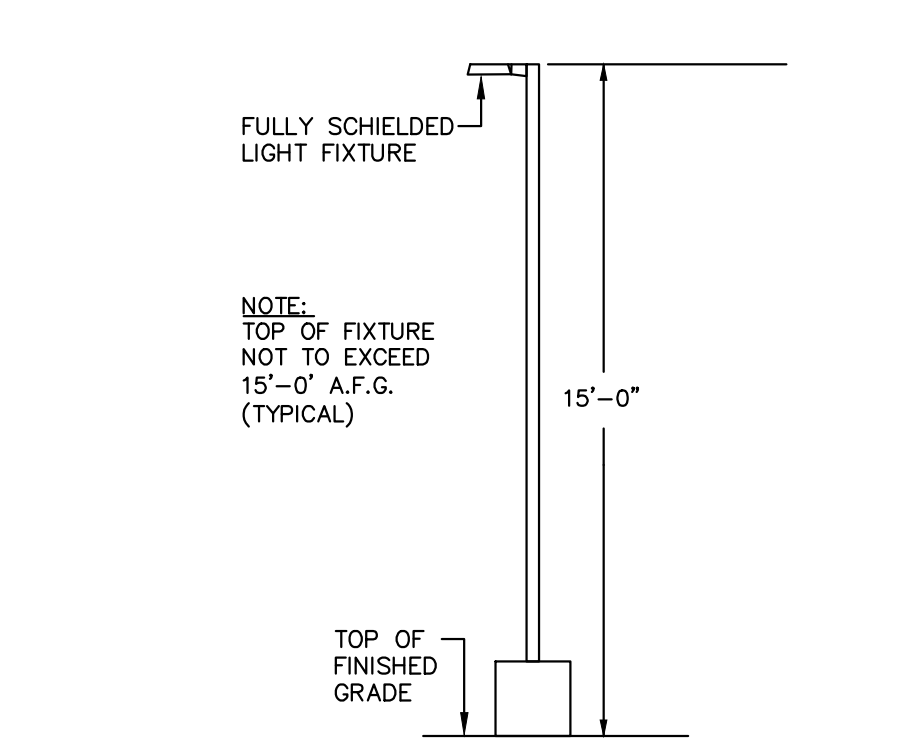


Diagram illustrating the mounting of a light fixture (type 'SD') to the side of a structural steel beam. The fixture is mounted to the side of the beam, and the light pattern is shielded by steel framing, preventing light from trespassing onto adjacent property. The diagram also shows the top of the finished grade.

CARPORT LIGHT DETAIL

NTS



74770 Highway 111, Suite 203
Indian Wells, CA 92210
rtmec.com | 760.340.8005



EDI International, PC
3250 Briarpark Dr.
Suite 140
Houston, TX 77042
Phone: (713) 375-1400
Fax: (713) 375-1600
www.EDI-International.com
TEXAS CALIFORNIA NEW YORK

HAWES CROSSING
MESA, AZ, 85212
FORE GREEN DEVELOPMENT

[illegible]


Project No.	22017
Issued:	SUBMITTAL
Issue Date:	10/03/2022

DRAWING TITLE

**ELECTRICAL SITE
LIGHTING PLAN**

Scale:
DRAWING NUMBER

E1.1

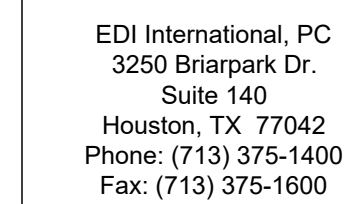

MESA, AZ, 85212

FORE GREEN DEVELOPMENT




TYPICAL FOR 'SA','SB','SC'

NTS



NTS

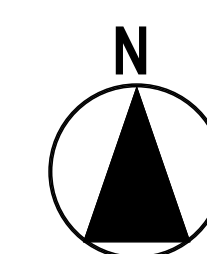

ELECTRICAL SITE LIGHTING PLAN (SOUTH) 1"=30'-0"

[illegible][illegible]

Project No.	22017
Issued:	SUBMITTAL
Issue Date:	10/03/2022


DRAWING TITLE

ELECTRICAL SITE LIGHTING PLAN

Scale:

DRAWING NUMBER

E1.2

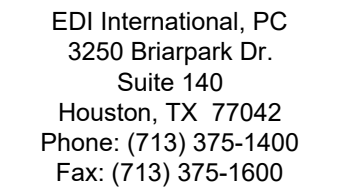

HAWES CROSSING
MESA, AZ, 85212
FORE GREEN DEVELOPMENT

Project No. 22017
Issued: SUBMITTAL
Issue Date: 10/03/2022

Scale:


DRAWING NUMBER



rtm
engineering consultants
74770 Highway 111, Suite 203
Indian Wells, CA 92210
rtmec.com | 760.340.9005



1

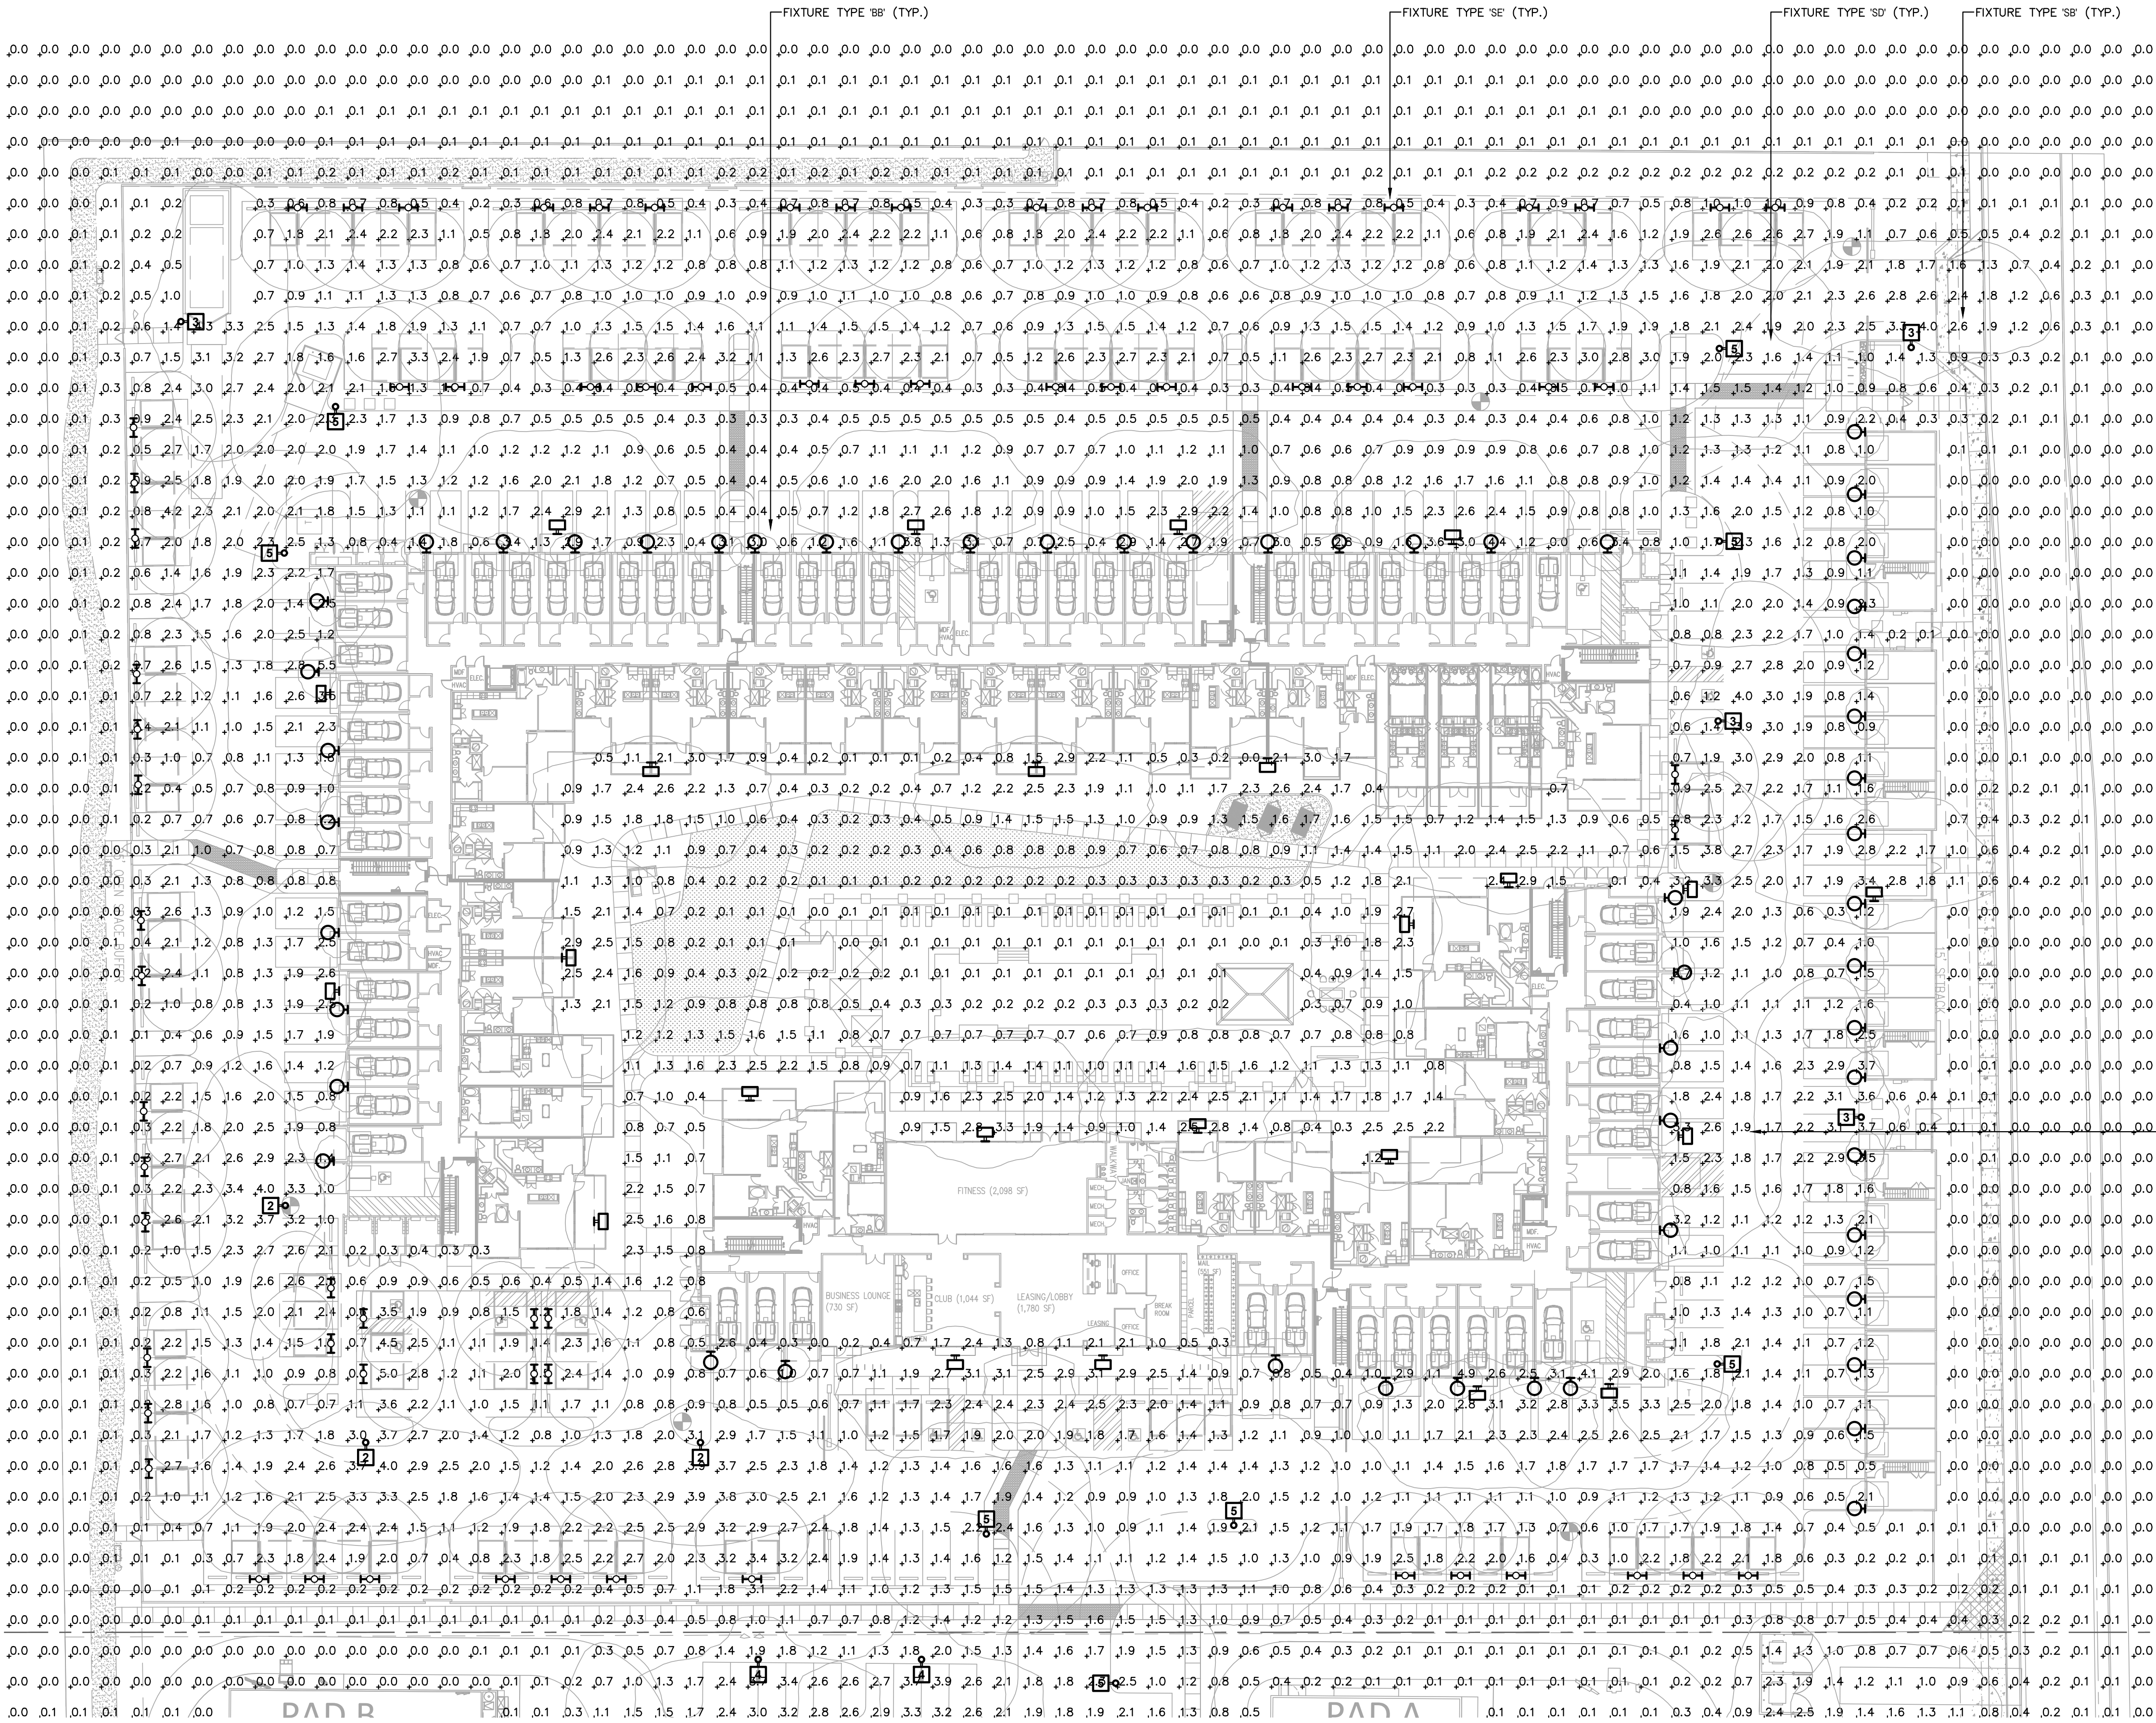



EDI International, PC
3250 Briarpark Dr.
Suite 140
Houston, TX 77042
Phone: (713) 375-1400
Fax: (713) 375-1600

www.EDI-International.com
TEXAS CALIFORNIA NEW YORK

HAWES CROSSING

MESA, AZ, 85212

FORE GREEN DEVELOPMENT


COPYRIGHT © 2022 EDI INTERNATIONAL, PC ALL RIGHTS RESERVED		
NO.	DATE	ISSUE

Project No. 22017
Issued: SUBMITTAL
Issue Date: 10/03/2022

DRAWING TITLE
**SITE
PHOTOMETRIC
PLAN**

Scale:
DRAWING NUMBER

E1.4

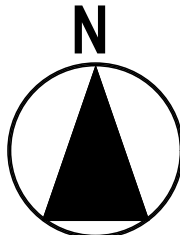

SITE PHOTOMETRICS (SOUTH) 1"=30'-0"

1

