


Statistics						
Description	Symbol	Avg	Max	Min	Max/Min	Avg/Min
SITE - FC @ GRADE	+	1.7 fc	8.7 fc	0.0 fc	N/A	N/A
PROPERTY LINE - FC @ 3' AFG	X	0.0 fc	0.1 fc	0.0 fc	N/A	N/A

Schedule										
Symbol	Label	Quantity	Manufacturer	Catalog Number	Description	Lamp	Filename	Lumens Per Lamp	Light Loss Factor	Wattage
SA	SA	1	LITHONIA LIGHTING	(2) DSX0 LED P4 30K 80CRI T5W MVOLT SPA (FINISH) / SSS 17.5" W/2.5" BASE	TWIN-HEAD AREA LUMINAIRE WITH P4 PERFORMANCE PACKAGE - TYPE 5W	LED - 3000K	DSX0_LED_P4_30K_80CRI_T5W_Jes	10288	0.91	186.08
SB	SB	1	LITHONIA LIGHTING	DSX0 LED P4 30K 80CRI T5W MVOLT SPA (FINISH) / SSS 17.5" W/2.5" BASE	AREA LUMINAIRE WITH P4 PERFORMANCE PACKAGE - TYPE T5W	LED - 3000K	DSX0_LED_P4_30K_80CRI_T5W_Jes	9908	0.91	93.04
SC	SC	4	LITHONIA LIGHTING	DSX0 LED P5 30K 80CRI T3M MVOLT SPA HS (FINISH) / SSS 17.5" W/2.5" BASE	AREA LUMINAIRE WITH P4 PERFORMANCE PACKAGE - TYPE T3M W/WHOUSESIDE SHIELD	LED - 3000K	DSX0_LED_P5_30K_80CRI_T3M_HS_Jes	9129	0.91	90.12
SD	SD	2	LITHONIA LIGHTING	WDGE2 LED P4 30K 80CRI T3M MVOLT SRM (FINISH)	WDGE2 LED WITH P4 - PERFORMANCE PACKAGE, 3000K, 80CRI, TYPE 3 MEDIUM OPTIC	LED - 3000K	WDGE2_LED_P4_30K_80CRI_T3M_Jes	4065	0.91	46.6589
SFE	SFE	4	LITHONIA LIGHTING	WDGE2 LED P2 30K 80CRI T4M MVOLT SRM E20WC (FINISH)	WALL MOUNT WITH P2 PERFORMANCE PACKAGE AND EM BATTERY PACK - TYPE T4M	LED - 3000K	WDGE2_LED_P2_30K_80CRI_T4M_Jes	1922	0.91	18.9815
SG	SG	15	GOATHAM LIGHTING	EVO4SC 30/10 AR WD LSS MVOLT GZ10 (MOUNTING) WL (FINISH)	EVO 4IN ROUND CYLINDER, WET LOCATION SURFACE CEILING MOUNT, 80 CRI, 3000K, 1000LM, MED WIDE DIST, CLEAR SEMI-SPEC	LED - 3000K	EVO4SC_30_10_AR_WD_LSS_Jes	824	0.91	8.8
SGE	SGE	4	GOATHAM LIGHTING	EVO4SC 30/10 AR WD LSS MVOLT GZ10 (MOUNTING) E10WCP WL (FINISH)	EVO 4IN ROUND CYLINDER, WET LOCATION SURFACE CEILING MOUNT, 80 CRI, 3000K, 1000LM, MED WIDE DIST, CLEAR SEMI-SPEC W/EM BATTERY PACK	LED - 3000K	EVO4SC_30_10_AR_WD_LSS_Jes	824	0.91	8.8

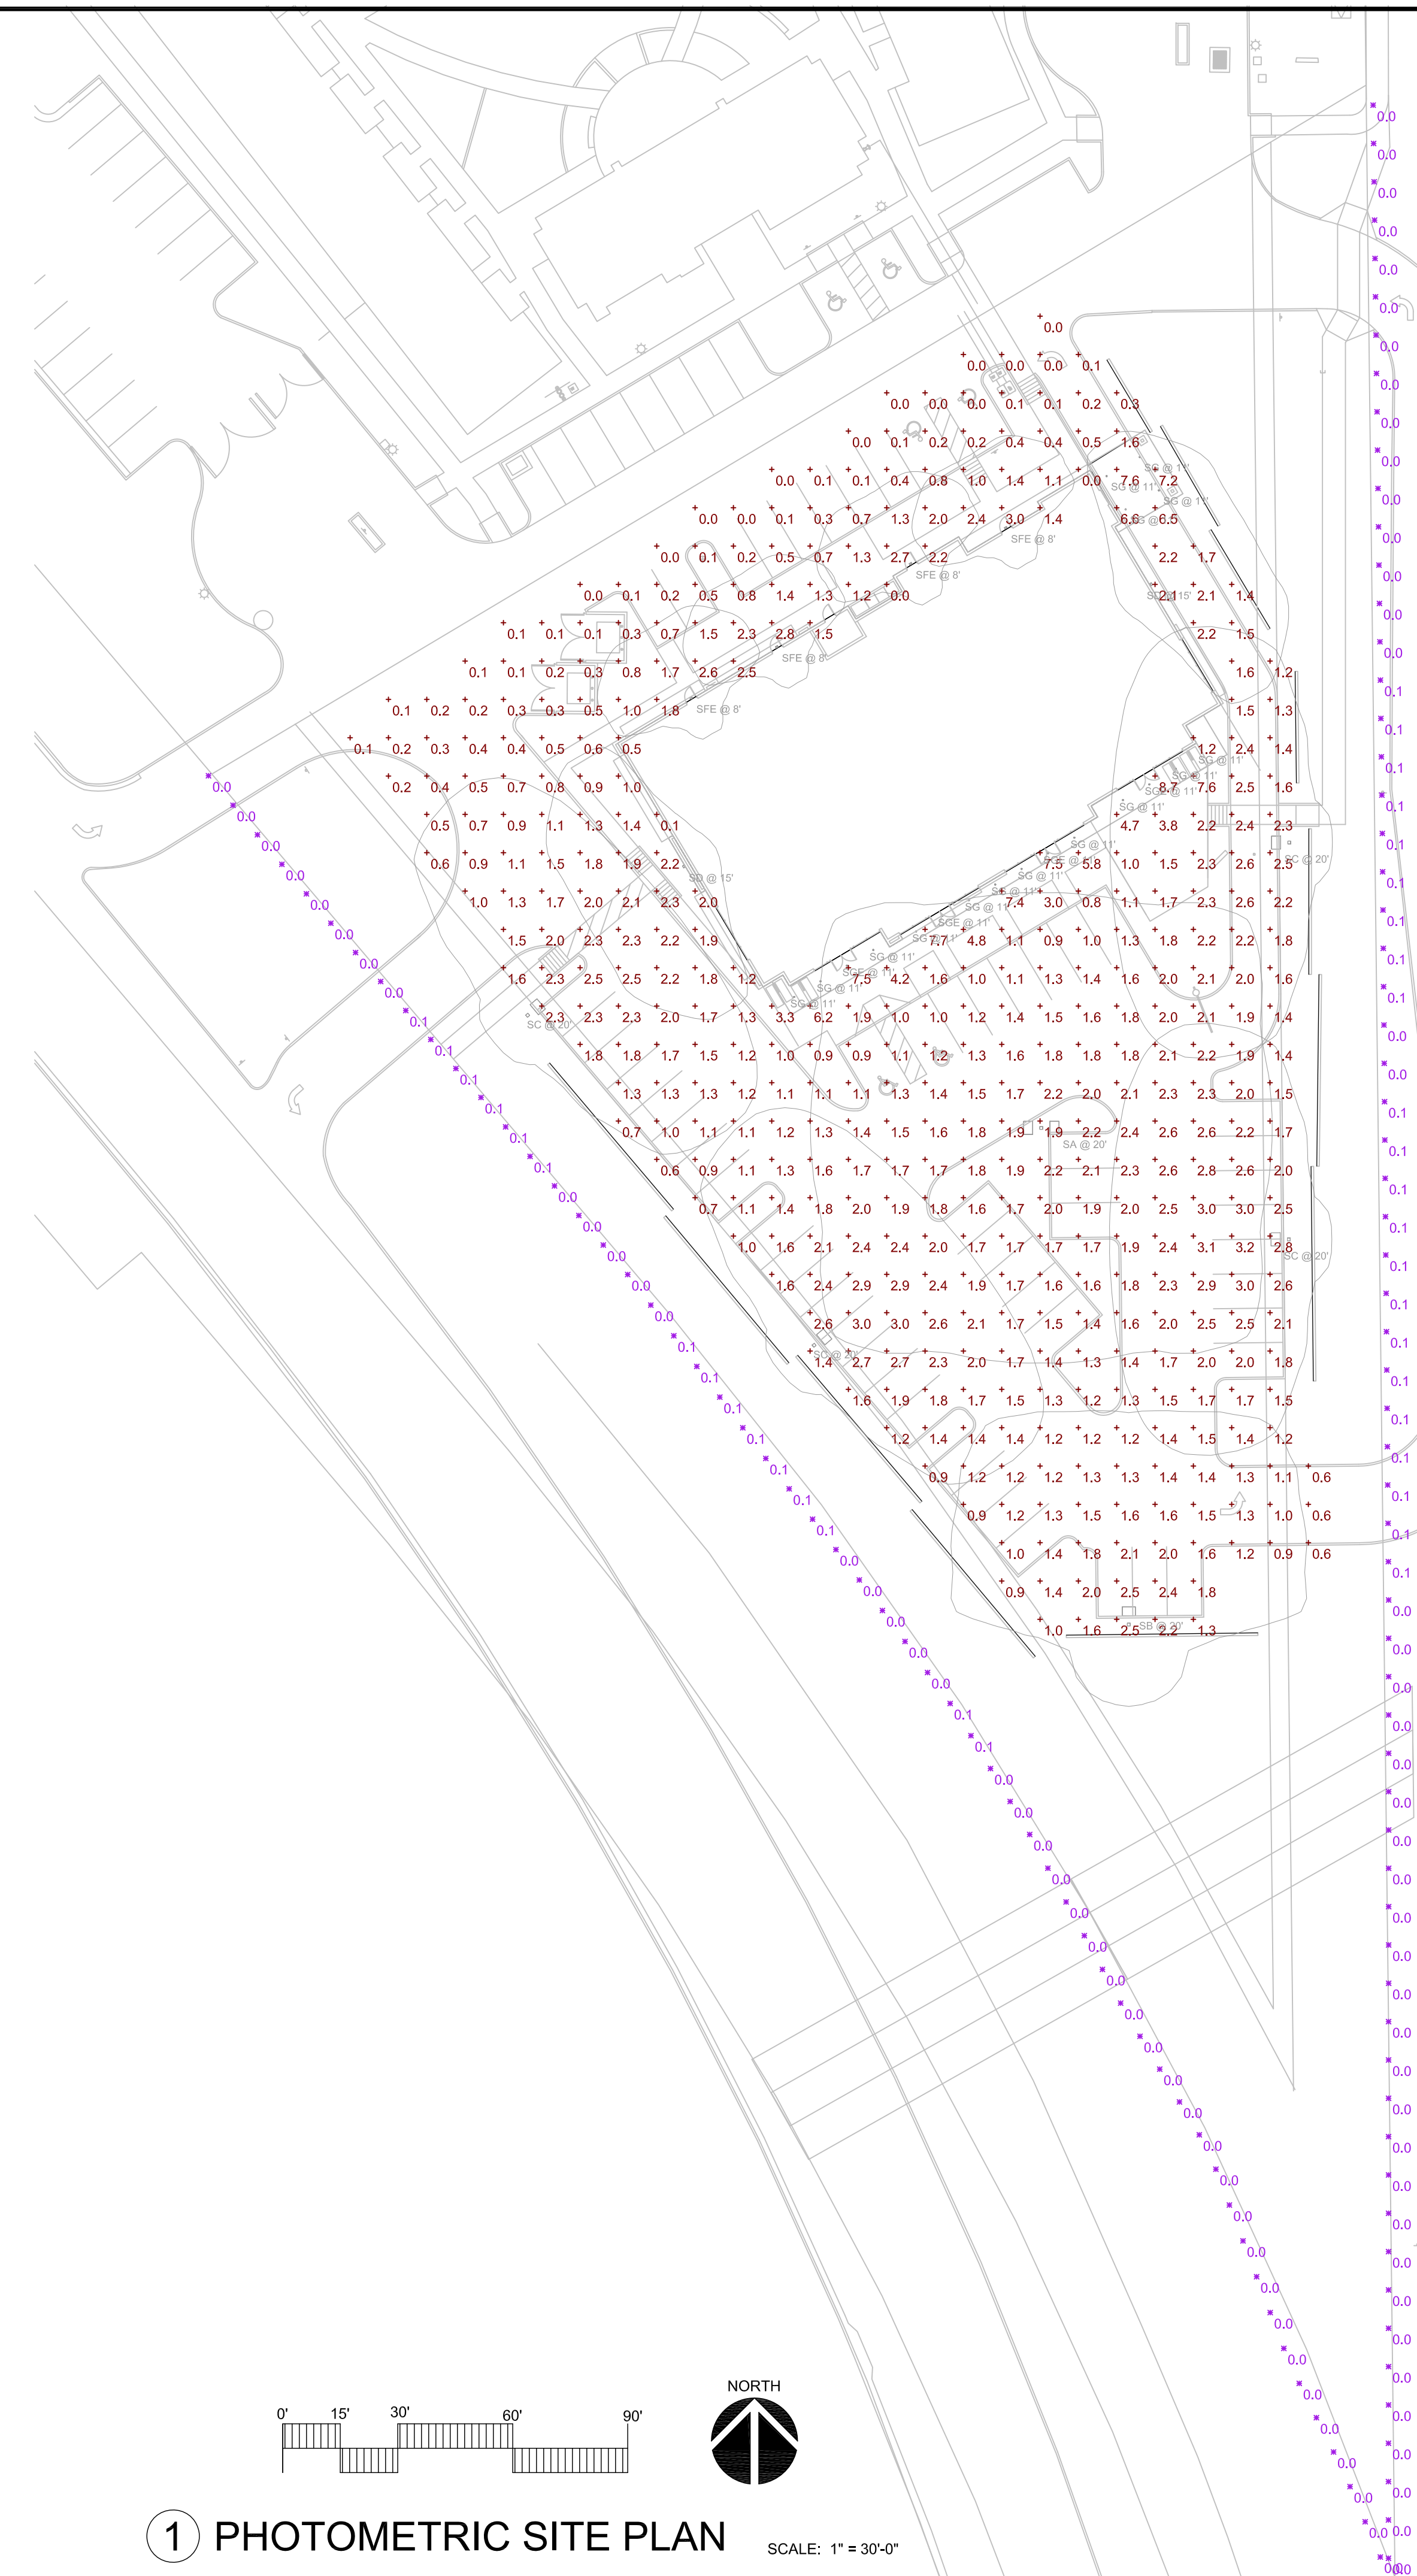

① PHOTOMETRIC SITE PLAN SCALE: 1" = 30'-0"

**CABANA ON POWER ROAD RETAIL CENTER**  
6209 S POWER ROAD  
MESA, ARIZONA

PROJECT NUMBER: 2466810-01  
PROJECT MANAGER:  
DRAWN BY:  
CHECKED BY:

NO	REVISION	DATE

SHEET DESCRIPTION  
SITE PHOTOMETRICS



SHEET NO.

**PH-1**

ISSUE DATE: 5 APR 2024

