
 


DATE: 6/27/2023, 1:57:22 PM BY: Alexander_Olivero\AOLivero 1:2023\20230309 Sky Arizona PHOTOMETRIC PLAN.dwg

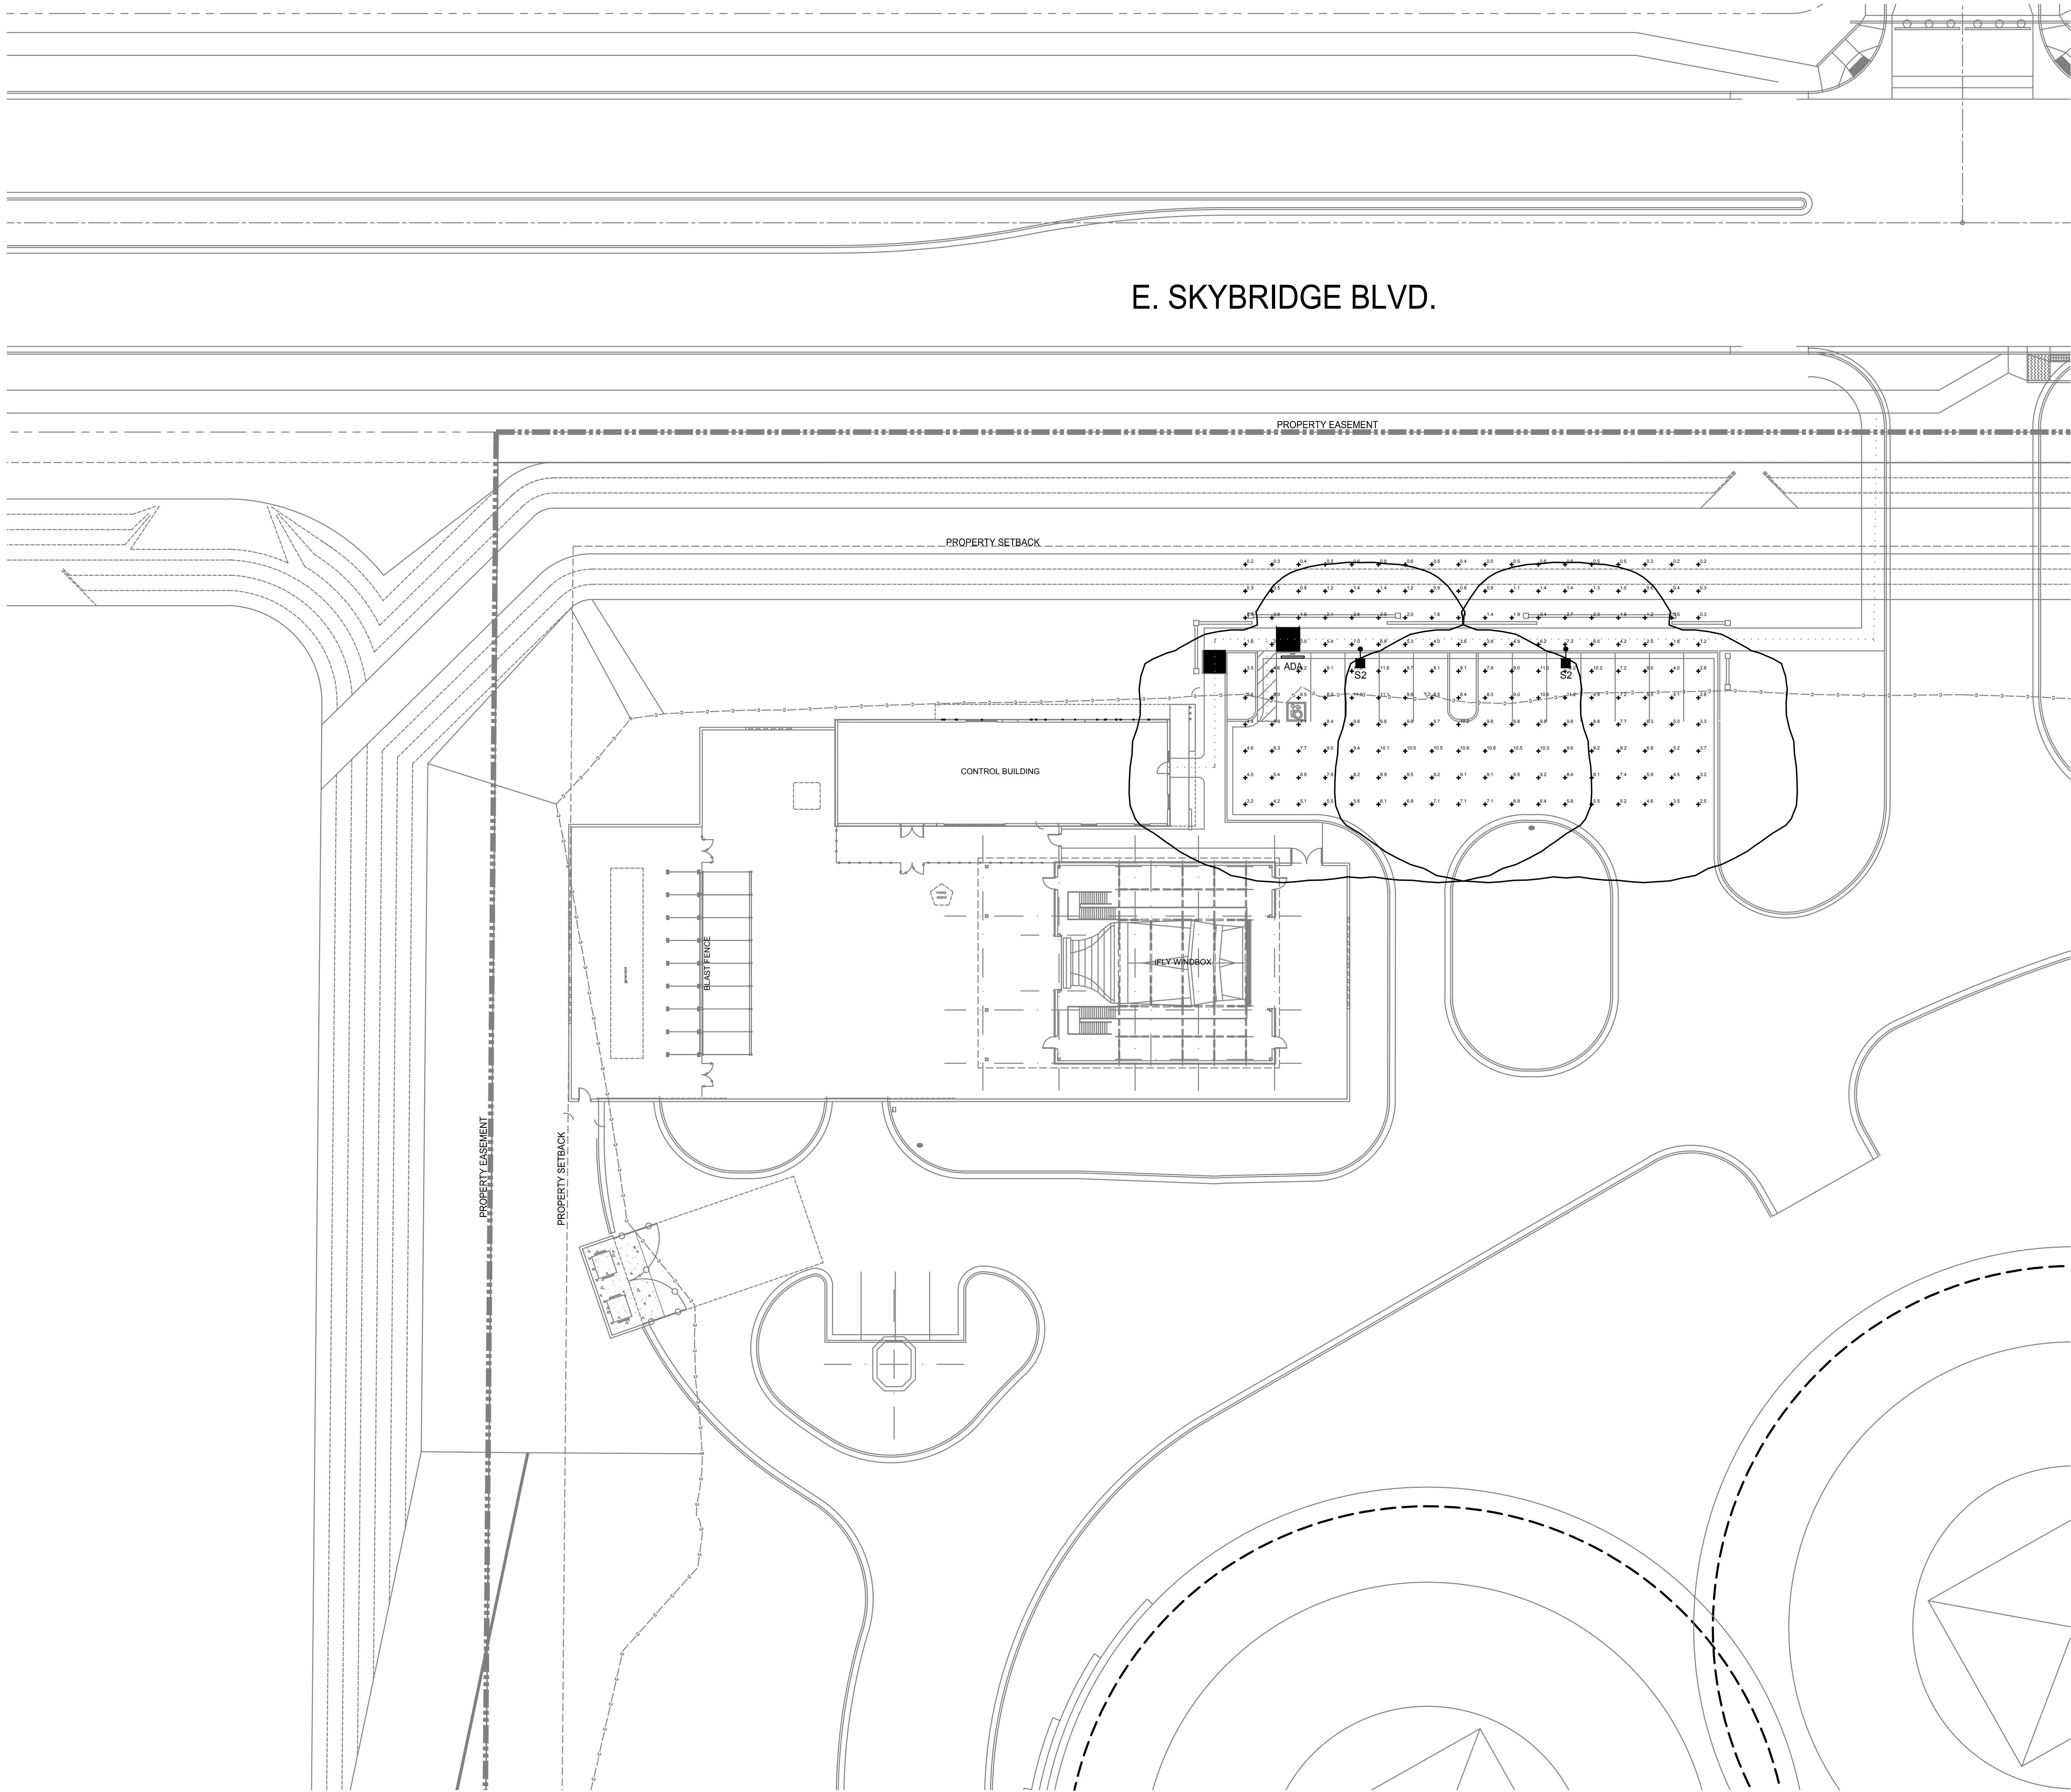

SITE PHOTOMETRIC PLAN



Schedule									
Symbol	Label	Image	QTY	Manufacturer	Catalog	Description	Number	Lamp	Input
	S2		2	Lithonia Lighting	DSX2 LED P6 40K TFFM MVOLT HS	DSX2 LED P6 40K TFFM MVOLT with house side shield	Lamps	31845	0.9
									343

Statistics					
Description	Symbol	Avg	Max	Min	Avg/Min
PARKING		9.3 fc	12.2 fc	0.2 fc	61.0:1
					28.5:1



PEARSON
ENGINEERING
ASSOCIATES
INC.
8625 N. 23RD AVENUE
PHOENIX, ARIZONA 85021
PHONE: (602) 264-0807
FAX: (602) 274-7542
WEB SITE: www.pearsong.com
DESIGNER: RGN
PROJECT NO: 2023039

REVISION	DATE	DESCRIPTION

Project Number 7032-118a	Date 05/01/2023	Drawn By ADO	Checked By JMP
-----------------------------	--------------------	-----------------	-------------------

SITE PLAN
E0.3

SKYBRIDGE ARIZONA AT
PHOENIX-MESA GATEWAY
AIRPORT
7801 E. SKYBRIDGE BLVD.
MESA, ARIZONA 85212
CROSS FLOW TEST FACILITY



adm
group
architecture.
design.
management.

2100 WEST 15TH STREET | TEMPE, AZ 85281 | 480.285.3900

