



This drawing is the property of the Architect and is not to be reproduced, stored in a retrieval system, or used in any way without the written permission of the Architect. The Contractor shall check and verify all dimensions prior to construction, do not scale this drawing. This drawing shall not be used for construction unless properly signed and sealed by the Architect.

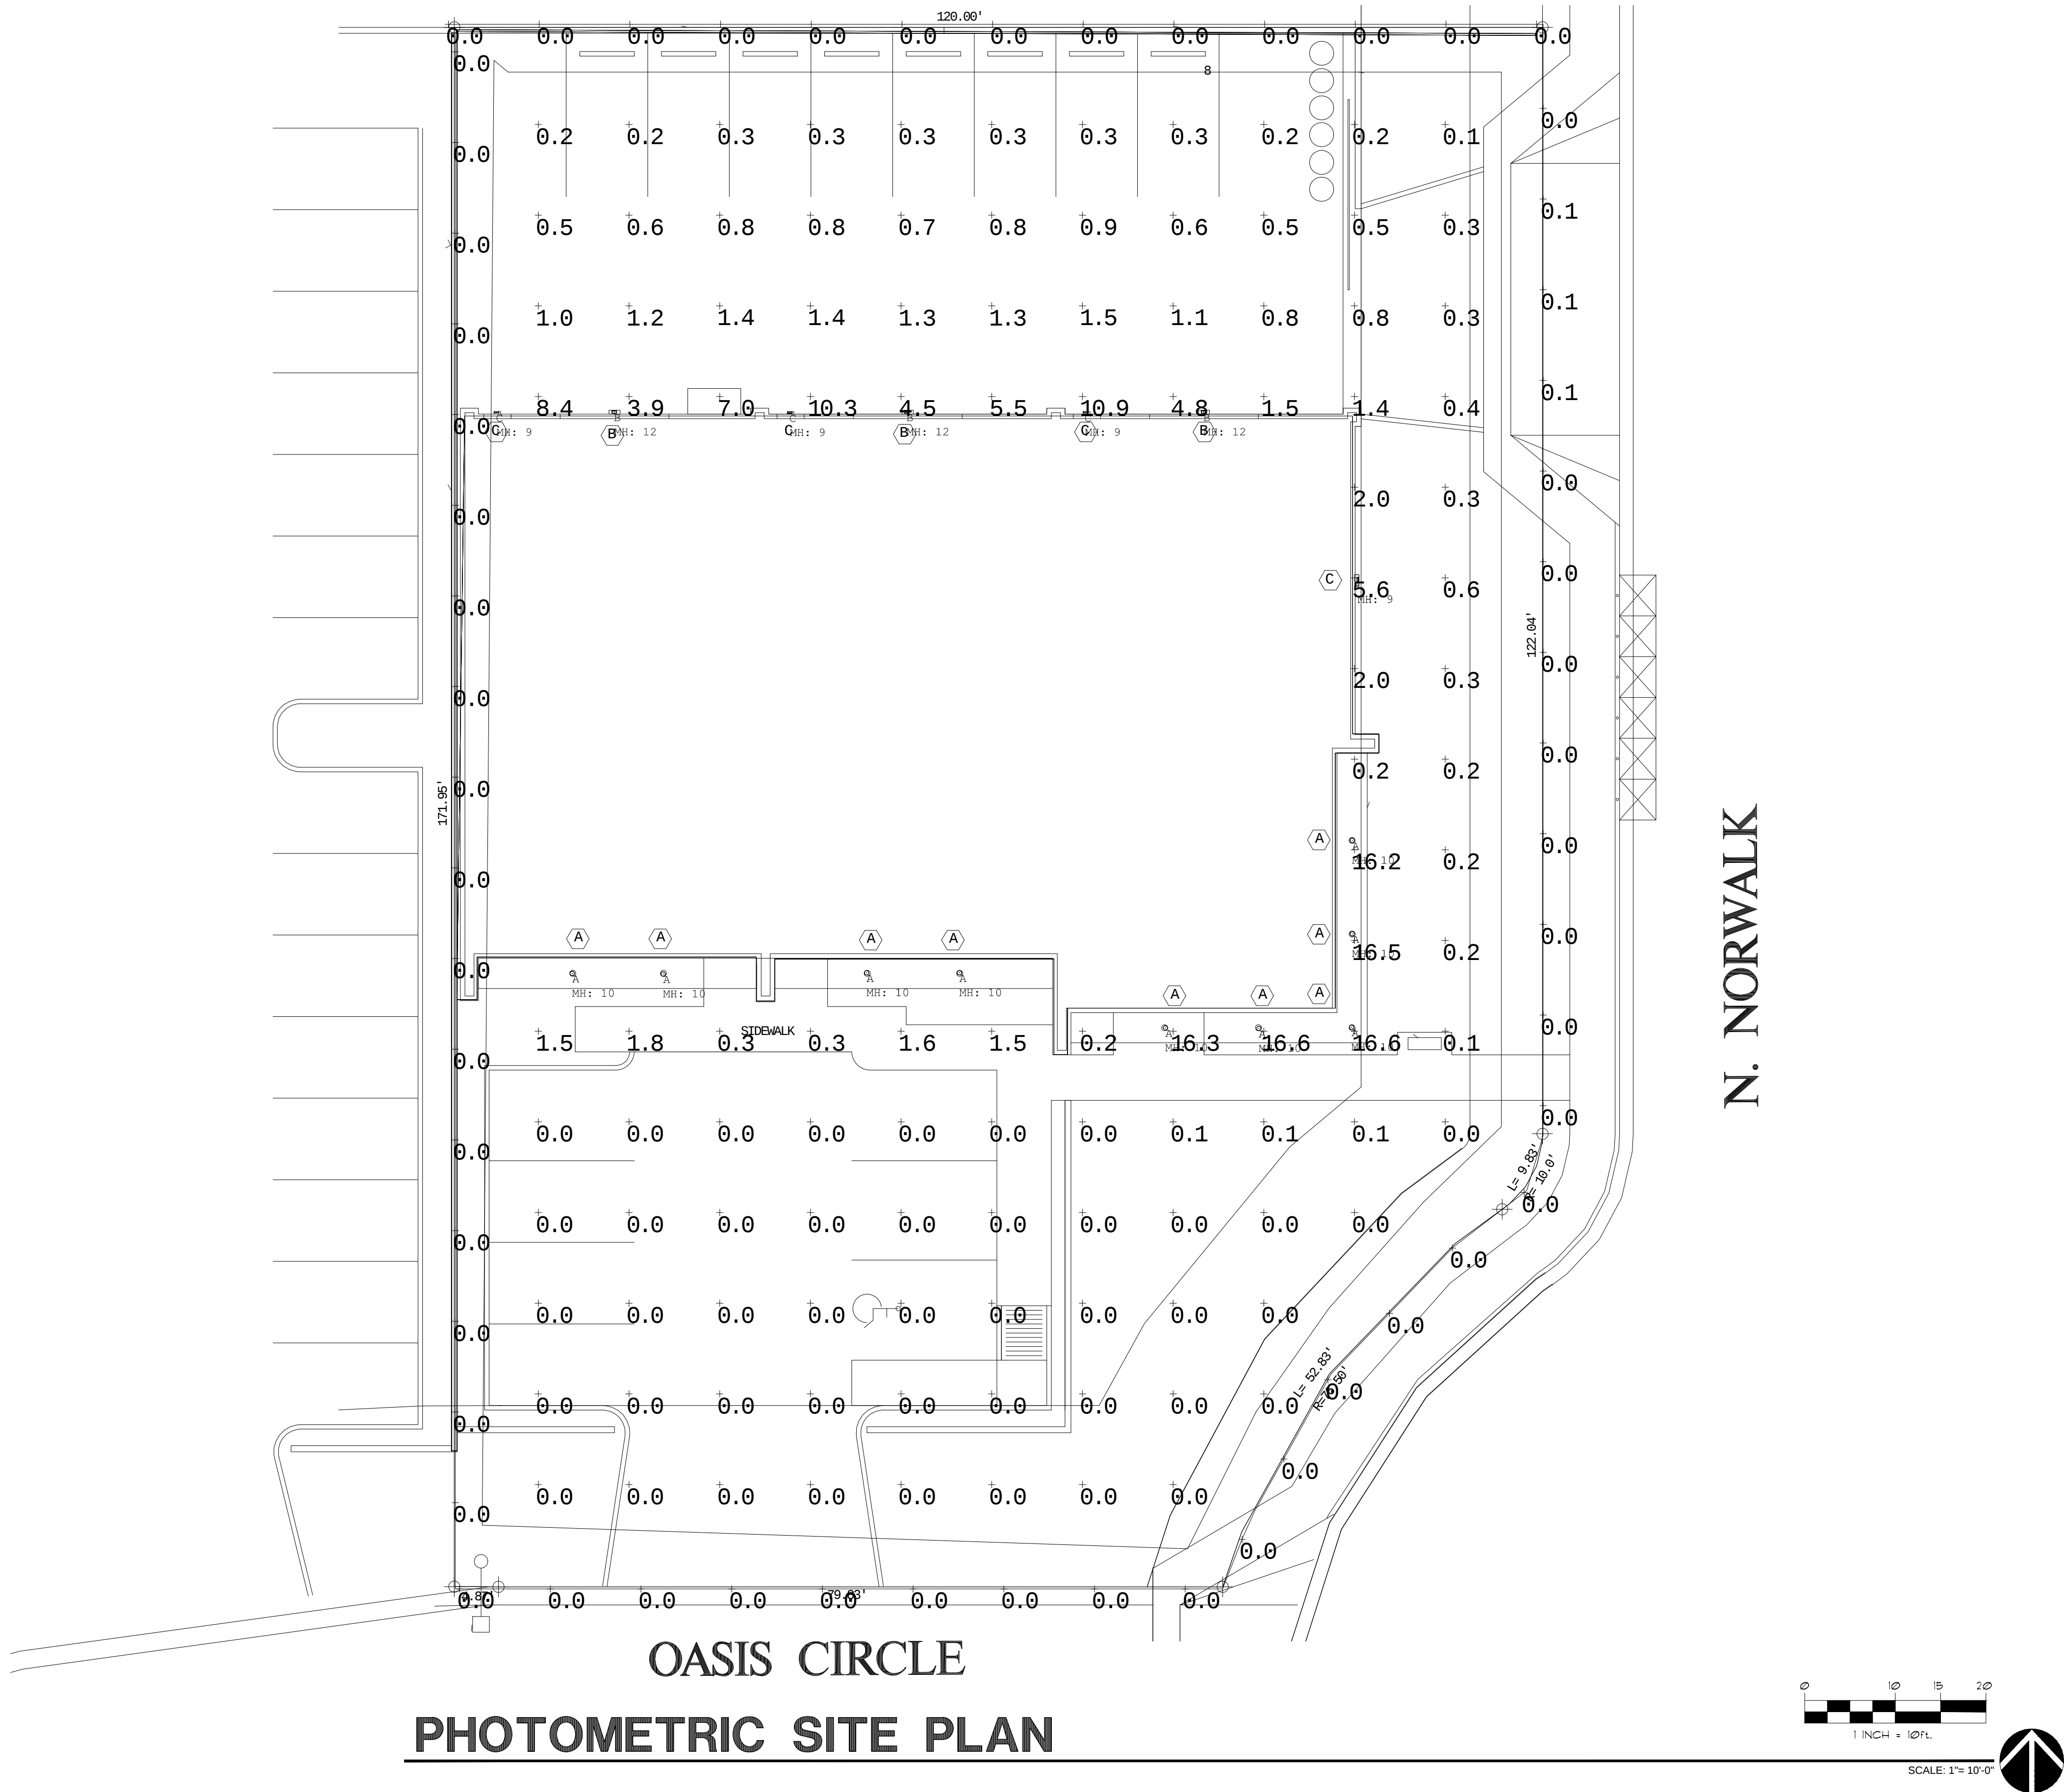

Luminaire Schedule										
Qty	Label	Symbol	Manufacturer	Description	MH	LLF	Lumens	Watts	Total Watts	BUG Rating
9	A	⊙	PRESCOLITE	LFR-6RDS-M-15L35K8WD-DM1_LFR-6RDS-T-S	10'	0.900	1488	12.273	110.457	B2-U0-G0
3	B	□	HUBBELL OUTDOOR	RWL1-48L-10-4K7-4W-U	12'	0.900	1336	10.1	30.3	B0-U0-G1
4	C	□	DUAL-LITE	CUSO-AC	9'	0.900	1581	16.4	65.6	B1-U0-G0


Calculation Summary							
Label	CalcType	Units	Avg	Max	Min	Avg/Min	Max/Min
Property Line	Illuminance	Fc	0.01	0.1	0.0	N.A.	N.A.
Site	Illuminance	Fc	1.59	16.6	0.0	N.A.	N.A.

HITCHENS ASSOCIATES
ARCHITECTS

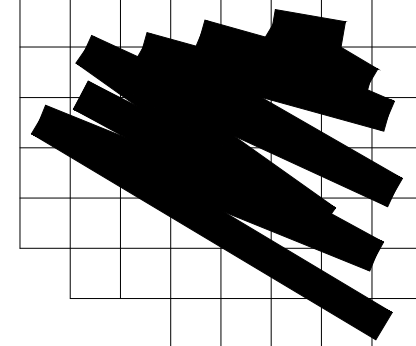

3126 N. LOS ALAMOS
MESA, ARIZONA 85213

TELEPHONE:
602-615-0204

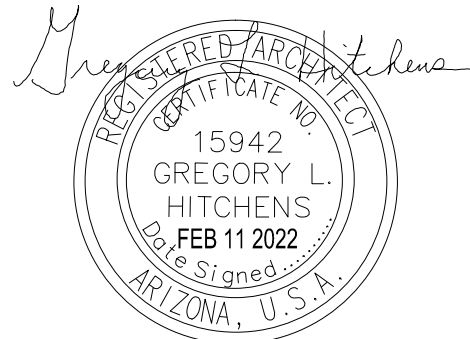

REVISIONS

2 7-18-22 city revisions

PROPOSED
OFFICE WAREHOUSE
BUILDING

3962 E. OASIS CIRCLE
MESA, ARIZONA
85215

PROJECT NO: 22201
DRAWN BY: GLH
DATE: 4-22-2022

PHOTOMETRIC
SITE PLAN
PH1