



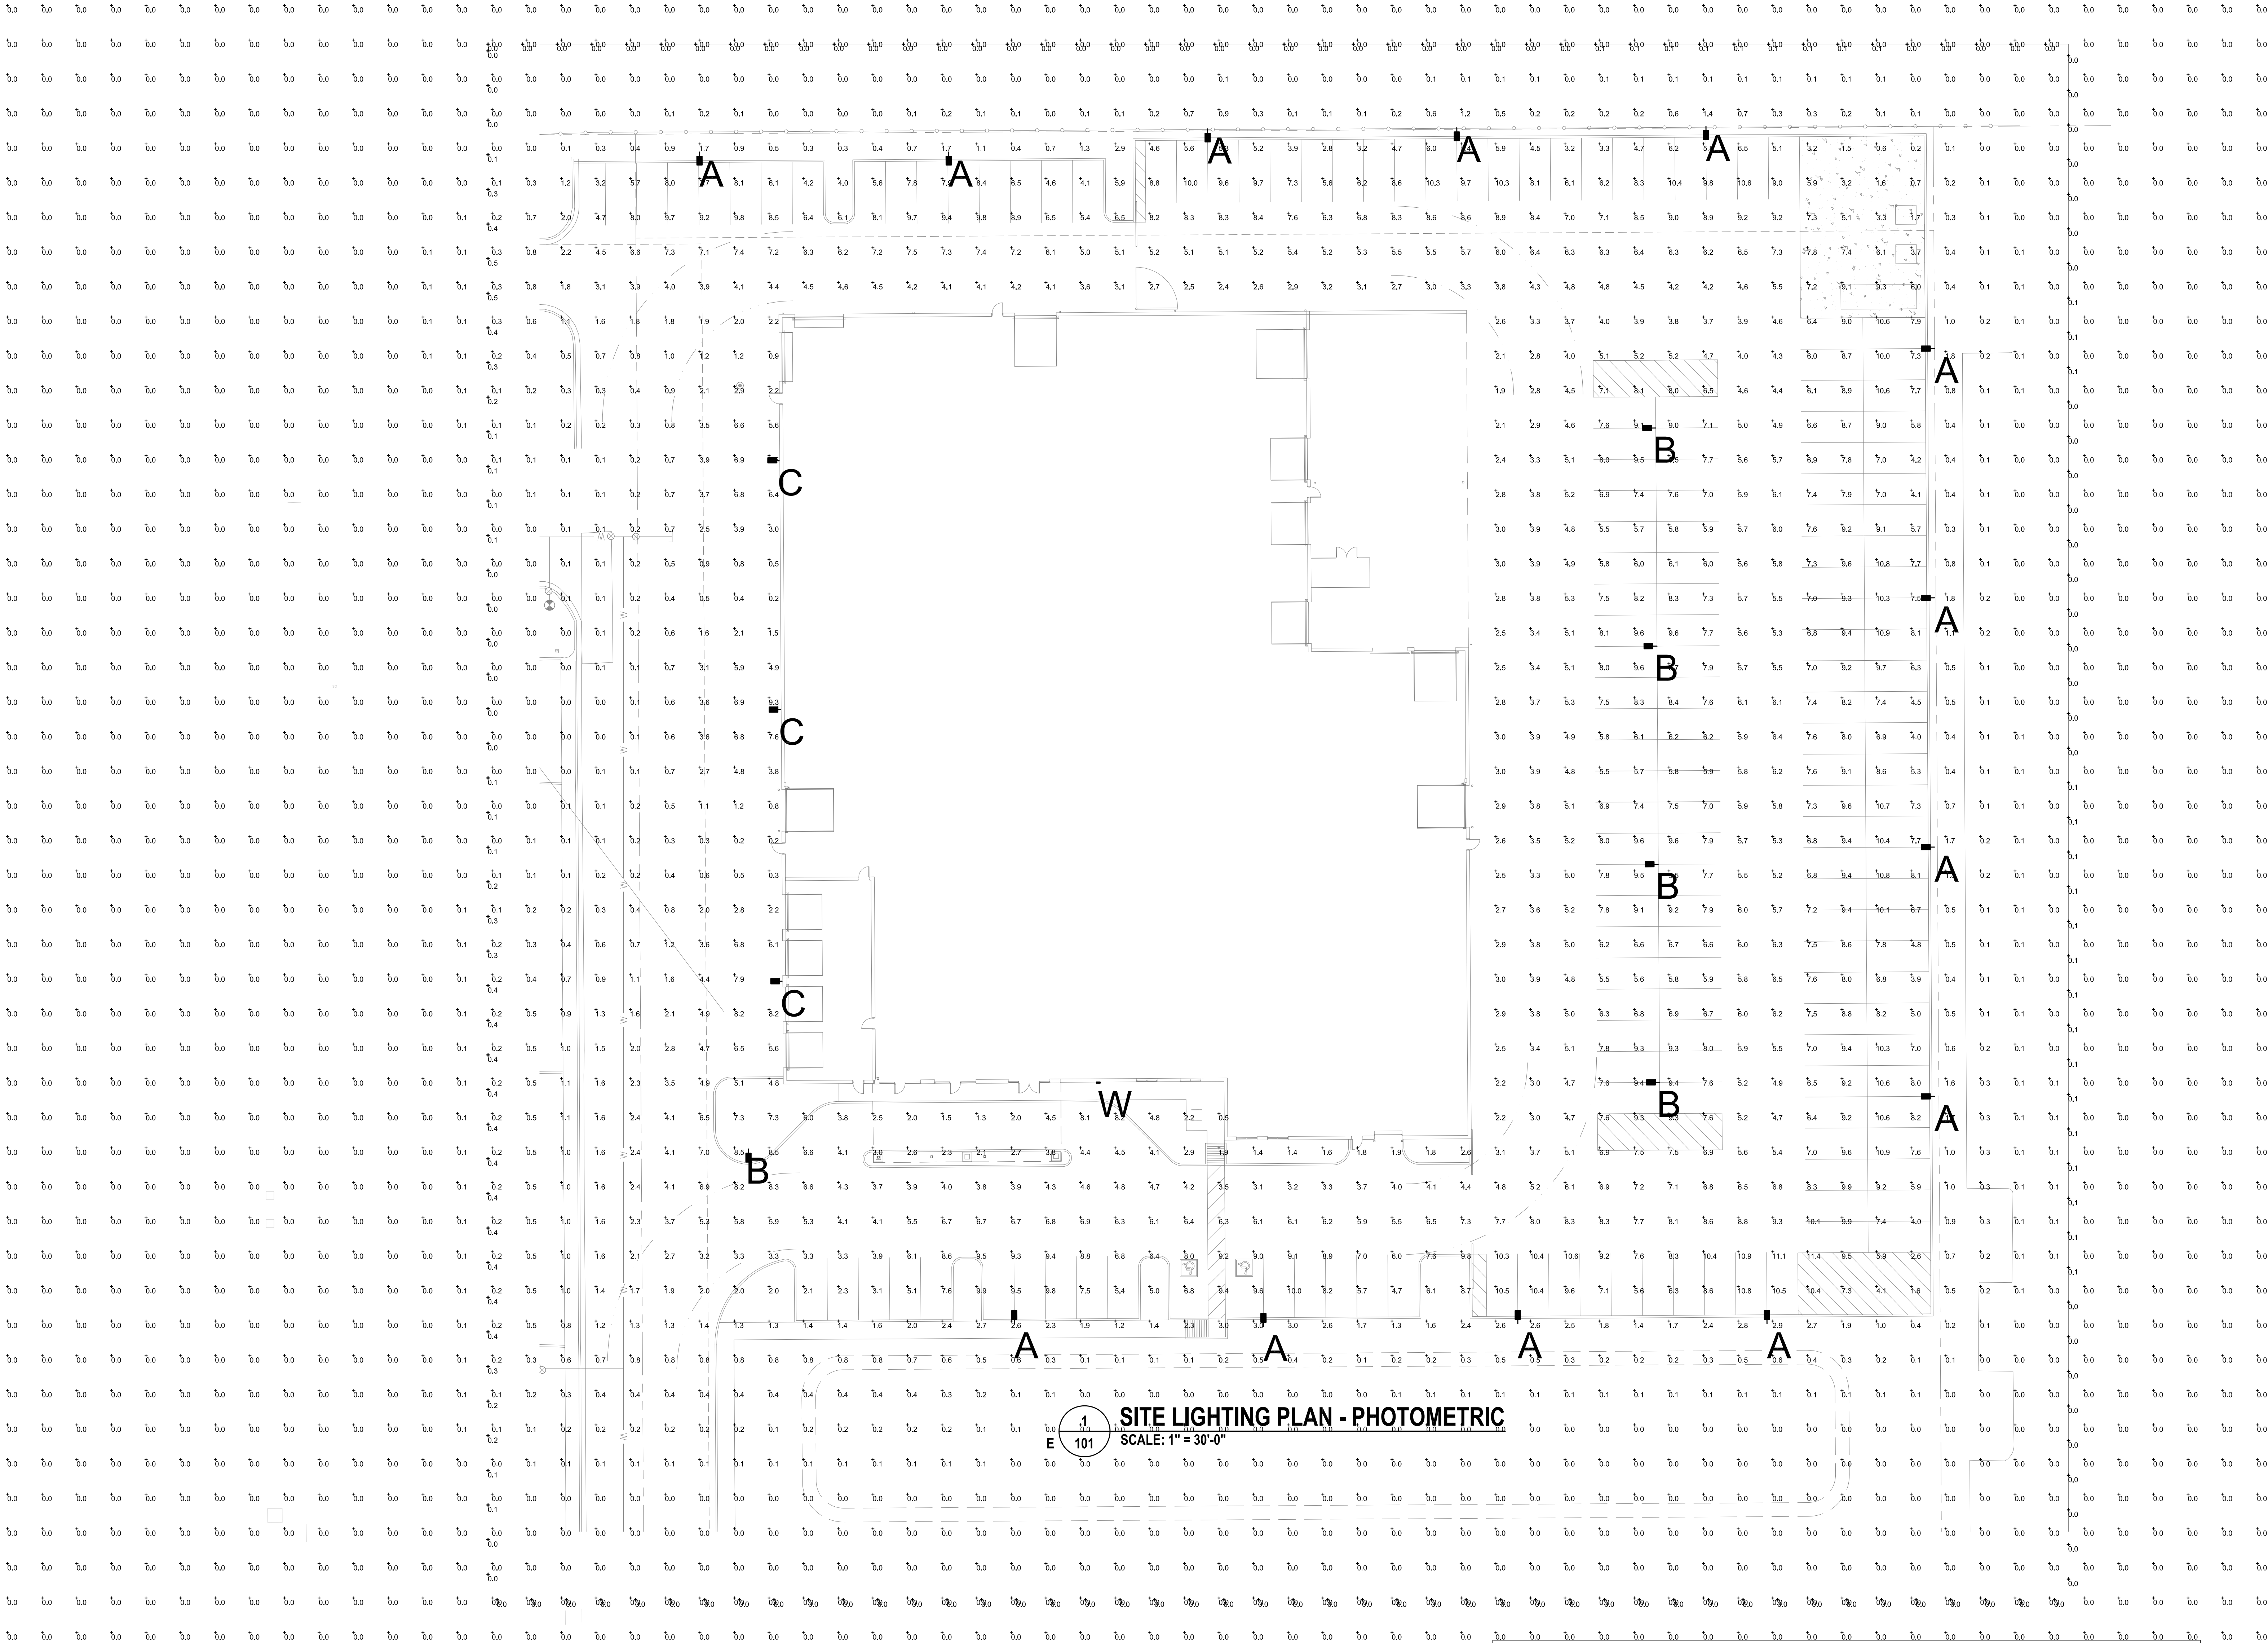

Calculation Summary							
Label	CalcType	Units	Avg	Max	Min	Avg/Min	Max/Min
CALC POINTS @ 4' ABOVE GRADE	Illuminance	Fc	1.58	11.4	0.0	N.A.	N.A.
PROPERTY LINE @ GRADE	Illuminance	Fc	0.07	0.5	0.0	N.A.	N.A.
GENERAL PARKING	Illuminance	Fc	7.21	11.4	2.3	3.13	4.96
REAR OF LOT	Illuminance	Fc	2.37	9.5	0.0	N.A.	N.A.

Luminaire Schedule							
Symbol	Qty	Label	Arrangement	Description	Mounting Height	LLD	LUF
■	13	A	Single	MRM-LED-36L-SIL-FT-50-70CRI-L-SINGLE	16'	1,000	1,000
■	5	B	Single	MRM-LED-36L-SIL-SW-50-70CRI-L-SINGLE	16'	1,000	1,000
■	3	C	Single	MRS-LED-48L-SIL-FT-50-70CRI	16'	1,000	1,000
■	1	W	Single	XWM-FT-LED-48L-50	16'	1,000	1,000
						Arr. Lum. Lumens	Arr. Watts
						22428	254
						36934	254
						9308	63
						8465	64

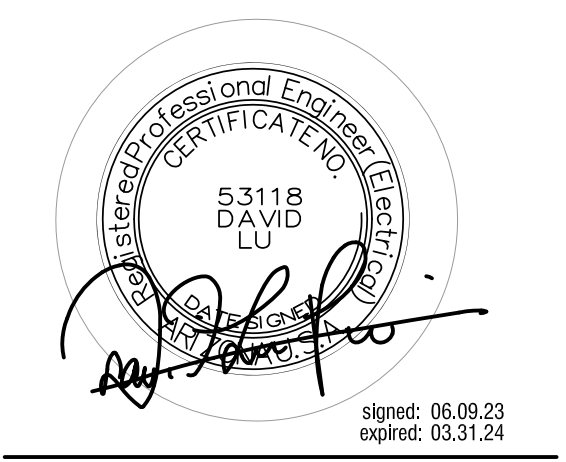

Copyright © 2023 Praxis3, LLC
All reports, plans, specifications, computer files, field notes, notes and other documents and instruments prepared by Praxis3 shall remain the confidential, proprietary and other reserved rights, including copyright therein.
This drawing may not be reproduced in whole or in part without written permission of Praxis3. It is to be returned upon request. Scale as stated on title and on the original drawings.

Rev	Date	Comments
-	06.12.23	Site Lighting
-	-	-

Client:
Asbury Automotive Group

2905 Premiere Pkwy, Suite 300
Duluth, GA 30097

Project Number:
Project Name:

LHM Ford Mesa Collision Center

Mesa, AZ 85206
Key Plan:

Sheet Title:
Site Lighting Photometric

Sheet Number:
E101