
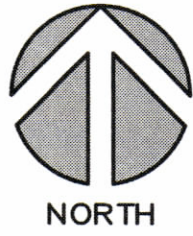


This document, including the ideas and designs it contains, is an instrument of professional services rendered by the RMA Design Group, LLC. This document may not be used or copied in whole, or in part, for any purpose other than this specific project without the expressed written consent of RMA Architects, LLC.

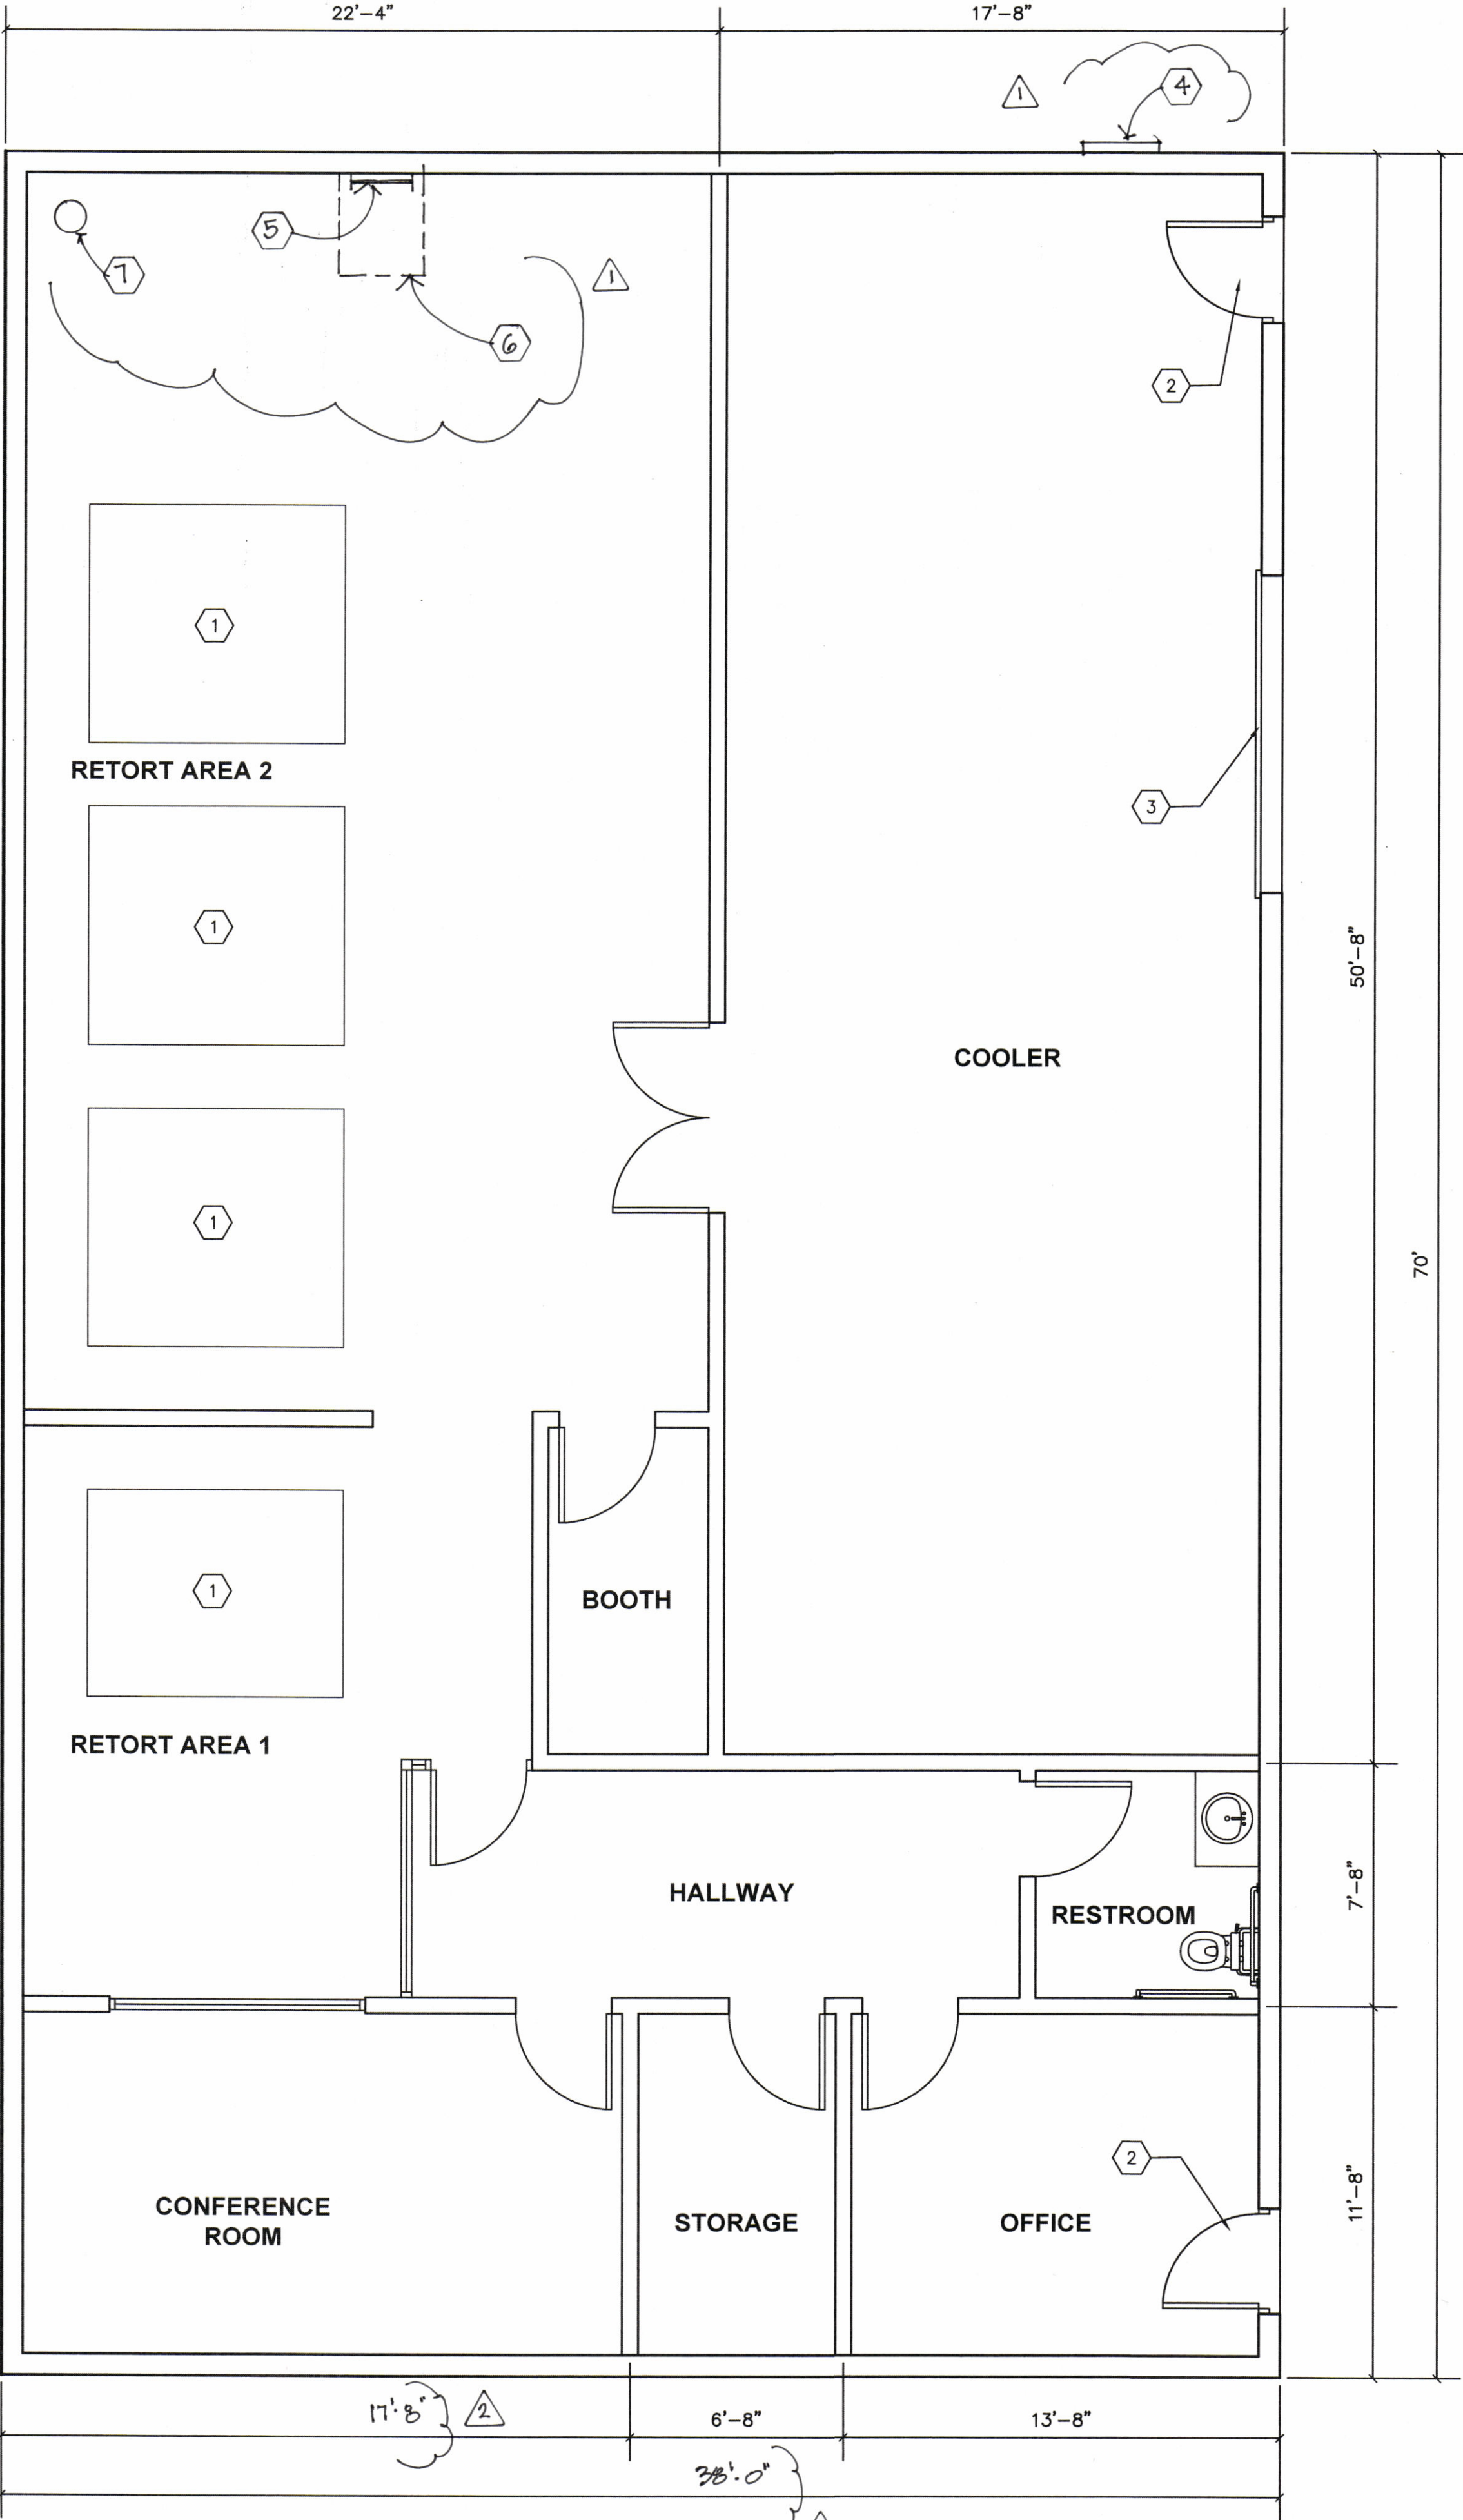

## PROPOSED FLOOR PLAN

SCALE: 1/4"=1'-0"

### KEYNOTES

1. RETORT MACHINE
2. 3'-1" MAN DOOR
3. 10'x12' O.H. DOOR
4. SERVICE ENTRANCE SECTION
5. ROOF ACCESS LADDER
6. ROOF HATCH ABOVE
7. FIRE SPRINKLER RISER

NOTE: ALL DOWNSPOUTS TO BE LOCATED INTERNALLY

SEAL

229 Sawtooth Mountain Wy  
Dripping Springs, Texas  
78620  
(T) 623-252-8340

www.rmadesigngroup.com

A NEW ADDITION FOR:  
**SUNFLOWER CREMATION AND BURIAL**  
5650 E. MAIN ST.  
MESA, AZ

PROPOSED FLOOR PLAN

NUMBER	REVISION / MILESTONE DESCRIPTION	DATE
1	CITY CORRECTION	5/1/23
2	DESIGN CORRECTION TO MAROLA SITE PLAN	5/1/23

PROJECT NUMBER	DRAWN BY	CHECKED BY	SCALE	AS SHOWN
	BP	RM		

PROJECT NUMBER  
SHEET NUMBER

DR-2