



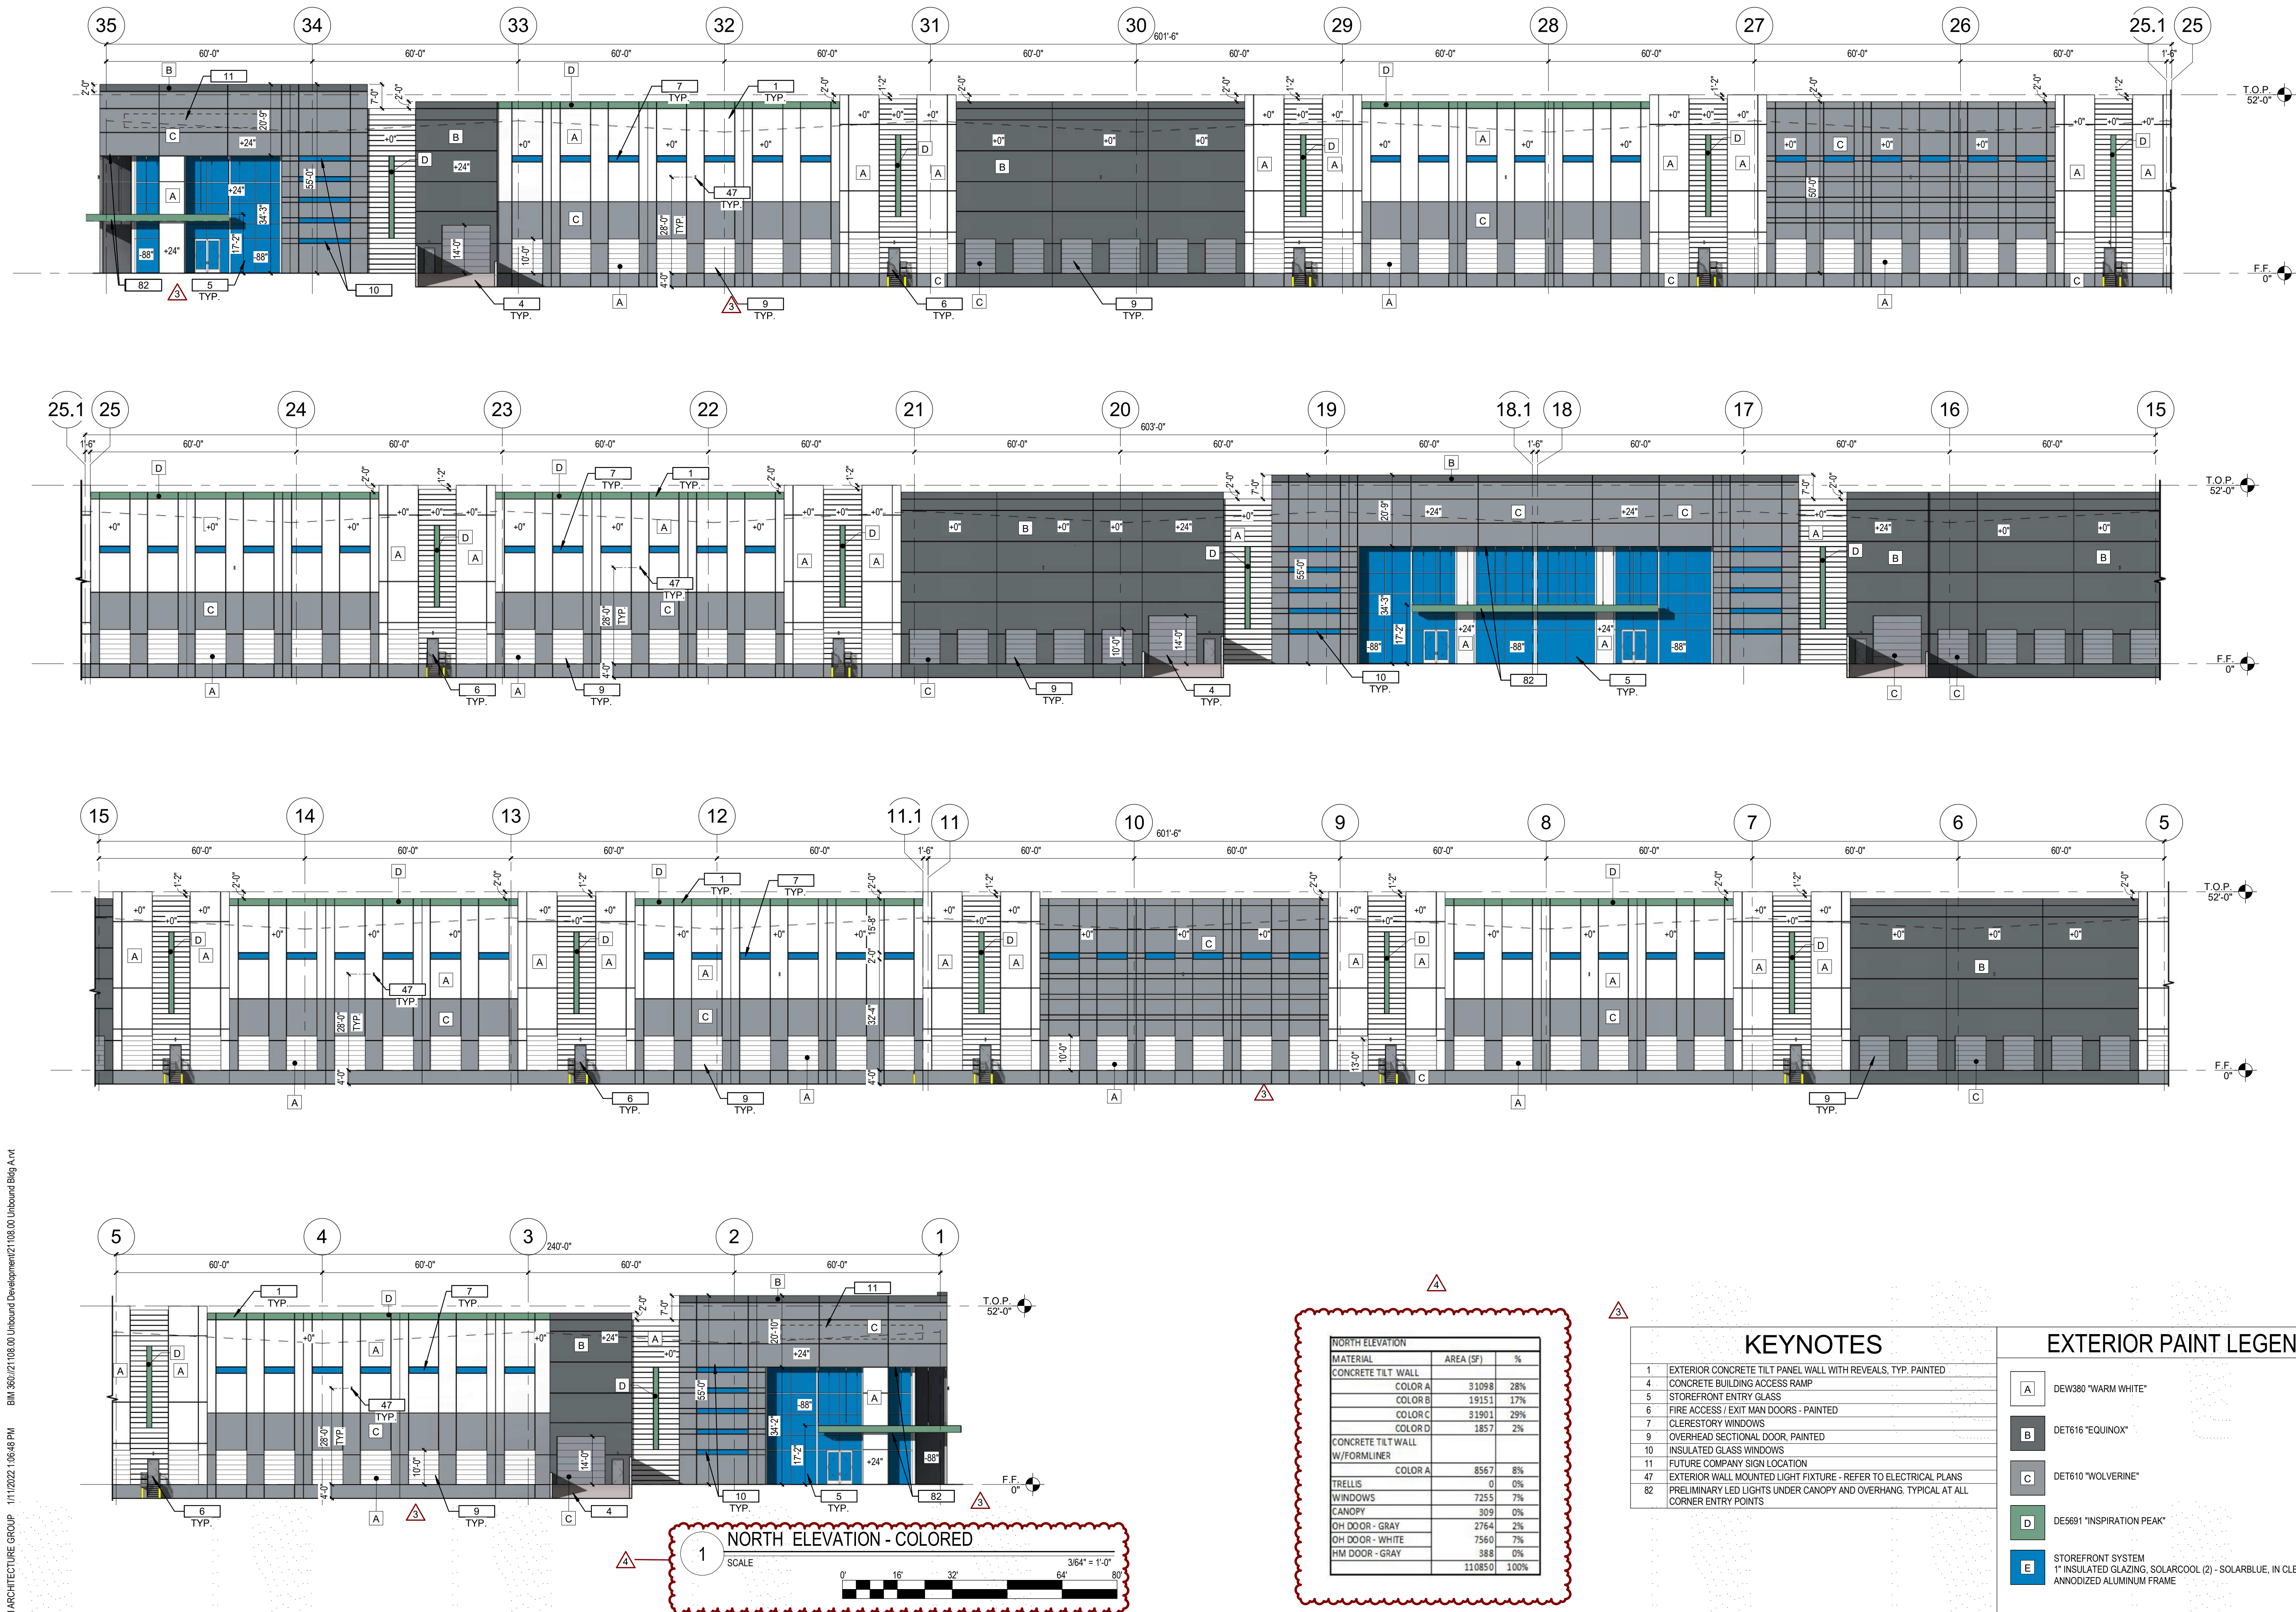

CONCEPTUAL AND SCHEMATIC DESIGNS, INCLUDING RENDERINGS, ARE CREATED FOR THE SOLE PURPOSE OF DEVELOPING A DESIGN CONCEPT. THEY ARE PART OF THE OVERALL DESIGN PROCESS THAT ULTIMATELY LEADS TO MORE DETAILED DRAWINGS, BUT THE INFORMATION DEPICTED IN THESE DESIGNS IS INCOMPLETE AND NOT INTENDED TO REPRESENT THE FULL SCOPE OF THE PROJECT DESIGN. THE USE OF THESE CONCEPTUAL AND SCHEMATIC DESIGNS/RENDERINGS FOR ANY PURPOSE OTHER THAN AS INTENDED BY THE ARCHITECT IS PROHIBITED.

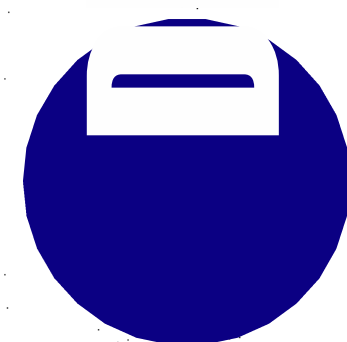

4600
EAST INDIAN SCHOOL RD
PHOENIX, ARIZONA 85018
602-840-2929 P

UNBOUND GATEWAY

BLDG A

SOSSAMAN AND PECOS

NOTICE: ALL INFORMATION IS THE PROPERTY OF THE OWNER TO WHOM IT IS LOANED. NO PART OF THIS DOCUMENT IS TO BE REPRODUCED OR TRANSMITTED IN ANY FORM OR BY ANY MEANS, ELECTRONIC OR MECHANICAL, WITHOUT THE WRITTEN PERMISSION OF THE OWNER. CERTIFY AND APPROVE BILLINGS AND ESTIMATES WITHIN 30 DAYS AFTER THE BILLINGS AND ESTIMATES ARE RECEIVED FROM THE CONTRACTOR.




FIRST ISSUED: 06/28/21

REVISIONS		
No.	DATE	DESCRIPTION
1	8-9-21	1ST DRB COMMENTS
2	8-28-21	2ND DRB COMMENTS
3	12-2-21	3RD DRB COMMENTS
4	01-10-22	P&Z COMMENTS

PROJECT NO: 21108.0
DRAWN BY: DTC
CHECKED BY: DCAL
COPYRIGHT 2021: DEUTSCH ARCHITECTURE GROUP

EXTERIOR ELEVATIONS - COLORED BLDG A

A-210C

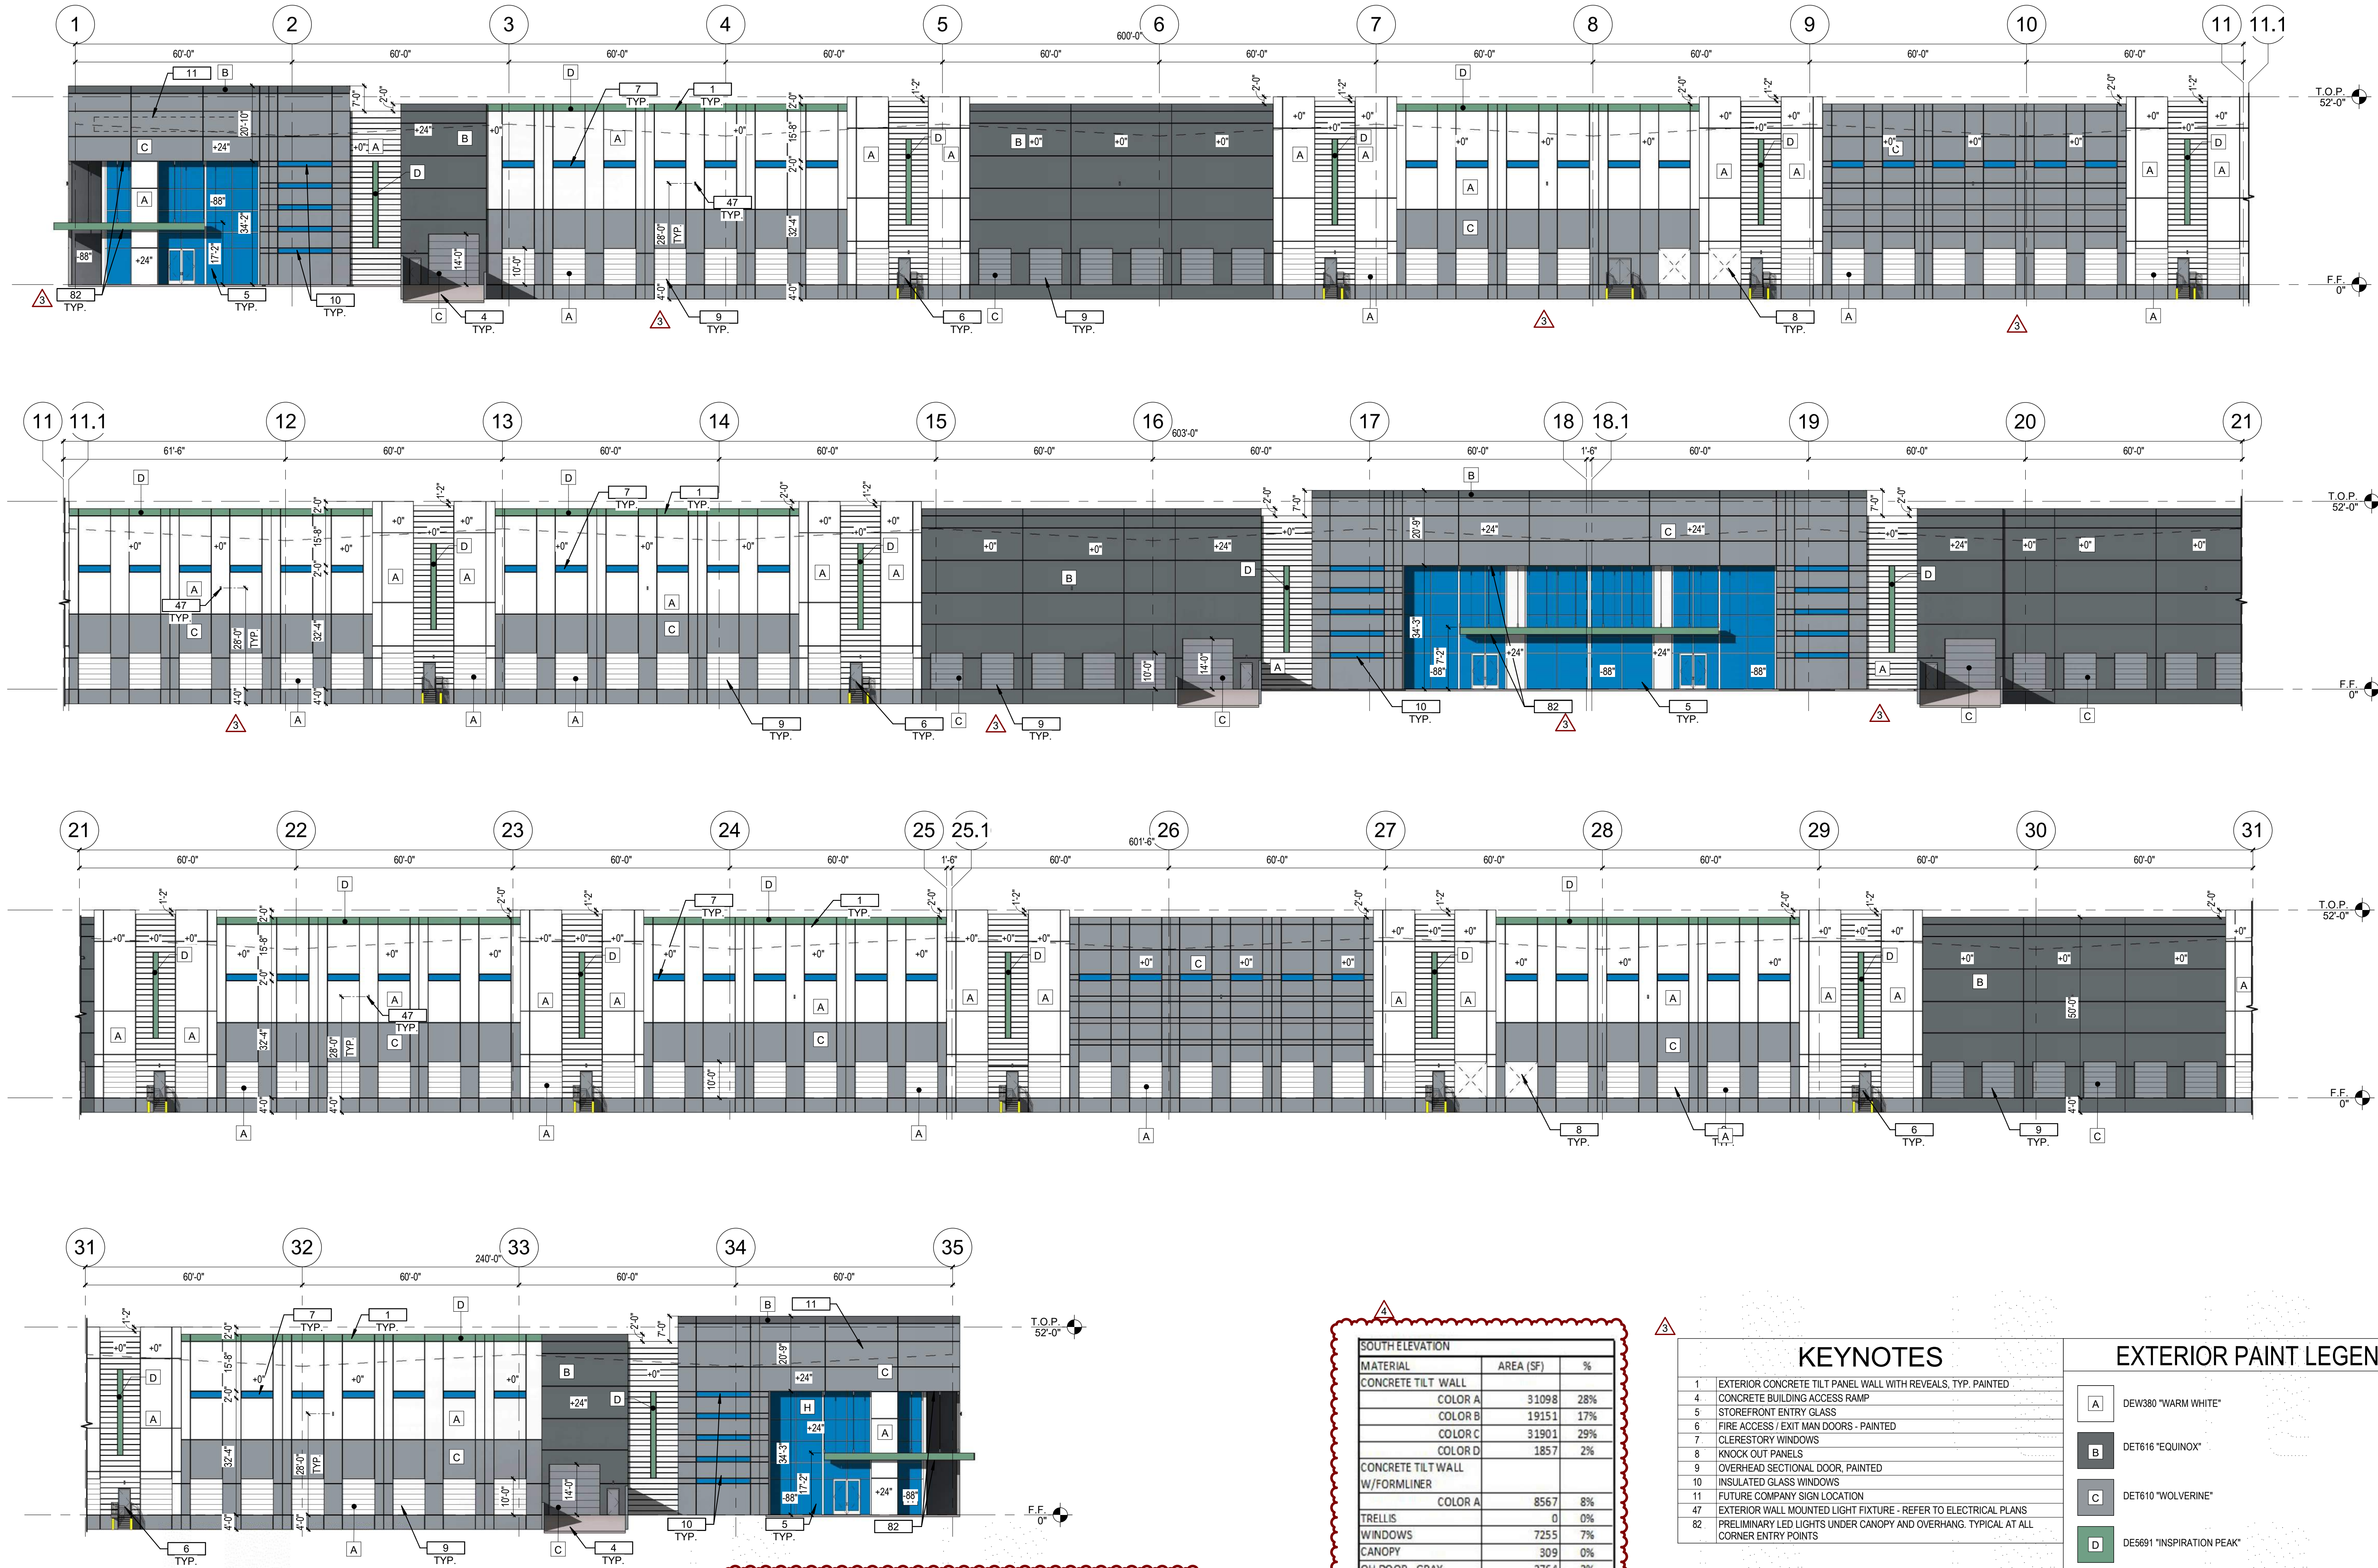

1 SOUTH ELEVATION - COLORED



SOUTH ELEVATION		
MATERIAL	AREA (SF)	%
CONCRETE TILT WALL		
COLOR A	31098	28%
COLOR B	19151	17%
COLOR C	31901	29%
COLOR D	1857	2%
CONCRETE TILT WALL W/FORMLINER		
COLOR A	8567	8%
TRELLIS	0	0%
WINDOWS	7255	7%
CANOPY	309	0%
OH DOOR - GRAY	2764	2%
OH DOOR - WHITE	7560	7%
HM DOOR - GRAY	388	0%
	110850	100%


KEYNOTES

- EXTERIOR CONCRETE TILT PANEL WALL WITH REVEALS, TYP. PAINTED
- CONCRETE BUILDING ACCESS RAMP
- STOREFRONT ENTRY GLASS
- FIRE ACCESS / EXIT MAN DOORS - PAINTED
- CLERESTORY WINDOWS
- KNOCK OUT PANELS
- OVERHEAD SECTIONAL DOOR, PAINTED
- INSULATED GLASS WINDOWS
- FUTURE COMPANY SIGN LOCATION
- EXTERIOR WALL MOUNTED LIGHT FIXTURE - REFER TO ELECTRICAL PLANS
- PRELIMINARY LED LIGHTS UNDER CANOPY AND OVERHANG, TYPICAL AT ALL CORNER ENTRY POINTS

EXTERIOR PAINT LEGEND

- | | |
|---|---|
| A | DEW380 "WARM WHITE" |
| B | DET616 "EQUINOX" |
| C | DET610 "WOLVERINE" |
| D | DE5691 "INSPIRATION PEAK" |
| E | STOREFRONT SYSTEM
1" INSULATED GLAZING, SOLARCOOL (2) - SOLARBLUE, IN CLEAR ANNOZIZED ALUMINUM FRAME |

CONCEPTUAL AND SCHEMATIC DESIGNS, INCLUDING RENDERINGS, ARE CREATED FOR THE SOLE PURPOSE OF DEVELOPING A DESIGN CONCEPT. THEY ARE PART OF THE OVERALL DESIGN PROCESS THAT ULTIMATELY LEADS TO MORE DETAILED DRAWINGS, BUT THE INFORMATION DEPICTED IN THESE DESIGNS IS INCOMPLETE AND NOT INTENDED TO REPRESENT THE FULL SCOPE OF THE PROJECT DESIGN. THE USE OF THESE CONCEPTUAL AND SCHEMATIC DESIGNS/RENDERINGS FOR ANY PURPOSE OTHER THAN AS INTENDED BY THE ARCHITECT IS PROHIBITED.

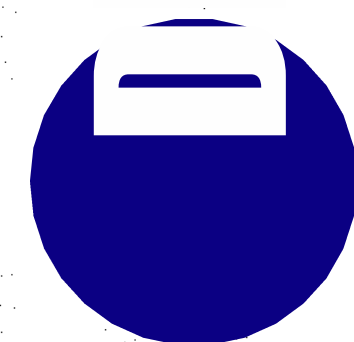

4600
EAST INDIAN SCHOOL RD
PHOENIX, ARIZONA 85018
602-840-2929 P

UNBOUND GATEWAY

BLDG A

SOSSAMAN AND PECOS

NOTICE OF EXISTING CERTIFICATION AND APPROVAL PERIOD: THIS CONTRACT ALLOWS THE OWNER TO CERTIFY AND APPROVE THE DESIGN AND CONSTRUCTION OF THE PROJECT FROM THE CONTRACTOR.

unbound
DEVELOPMENT

FIRST ISSUED: 06/28/21

REVISIONS

No.	DATE	DESCRIPTION
1	8-9-21	1ST DRB COMMENTS
2	8-28-21	2ND DRB COMMENTS
3	12-2-21	3RD DRB COMMENTS
4	01-10-22	P&Z COMMENTS

PROJECT NO: 21108.0


DRAWN BY: DTC

CHECKED BY: DCAL

COPYRIGHT 2021: DEUTSCH ARCHITECTURE GROUP

EXTERIOR
ELEVATIONS -
COLORED BLDG A

A-211C

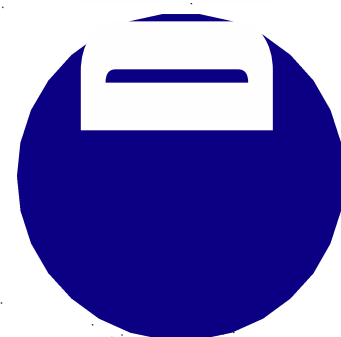

4600
EAST INDIAN SCHOOL RD
PHOENIX, ARIZONA 85018
602-840-2929 P

UNBOUND GATEWAY

BLDG A
SOSSAMAN AND PECOS

NOTICE OF RECORD, CERTIFICATION AND APPROVAL PERIOD: THIS CONTRACT ALLOWS THE OWNER TO CERTIFY AND APPROVE THE DESIGN AND CONSTRUCTION OF THE PROJECT FROM THE CONTRACTOR.



FIRST ISSUED: 06/28/21

REVISIONS

No.	DATE	DESCRIPTION
3	12-2-21	3RD DRB COMMENTS
4	01-10-22	P&Z COMMENTS

PROJECT NO: 21108.0


DRAWN BY: DTC

CHECKED BY: DCAL



COPYRIGHT 2021: DEUTSCH ARCHITECTURE GROUP

EXTERIOR ELEVATIONS - COLORED BLDG A


A-212C

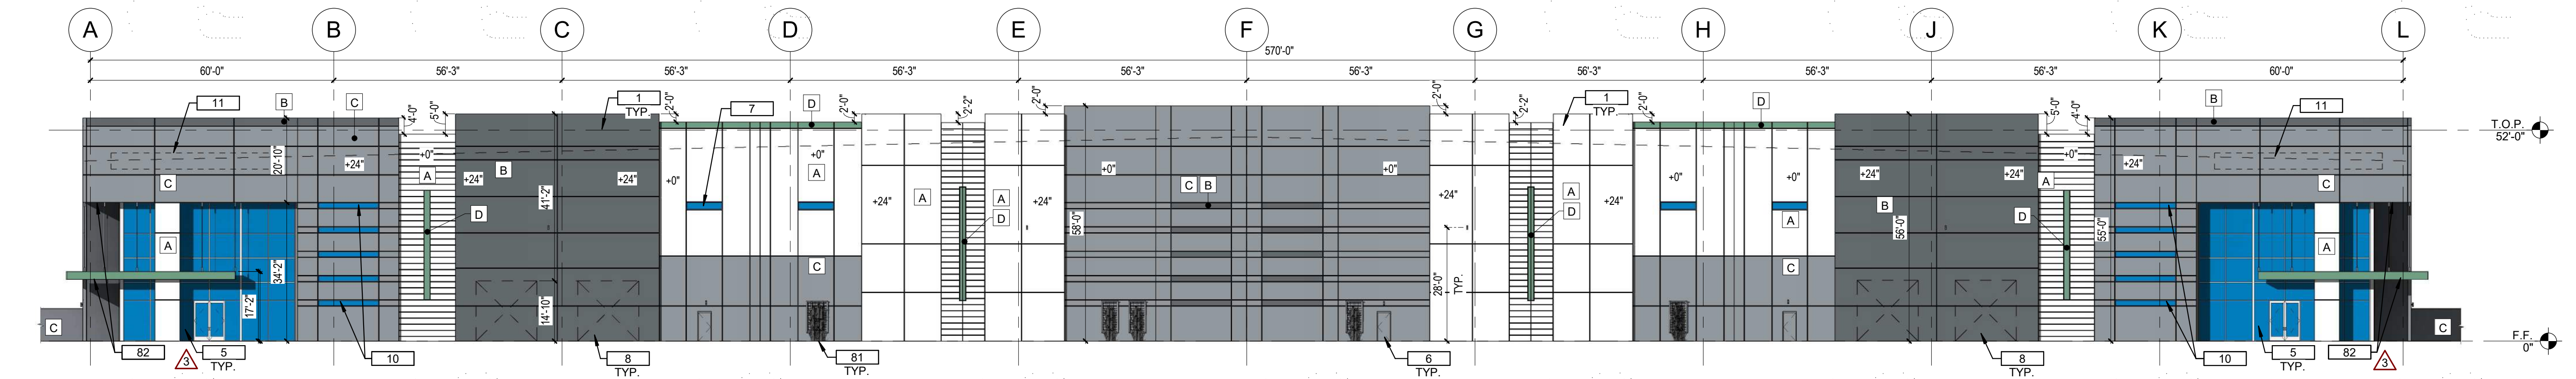

1 WEST ELEVATION - COLORED

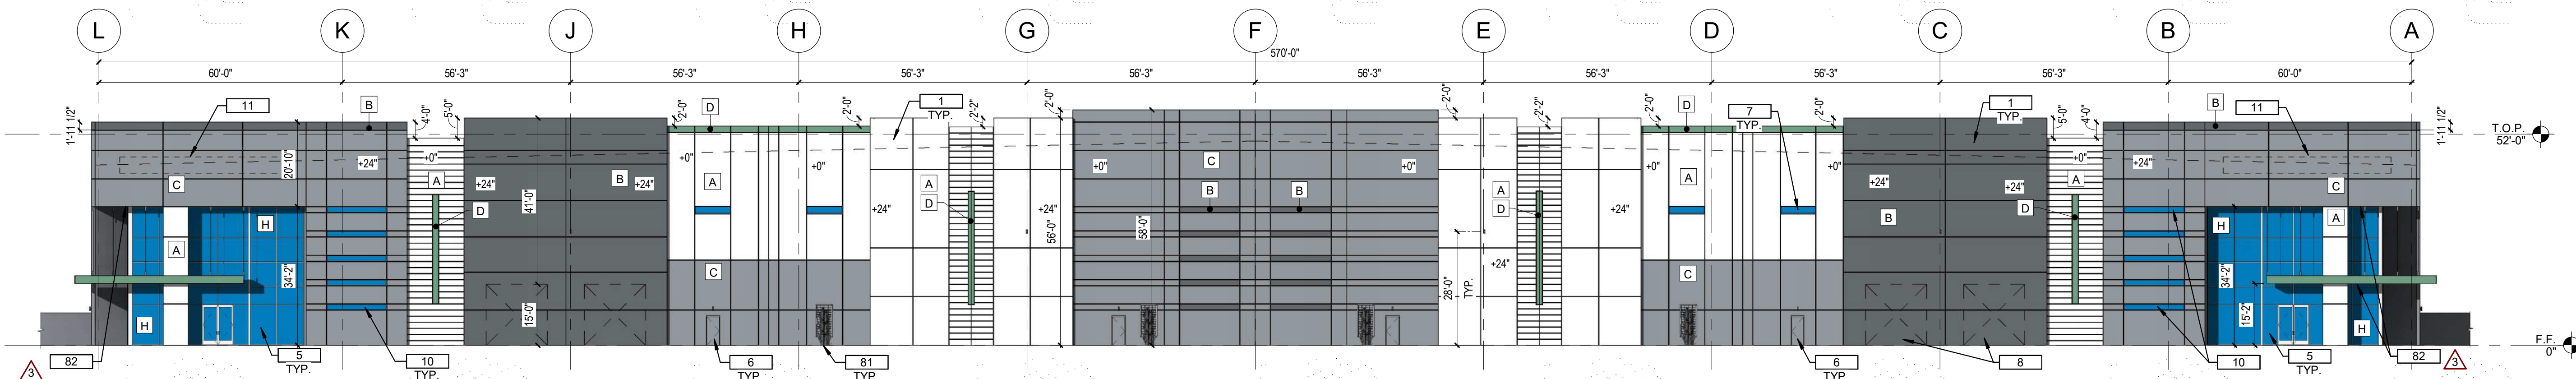 

2 EAST ELEVATION - COLORED

 

WEST ELEVATION		
MATERIAL	AREA (SF)	%
CONCRETE TILT WALL		
COLOR A	7220	26%
COLOR B	2901	10%
COLOR C	10968	39%
COLOR E	196	1%
CONCRETE TILT WALL W/FORMLINER		
COLOR A	2550	9%
TRELLIS	192	1%
WINDOWS	3107	11%
CORNICE	164	1%
CANOPY	598	2%
OH DOOR	0	0%
HM DOOR	84	0%
	27980	100%

EAST ELEVATION		
MATERIAL	AREA (SF)	%
CONCRETE TILT WALL		
COLOR A	7220	26%
COLOR B	2901	10%
COLOR C	10968	39%
COLOR E	196	1%
CONCRETE TILT WALL W/FORMLINER		
COLOR A	2550	9%
TRELLIS	192	1%
WINDOWS	3107	11%
CORNICE	164	1%
CANOPY	598	2%
OH DOOR	0	0%
HM DOOR	84	0%
	27980	100%

KEYNOTES

1	EXTERIOR CONCRETE TILT PANEL WALL WITH REVEALS, TYP. PAINTED
5	STOREFRONT ENTRY GLASS
6	FIRE ACCESS / EXIT MAN DOORS - PAINTED
7	CLERESTORY WINDOWS
8	KNOCK OUT PANELS
10	INSULATED GLASS WINDOWS
11	FUTURE COMPANY SIGN LOCATION
81	STEEL TRELLIS WITH CLIMBING VINES
82	PRELIMINARY LED LIGHTS UNDER CANOPY AND OVERHANG, TYPICAL AT ALL CORNER ENTRY POINTS


EXTERIOR PAINT LEGEND

A	DEW380 "WARM WHITE"
B	DET616 "EQUINOX"
C	DET610 "WOLVERINE"
D	DE5691 "INSPIRATION PEAK"
E	STOREFRONT SYSTEM 1" INSULATED GLAZING, SOLARCOOL (2) - SOLARBLUE, IN CLEAR ANNOIDIZED ALUMINUM FRAME

CONCEPTUAL AND SCHEMATIC DESIGNS, INCLUDING RENDERINGS, ARE CREATED FOR THE SOLE PURPOSE OF DEVELOPING A DESIGN CONCEPT. THEY ARE PART OF THE OVERALL DESIGN PROCESS THAT ULTIMATELY LEADS TO MORE DETAILED DRAWINGS, BUT THE INFORMATION DEPICTED IN THESE DESIGNS IS INCOMPLETE AND NOT INTENDED TO REPRESENT THE FULL SCOPE OF THE PROJECT DESIGN. THE USE OF THESE CONCEPTUAL AND SCHEMATIC DESIGNS/RENDERINGS FOR ANY PURPOSE OTHER THAN AS INTENDED BY THE ARCHITECT IS PROHIBITED.



1 EAST ELEVATION - COLORED
SCALE 3/64" = 1'-0"

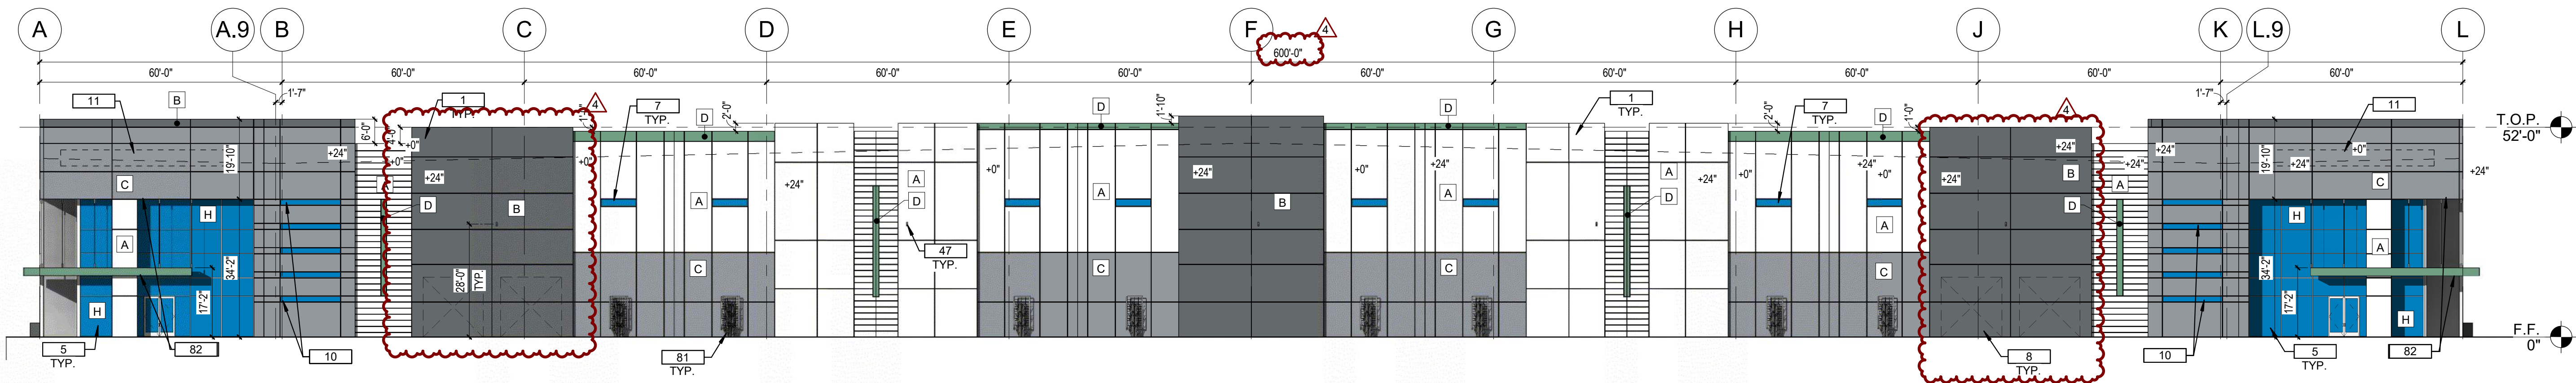


2 NORTH ELEVATION - COLORED
SCALE 3/64" = 1'-0"

EAST ELEVATION			NORTH ELEVATION		
MATERIAL	AREA (SF)	%	MATERIAL	AREA (SF)	%
CONCRETE TILT WALL			CONCRETE TILT WALL		
COLOR A	15994	31%	COLOR A	9914	0.30
COLOR B	11001	21%	COLOR B	7150	0.22
COLOR C	9656	19%	COLOR C	8478	0.26
COLOR D	1020	2%	COLOR D	628	0.02
CONCRETE TILT WALL W/FORMLINER			CONCRETE TILT WALL W/FORMLINER		
COLOR A	4714	9%	COLOR A	2320	0.07
TRELLIS	0	0%	TRELLIS	384	0.01
WINDOWS	3707	7%	WINDOWS	3272	0.10
CORNICE	1060	2%	CANOPY	160	0.00
CANOPY	160	0%	CORNICE	796	0.02
OH DOOR	4588	9%	OH DOOR	0	0.00
HM DOOR	210	0%	HM DOOR	84	0.00
	52110	100%		33186	1.00

KEYNOTES	
1	EXTERIOR CONCRETE TILT PANEL WALL WITH REVEALS, TYP. PAINTED
4	CONCRETE BUILDING ACCESS RAMP
5	STOREFRONT ENTRY GLASS
6	FIRE ACCESS / EXIT MAN DOORS - PAINTED
7	CLERESTORY WINDOWS
8	KNOCK OUT PANELS
9	OVERHEAD SECTIONAL DOOR, PAINTED
10	INSULATED GLASS WINDOWS
11	FUTURE COMPANY SIGN LOCATION
47	EXTERIOR WALL MOUNTED LIGHT FIXTURE - REFER TO ELECTRICAL PLANS
81	STEEL TRELLIS WITH CLIMBING VINES
82	PRELIMINARY LED LIGHTS UNDER CANOPY AND OVERHANG, TYPICAL AT ALL CORNER ENTRY POINTS


EXTERIOR PAINT LEGEND	
A	DEW380 "WARM WHITE"
B	DET616 "EQUINOX"
C	DET610 "WOLVERINE"
D	DE5691 "INSPIRATION PEAK"
H	STOREFRONT SYSTEM 1" INSULATED GLAZING, SOLARCOOL (2) - SOLARBLUE, IN CLEAR ANNOZIDIZED ALUMINUM FRAME

CONCEPTUAL AND SCHEMATIC DESIGNS, INCLUDING RENDERINGS, ARE CREATED FOR THE SOLE PURPOSE OF DEVELOPING A DESIGN CONCEPT. THEY ARE PART OF THE OVERALL DESIGN PROCESS THAT ULTIMATELY LEADS TO MORE DETAILED DRAWINGS, BUT THE INFORMATION DEPICTED IN THESE DESIGNS IS INCOMPLETE AND NOT INTENDED TO REPRESENT THE FULL SCOPE OF THE PROJECT DESIGN. THE USE OF THESE CONCEPTUAL AND SCHEMATIC DESIGNS/RENDERINGS FOR ANY PURPOSE OTHER THAN AS INTENDED BY THE ARCHITECT IS PROHIBITED.

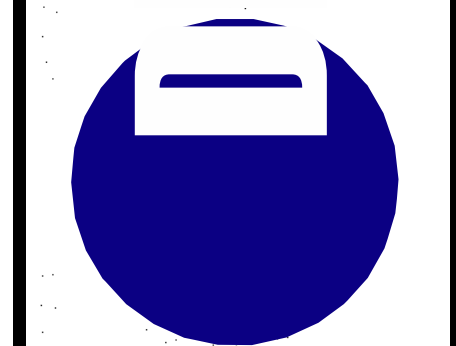

4600
EAST INDIAN SCHOOL RD
PHOENIX, ARIZONA 85018
602-840-2929 P

UNBOUND GATEWAY
BLDG C
SOSSAMAN AND PECOS


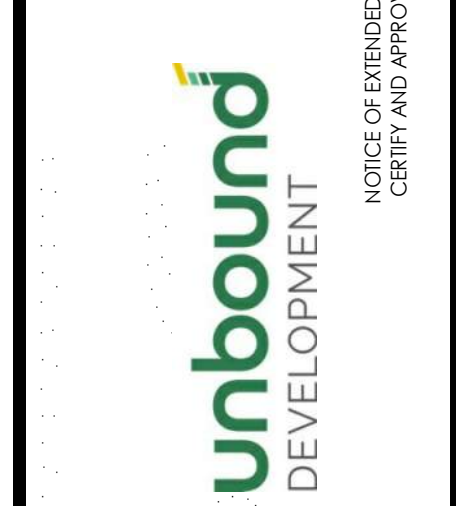


FIRST ISSUED: 06/16/21


REVISIONS		
No.	DATE	DESCRIPTION
1	8/9/21	1ST DRB COMMENTS
2	8/25/21	2ND DRB COMMENTS
3	12/2/21	3RD DRB COMMENTS
4	1/10/22	P&Z COMMENTS

PROJECT NO: 21108.00
DRAWN BY: DTC
CHECKED BY: DCAL
COPYRIGHT 2021: DEUTSCH ARCHITECTURE GROUP

EXTERIOR ELEVATIONS - COLORED BLDG C

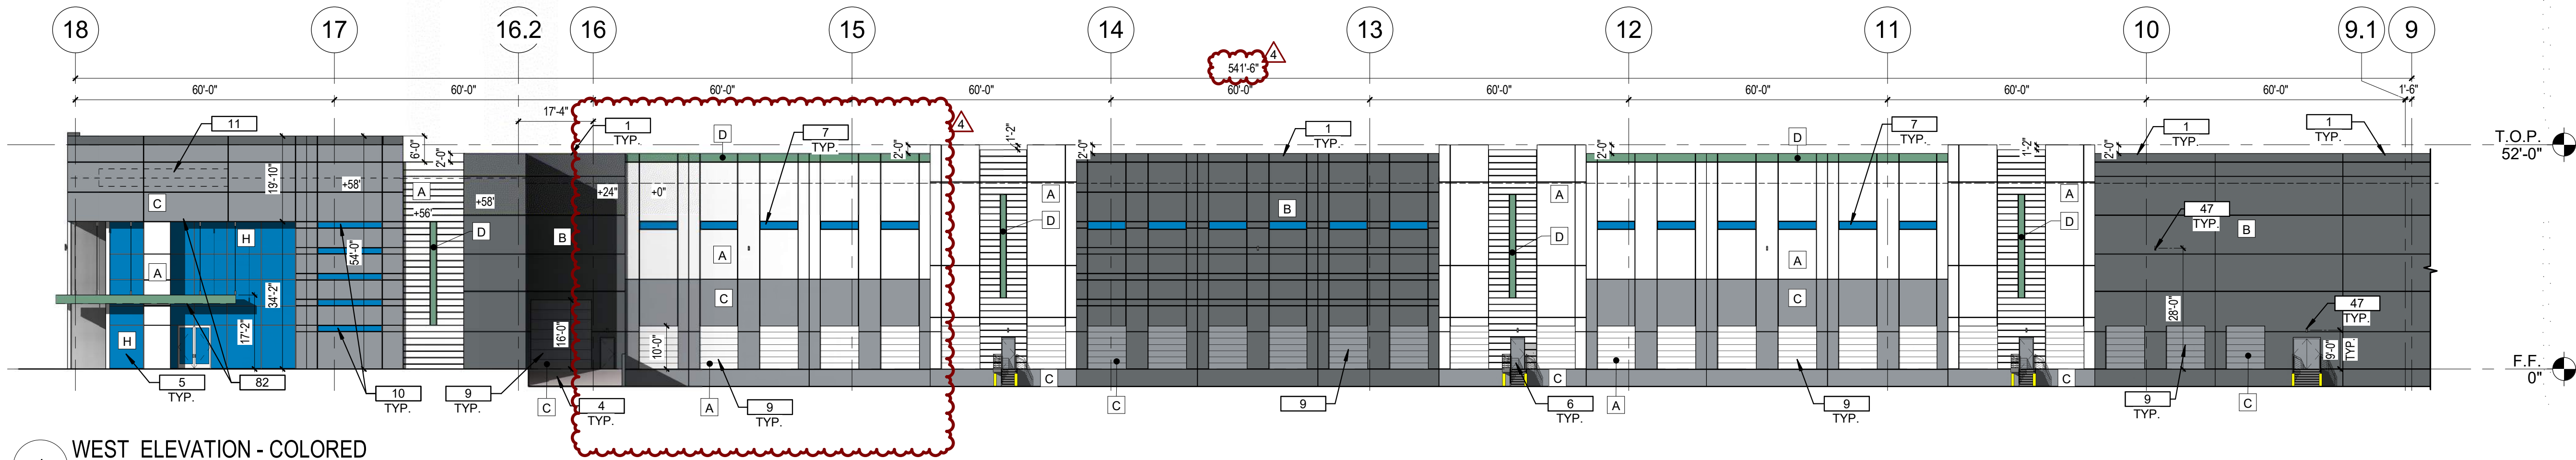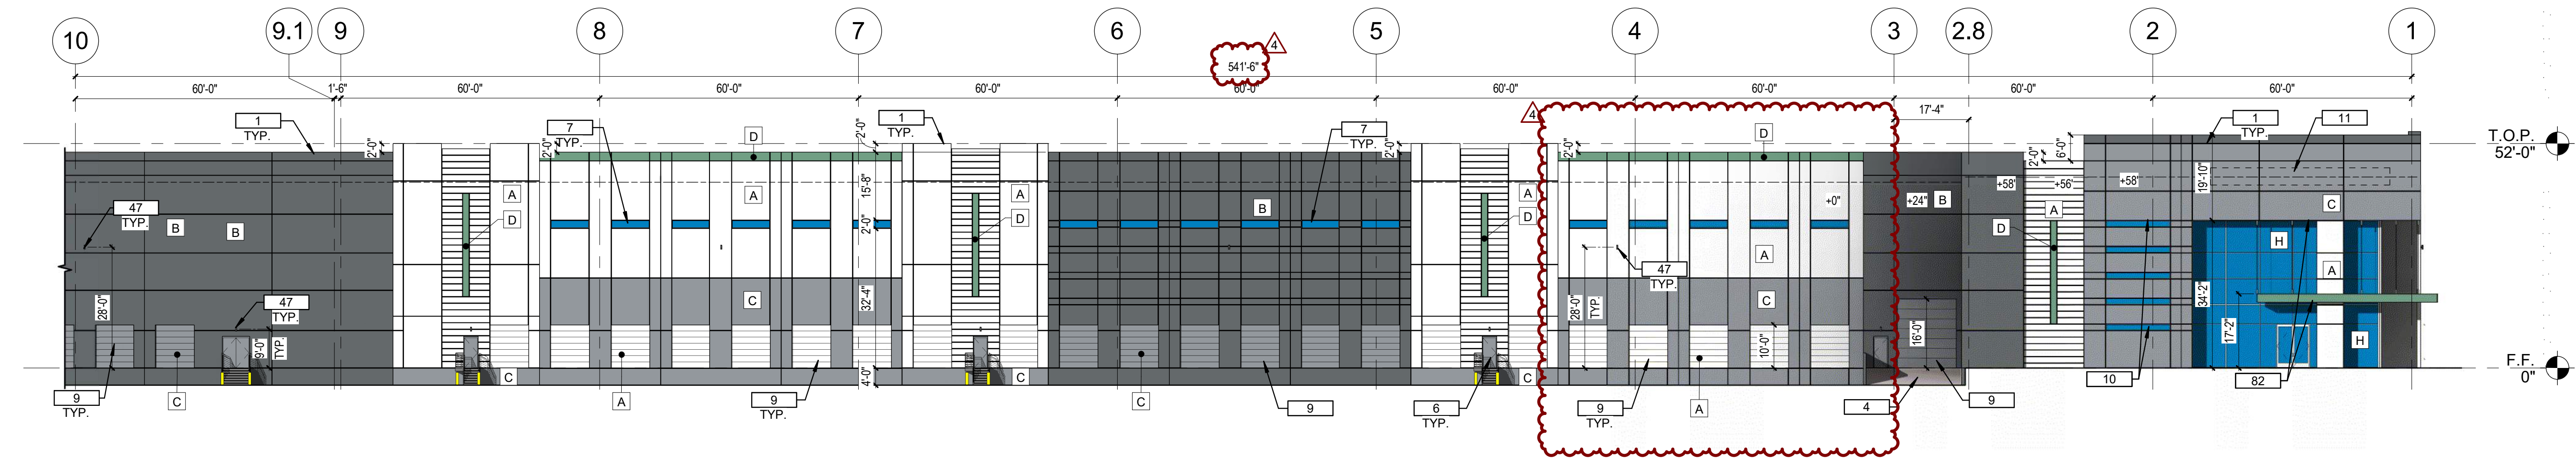

1 WEST ELEVATION - COLORED
SCALE 0' 16' 32' 64' 80' 3/64" = 1'-0"

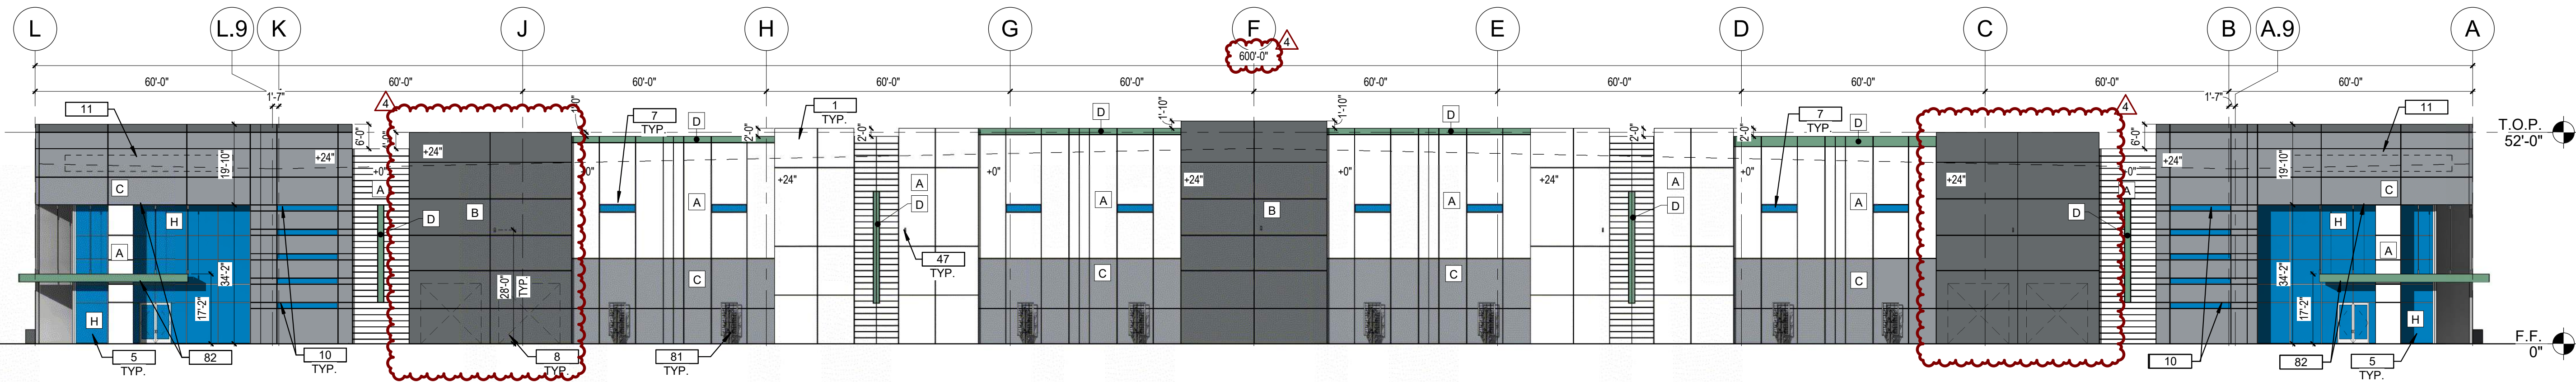

2 SOUTH ELEVATION - COLORED
SCALE 0' 16' 32' 64' 80' 3/64" = 1'-0"

WEST ELEVATION		
MATERIAL	AREA (SF)	%
CONCRETE TILT WALL		
COLOR A	15994	31%
COLOR B	11153	21%
COLOR C	9656	19%
COLOR D	1020	2%
CONCRETE TILT WALL W/FORMLINER		
COLOR A	4714	9%
TRELLIS	0	0%
WINDOWS	3707	7%
CORNICE	1060	2%
CANOPY	160	0%
OH DOOR	4460	9%
HM DOOR	186	0%
	52110	100%

SOUTH ELEVATION		
MATERIAL	AREA (SF)	%
CONCRETE TILT WALL		
COLOR A	9914	0.30
COLOR B	7150	0.22
COLOR C	8478	0.26
COLOR D	628	0.02
CONCRETE TILT WALL W/FORMLINER		
COLOR A	2320	0.07
TRELLIS	384	0.01
WINDOWS	3272	0.10
CANOPY	160	0.00
CORNICE	796	0.02
OH DOOR	0	0.00
HM DOOR	84	0.00
	33186	1.00


KEYNOTES

- EXTERIOR CONCRETE TILT PANEL WALL WITH REVEALS, TYP. PAINTED
- CONCRETE BUILDING ACCESS RAMP
- STOREFRONT ENTRY GLASS
- FIRE ACCESS / EXIT MAN DOORS - PAINTED
- CLERESTORY WINDOWS
- KNOCK OUT PANELS
- OVERHEAD SECTIONAL DOOR, PAINTED
- INSULATED GLASS WINDOWS
- FUTURE COMPANY SIGN LOCATION
- EXTERIOR WALL MOUNTED LIGHT FIXTURE - REFER TO ELECTRICAL PLANS
- STEEL TRELLIS WITH CLIMBING VINES
- PRELIMINARY LED LIGHTS UNDER CANOPY AND OVERHANG, TYPICAL AT ALL CORNER ENTRY POINTS

EXTERIOR PAINT LEGEND

- | | |
|---|---|
| A | DEW380 "WARM WHITE" |
| B | DET616 "EQUINOX" |
| C | DET610 "WOLVERINE" |
| D | DE5891 "INSPIRATION PEAK" |
| H | STOREFRONT SYSTEM
1" INSULATED GLAZING, SOLARCOOL (2) - SOLARBLUE, IN CLEAR ANNOZIDIZED ALUMINUM FRAME |

CONCEPTUAL AND SCHEMATIC DESIGNS, INCLUDING RENDERINGS, ARE CREATED FOR THE SOLE PURPOSE OF DEVELOPING A DESIGN CONCEPT. THEY ARE PART OF THE OVERALL DESIGN PROCESS THAT ULTIMATELY LEADS TO MORE DETAILED DRAWINGS, BUT THE INFORMATION DEPICTED IN THESE DESIGNS IS INCOMPLETE AND NOT INTENDED TO REPRESENT THE FULL SCOPE OF THE PROJECT DESIGN. THE USE OF THESE CONCEPTUAL AND SCHEMATIC DESIGNS/RENDERINGS FOR ANY PURPOSE OTHER THAN AS INTENDED BY THE ARCHITECT IS PROHIBITED.

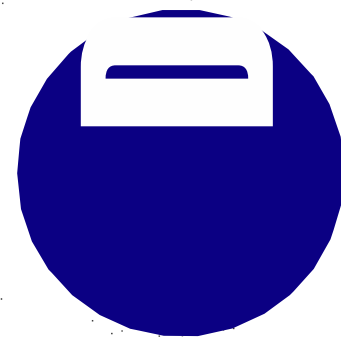

4600
EAST INDIAN SCHOOL RD
PHOENIX, ARIZONA 85018
602-840-2929 P

UNBOUND GATEWAY

BLDG C

SOSSAMAN AND PECOS

NOTICE OF EXTENDED CERTIFICATION AND APPROVAL PERIOD: THIS CONTRACT ALLOWS THE OWNER TO CERTIFY AND APPROVE BILLINGS AND ESTIMATES WITHIN 30 DAYS AFTER THE BILLINGS AND ESTIMATES ARE RECEIVED FROM THE CONTRACTOR.

unbound
DEVELOPMENT

FIRST ISSUED: 06/16/21

REVISIONS

No.	DATE	DESCRIPTION
1	8/9/21	1ST DRB COMMENTS
2	8/25/21	2ND DRB COMMENTS
3	12/2/21	3RD DRB COMMENTS
4	1/10/22	P&Z COMMENTS



PROJECT NO: 21108.00

DRAWN BY: DTC

CHECKED BY: DCAL

COPYRIGHT 2021: DEUTSCH ARCHITECTURE GROUP

EXTERIOR
ELEVATIONS -
COLORED BLDG C

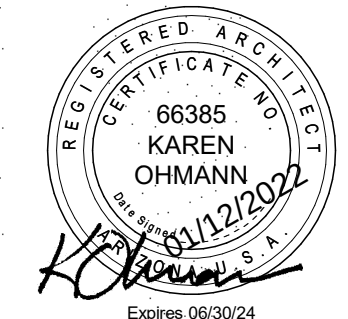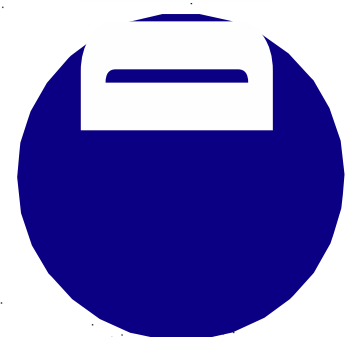

4600
EAST INDIAN SCHOOL RD
PHOENIX, ARIZONA 85018
602-840-2929 P

UNBOUND GATEWAY

BLDG D
SOSSAMAN AND PECOS



NOTICE OF EXTENDED CERTIFICATION AND APPROVAL PERIOD: THIS CONTRACT ALLOWS THE OWNER TO CERTIFY AND APPROVE BILLINGS AND ESTIMATES WITHIN 30 DAYS AFTER THE BILLINGS AND ESTIMATES ARE RECEIVED FROM THE CONTRACTOR.

FIRST ISSUED: 06/16/21

REVISIONS

No.	DATE	DESCRIPTION
1	8/9/21	1ST DRB COMMENTS
2	8/25/21	2ND DRB COMMENTS
3	12/2/21	3RD DRB COMMENTS
4	1/10/22	P&Z COMMENTS

PROJECT NO: 21108.00

DRAWN BY: DTC

CHECKED BY: DCAL

COPYRIGHT 2021: DEUTSCH

ARCHITECTURE GROUP



**EXTERIOR
ELEVATIONS -
COLORED BLDG C**

A-210C


21108.00-UNBOUND GATEWAY-PRS21-00272



1 EAST ELEVATION - COLORED

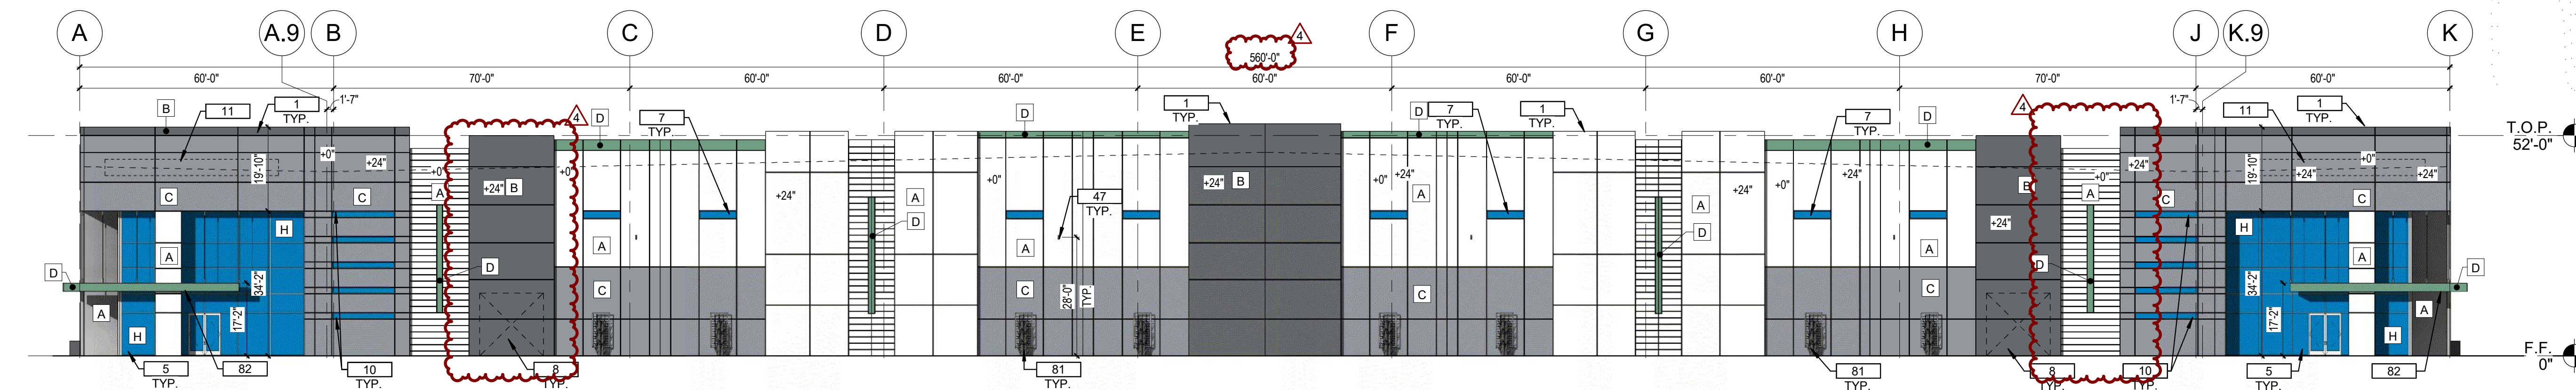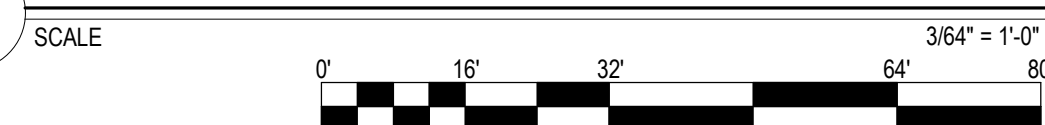

2 NORTH ELEVATION - COLORED

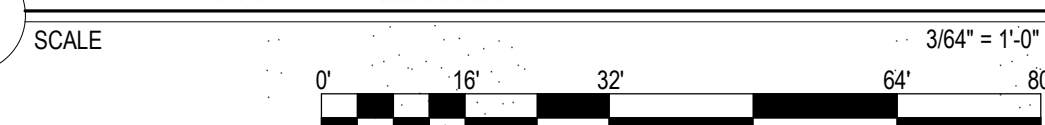

EAST ELEVATION			NORTH ELEVATION		
MATERIAL	AREA (SF)	%	MATERIAL	AREA (SF)	%
CONCRETE TILT WALL					
COLOR A	15994	31%	COLOR A	9914	0.30
COLOR B	11001	21%	COLOR B	7150	0.22
COLOR C	9656	19%	COLOR C	8478	0.25
COLOR D	1020	2%	COLOR D	628	0.02
CONCRETE TILT WALL W/FORMLINER					
COLOR A	4714	9%	COLOR A	2320	0.07
TRELLIS	0	0%	TRELLIS	384	0.01
WINDOWS	3707	7%	WINDOWS	3272	0.10
CORNICE	1060	2%	CORNICE	160	0.00
CANOPY	160	0%	CANOPY	796	0.02
OH DOOR	4588	9%	OH DOOR	0	0.00
HM DOOR	210	0%	HM DOOR	84	0.00
	52110	100%		33186	1.00


KEYNOTES

- EXTERIOR CONCRETE TILT PANEL WALL WITH REVEALS, TYP. PAINTED
- CONCRETE BUILDING ACCESS RAMP
- STOREFRONT ENTRY GLASS
- FIRE ACCESS / EXIT MAN DOORS - PAINTED
- CLERESTORY WINDOWS
- KNOCK OUT PANELS
- OVERHEAD SECTIONAL DOOR, PAINTED
- INSULATED GLASS WINDOWS
- FUTURE COMPANY SIGN LOCATION
- EXTERIOR WALL MOUNTED LIGHT FIXTURE - REFER TO ELECTRICAL PLANS
- STEEL TRELLIS WITH CLIMBING VINES
- PRELIMINARY LED LIGHTS UNDER CANOPY AND OVERHANG, TYPICAL AT ALL CORNER ENTRY POINTS

EXTERIOR PAINT LEGEND

- A DEW380 "WARM WHITE"
- B DET616 "EQUINOX"
- C DET610 "WOLVERINE"
- D DE5691 "INSPIRATION PEAK"
- H STOREFRONT SYSTEM
1" INSULATED GLAZING, SOLARCOOL (2) - SOLARBLUE, IN CLEAR ANNOZIDIZED ALUMINUM FRAME

CONCEPTUAL AND SCHEMATIC DESIGNS, INCLUDING RENDERINGS, ARE CREATED FOR THE SOLE PURPOSE OF DEVELOPING A DESIGN CONCEPT. THEY ARE PART OF THE OVERALL DESIGN PROCESS THAT ULTIMATELY LEADS TO MORE DETAILED DRAWINGS, BUT THE INFORMATION DEPICTED IN THESE DESIGNS IS INCOMPLETE AND NOT INTENDED TO REPRESENT THE FULL SCOPE OF THE PROJECT DESIGN. THE USE OF THESE CONCEPTUAL AND SCHEMATIC DESIGNS/RENDERINGS FOR ANY PURPOSE OTHER THAN AS INTENDED BY THE ARCHITECT IS PROHIBITED.

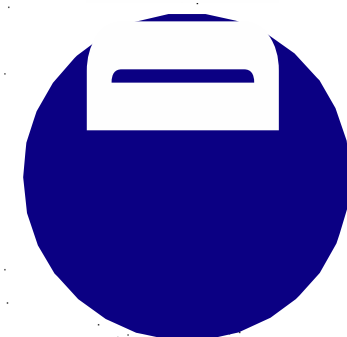

4600
EAST INDIAN SCHOOL RD
PHOENIX, ARIZONA 85018
602-840-2929 P

UNBOUND GATEWAY

BLDG D
SOSSAMAN AND PECOS



NOTICE OF EXTENDED CERTIFICATION AND APPROVAL PERIOD: THIS CONTRACT ALLOWS THE OWNER TO CERTIFY AND APPROVE BILLINGS AND ESTIMATES WITHIN 30 DAYS AFTER THE BILLINGS AND ESTIMATES ARE RECEIVED FROM THE CONTRACTOR.

FIRST ISSUED: 06/16/21

REVISIONS		
No.	DATE	DESCRIPTION
1	8/9/21	1ST DRB COMMENTS
2	8/25/21	2ND DRB COMMENTS
3	12/2/21	3RD DRB COMMENTS
4	1/10/22	P&Z COMMENTS

PROJECT NO: 21108.00
DRAWN BY: DTC
CHECKED BY: DCAL
COPYRIGHT 2021: DEUTSCH ARCHITECTURE GROUP



EXTERIOR
ELEVATIONS -
COLORED BLDG C

A-211C


21108.00-UNBOUND GATEWAY-PRS21-00272



WEST ELEVATION - COLORED

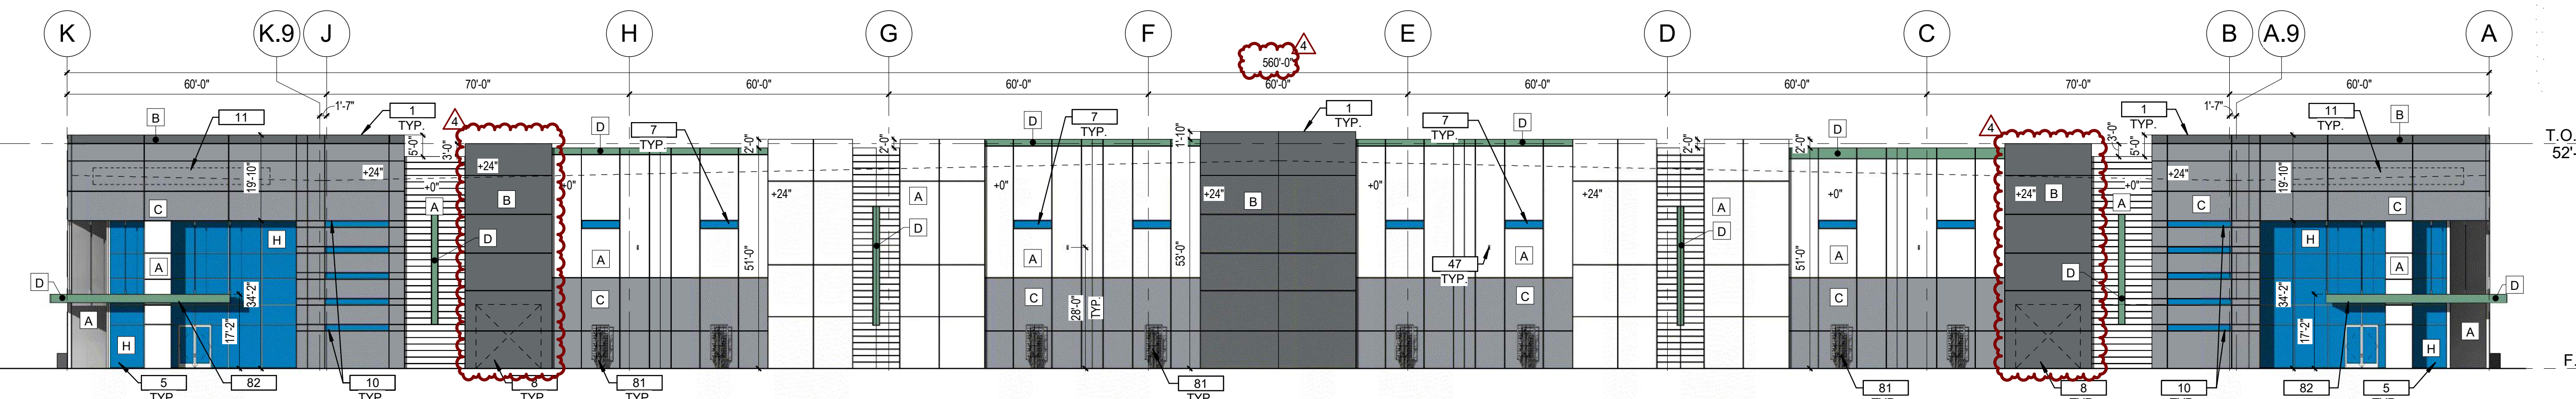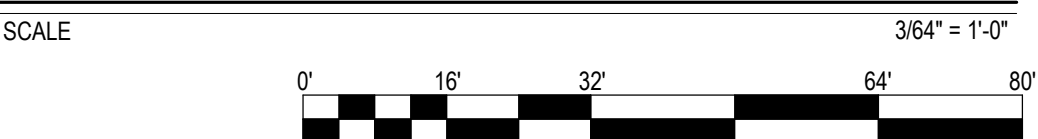

SOUTH ELEVATION - COLORED

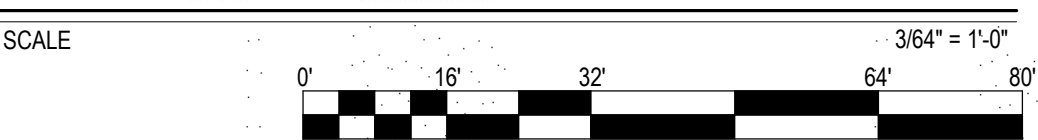

WEST ELEVATION		
MATERIAL	AREA (SF)	%
CONCRETE TILT WALL		
COLOR A	15994	31%
COLOR B	11153	21%
COLOR C	9656	19%
COLOR D	1020	2%
CONCRETE TILT WALL W/FORMLINER		
COLOR A	4714	9%
TRELLIS	0	0%
WINDOWS	3707	7%
CORNICE	1060	2%
CANOPY	160	0%
OH DOOR	4460	9%
HM DOOR	186	0%
	52110	100%

SOUTH ELEVATION		
MATERIAL	AREA (SF)	%
CONCRETE TILT WALL		
COLOR A	9914	0.30
COLOR B	7150	0.22
COLOR C	8478	0.26
COLOR D	628	0.02
CONCRETE TILT WALL W/FORMLINER		
COLOR A	2320	0.07
TRELLIS	384	0.01
WINDOWS	3272	0.10
CORNICE	160	0.00
CANOPY	796	0.02
OH DOOR	0	0.00
HM DOOR	84	0.00
	33186	1.00


KEYNOTES

- EXTERIOR CONCRETE TILT PANEL WALL WITH REVEALS, TYP. PAINTED
- CONCRETE BUILDING ACCESS RAMP
- STOREFRONT ENTRY GLASS
- FIRE ACCESS / EXIT MAN DOORS - PAINTED
- CLERESTORY WINDOWS
- KNOCK OUT PANELS
- OVERHEAD SECTIONAL DOOR, PAINTED
- INSULATED GLASS WINDOWS
- FUTURE COMPANY SIGN LOCATION
- EXTERIOR WALL MOUNTED LIGHT FIXTURE - REFER TO ELECTRICAL PLANS
- STEEL TRELLIS WITH CLIMBING VINES
- PRELIMINARY LED LIGHTS UNDER CANOPY AND OVERHANG, TYPICAL AT ALL CORNER ENTRY POINTS

EXTERIOR PAINT LEGEND

- DEW380 "WARM WHITE"
- DET616 "EQUINOX"
- DET610 "WOLVERINE"
- DE5691 "INSPIRATION PEAK"
- STOREFRONT SYSTEM
1" INSULATED GLAZING, SOLARCOOL (2) - SOLARBLUE, IN CLEAR ANNOZIDIZED ALUMINUM FRAME

CONCEPTUAL AND SCHEMATIC DESIGNS, INCLUDING RENDERINGS, ARE CREATED FOR THE SOLE PURPOSE OF DEVELOPING A DESIGN CONCEPT. THEY ARE PART OF THE OVERALL DESIGN PROCESS THAT ULTIMATELY LEADS TO MORE DETAILED DRAWINGS, BUT THE INFORMATION DEPICTED IN THESE DESIGNS IS INCOMPLETE AND NOT INTENDED TO REPRESENT THE FULL SCOPE OF THE PROJECT DESIGN. THE USE OF THESE CONCEPTUAL AND SCHEMATIC DESIGNS/RENDERINGS FOR ANY PURPOSE OTHER THAN AS INTENDED BY THE ARCHITECT IS PROHIBITED.

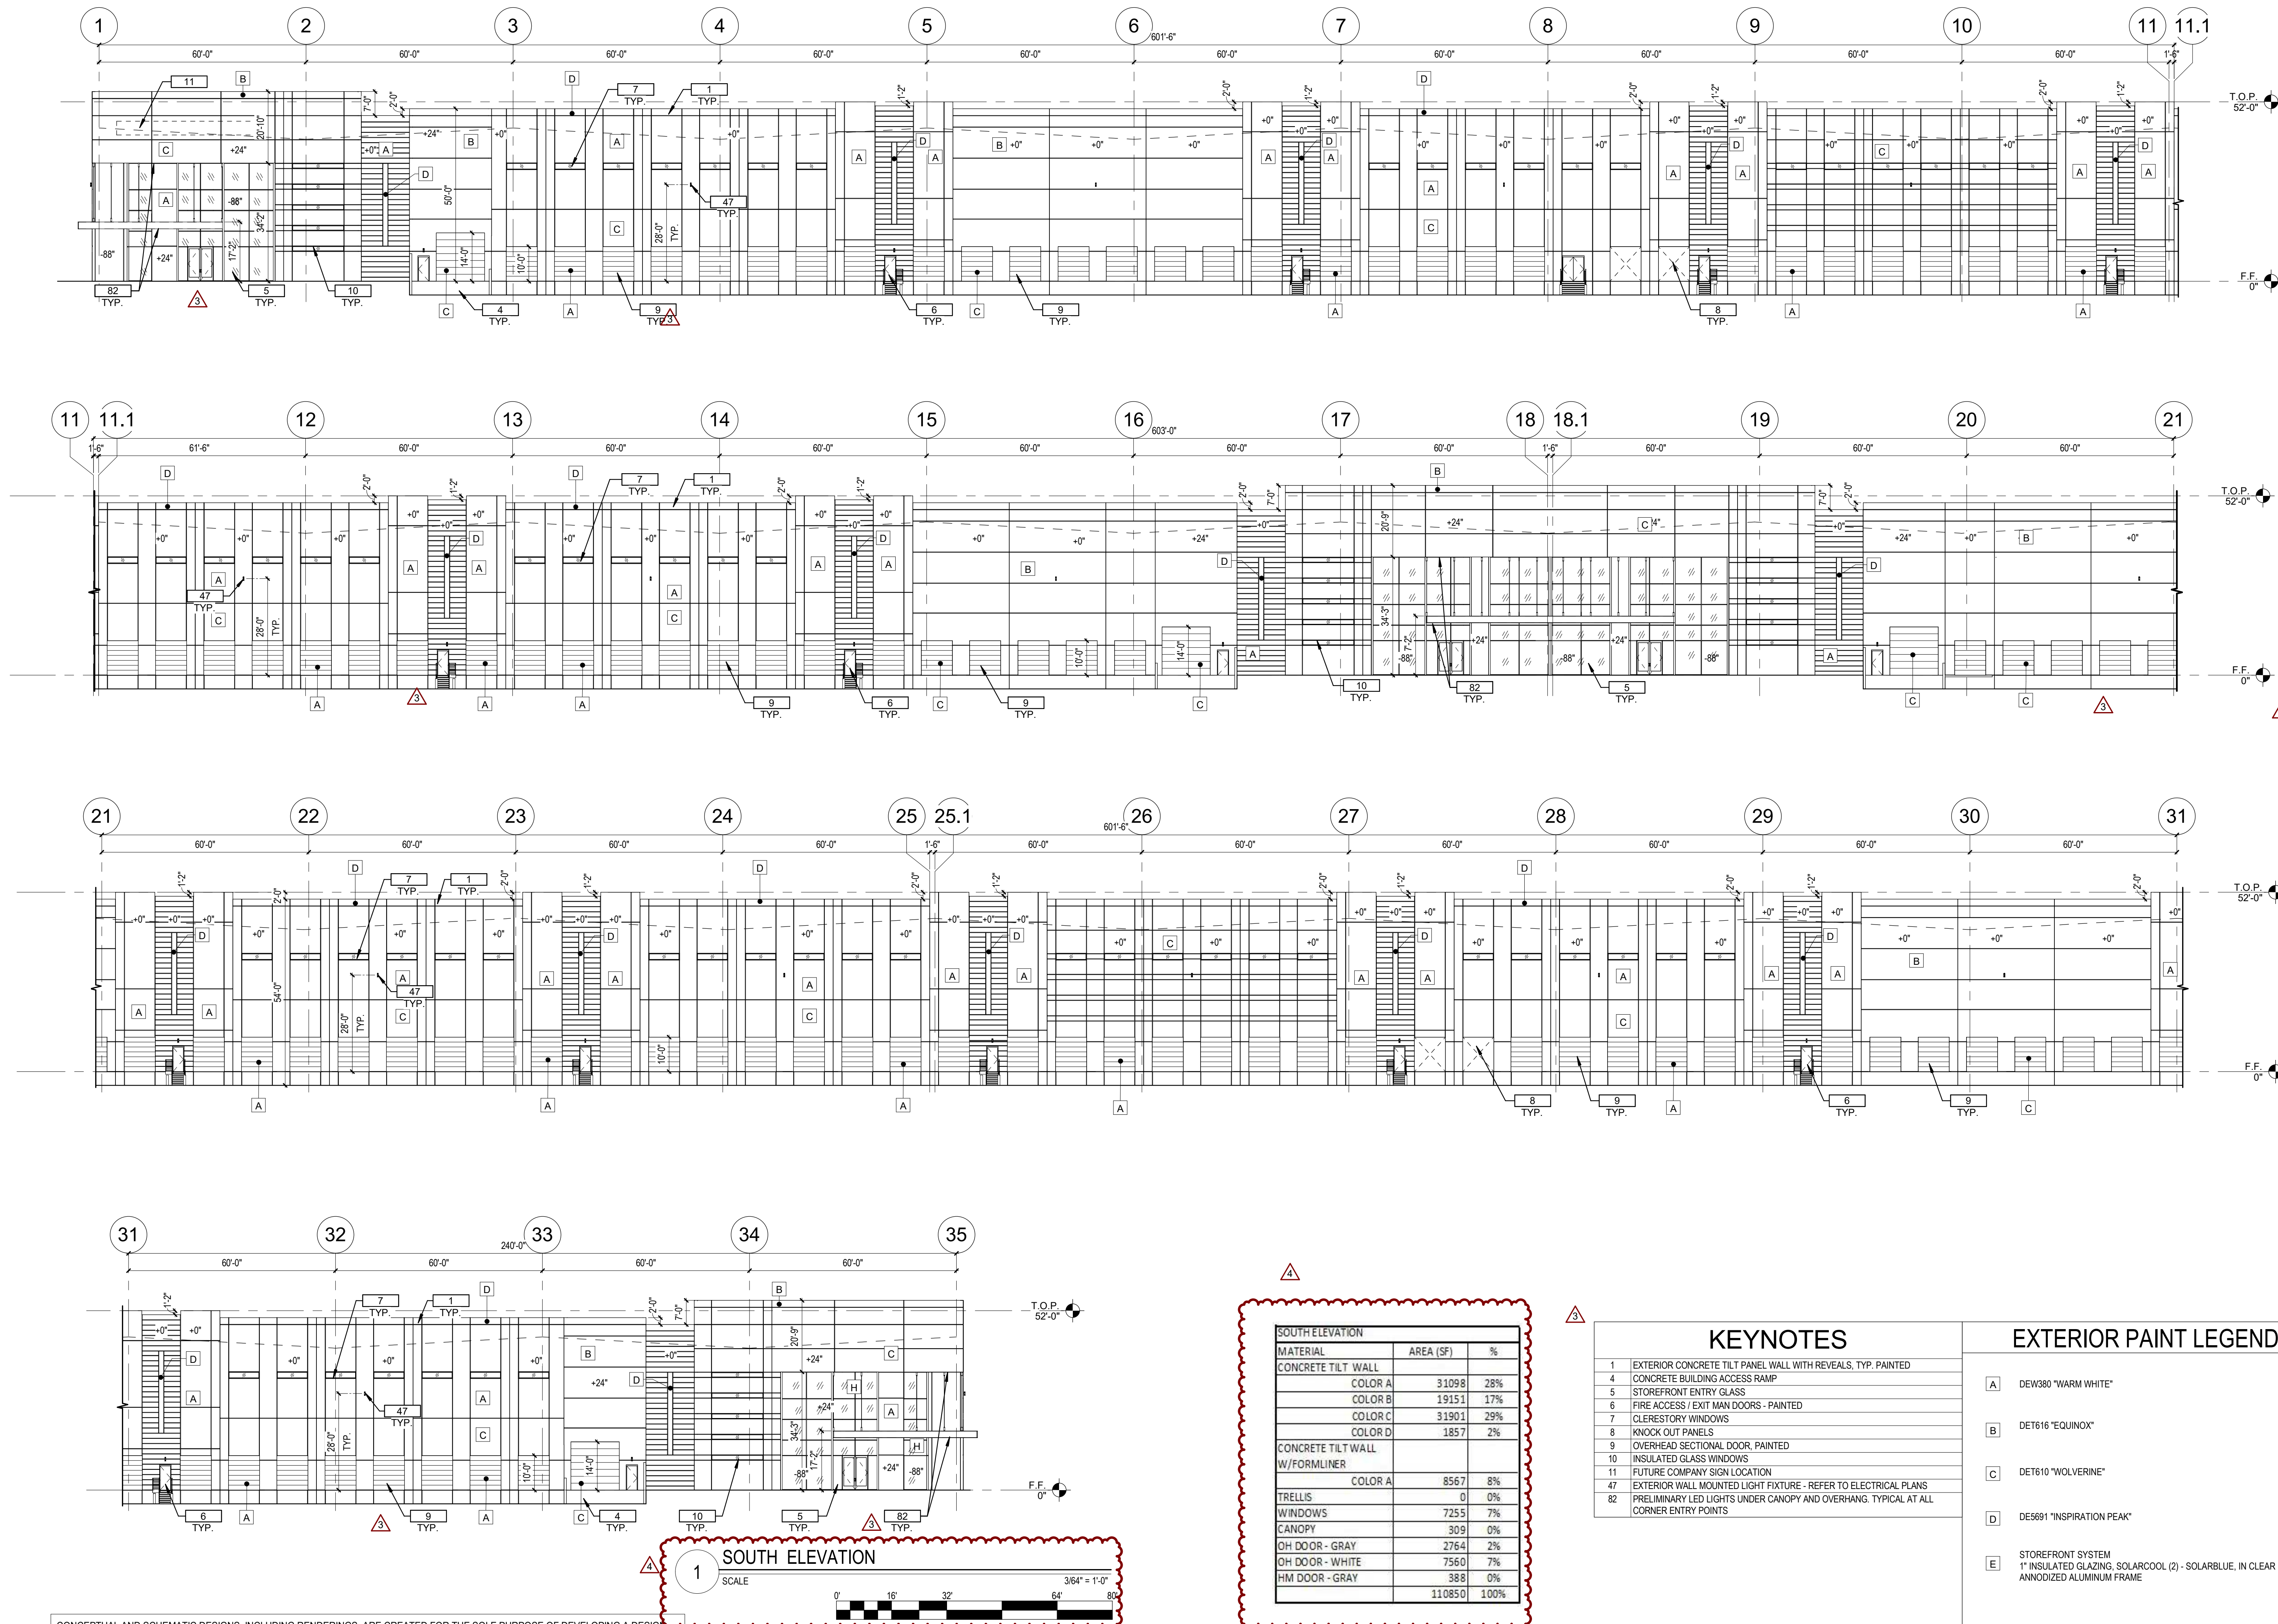

SOUTH ELEVATION		
MATERIAL	AREA (SF)	%
CONCRETE TILT WALL	COLOR A	31098 28%
	COLOR B	19151 17%
	COLOR C	31901 29%
	COLOR D	1857 2%
CONCRETE TILT WALL W/FORMLINER		
COLOR A	8567 8%	
TRELLIS	0 0%	
WINDOWS	7255 7%	
CANOPY	309 0%	
GH DOOR - GRAY	2764 2%	
GH DOOR - WHITE	7560 7%	
HM DOOR - GRAY	388 0%	
	110850 100%	


KEYNOTES

- EXTERIOR CONCRETE TILT PANEL WALL WITH REVEALS, TYP. PAINTED
- CONCRETE BUILDING ACCESS RAMP
- STOREFRONT ENTRY GLASS
- FIRE ACCESS / EXIT MAN DOORS - PAINTED
- CLERESTORY WINDOWS
- KNOCK OUT PANELS
- OVERHEAD SECTIONAL DOOR, PAINTED
- INSULATED GLASS WINDOWS
- FUTURE COMPANY SIGN LOCATION
- EXTERIOR WALL MOUNTED LIGHT FIXTURE - REFER TO ELECTRICAL PLANS
- PRELIMINARY LED LIGHTS UNDER CANOPY AND OVERHANG. TYPICAL AT ALL CORNER ENTRY POINTS

EXTERIOR PAINT LEGEND

- A DEW380 "WARM WHITE"
- B DET616 "EQUINOX"
- C DET610 "WOLVERINE"
- D DE5891 "INSPIRATION PEAK"
- E STOREFRONT SYSTEM
1" INSULATED GLAZING, SOLARCOOL (2) - SOLARBLUE, IN CLEAR ANNOZIDIZED ALUMINUM FRAME

CONCEPTUAL AND SCHEMATIC DESIGNS, INCLUDING RENDERINGS, ARE CREATED FOR THE SOLE PURPOSE OF DEVELOPING A DESIGN CONCEPT. THEY ARE PART OF THE OVERALL DESIGN PROCESS THAT ULTIMATELY LEADS TO MORE DETAILED DRAWINGS, BUT THE INFORMATION DEPICTED IN THESE DESIGNS IS INCOMPLETE AND NOT INTENDED TO REPRESENT THE FULL SCOPE OF THE PROJECT DESIGN. THE USE OF THESE CONCEPTUAL AND SCHEMATIC DESIGNS/RENDERINGS FOR ANY PURPOSE OTHER THAN AS INTENDED BY THE ARCHITECT IS PROHIBITED.

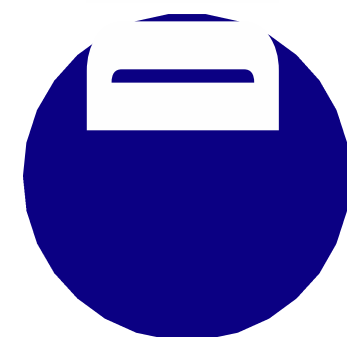

4600
EAST INDIAN SCHOOL RD
PHOENIX, ARIZONA 85018
602-840-2929 P

UNBOUND GATEWAY

BLDG A

SOSSAMAN AND PECOS

unbound
DEVELOPMENT

NOTICE OF EXTENSION: ANY CHANGES TO THE ORIGINAL DESIGN SHALL BE MADE TO THE ORIGINAL DESIGN AND ESTIMATES ARE RECEIVED FROM THE CONTRACTOR.

FIRST ISSUED: 06/22/21

REVISIONS

No.	DATE	DESCRIPTION
1	8-9-21	1ST DRB COMMENTS
2	8-28-21	2ND DRB COMMENTS
3	12-2-21	3RD DRB COMMENTS
4	01-10-22	P&Z COMMENTS


PROJECT NO: 21108.0

DRAWN BY: DTC

CHECKED BY: DCAL

COPYRIGHT 2021: DEUTSCH ARCHITECTURE GROUP

EXTERIOR
ELEVATIONS -
BLDG A

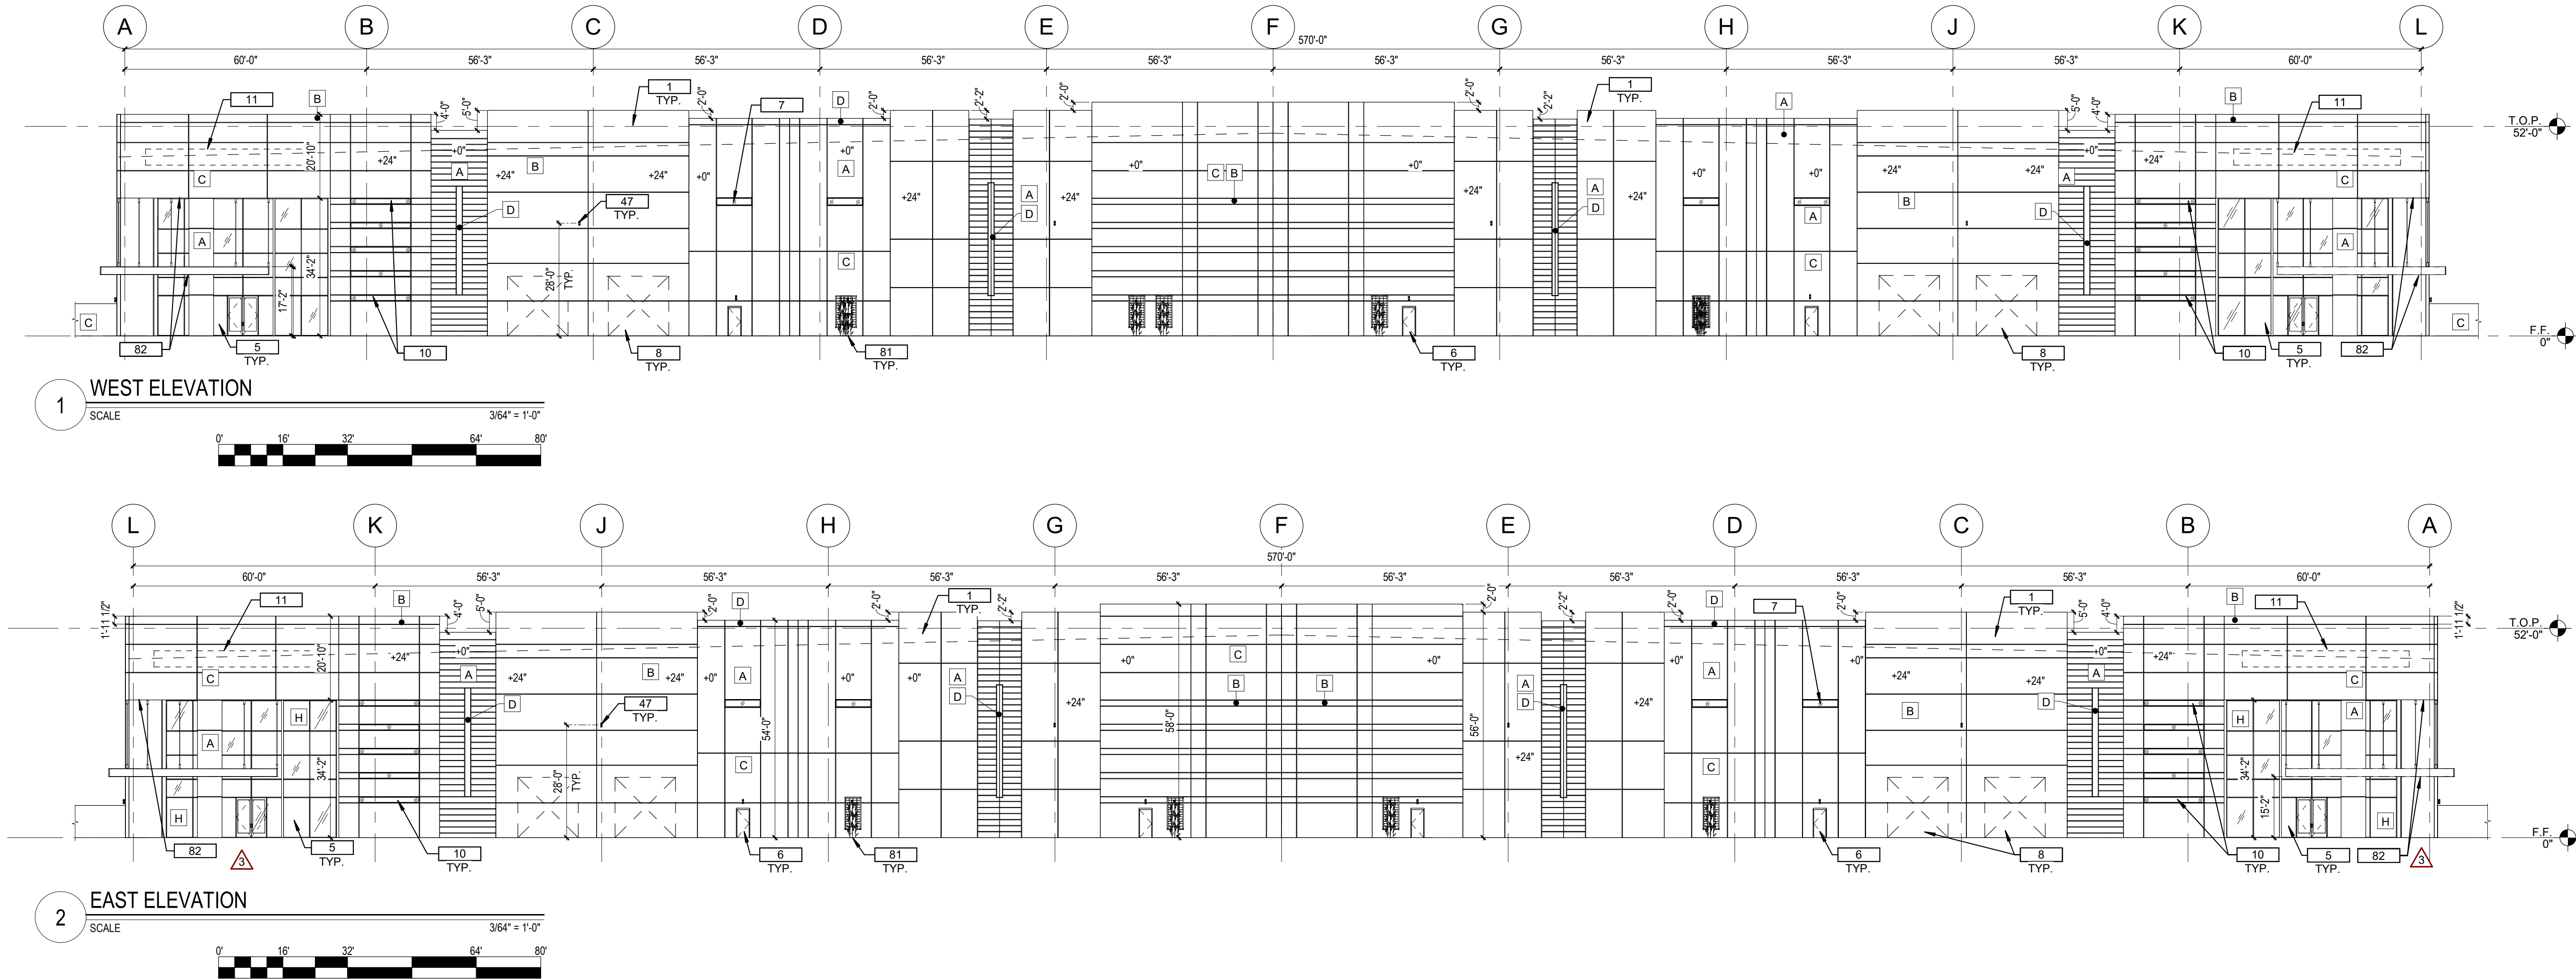


WEST ELEVATION		
MATERIAL	AREA (SF)	%
CONCRETE TILT WALL	COLOR A	7220 26%
	COLOR B	2901 10%
	COLOR C	10968 39%
	COLOR E	196 1%
CONCRETE TILT WALL W/FORMLINER	COLOR A	2550 9%
TRELLIS	192	1%
WINDOWS	3107	11%
CORNICE	164	1%
CANOPY	598	2%
OH DOOR	0	0%
HM DOOR	84	0%
	27980	100%

EAST ELEVATION		
MATERIAL	AREA (SF)	%
CONCRETE TILT WALL	COLOR A	7220 26%
	COLOR B	2901 10%
	COLOR C	10968 39%
	COLOR E	196 1%
CONCRETE TILT WALL W/FORMLINER	COLOR A	2550 9%
TRELLIS	192	1%
WINDOWS	3107	11%
CORNICE	164	1%
CANOPY	598	2%
OH DOOR	0	0%
HM DOOR	84	0%
	27980	100%

KEYNOTES	
1	EXTERIOR CONCRETE TILT PANEL WALL WITH REVEALS, TYP. PAINTED
5	STOREFRONT ENTRY GLASS
6	FIRE ACCESS / EXIT MAN DOORS - PAINTED
7	CLERESTORY WINDOWS
8	KNOCK OUT PANELS
10	INSULATED GLASS WINDOWS
11	FUTURE COMPANY SIGN LOCATION
47	EXTERIOR WALL MOUNTED LIGHT FIXTURE - REFER TO ELECTRICAL PLANS
81	STEEL TRELLIS WITH CLIMBING VINES
82	PRELIMINARY LED LIGHTS UNDER CANOPY AND OVERHANG, TYPICAL AT ALL CORNER ENTRY POINTS

EXTERIOR PAINT LEGEND	
A	DEW380 "WARM WHITE"
B	DET616 "EQUINOX"
C	DET610 "WOLVERINE"
D	DE5891 "INSPIRATION PEAK"
E	STOREFRONT SYSTEM 1" INSULATED GLAZING, SOLARCOOL (2) - SOLARBLUE, IN CLEAR ANNOIDIZED ALUMINIUM FRAME

CONCEPTUAL AND SCHEMATIC DESIGNS, INCLUDING RENDERINGS, ARE CREATED FOR THE SOLE PURPOSE OF DEVELOPING A DESIGN CONCEPT. THEY ARE PART OF THE OVERALL DESIGN PROCESS THAT ULTIMATELY LEADS TO MORE DETAILED DRAWINGS, BUT THE INFORMATION DEPICTED IN THESE DESIGNS IS INCOMPLETE AND NOT INTENDED TO REPRESENT THE FULL SCOPE OF THE PROJECT DESIGN. THE USE OF THESE CONCEPTUAL AND SCHEMATIC DESIGNS/RENDERINGS FOR ANY PURPOSE OTHER THAN AS INTENDED BY THE ARCHITECT IS PROHIBITED.

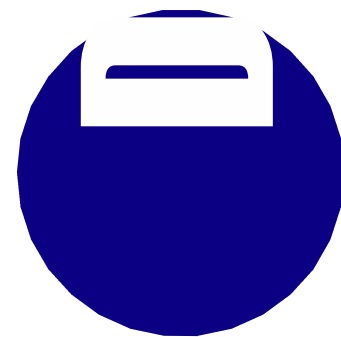

4600
EAST INDIAN SCHOOL RD
PHOENIX, ARIZONA 85018
602-840-2929 P

**UNBOUND GATEWAY
BLDG A**

SOSSAMAN AND PECOS

NOTICE OF ENTIRETY: CONTRACTOR SHALL BE RESPONSIBLE FOR OBTAINING ALL NECESSARY PERMITS AND APPROVALS. THE OWNER TO CERTIFY AND APPROVE BILLINGS AND ESTIMATES WITHIN 30 DAYS AFTER THE BILLINGS AND ESTIMATES ARE RECEIVED FROM THE CONTRACTOR.

unbound
DEVELOPMENT


FIRST ISSUED: 06/22/21

REVISIONS		
No.	DATE	DESCRIPTION
3	12-2-21	3RD DRB COMMENTS
4	01-10-22	P&Z COMMENTS

PROJECT NO: 21108.0
DRAWN BY: DTC
CHECKED BY: DCAL
COPYRIGHT 2021: DEUTSCH ARCHITECTURE GROUP

**EXTERIOR
ELEVATIONS -
BLDG A**

A-212

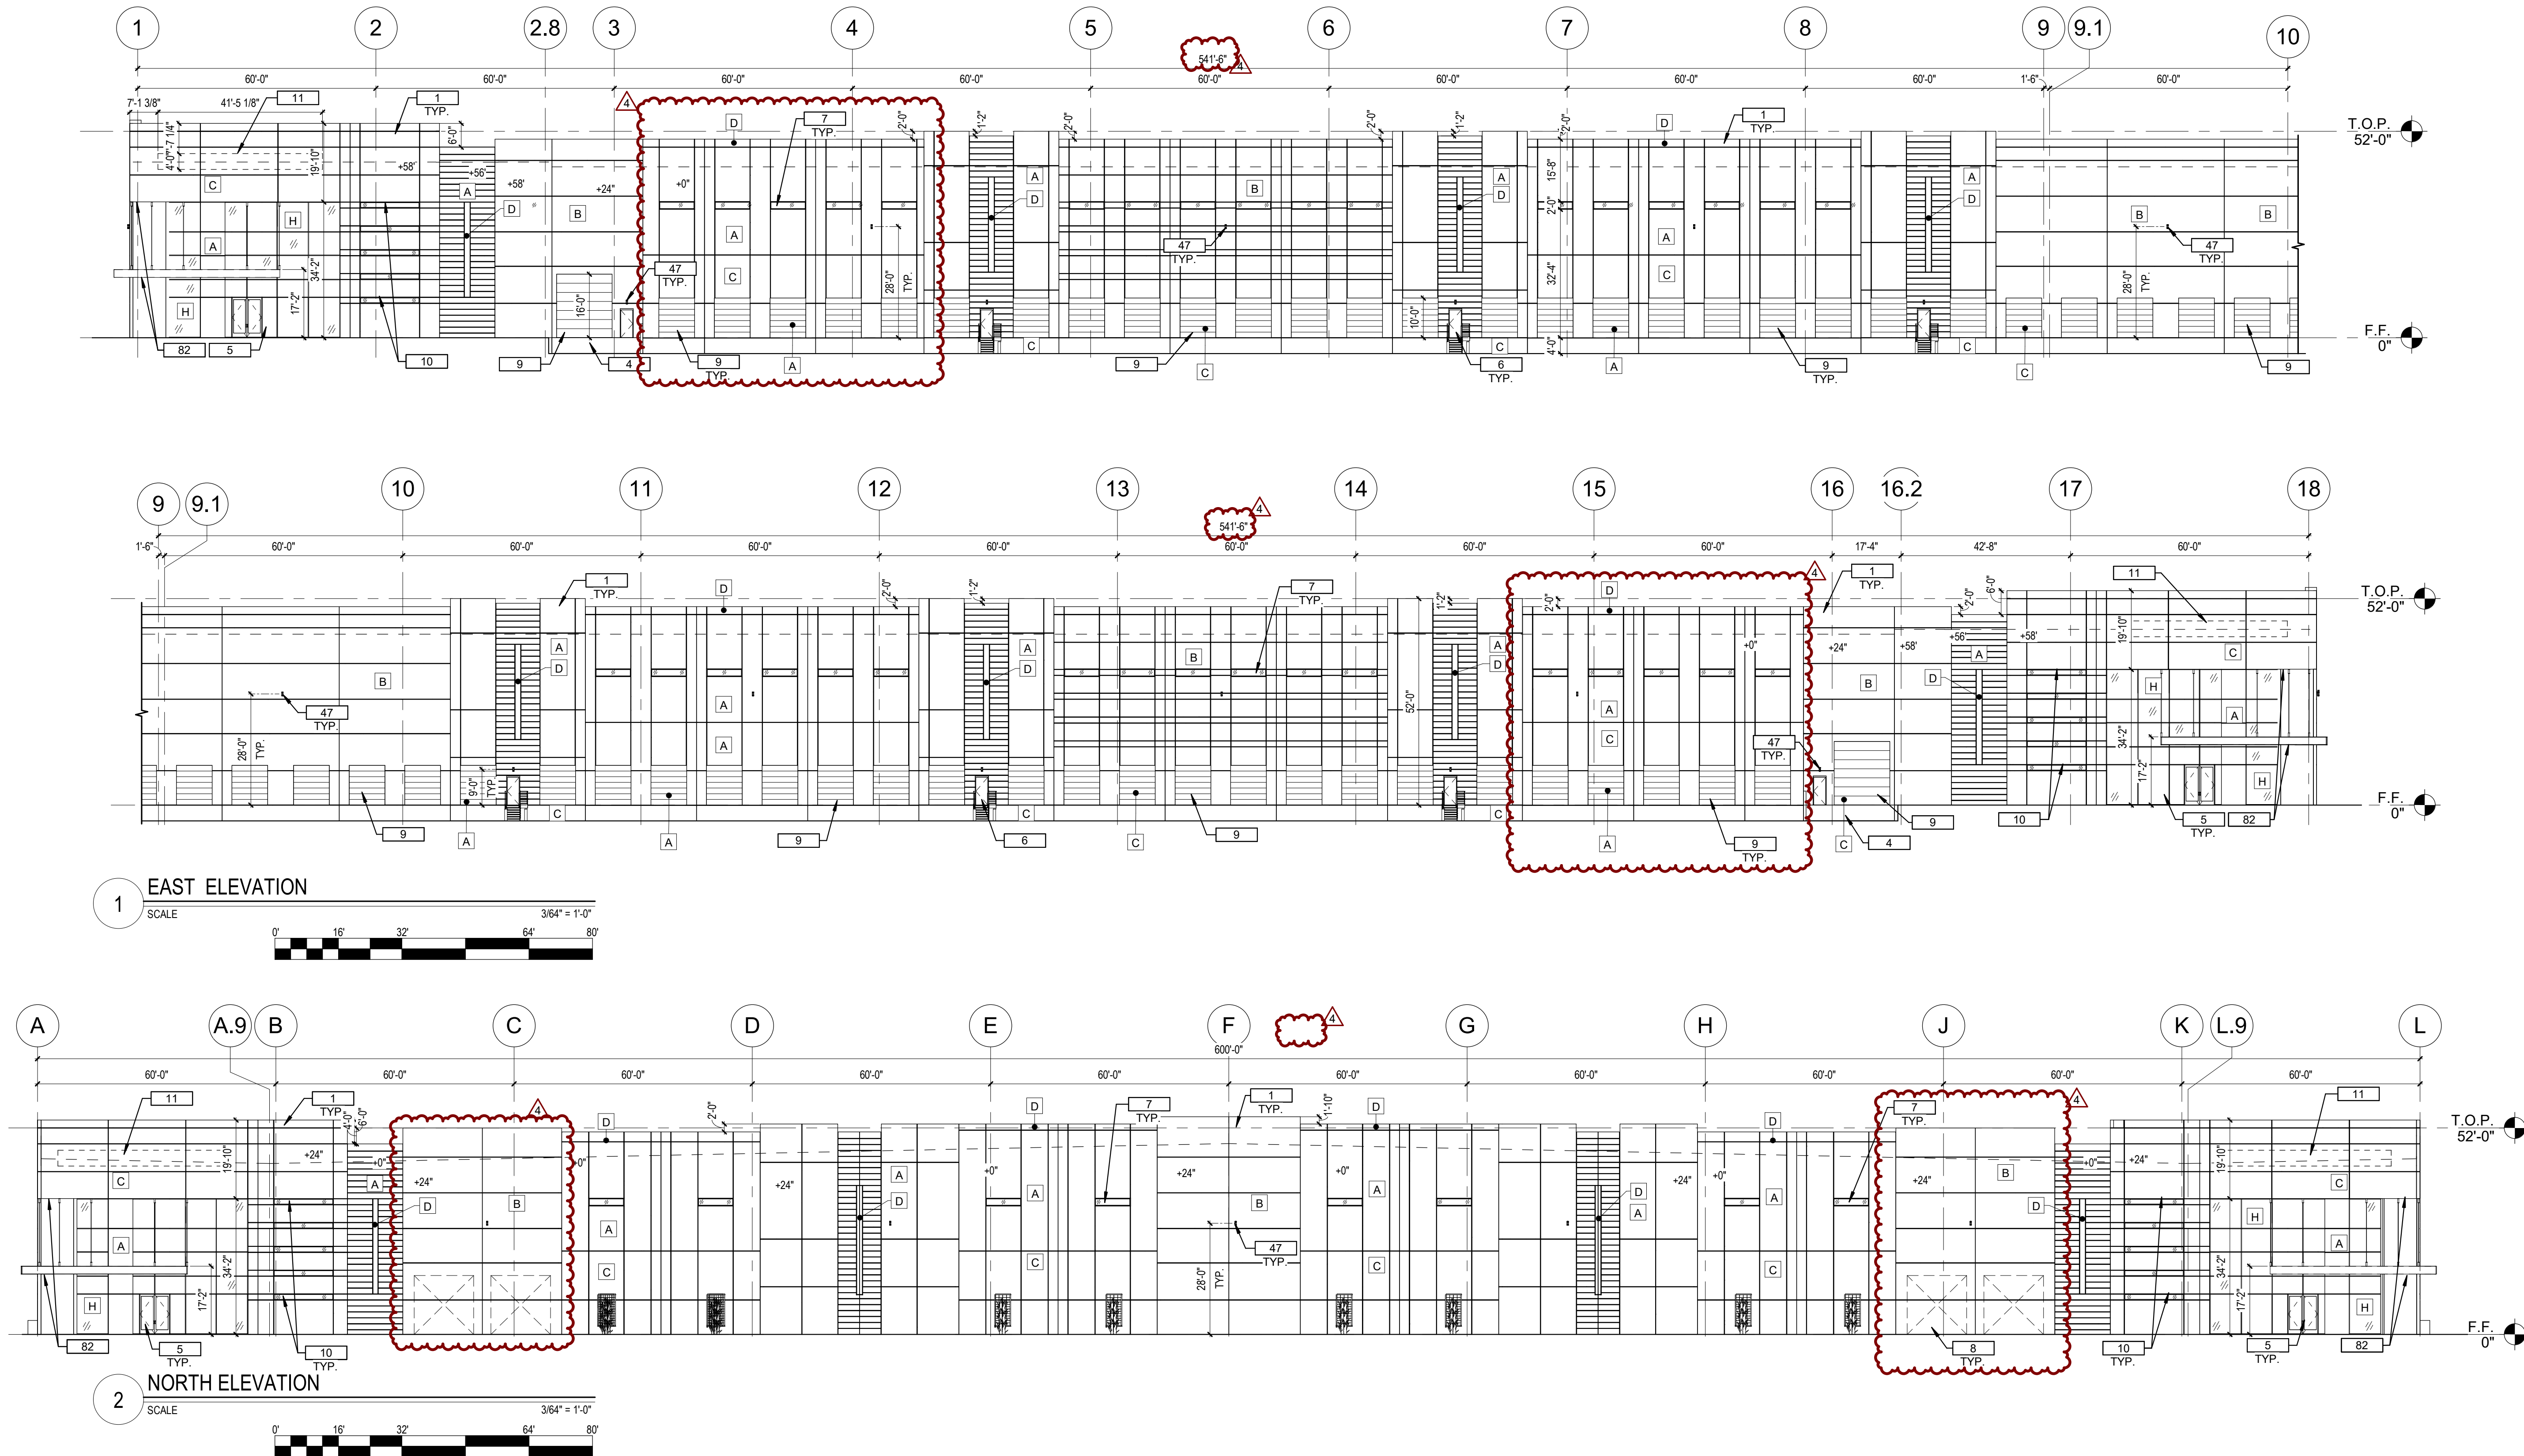


EAST ELEVATION			NORTH ELEVATION		
MATERIAL	AREA (SF)	%	MATERIAL	AREA (SF)	%
CONCRETE TILT WALL					
COLOR A	15994	31%	COLOR A	9914	0.30
COLOR B	11001	21%	COLOR B	7150	0.22
COLOR C	9656	19%	COLOR C	8478	0.26
COLOR D	1020	2%	COLOR D	628	0.02
CONCRETE TILT WALL W/FORMLINER					
COLOR A	4714	9%	COLOR A	2320	0.07
TRELLIS	0	0%	TRELLIS	384	0.01
WINDOWS	3707	7%	WINDOWS	3272	0.10
CORNICE	1060	2%	CANOPY	160	0.00
CANOPY	160	0%	CORNICE	796	0.02
OH DOOR	4588	9%	OH DOOR	0	0.00
HM DOOR	210	0%	HM DOOR	84	0.00
	52110	100%		33186	1.00

KEYNOTES	
1	EXTERIOR CONCRETE TILT PANEL WALL WITH REVEALS, TYP. PAINTED
4	CONCRETE BUILDING ACCESS RAMP
5	STOREFRONT ENTRY GLASS
6	FIRE ACCESS / EXIT MAIN DOORS - PAINTED
7	CLERESTORY WINDOWS
8	KNOCK OUT PANELS
9	OVERHEAD SECTIONAL DOOR, PAINTED
10	INSULATED GLASS WINDOWS
11	FUTURE COMPANY SIGN LOCATION
47	EXTERIOR WALL MOUNTED LIGHT FIXTURE - REFER TO ELECTRICAL PLANS
82	PRELIMINARY LED LIGHTS UNDER CANOPY AND OVERHANG. TYPICAL AT ALL CORNER ENTRY POINTS

EXTERIOR PAINT LEGEND	
A	DEW380 "WARM WHITE"
B	DET616 "EQUINOX"
C	DET610 "WOLVERINE"
D	DE5891 "INSPIRATION PEAK"
H	STOREFRONT SYSTEM 1" INSULATED GLAZING, SOLARCOOL (2) - SOLARBLUE, IN CLEAR ANNOZIDED ALUMINUM FRAME

CONCEPTUAL AND SCHEMATIC DESIGNS, INCLUDING RENDERINGS, ARE CREATED FOR THE SOLE PURPOSE OF DEVELOPING A DESIGN CONCEPT. THEY ARE PART OF THE OVERALL DESIGN PROCESS THAT ULTIMATELY LEADS TO MORE DETAILED DRAWINGS, BUT THE INFORMATION DEPICTED IN THESE DESIGNS IS INCOMPLETE AND NOT INTENDED TO REPRESENT THE FULL SCOPE OF THE PROJECT DESIGN. THE USE OF THESE CONCEPTUAL AND SCHEMATIC DESIGNS/RENDERINGS FOR ANY PURPOSE OTHER THAN AS INTENDED BY THE ARCHITECT IS PROHIBITED.

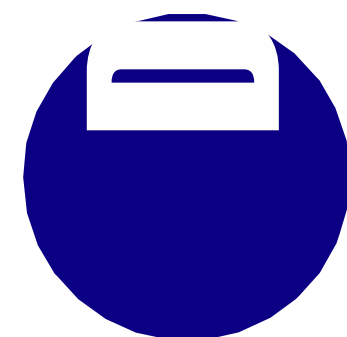

4600
EAST INDIAN SCHOOL RD
PHOENIX, ARIZONA 85018
602-840-2929 P

UNBOUND GATEWAY

BLDG C

SOSSAMAN AND PECOS

NOTICE OF EXTENSION, CERTIFICATION AND APPROVAL PERIOD: PROVISION: THIS CONTRACT ALLOWS THE OWNER TO CERTIFY AND APPROVE BILLINGS AND ESTIMATES WITHIN 30 DAYS AFTER THE BILLINGS AND ESTIMATES ARE RECEIVED FROM THE CONTRACTOR.




unbound
DEVELOPMENT

FIRST ISSUED: 06/16/21

REVISIONS		
No.	DATE	DESCRIPTION
1	8/9/21	1ST DRB COMMENTS
2	8/25/21	2ND DRB COMMENTS
3	12/2/21	3RD DRB COMMENTS
4	1/10/22	P&Z COMMENTS

PROJECT NO: 21108.00
DRAWN BY: DTC
CHECKED BY: DCAL
COPYRIGHT 2021: DEUTSCH ARCHITECTURE GROUP

EXTERIOR
ELEVATIONS

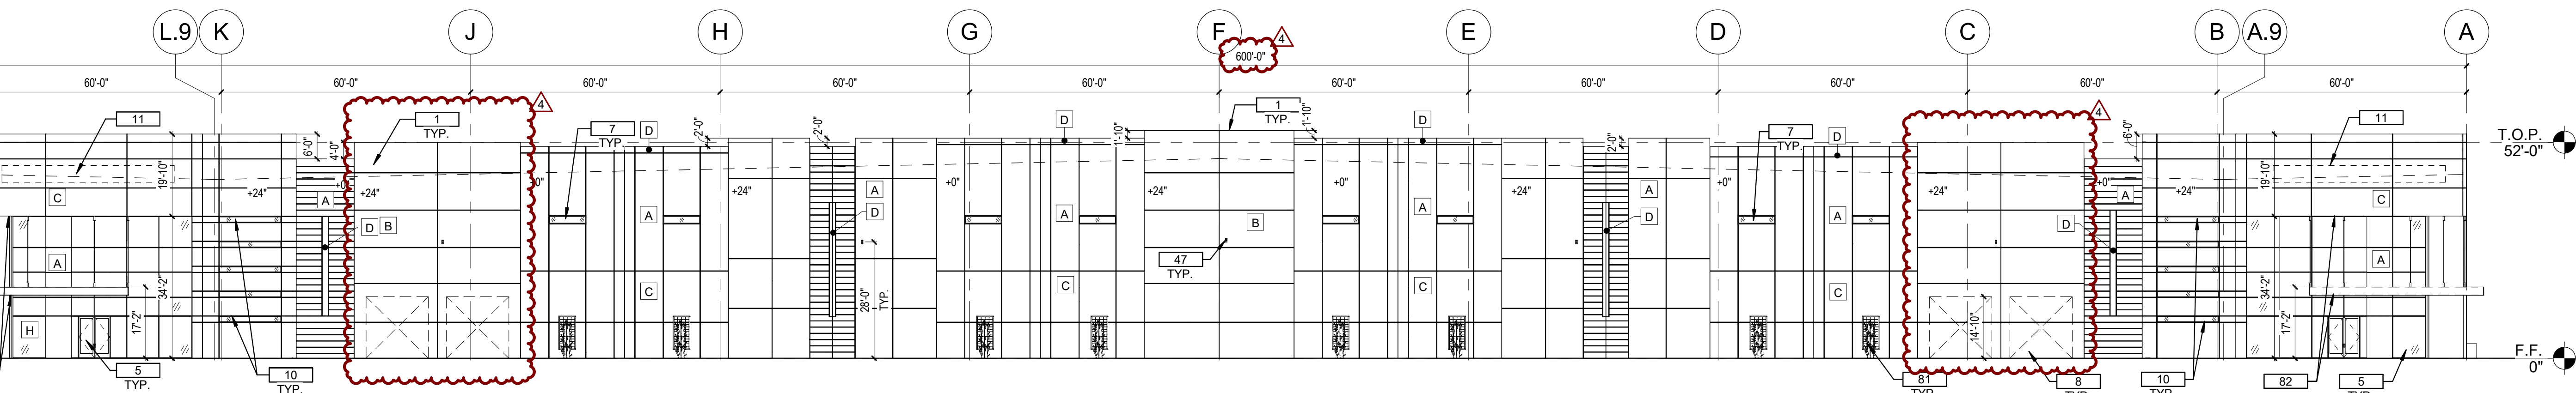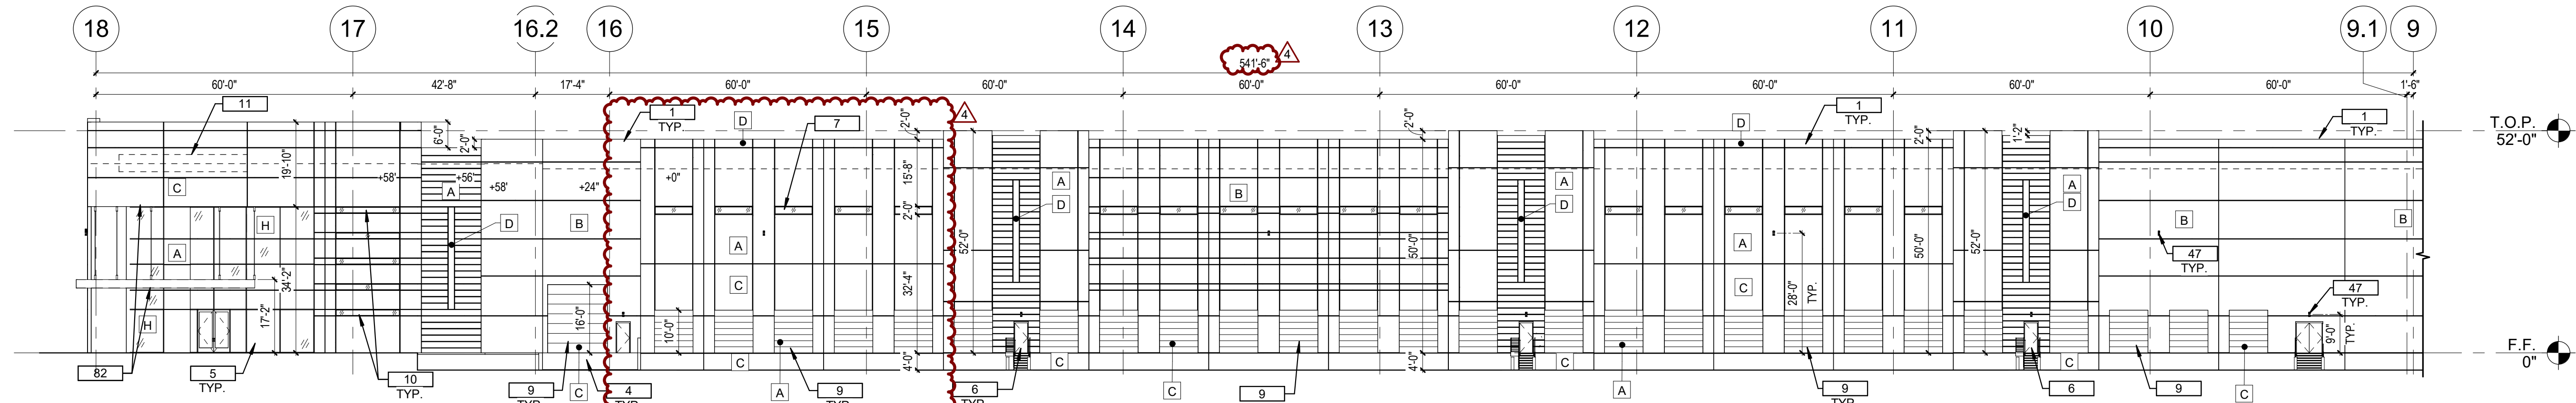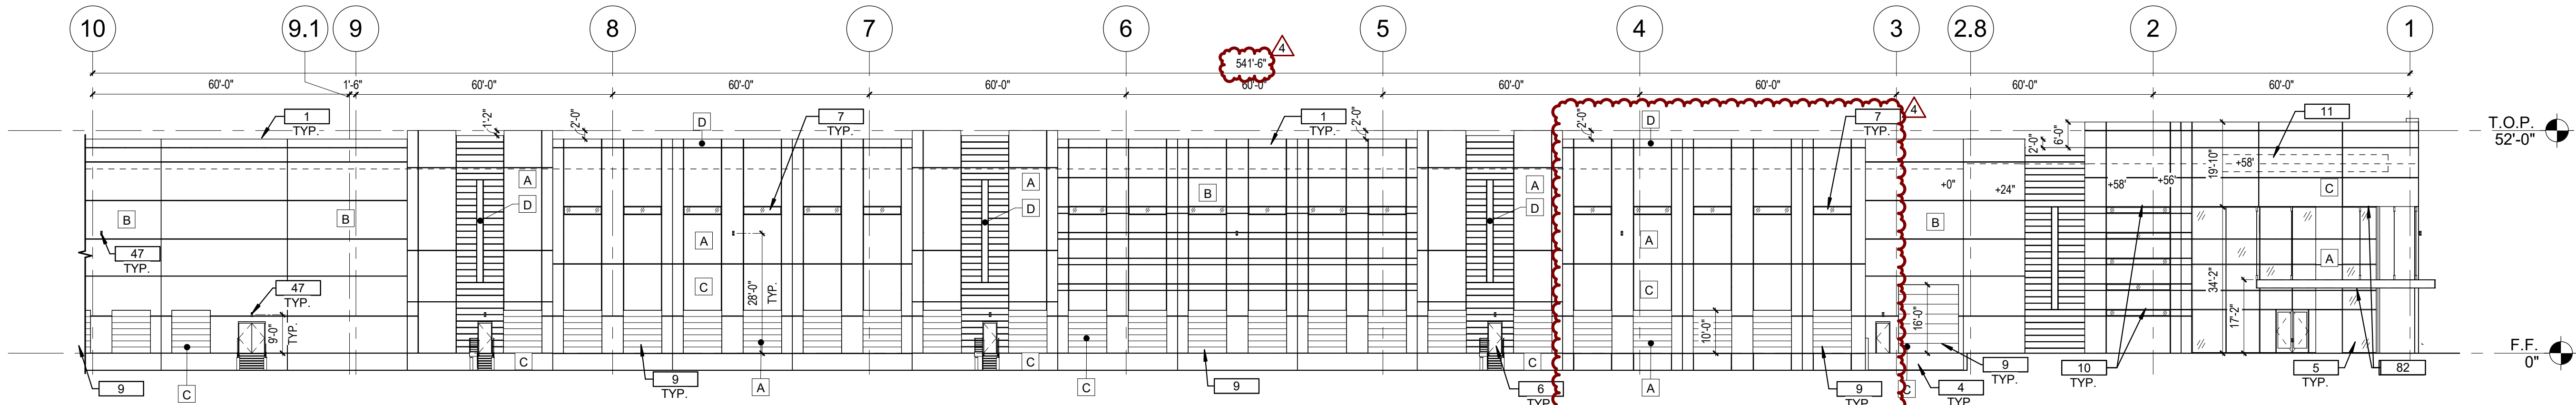


WEST ELEVATION		
MATERIAL	AREA (SF)	%
CONCRETE TILT WALL		
COLOR A	15994	31%
COLOR B	11153	21%
COLOR C	9656	19%
COLOR D	1020	2%
CONCRETE TILT WALL W/FORMLINER		
COLOR A	4714	9%
TRELLIS	0	0%
WINDOWS	3707	7%
CORNICE	1060	2%
CANOPY	160	0%
OH DOOR	4460	9%
HM DOOR	186	0%
	52110	100%

SOUTH ELEVATION		
MATERIAL	AREA (SF)	%
CONCRETE TILT WALL		
COLOR A	9914	0.30
COLOR B	7150	0.22
COLOR C	8478	0.26
COLOR D	628	0.02
CONCRETE TILT WALL W/FORMLINER		
COLOR A	2320	0.07
TRELLIS	384	0.01
WINDOWS	3272	0.10
CANOPY	160	0.00
CORNICE	796	0.02
OH DOOR	0	0.00
HM DOOR	84	0.00
	33186	1.00

KEYNOTES	
1	EXTERIOR CONCRETE TILT PANEL WALL WITH REVEALS, TYP. PAINTED
4	CONCRETE BUILDING ACCESS RAMP
5	STOREFRONT ENTRY GLASS
6	FIRE ACCESS / EXIT MAN DOORS - PAINTED
7	CLERESTORY WINDOWS
8	KNOCK OUT PANELS
9	OVERHEAD SECTIONAL DOOR, PAINTED
10	INSULATED GLASS WINDOWS
11	FUTURE COMPANY SIGN LOCATION
47	EXTERIOR WALL MOUNTED LIGHT FIXTURE - REFER TO ELECTRICAL PLANS
81	STEEL TRELLIS WITH CLIMBING VINES
82	PRELIMINARY LED LIGHTS UNDER CANOPY AND OVERHANG. TYPICAL AT ALL CORNER ENTRY POINTS

EXTERIOR PAINT LEGEND	
A	DEW380 "WARM WHITE"
B	DET616 "EQUINOX"
C	DET610 "WOLVERINE"
D	DE5891 "INSPIRATION PEAK"
H	STOREFRONT SYSTEM 1" INSULATED GLAZING, SOLARCOOL (2) - SOLARBLUE, IN CLEAR ANNOZIDED ALUMINUM FRAME

CONCEPTUAL AND SCHEMATIC DESIGNS, INCLUDING RENDERINGS, ARE CREATED FOR THE SOLE PURPOSE OF DEVELOPING A DESIGN CONCEPT. THEY ARE PART OF THE OVERALL DESIGN PROCESS THAT ULTIMATELY LEADS TO MORE DETAILED DRAWINGS, BUT THE INFORMATION DEPICTED IN THESE DESIGNS IS INCOMPLETE AND NOT INTENDED TO REPRESENT THE FULL SCOPE OF THE PROJECT DESIGN. THE USE OF THESE CONCEPTUAL AND SCHEMATIC DESIGNS/RENDERINGS FOR ANY PURPOSE OTHER THAN AS INTENDED BY THE ARCHITECT IS PROHIBITED.

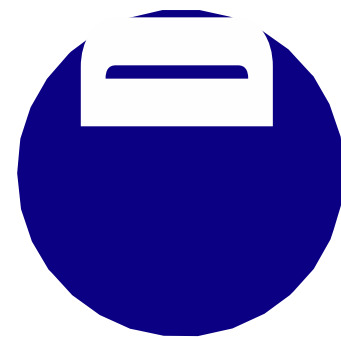

4600
EAST INDIAN SCHOOL RD
PHOENIX, ARIZONA 85018
602-840-2828 P

**UNBOUND GATEWAY
BLDG C**
SOSSAMAN AND PECOS


unbound
DEVELOPMENT

FIRST ISSUED: 06/16/21

REVISIONS		
No.	DATE	DESCRIPTION
1	8/9/21	1ST DRB COMMENTS
2	8/25/21	2ND DRB COMMENTS
3	12/2/21	3RD DRB COMMENTS
4	1/10/22	P&Z COMMENTS

PROJECT NO: 21108.00
DRAWN BY: DTC
CHECKED BY: DCAL
COPYRIGHT 2021: DEUTSCH ARCHITECTURE GROUP


**EXTERIOR
ELEVATIONS**

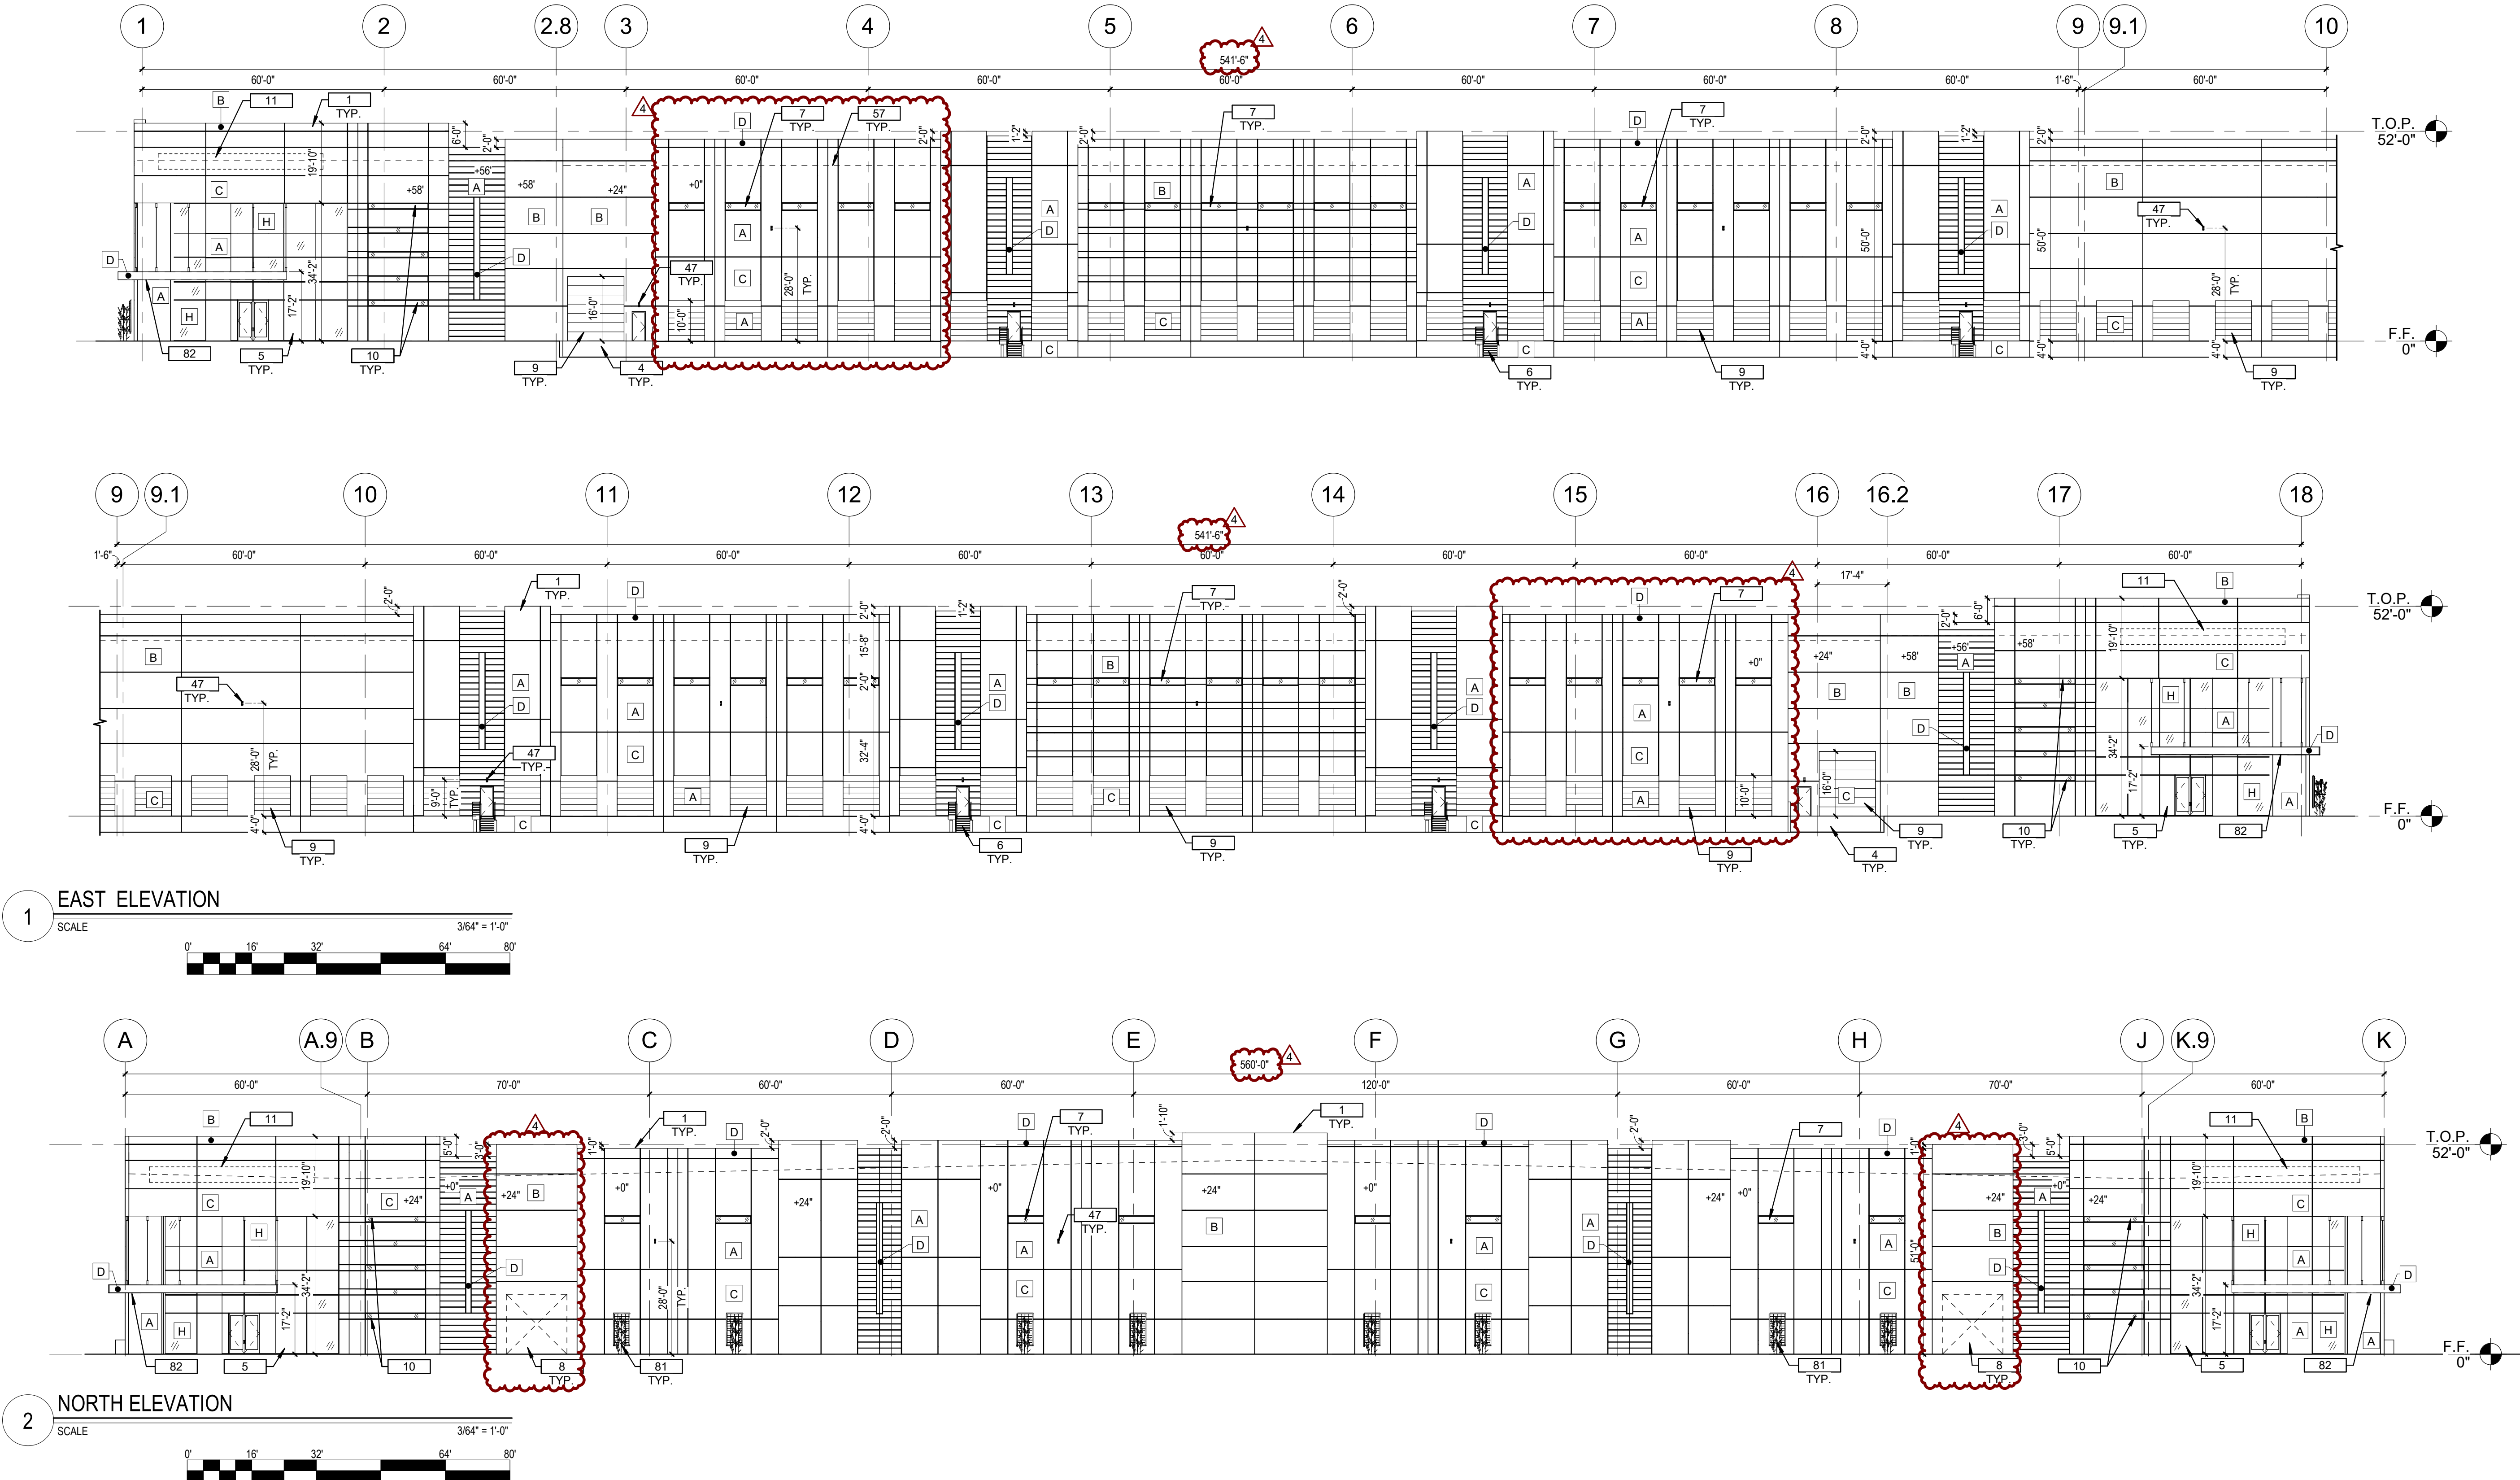

EAST ELEVATION			NORTH ELEVATION		
MATERIAL	AREA (SF)	%	MATERIAL	AREA (SF)	%
CONCRETE TILT WALL					
COLOR A	15994	31%	COLOR A	9914	0.30
COLOR B	11001	21%	COLOR B	7150	0.22
COLOR C	9656	19%	COLOR C	8478	0.26
COLOR D	1020	2%	COLOR D	628	0.02
CONCRETE TILT WALL W/FORMLINER					
COLOR A	4714	9%	COLOR A	2320	0.07
TRELLIS	0	0%	TRELLIS	384	0.01
WINDOWS	3707	7%	WINDOWS	3272	0.10
CORNICE	1060	2%	CANOPY	160	0.00
CANOPY	160	0%	CORNICE	796	0.02
OH DOOR	4588	9%	OH DOOR	0	0.00
HM DOOR	210	0%	HM DOOR	84	0.00
	52110	100%		33186	1.00

KEYNOTES		EXTERIOR PAINT LEGEND	
1	EXTERIOR CONCRETE TILT PANEL WALL WITH REVEALS, TYP. PAINTED	A	DEW380 "WARM WHITE"
4	CONCRETE BUILDING ACCESS RAMP	B	DET616 "EQUINOX"
5	STOREFRONT ENTRY GLASS	C	DET610 "WOLVERINE"
6	FIRE ACCESS / EXIT MAN DOORS - PAINTED	D	DE5891 "INSPIRATION PEAK"
7	CLERESTORY WINDOWS	H	STOREFRONT SYSTEM 1" INSULATED GLAZING, SOLARCOOL (2) - SOLARBLUE, IN CLEAR ANNOZIDED ALUMINUM FRAME
8	KNOCK OUT PANELS		
9	OVERHEAD SECTIONAL DOOR, PAINTED		
10	INSULATED GLASS WINDOWS		
11	FUTURE COMPANY SIGN LOCATION		
47	EXTERIOR WALL MOUNTED LIGHT FIXTURE - REFER TO ELECTRICAL PLANS		
57	LINE OF ROOF BEYOND		
81	STEEL TRELLIS WITH CLIMBING VINES		
82	PRELIMINARY LED LIGHTS UNDER CANOPY AND OVERHANG, TYPICAL AT ALL CORNER ENTRY POINTS		

CONCEPTUAL AND SCHEMATIC DESIGNS, INCLUDING RENDERINGS, ARE CREATED FOR THE SOLE PURPOSE OF DEVELOPING A DESIGN CONCEPT. THEY ARE PART OF THE OVERALL DESIGN PROCESS THAT ULTIMATELY LEADS TO MORE DETAILED DRAWINGS, BUT THE INFORMATION DEPICTED IN THESE DESIGNS IS INCOMPLETE AND NOT INTENDED TO REPRESENT THE FULL SCOPE OF THE PROJECT DESIGN. THE USE OF THESE CONCEPTUAL AND SCHEMATIC DESIGNS/RENDERINGS FOR ANY PURPOSE OTHER THAN AS INTENDED BY THE ARCHITECT IS PROHIBITED.

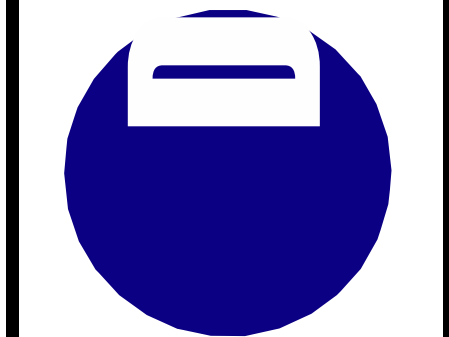

4600
EAST INDIAN SCHOOL RD
PHOENIX, ARIZONA 85018
602-840-2829 P

UNBOUND GATEWAY
BLDG D
SOSSAMAN AND PECOS




FIRST ISSUED: XX/XX/XX

REVISIONS		
No.	DATE	DESCRIPTION
1	8/9/21	1ST DRB COMMENTS
2	8/25/21	2ND DRB COMMENTS
3	12/2/21	3RD DRB COMMENTS
4	1/10/22	P&Z COMMENTS

PROJECT NO: 21108.00
DRAWN BY: DTC
CHECKED BY: DCAL
COPYRIGHT 2021: DEUTSCH ARCHITECTURE GROUP

EXTERIOR ELEVATIONS

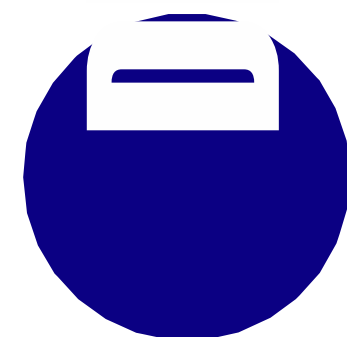

4600
EAST INDIAN SCHOOL RD
PHOENIX, ARIZONA 85018
602-840-2828 P

UNBOUND GATEWAY

BLDG D

SOSSAMAN AND PECOS

NOTICE OF EXTERIOR CERTIFICATION AND APPROVAL: THIS CONTRACTOR HAS REVIEWED THE EXTERIOR ELEVATIONS AND APPROVES THE DESIGN AND MATERIALS. FROM THE CONTRACTOR

unbound
DEVELOPMENT

FIRST ISSUED: 06/16/21

REVISIONS

No.	DATE	DESCRIPTION
1	8/9/21	1ST DRB COMMENTS
2	8/25/21	2ND DRB COMMENTS
3	12/2/21	3RD DRB COMMENTS
4	1/10/22	P&Z COMMENTS

PROJECT NO: 21108.00

DRAWN BY: DTC


CHECKED BY: DCAL

COPYRIGHT 2021: DEUTSCH ARCHITECTURE GROUP

EXTERIOR
ELEVATIONS


A-211

21108.00-UNBOUND GATEWAY-PRS21-00272

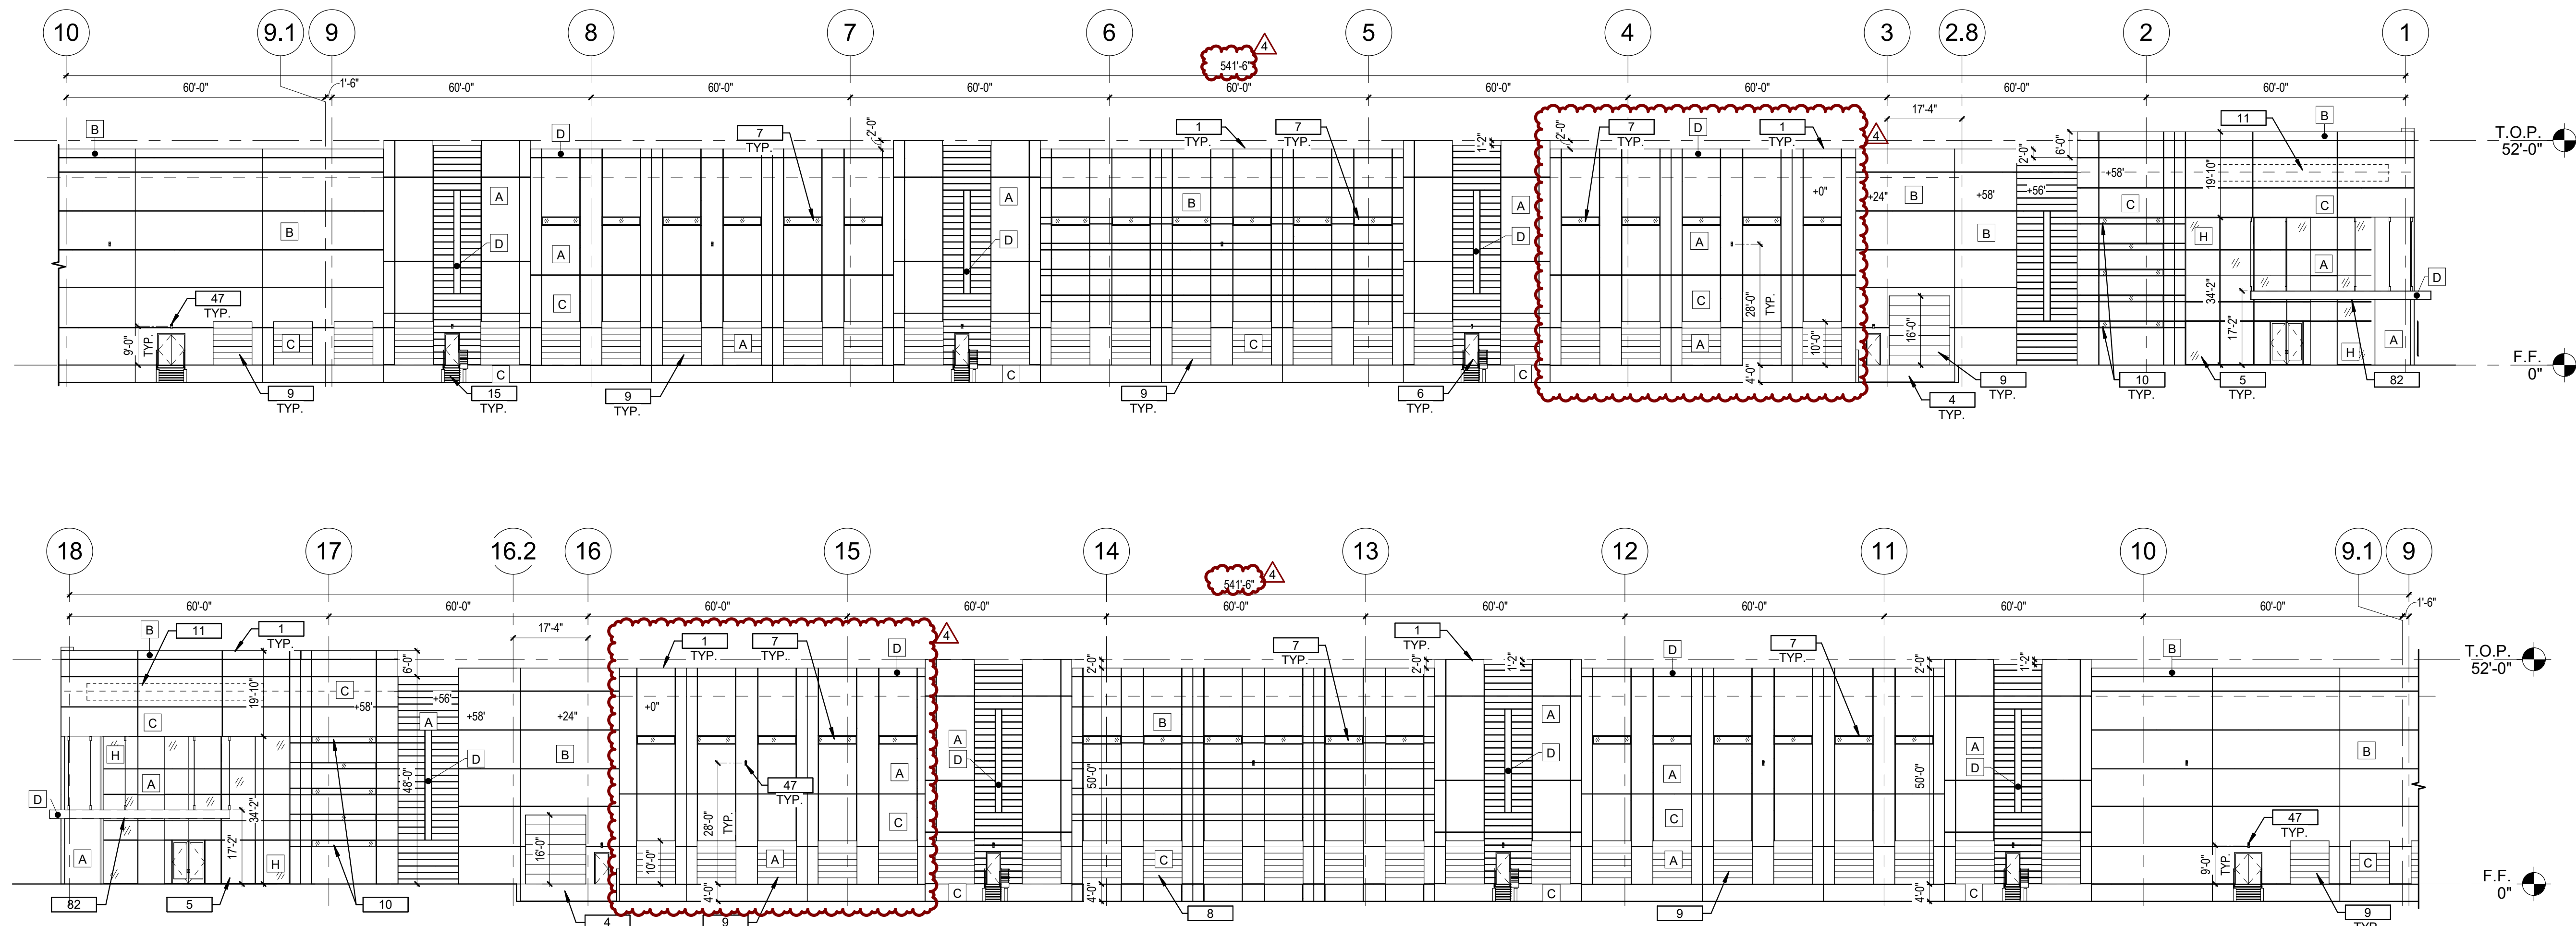


1 WEST ELEVATION

 SCALE



2 SOUTH ELEVATION

 SCALE



WEST ELEVATION		
MATERIAL	AREA (SF)	%
CONCRETE TILT WALL		
COLOR A	15994	31%
COLOR B	11153	21%
COLOR C	9656	19%
COLOR D	1020	2%
CONCRETE TILT WALL W/FORMLINER		
COLOR A	4714	9%
TRELLIS	0	0%
WINDOWS	3707	7%
CORNICE	1060	2%
CANOPY	160	0%
OH DOOR	4460	9%
HM DOOR	186	0%
	52110	100%

SOUTH ELEVATION		
MATERIAL	AREA (SF)	%
CONCRETE TILT WALL		
COLOR A	9914	0.30
COLOR B	7150	0.22
COLOR C	8478	0.26
COLOR D	628	0.02
CONCRETE TILT WALL W/FORMLINER		
COLOR A	2320	0.07
TRELLIS	384	0.01
WINDOWS	3272	0.10
CANOPY	160	0.00
CORNICE	796	0.02
OH DOOR	0	0.00
HM DOOR	84	0.00
	33186	1.00

KEYNOTES

- EXTERIOR CONCRETE TILT PANEL WALL WITH REVEALS, TYP. PAINTED
- CONCRETE BUILDING ACCESS RAMP
- STOREFRONT ENTRY GLASS
- FIRE ACCESS / EXIT MAN DOORS - PAINTED
- CLERESTORY WINDOWS
- KNOCK OUT PANELS
- OVERHEAD SECTIONAL DOOR, PAINTED
- INSULATED GLASS WINDOWS
- FUTURE COMPANY SIGN LOCATION
- EXTERIOR MAN ACCESS DOOR - PAINTED TO MATCH ADJACENT WALL FINISH, TYP
- EXTERIOR WALL MOUNTED LIGHT FIXTURE - REFER TO ELECTRICAL PLANS
- STEEL TRELLIS WITH CLIMBING VINES
- PRELIMINARY LED LIGHTS UNDER CANOPY AND OVERHANG, TYPICAL AT ALL CORNER ENTRY POINTS

EXTERIOR PAINT LEGEND

- A DEW380 "WARM WHITE"
- B DET616 "EQUINOX"
- C DET610 "WOLVERINE"
- D DE5891 "INSPIRATION PEAK"
- H STOREFRONT SYSTEM
1" INSULATED GLAZING, SOLARCOOL (2) - SOLARBLUE, IN CLEAR ANNOZIDED ALUMINUM FRAME

CONCEPTUAL AND SCHEMATIC DESIGNS, INCLUDING RENDERINGS, ARE CREATED FOR THE SOLE PURPOSE OF DEVELOPING A DESIGN CONCEPT. THEY ARE PART OF THE OVERALL DESIGN PROCESS THAT ULTIMATELY LEADS TO MORE DETAILED DRAWINGS, BUT THE INFORMATION DEPICTED IN THESE DESIGNS IS INCOMPLETE AND NOT INTENDED TO REPRESENT THE FULL SCOPE OF THE PROJECT DESIGN. THE USE OF THESE CONCEPTUAL AND SCHEMATIC DESIGNS/RENDERINGS FOR ANY PURPOSE OTHER THAN AS INTENDED BY THE ARCHITECT IS PROHIBITED.