

This document, including the ideas and designs it contains, is an instrument of professional services rendered by the RMA Design Group, L.L.C. This document may not be used or copied in whole, or in part, for any purpose other than this specific project without the expressed written consent of RMA Architects, L.L.C.



PROPOSED NORTH WEST ELEVATION

SCALE: 1/4"=1'-0"



PROPOSED SOUTH WEST ELEVATION

SCALE: 1/4"=1'-0"

NOTE:
PLANTS AND TREES SHOWN ON THIS SHEET
ARE FOR REFERENCE ONLY

SEAL



229 Sawtooth Mountain Wy
Dripping Springs, Texas 78620
(T) 623-252-8340

www.rmadesigngroup.com

A NEW ADDITION FOR:
SUNFLOWER CREMATION AND BURIAL
5650 E. MAIN ST.
MESA, AZ

PROPOSED 3D ELEVATIONS

PROJECT NUMBER	REVISION / MILESTONE DESCRIPTION	DATE
DRAWN BY BP		
CHECKED BY RM		
ISSUE DATE		
SCALE		
AS SHOWN		

SHEET NUMBER

DR-5

This document, including the ideas and designs it contains, is an instrument of professional services rendered by the RMA Design Group, L.L.C. This document may not be used or copied in whole or in part, for any purpose other than the expressed written consent of RMA Architects, L.L.C.




EAST ELEVATION 1260 SQUARE FEET OF SURFACE AREA

- CHARCOAL BASE (5'-4") 373 S.F./29%
- LIGHT GRAY FIELD BAND (6'-8") 467 S.F./37%
- RED ACCENT BAND (1'-4") 94 S.F./7%
- LIGHT GRAY ACCENT (2'-8") 186 S.F./16%
- MEDIUM GRAY ACCENT (8") 46 S.F./4%
- CHARCOAL TOP BAND (1'-4") 94 S.F./7%
- (INCLUDES PAINTED METAL EDGE TRIM)

PROPOSED WEST ELEVATION

SCALE: 3/16" = 1'-0"

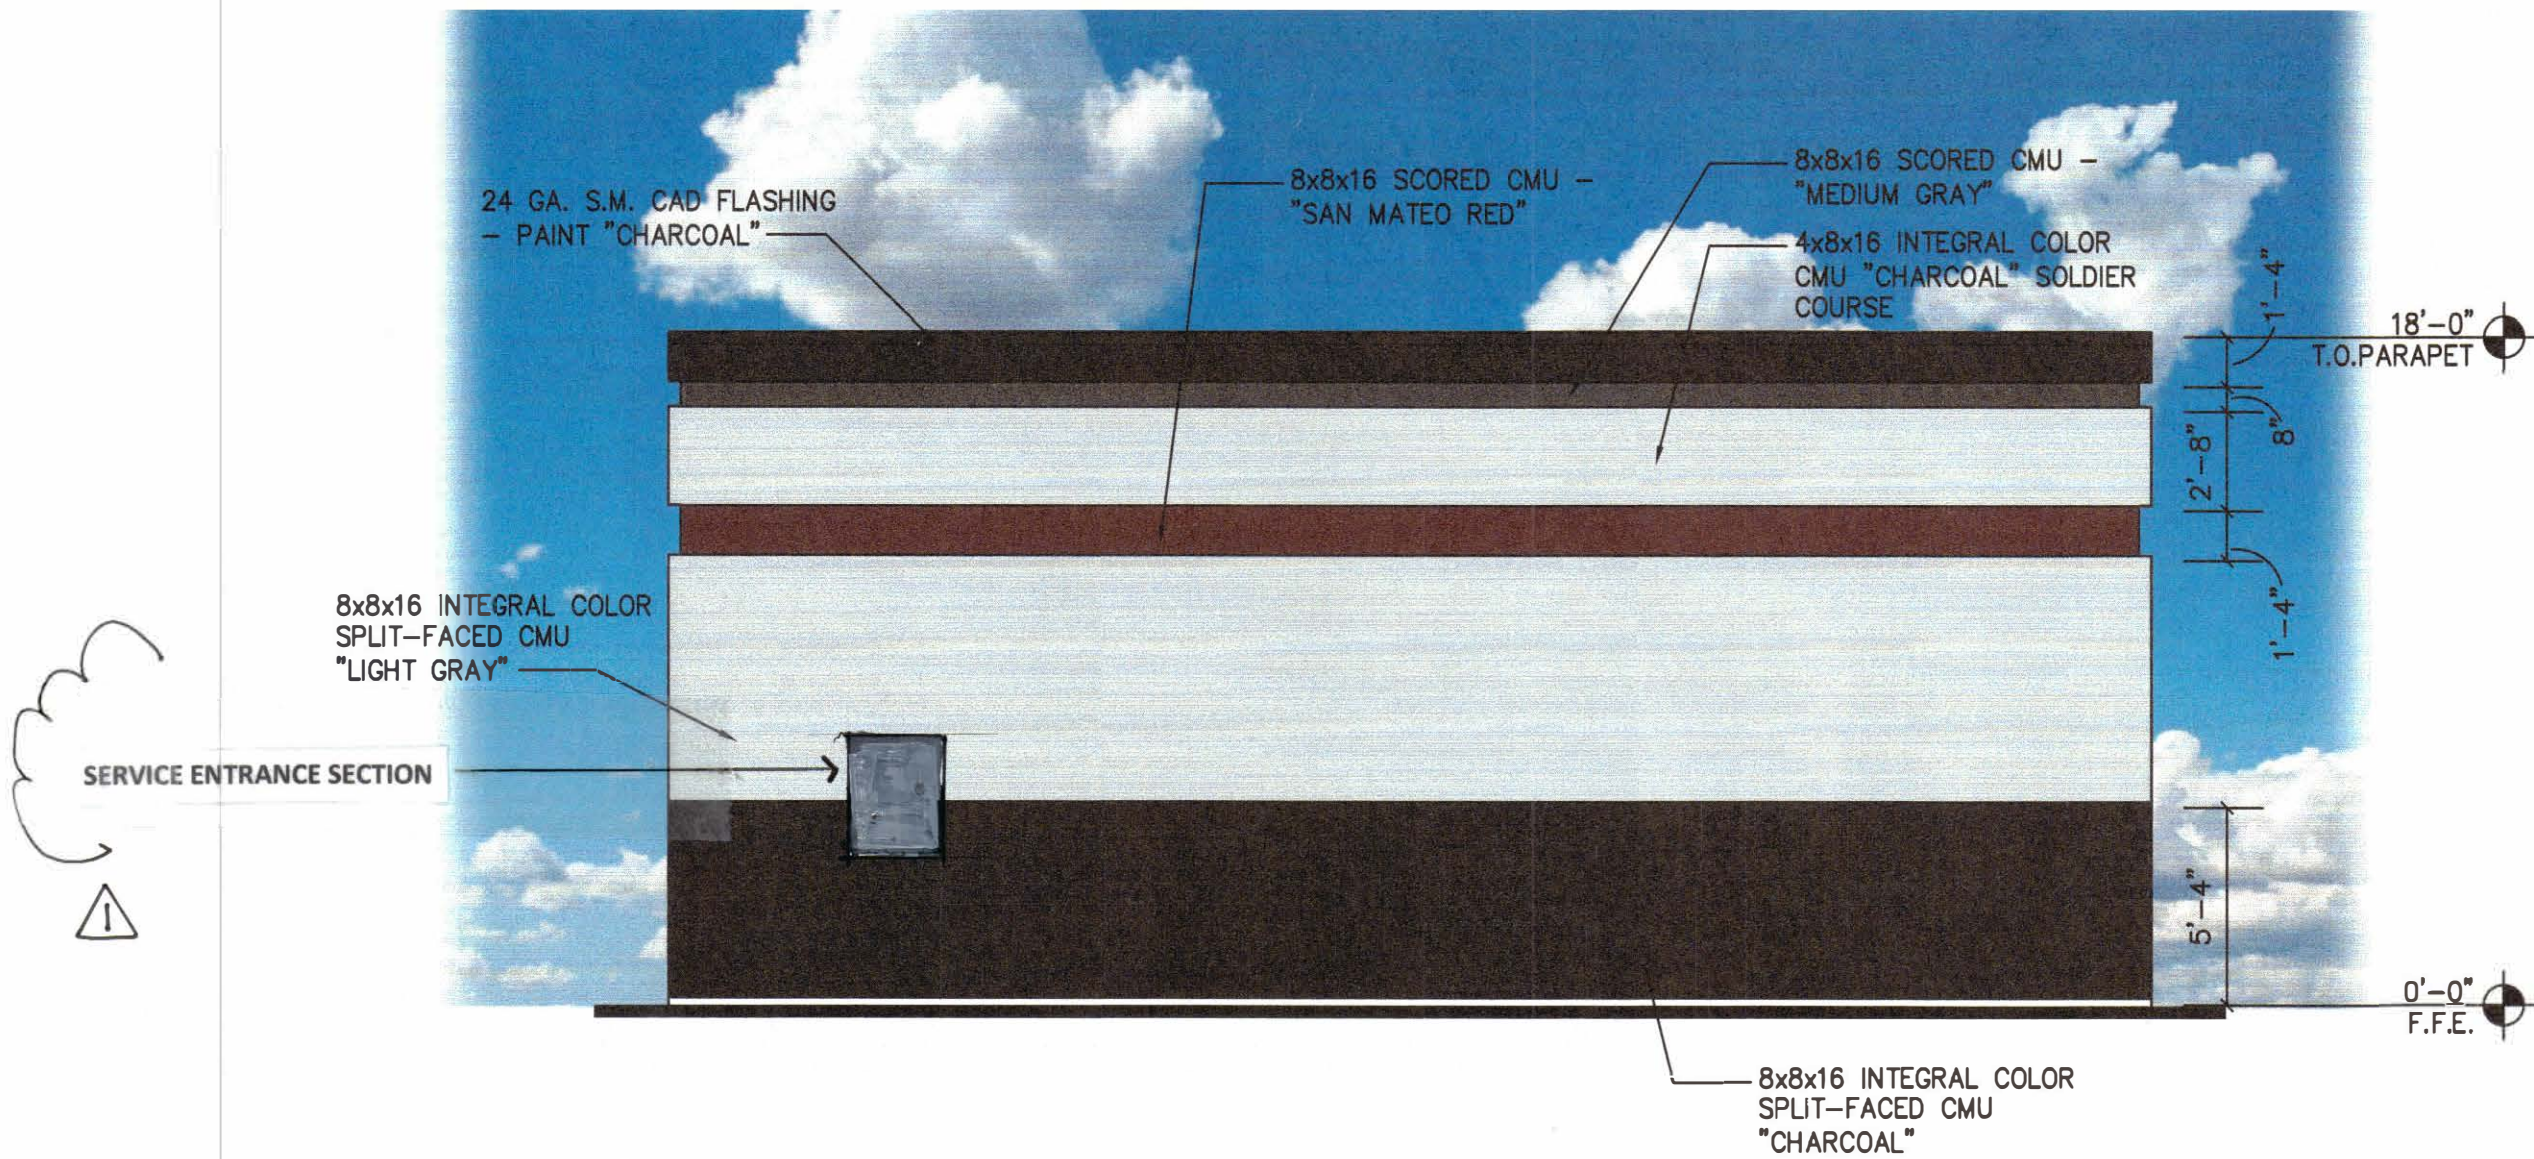

NORTH ELEVATION 696 SQUARE FEET OF SURFACE AREA

- CHARCOAL BASE (5'-4") 206 S.F./31%
- LIGHT GRAY FIELD BAND (6'-8") 258 S.F./37%
- RED ACCENT BAND (1'-4") 52 S.F./7%
- LIGHT GRAY ACCENT (2'-8") 102 S.F./14%
- MEDIUM GRAY ACCENT (8") 26 S.F. 4%
- CHARCOAL TOP BAND (1'-4") 52 S.F. 7%
- (INCLUDES PAINTED METAL EDGE TRIM)

PROPOSED NORTH ELEVATION

SCALE: 3/16" = 1'-0"

SEAL

229 Sawtooth Mountain Wy
Dripping Springs, Texas 78620
(T) 623-252-8340

www.madesigngroup.com

A NEW ADDITION FOR:

SUNFLOWER CREMATION AND BURIAL

5650 E. MAIN ST.
MESA, AZ

EXTERIOR ELEVATIONS



NUMBER	REVISION / MILESTONE DESCRIPTION	DATE
1	CITY CORRECTIONS	5/1/23

PROJECT NUMBER	DRAWN BY	CHECKED BY	ISSUE DATE	SCALE	AS SHOWN
	BP	RM			

DR-5



This document, including the ideas and designs it contains, is an instrument of professional services rendered by the RMA Design Group, LLC. This document may not be used or copied in whole, or in part, for any purpose other than this specific project without the expressed written consent of RMA Architects, LLC.

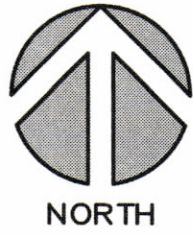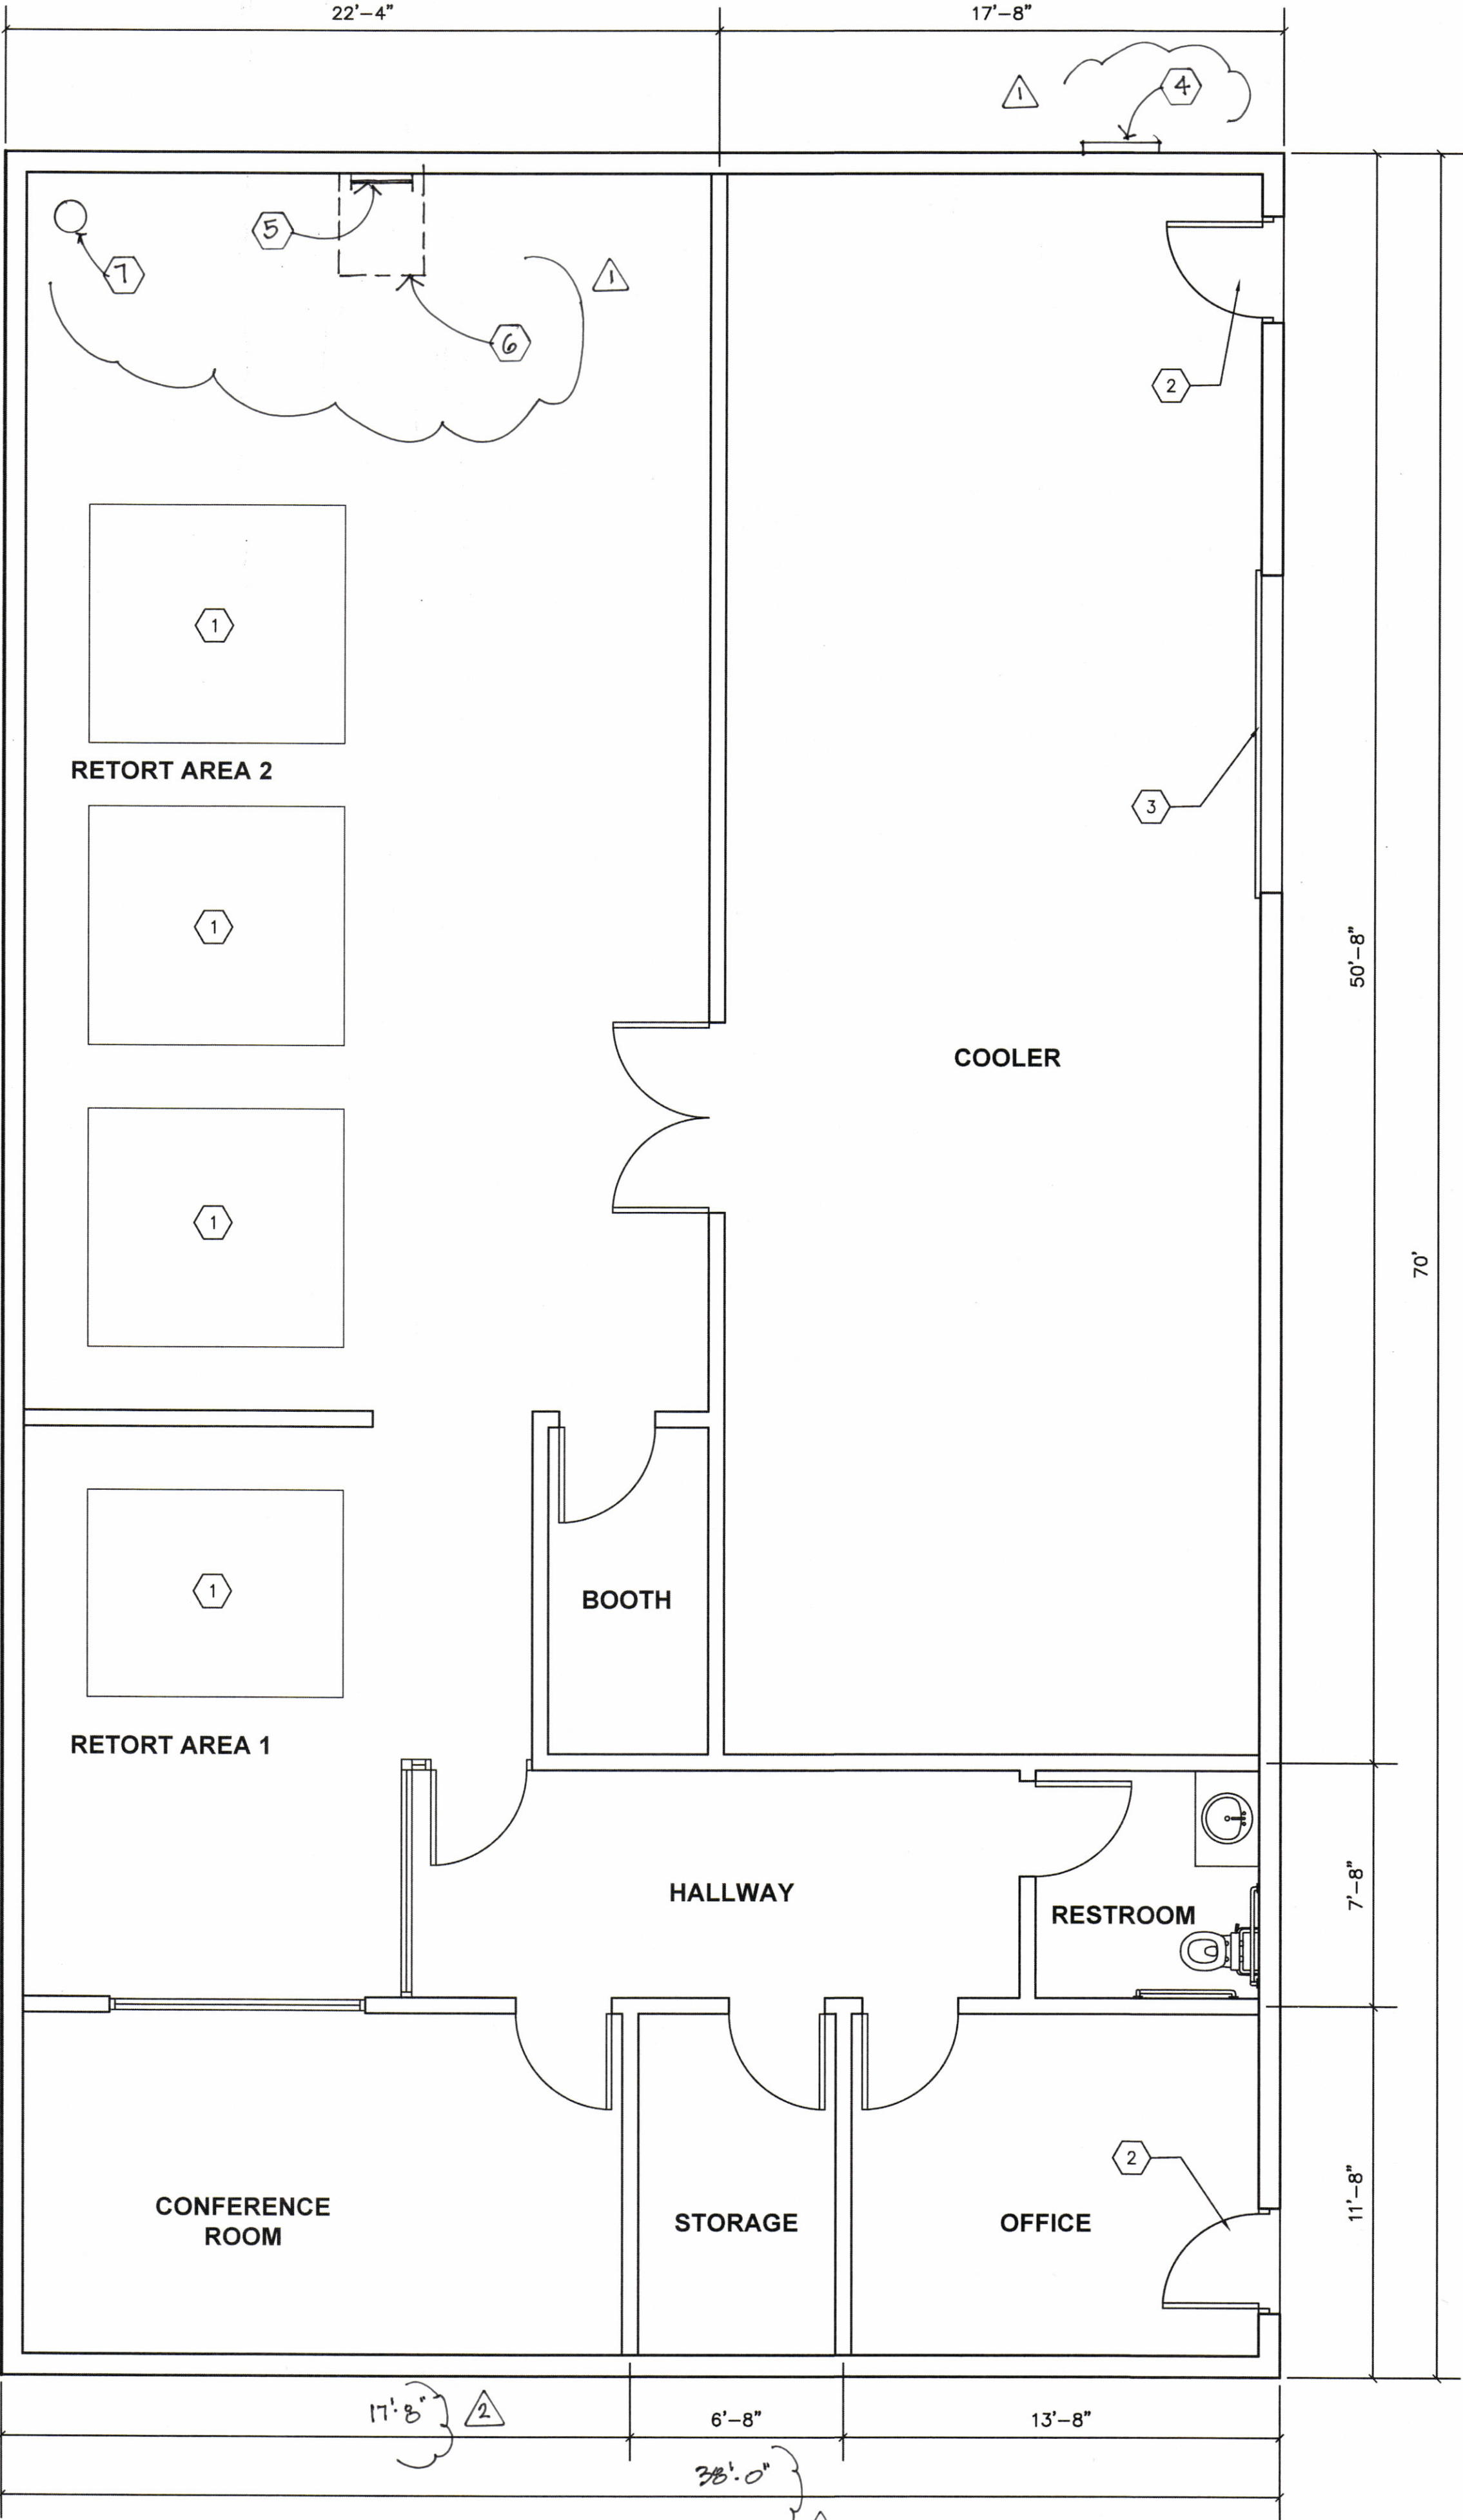

PROPOSED FLOOR PLAN

SCALE: 1/4"=1'-0"

KEYNOTES

1. RETORT MACHINE
2. 3'-1" MAN DOOR
3. 10'x12' O.H. DOOR
4. SERVICE ENTRANCE SECTION
5. ROOF ACCESS LADDER
6. ROOF HATCH ABOVE
7. FIRE SPRINKLER RISER

NOTE: ALL DOWNSPOUTS TO BE LOCATED INTERNALLY

SEAL

229 Sawtooth Mountain Wy
Dripping Springs, Texas
78620
(T) 623-252-8340

www.rmadesigngroup.com

A NEW ADDITION FOR:
SUNFLOWER CREMATION AND BURIAL
5650 E. MAIN ST.
MESA, AZ

PROPOSED FLOOR PLAN

NUMBER	REVISION / MILESTONE DESCRIPTION	DATE
1	CITY CORRECTION	5/1/23
2	DESIGN CORRECTION TO MAROLA SITE PLAN	5/1/23

PROJECT NUMBER	DRAWN BY	CHECKED BY	SCALE	AS SHOWN
	BP	RM		
SHEET NUMBER				

DR-2