



Devenney Group Ltd., Architects
 6900 East Camelback Road
 Suite 500
 Scottsdale, AZ 85251
 T: 602.943.8950
 www.devenneygroup.com

Consultant:

**PRELIMINARY
NOT FOR
CONSTRUCTION**

IF THESE PLANS DO NOT BEAR THE SEAL OF A REGISTRANT, THEY ARE TO BE CONSIDERED "PRELIMINARY" AND ARE NOT TO BE USED FOR CONSTRUCTION OR RECORDING. THESE PLANS ARE COPYRIGHTED AND ARE SUBJECT TO COPYRIGHT PROTECTION AS AN "ARCHITECTURAL WORK" UNDER SEC. 102 OF THE COPYRIGHT ACT, 17 U.S.C. AS AMENDED DECEMBER 1990 AND KNOWN AS ARCHITECTURAL WORKS COPYRIGHT PROTECTION ACT OF 1990. THE PROTECTION INCLUDES BUT IS NOT LIMITED TO THE OVERALL FORM AS WELL AS THE ARRANGEMENT AND COMPOSITION OF SPACES AND ELEMENTS OF THE DESIGN. UNDER SUCH PROTECTION, UNAUTHORIZED USE OF THESE PLANS CAN LEGALLY RESULT IN THE CESSION OF CONSTRUCTION OR BUILDINGS BEING SEIZED AND/OR MONETARY COMPENSATION TO DEVENNEY GROUP LTD.

**EAST MESA
HEALTH CLINIC**
 PARCEL #220-81-962
 1917 S. CRISMON RD
 MESA, AZ 85209

AUTHORITY HAVING JURISDICTION:
 CITY OF MESA
 AZ DEPT OF HEALTH SERVICES (ADHS)

AUTHORITY HAVING JURISDICTION'S PROJECT NO.:

FACILITY NUMBER:

AGENCY APPROVALS:

REVISIONS		
REV #	DESCRIPTION	DATE

DATE: 03/07/24
 SCALE: As indicated
 DRAWN: Author
 REVIEWED: Checker
 JOB NUMBER: 194197.00

PHOTOMETRIC SITE PLAN




311 E. Veterans Way, Ste. 102
 Tempe, Arizona 85281

Tel 480.530.9101
 Fax 480.530.9130
 SAZAN # 965-24007

E1.11

Luminaire Schedule							
Symbol	Qty	Label	[MANUFAC]	Description	LLF	Lum. Lumens	Luminaire Watts
	25	S1	KIM LIGHTING	AR2-54L-750-4K7-3	0.900	13407	126.27
	4	S1B	KIM LIGHTING	AR2-81L-700-4K7-3-BC	0.900	10215	178.2
	5	S2	KIM LIGHTING	AR2-54L-750-4K7-5W	0.900	12947	126.27
	12	SA	COLUMBIA LIGHTING	LXEN4-40XW-RFA-EDU	0.900	2143	14.678
	14	SB	BEACON	TRP1-24L-20-4K7-4W	0.900	2468	19.9
	9	SDL - Lamp	JIAIXING SUPER LIGHTING ELECTRIC APPLIANCE CO.,LTD	Lithonia 6VF 26-42TRT MVOLT	0.900	1470	18.18

Calculation Summary							
Label	CalcType	Units	Avg	Max	Min	Avg/Min	Max/Min
Entry Canopy_Planar	Illuminance	Fc	7.72	9.9	2.2	3.51	4.50
Property Line @ 36in AFG	Illuminance	Fc	0.00	0.1	0.0	N.A.	N.A.
Site_Planar	Illuminance	Fc	1.13	8.7	0.0	N.A.	N.A.

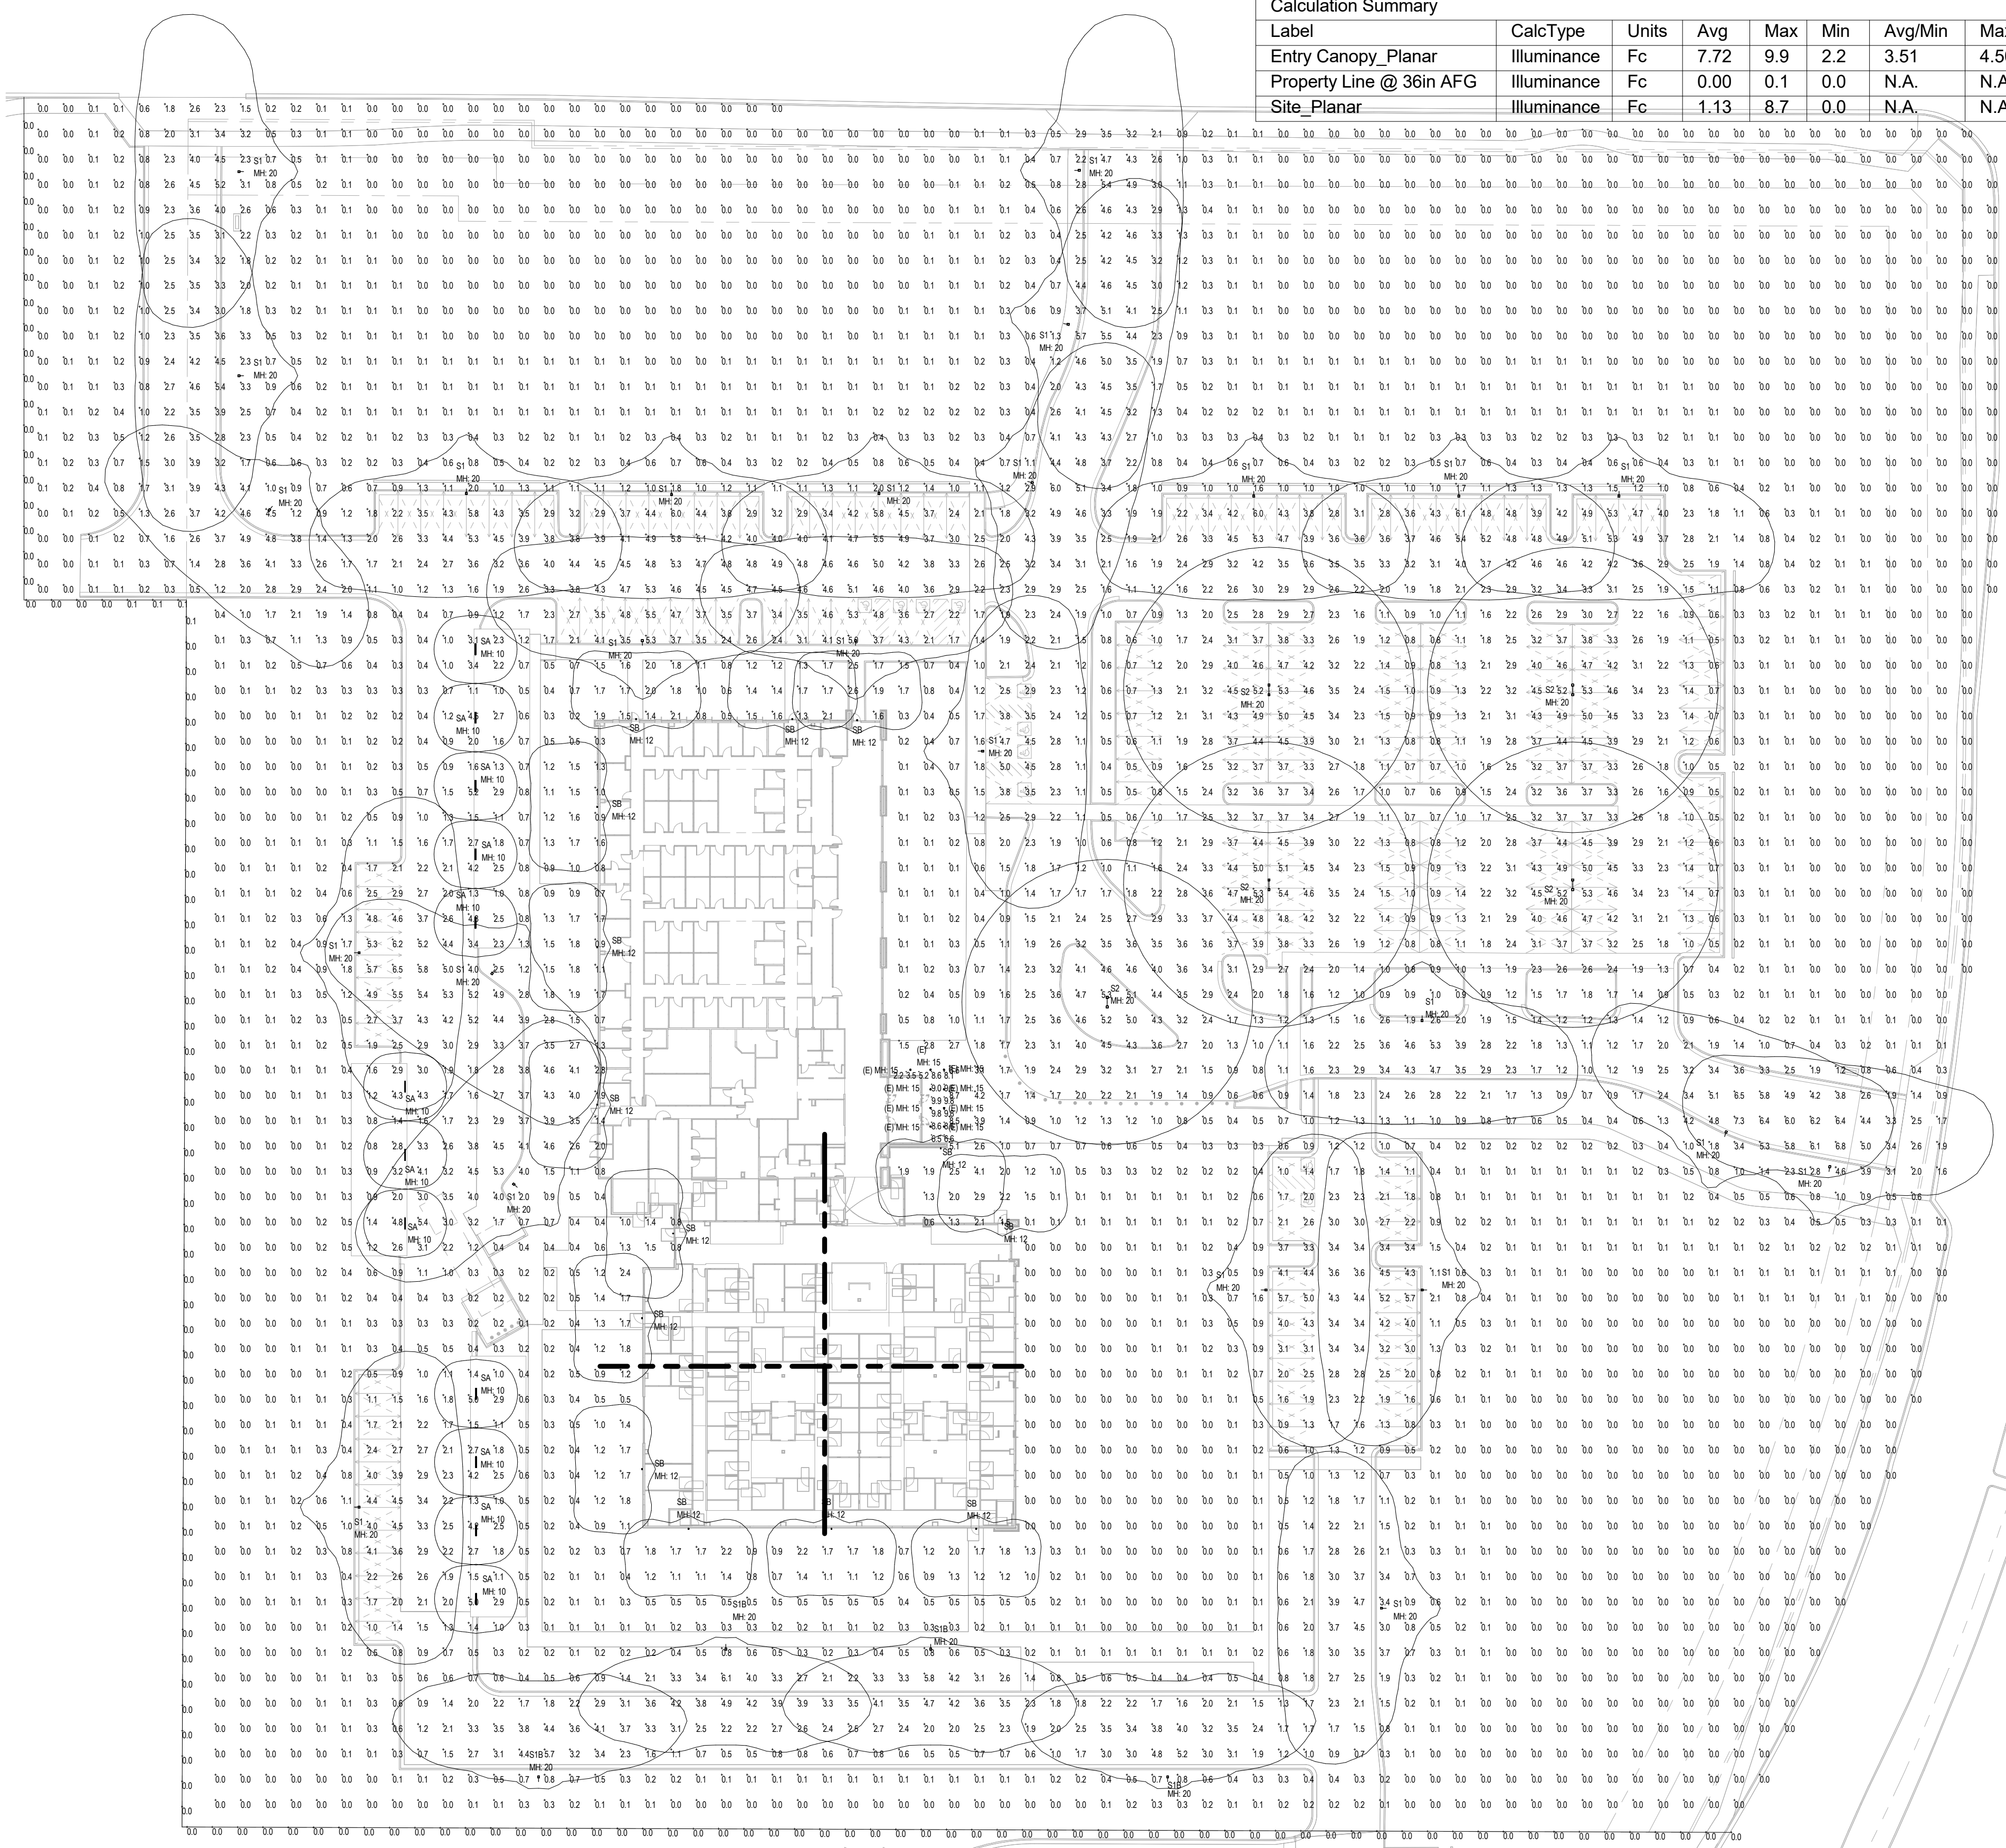

ELECTRICAL - PHOTOMETRIC SITE PLAN
 1" = 40'-0"