

SCALE: 1/16" = 1'-0"

SCALE: 1/16" = 1'-0"

SCALE: 1/16" = 1'-0"

SCALE: 1/16" = 1'-0"

	COLORS & MATERIALS
--	-------------------------------

	1	FIELD 1 – PPG0994-2 PITTSBURGH GRAY TILT PANEL
	2	ACCENT 1 – PPG0994-4 HIPPOPOTAMUS TILT PANEL
	3	ACCENT 2 – PPG0994-6 HUSKY GRAY TILT PANEL
	4	ACCENT 3 – PPG1160-4 KALEIDOSCOPE TILT PANEL
	5	ACCENT 4 – PPG1160-6 CHINESE PORCELAIN TILT PANEL
	6	CLEAR ANODIZED ALUMINUM STOREFRONT SYSTEM
	7	METAL CANOPY – CLEAR ANODIZED ALUMINUM FINISH

	KEYNOTES
--	-----------------

083.B	9'X10' OVERHEAD SECTIONAL DOCK HIGH DOOR
083.C2	20'X15' OVERHEAD COILING GRADE LEVEL DOOR
265.B1	BUILDING MOUNTED WALL PACK, SEE ELECTRICAL PLANS

**City of Mesa -
Administrative Review**
Cityview cases ADM23-00243 and ADM23-00254

Re-Submittal of Corrections:

- Loading Dock Elevation Windows,
- Overhead Door Canopies,
- Panel "Arch" Relief

6/29/23

amp

architect

ACMARTIN

444 S FLOWER STREET SUITE 1200
LOS ANGELES CA 90071 T 213 683 1900

consultant

project number 2203004

project architect DALE FURMAN

project manager EMA SHAHINIAN

project designer BANI DAVOD HESAR

visions

no.	date	revision
-----	------	----------

2/22/23 INITIAL PLAN CHECK

[illegible]

client / project

Cityview®



PLANNING DIVISION MEETS
WITH ADMINISTRATIVE
APPROVAL *WITH STIPULATIONS*

Germann Industrial Park

. Germann Rd. &
. Ellsworth Rd.,
lesa, AZ


set name

EXTERIOR ELEVATIONS BUILDING A

set number


A-501

Print date 3/21/2023 3:21:08 PM

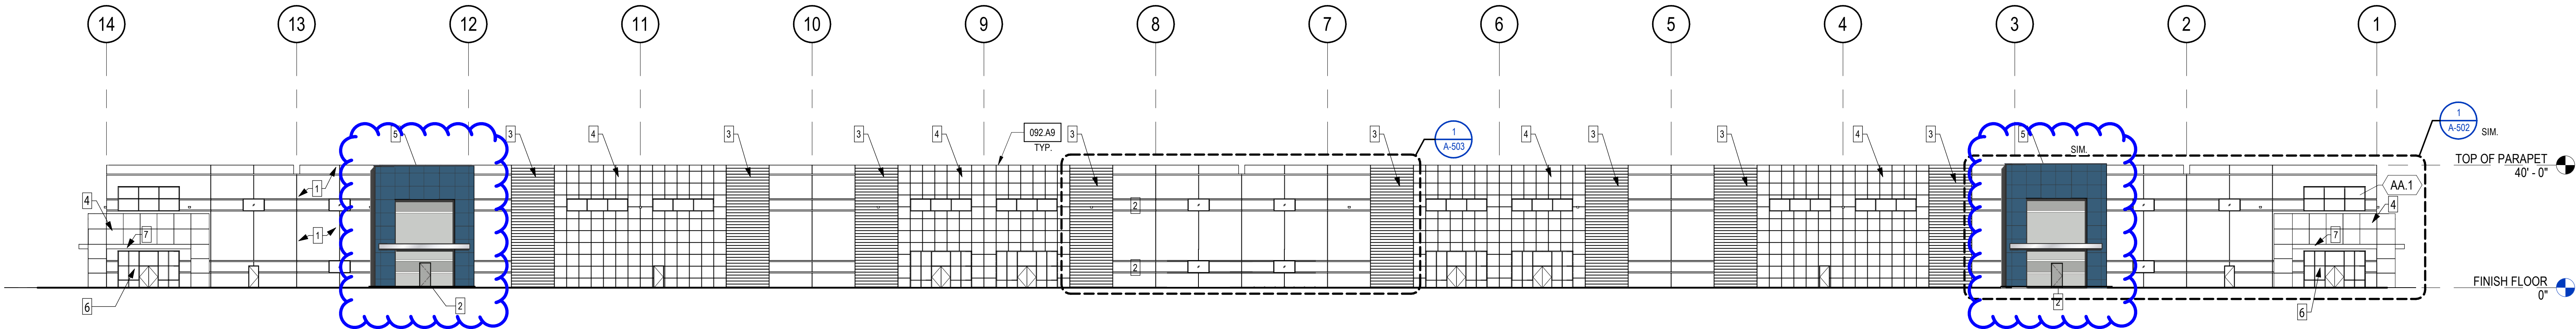


SOUTH ELEVATION

SCALE: 1" = 24'-0"

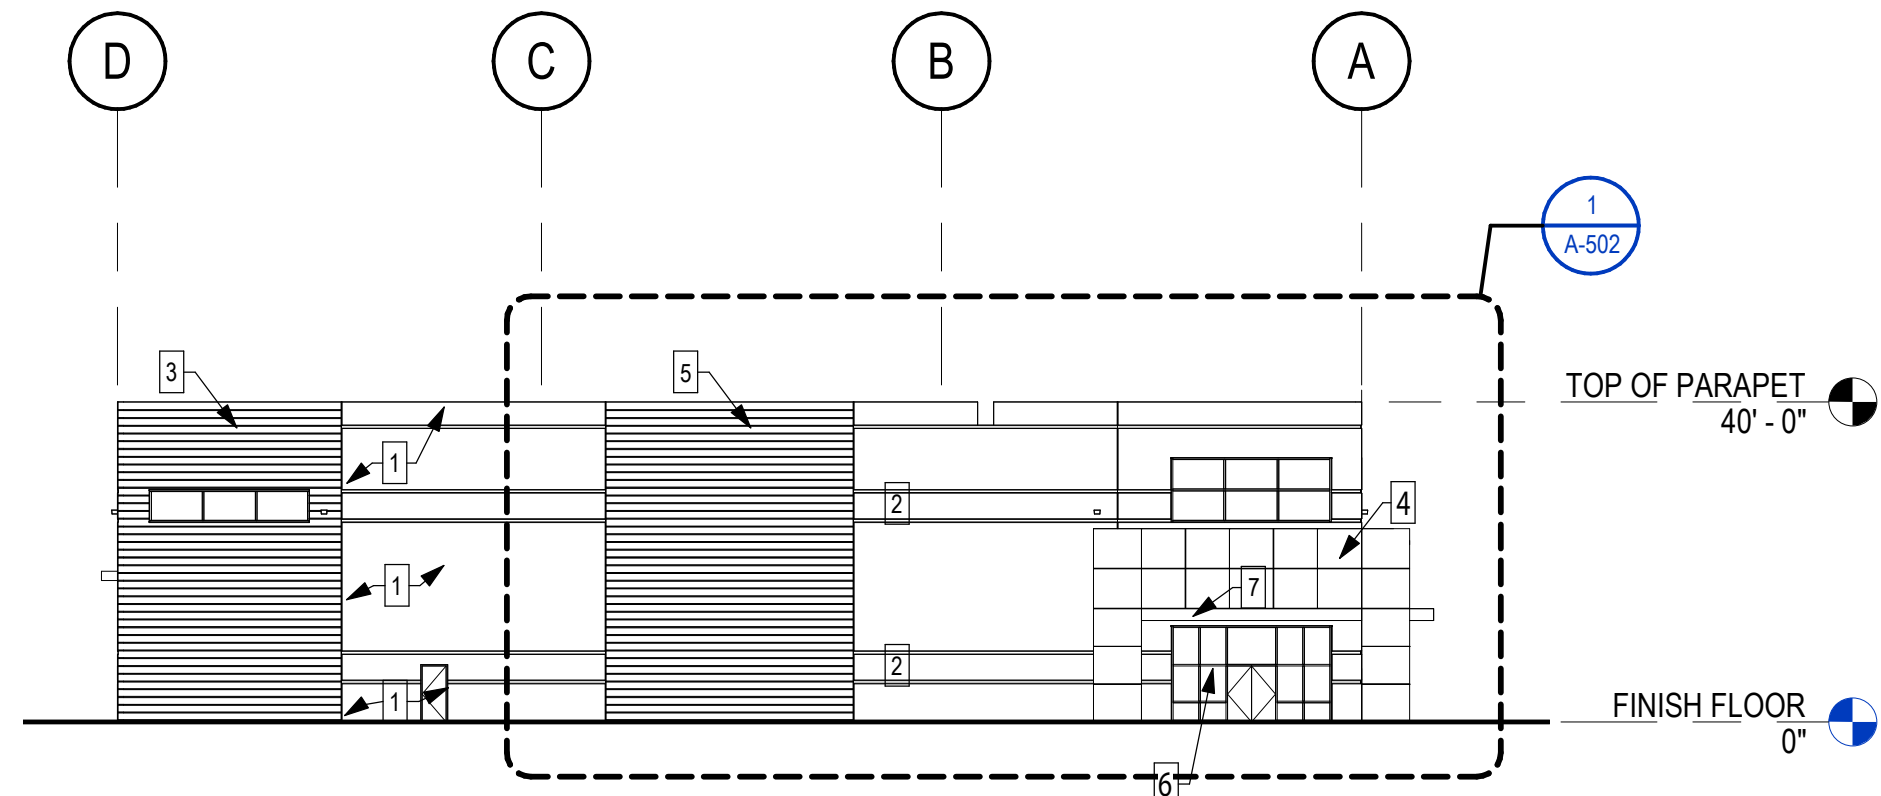


WEST ELEVATION

SCALE: 1" = 24'-0"

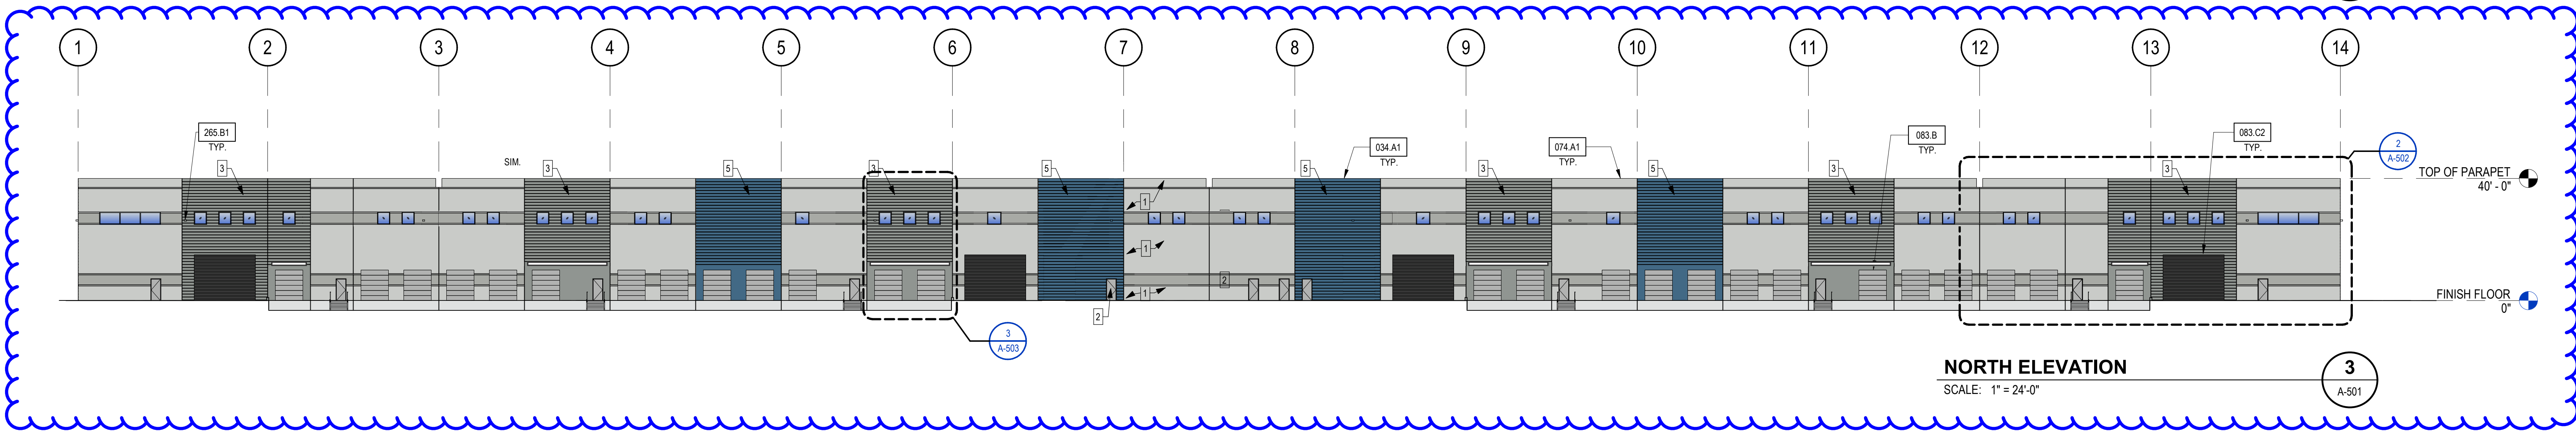

NORTH ELEVATION

SCALE: 1" = 24'-0"

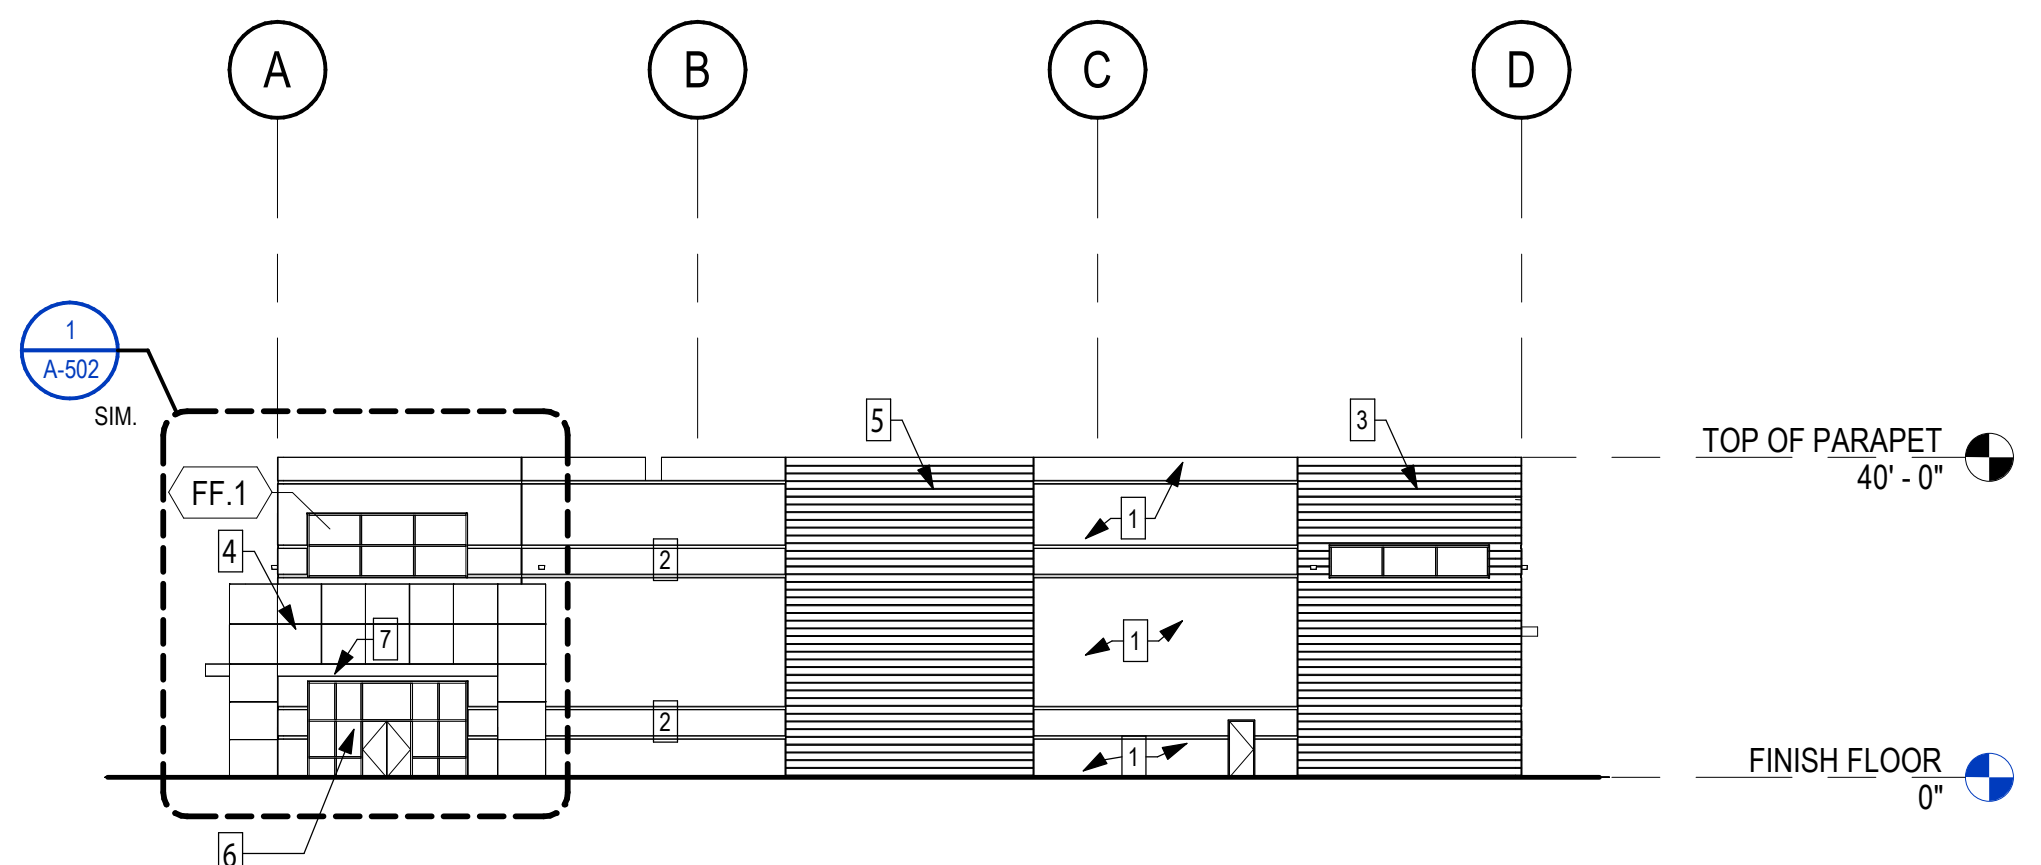

EAST ELEVATION

SCALE: 1" = 24'-0"

COLORS & MATERIALS

- | | |
|---|---|
| 1 | FIELD 1 - PPG0994-2 PITTSBURGH GRAY TILT PANEL |
| 2 | ACCENT 1 - PPG0994-4 HIPPOPOTAMUS TILT PANEL |
| 3 | ACCENT 2 - PPG0994-6 HUSKY GRAY TILT PANEL |
| 4 | ACCENT 3 - PPG1160-4 KALEIDOSCOPE TILT PANEL |
| 5 | ACCENT 4 - PPG1160-6 CHINESE PORCELAIN TILT PANEL |
| 6 | CLEAR ANODIZED ALUMINUM STOREFRONT SYSTEM |
| 7 | METAL CANOPY - CLEAR ANODIZED ALUMINUM FINISH |

KEYNOTES

- | | |
|--------|--|
| 034.A1 | CONCRETE TILT-UP PANEL |
| 074.A1 | PANEL JOINT |
| 083.B | 9'X10' OVERHEAD SECTIONAL DOCK HIGH DOOR |
| 083.C1 | 10'X15' OVERHEAD COILING GRADE LEVEL DOOR |
| 083.C2 | 20'X15' OVERHEAD COILING GRADE LEVEL DOOR |
| 092.A9 | 1-1/2" V-REVEAL |
| 265.B1 | BUILDING MOUNTED WALL MOUNTED ELECTRICAL BLANK |

**City of Mesa -
Administrative Review**

Cityview cases ADM23-00243 and ADM23-00254

Re-Submittal of Corrections:
- Loading Dock Elevation Windows,
- Overhead Door Canopies,
- Panel "Arch" Relief
6/29/23

stamp

architect

AC MARTIN

444 S FLOWER STREET, SUITE 1200
LOS ANGELES, CA 90071 T 213 683 1900

consultant

project number 2203004

project architect DALE FURMAN

project manager EMA SHAHINIAN

project designer BANI DAVOD HESAR

revisions

no. date revision

2/22/23 INITIAL PLAN CHECK

project status

client / project

Cityview

mesa.az

PLANNING DIVISION MEETS
WITH ADMINISTRATIVE
APPROVAL **WITH STIPULATIONS**

**Germann
Industrial Park**

**E. Germann Rd. &
S. Ellsworth Rd.,
Mesa, AZ**


sheet name

**EXTERIOR
ELEVATIONS
BUILDING B**

sheet number

A-501


plot date 3/21/2023 3:27:24 PM

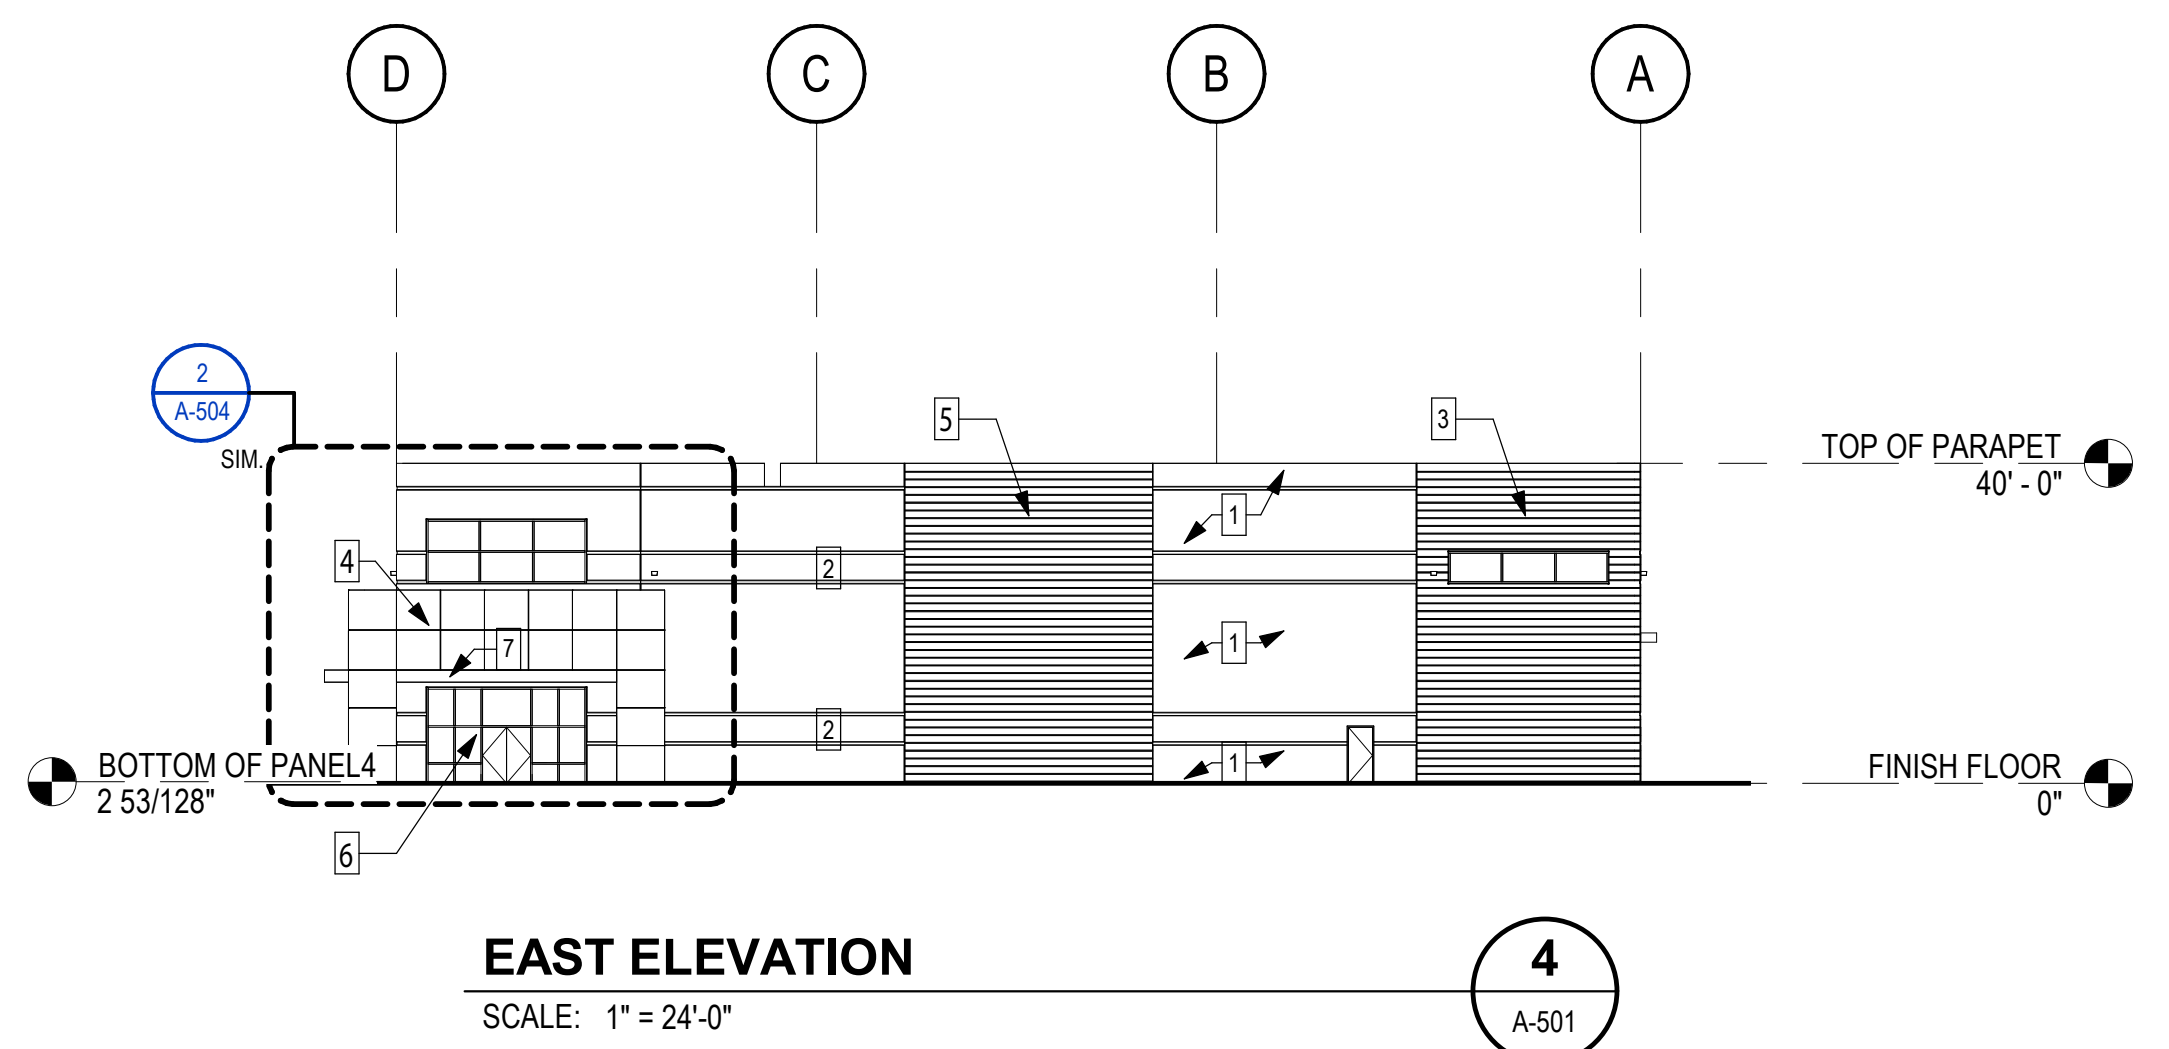

Re-Submittal of Corrections:


- Loading Dock Elevation Windows
- Overhead Door Canopies,
- Panel "Arch" Relief

6/29/23

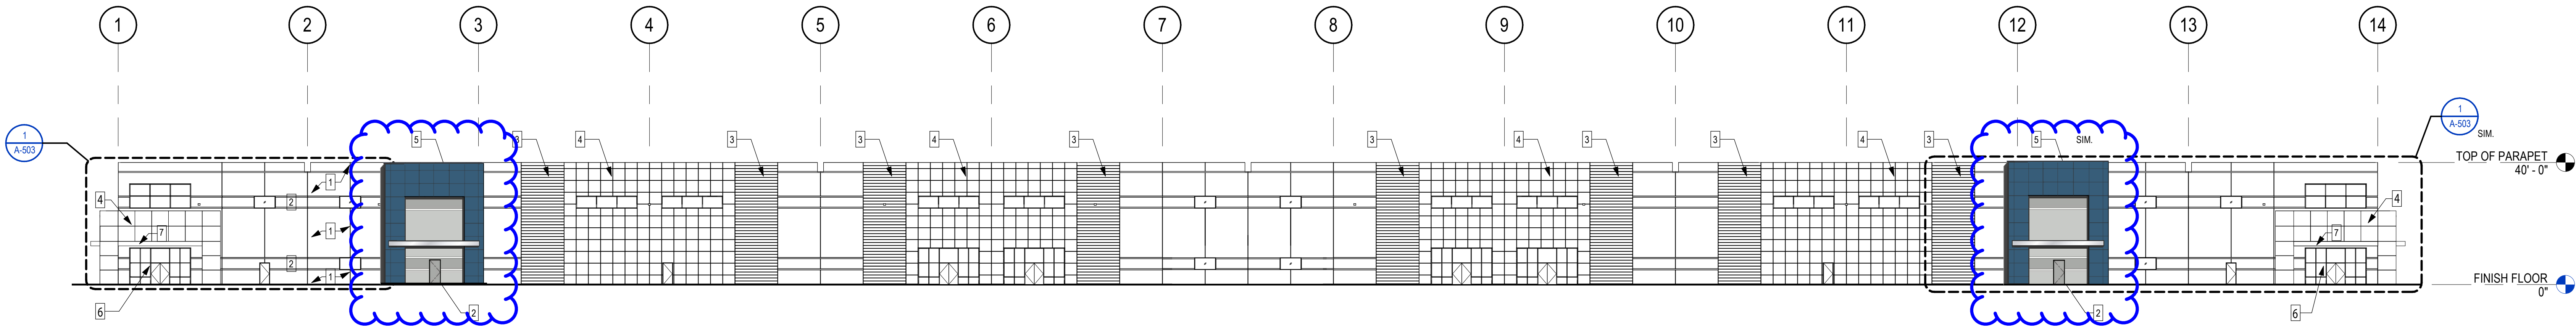


NORTH ELEVATION

SCALE: 1" = 24'-0"

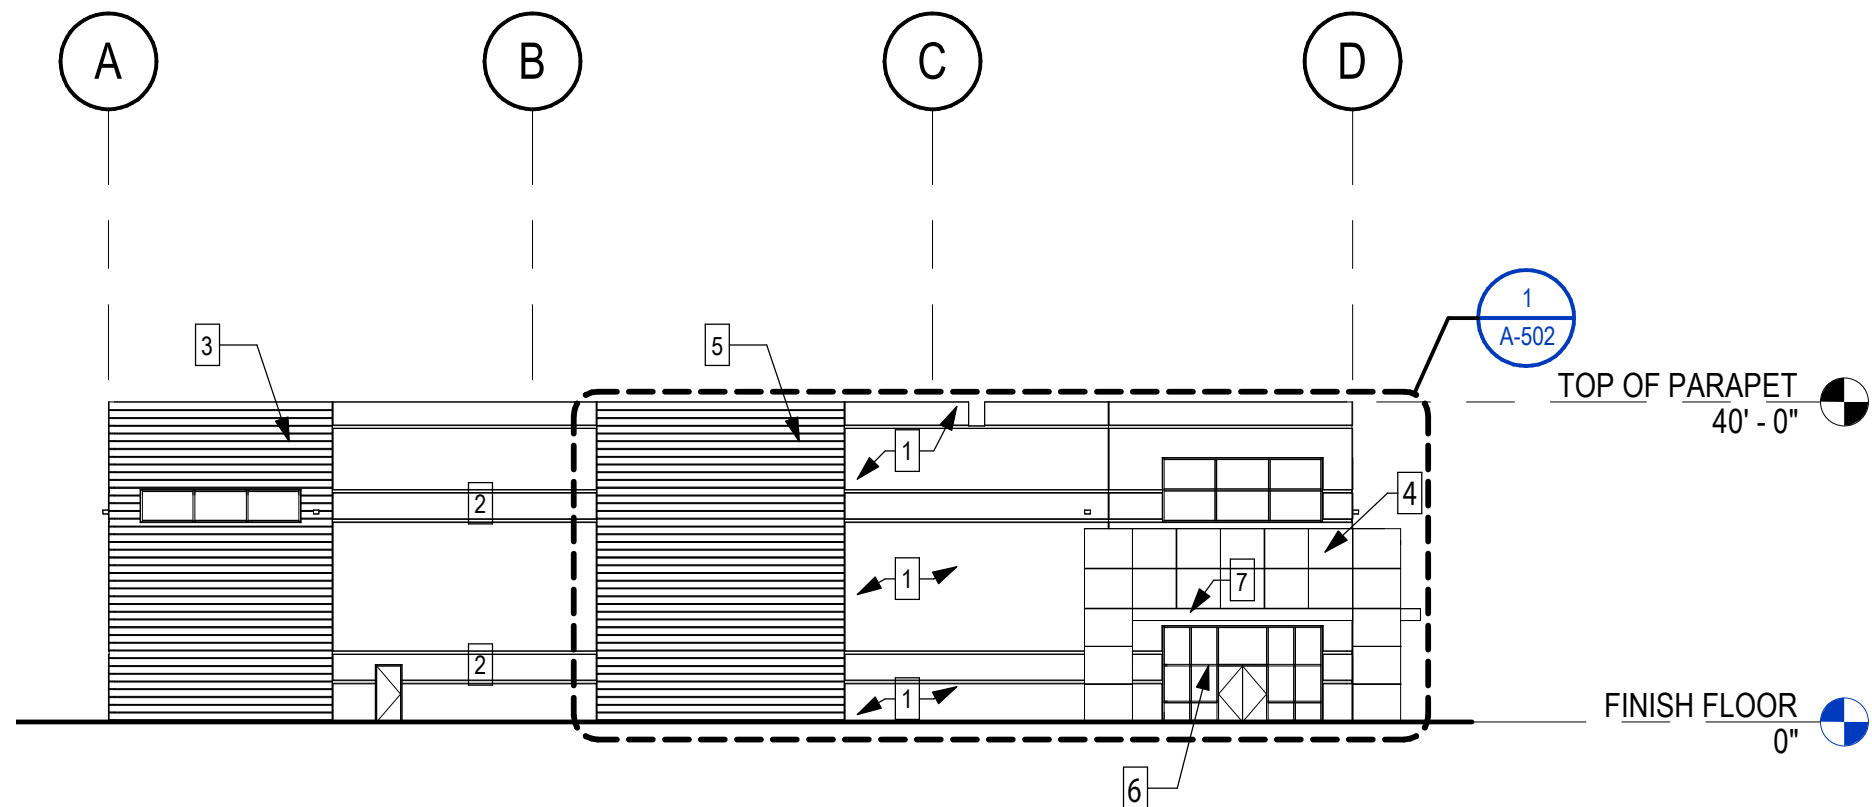


EAST ELEVATION

SCALE: 1" = 24'-0"

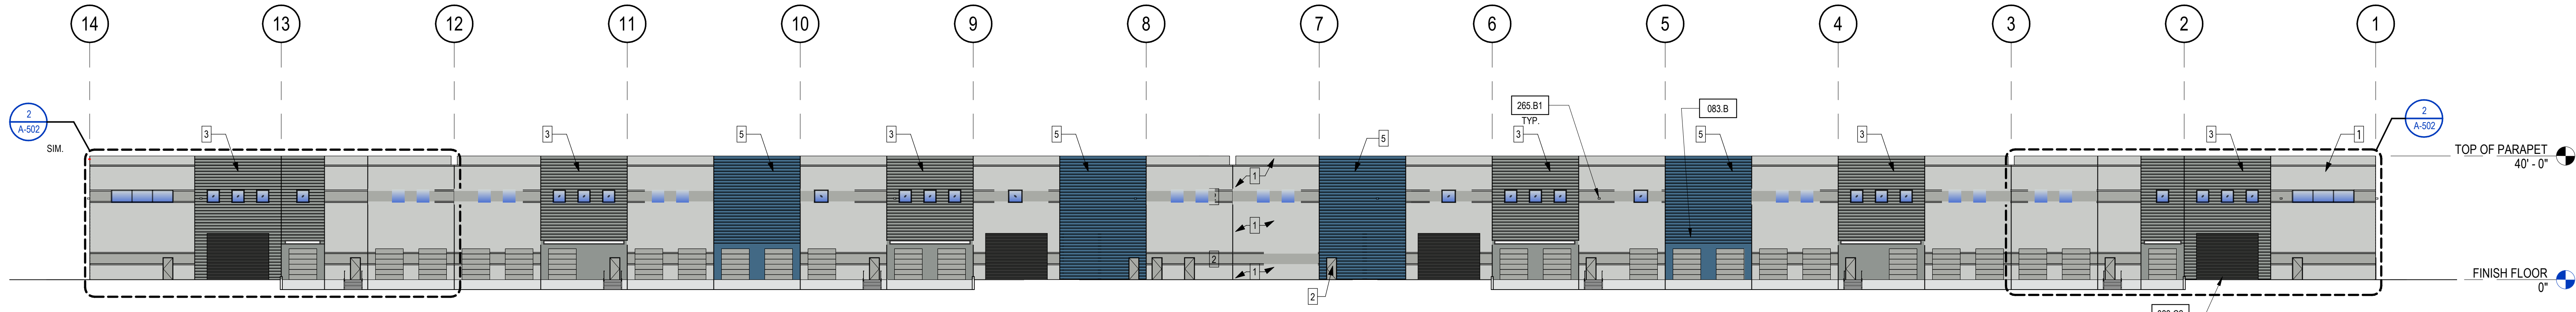

SOUTH ELEVATION

SCALE: 1" = 24'-0"

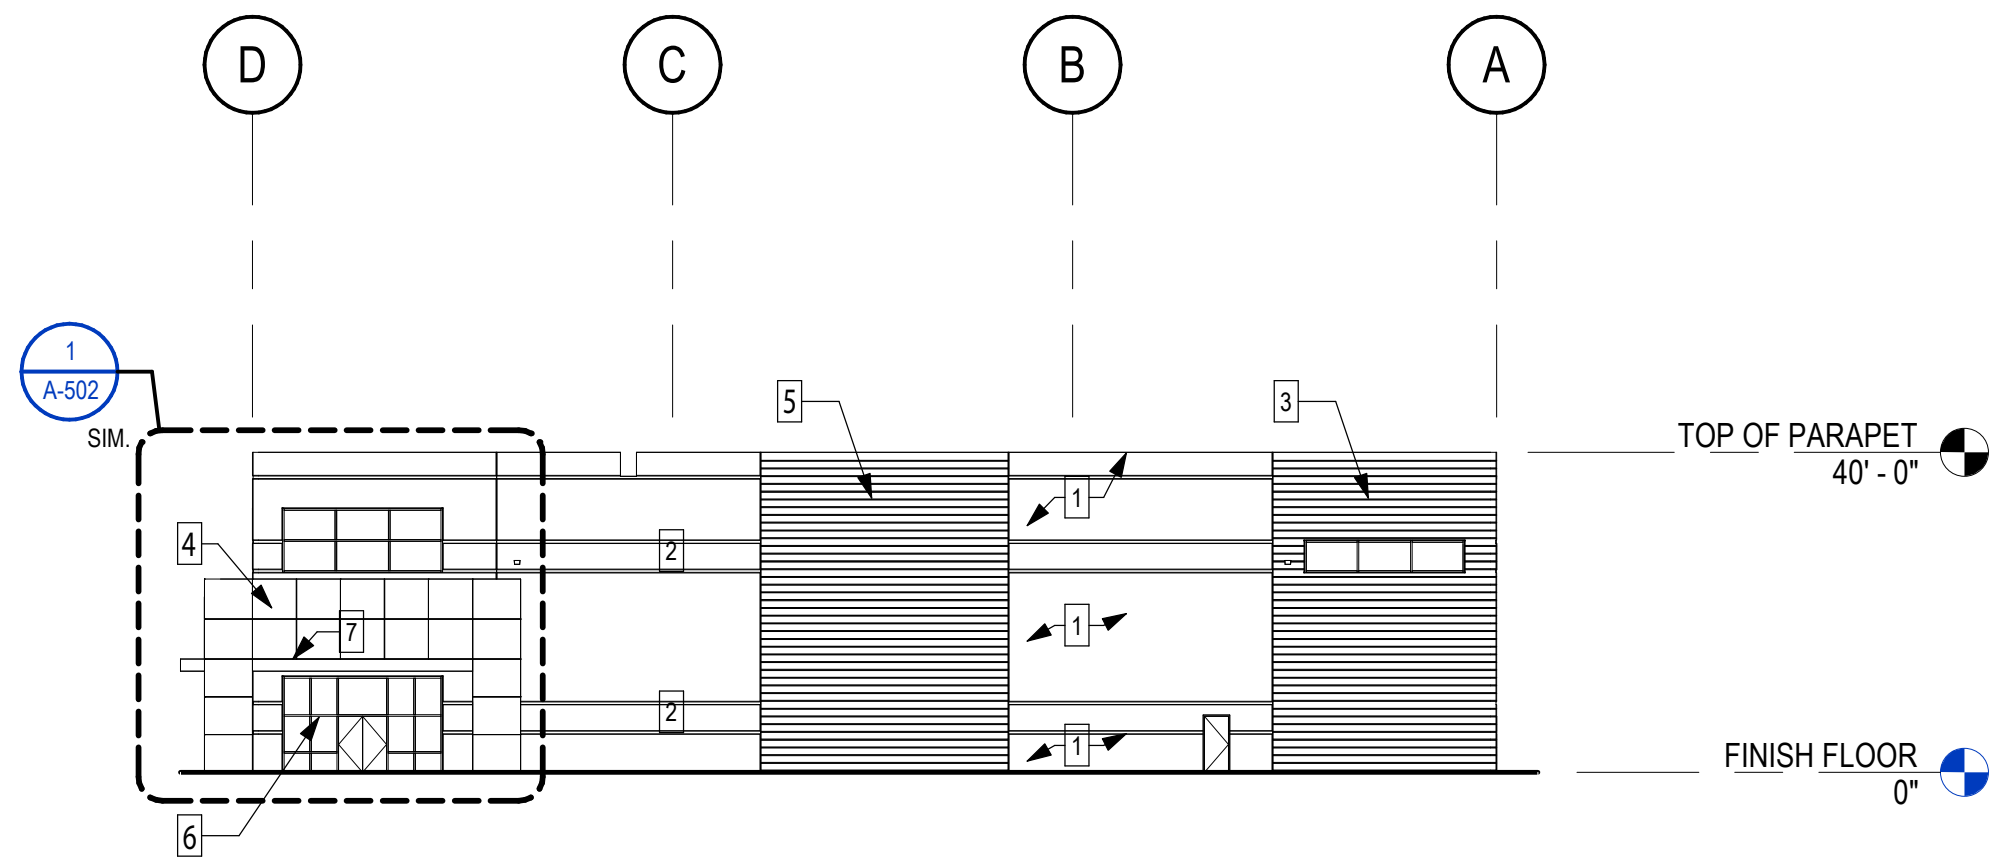

WEST ELEVATION

SCALE: 1" = 24'-0"

COLORS & MATERIALS

- | | |
|---|---|
| 1 | FIELD 1 - PPG0994-2 PITTSBURGH GRAY TILT PANEL |
| 2 | ACCENT 1 - PPG0994-4 HIPPOPOTAMUS TILT PANEL |
| 3 | ACCENT 2 - PPG0994-6 HUSKY GRAY TILT PANEL |
| 4 | ACCENT 3 - PPG1160-4 KALEIDOSCOPE TILT PANEL |
| 5 | ACCENT 4 - PPG1160-6 CHINESE PORCELAIN TILT PANEL |
| 6 | CLEAR ANODIZED ALUMINUM STOREFRONT SYSTEM |
| 7 | METAL CANOPY - CLEAR ANODIZED ALUMINUM FINISH |

KEYNOTES

- | | |
|--------|--|
| 083.B | 9'X10' OVERHEAD SECTIONAL DOCK HIGH DOOR |
| 083.C1 | 10'X15' OVERHEAD COILING GRADE LEVEL DOOR |
| 083.C2 | 20'X15' OVERHEAD COILING GRADE LEVEL DOOR |
| 265.B1 | BUILDING MOUNTED WALL PACK, SEE ELECTRICAL PLANS |

City of Mesa -
Administrative Review

Cityview cases ADM23-00243 and ADM23-00254

Re-Submission of Corrections:
- Loading Dock Elevation Windows,
- Overhead Door Canopies,
- Panel "Arch" Relief
6/29/23

stamp

architect

ACMARTIN

444 S FLOWER STREET, SUITE 1200
LOS ANGELES, CA 90071 T 213 683 1900

consultant

project number 2203004

project architect DALE FURMAN

project manager EMA SHAHINIAN

project designer BANI DAVOD HESAR

revisions

no.	date	revision
2/22/23		INITIAL PLAN CHECK

project status

Project Status
Issue Date

client / project

Cityview

mesa·az
PLANNING DIVISION MEETS
WITH ADMINISTRATIVE
APPROVAL WITH STIPULATIONS

Germann
Industrial

S Ellsworth Rd &
E Germann Rd, Mesa, AZ


sheet name

EXTERIOR
ELEVATIONS
BUILDING E

sheet number

A-501

plot date 3/21/2023 4:29:08 PM

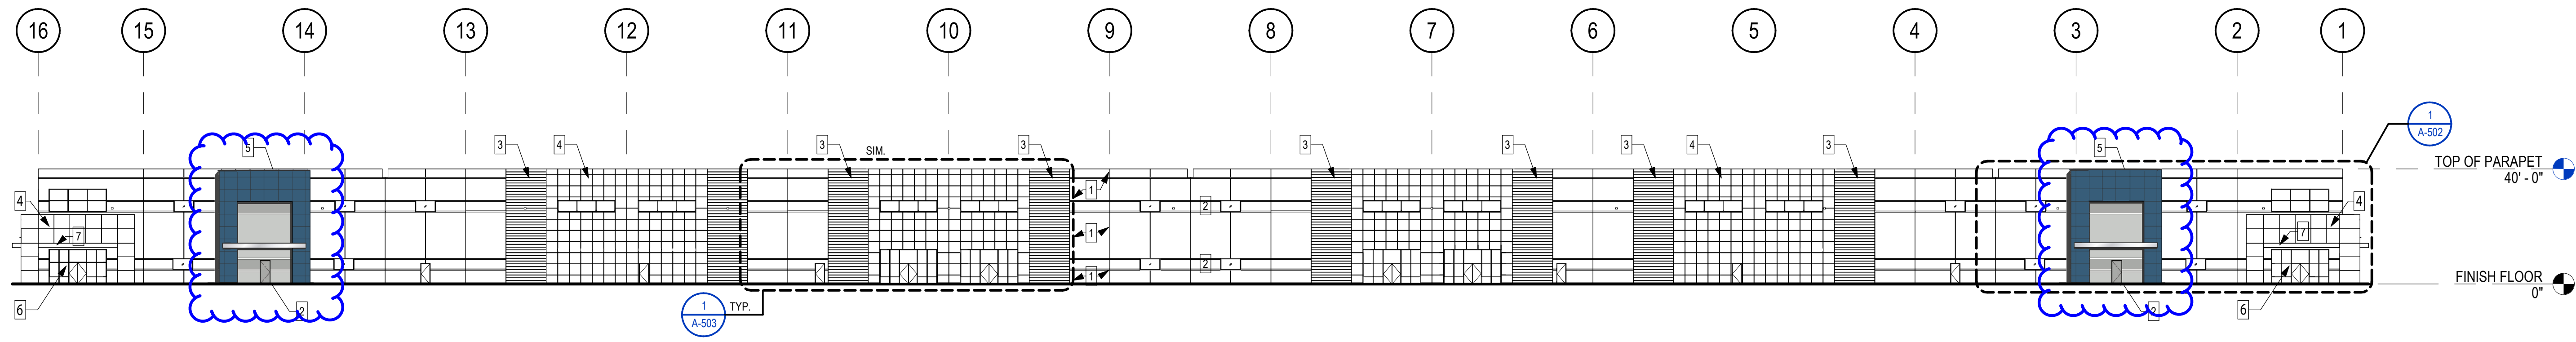


WEST ELEVATION

SCALE: 1" = 30'-0"

1

A-501

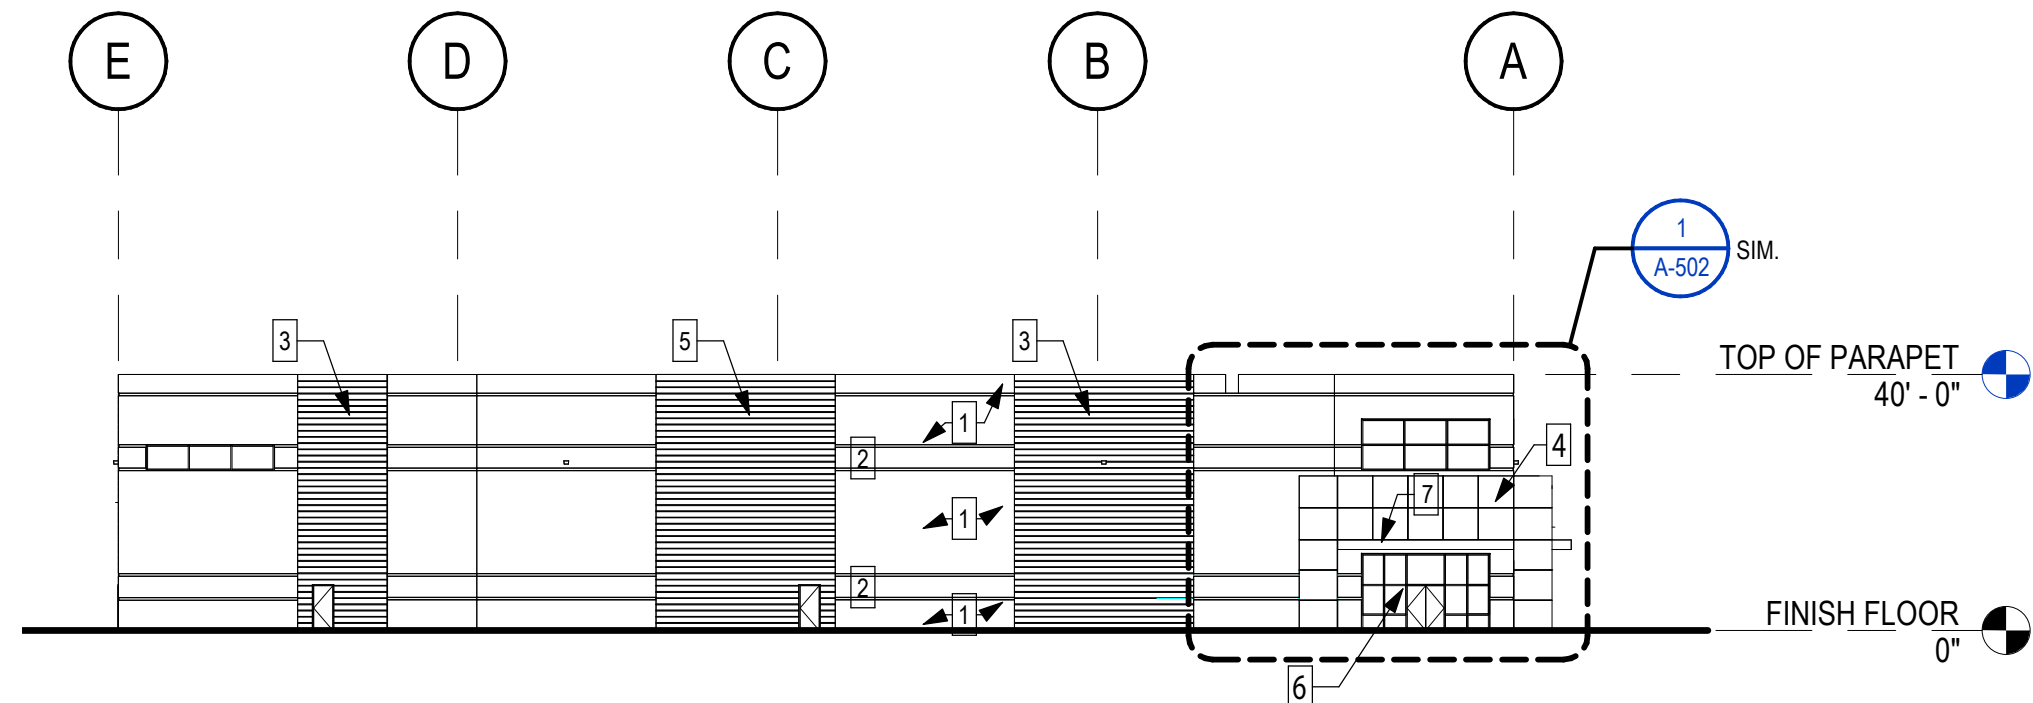


NORTH ELEVATION

SCALE: 1" = 30'-0"

2

A-501

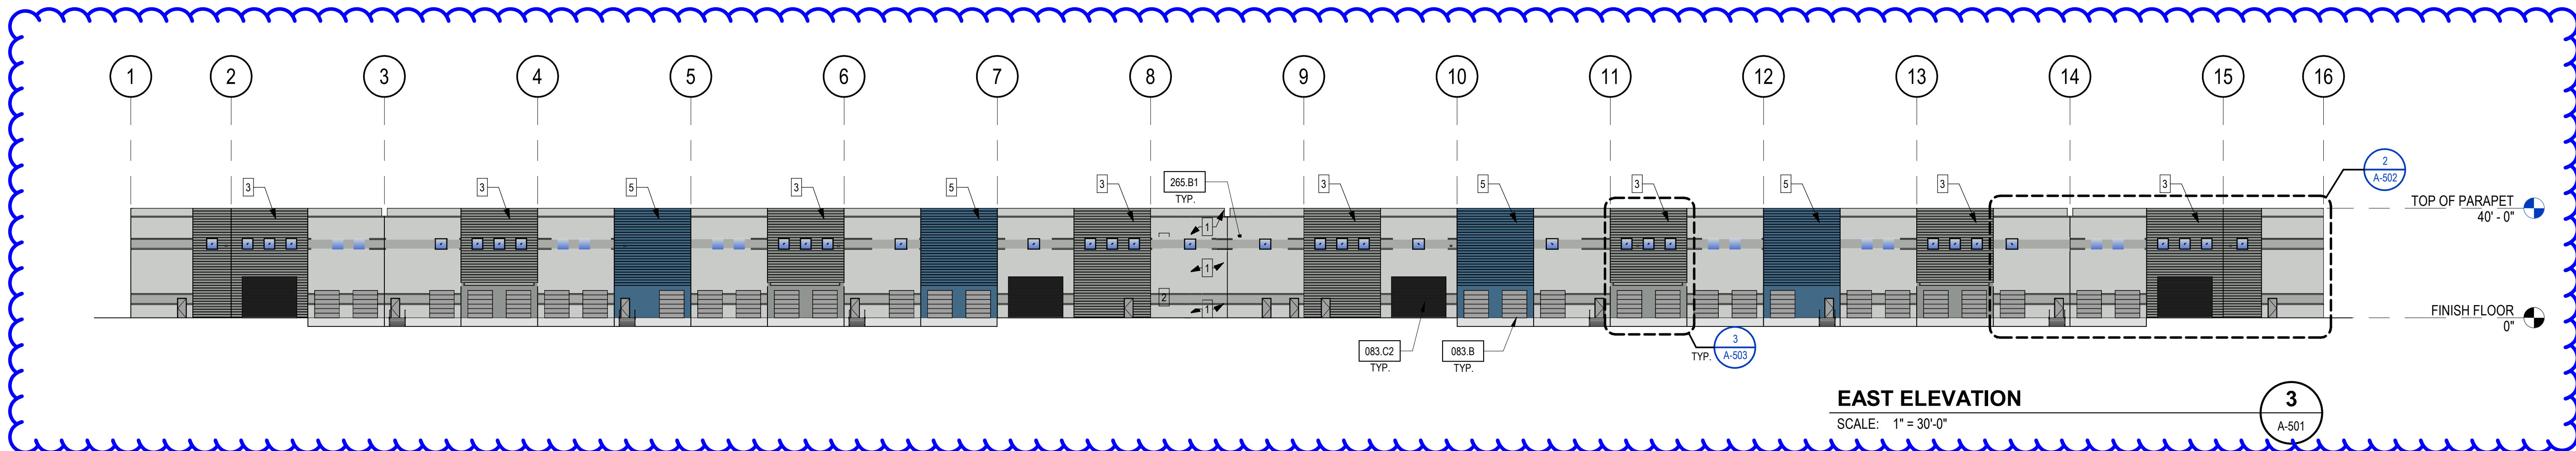


EAST ELEVATION

SCALE: 1" = 30'-0"

3

A-501

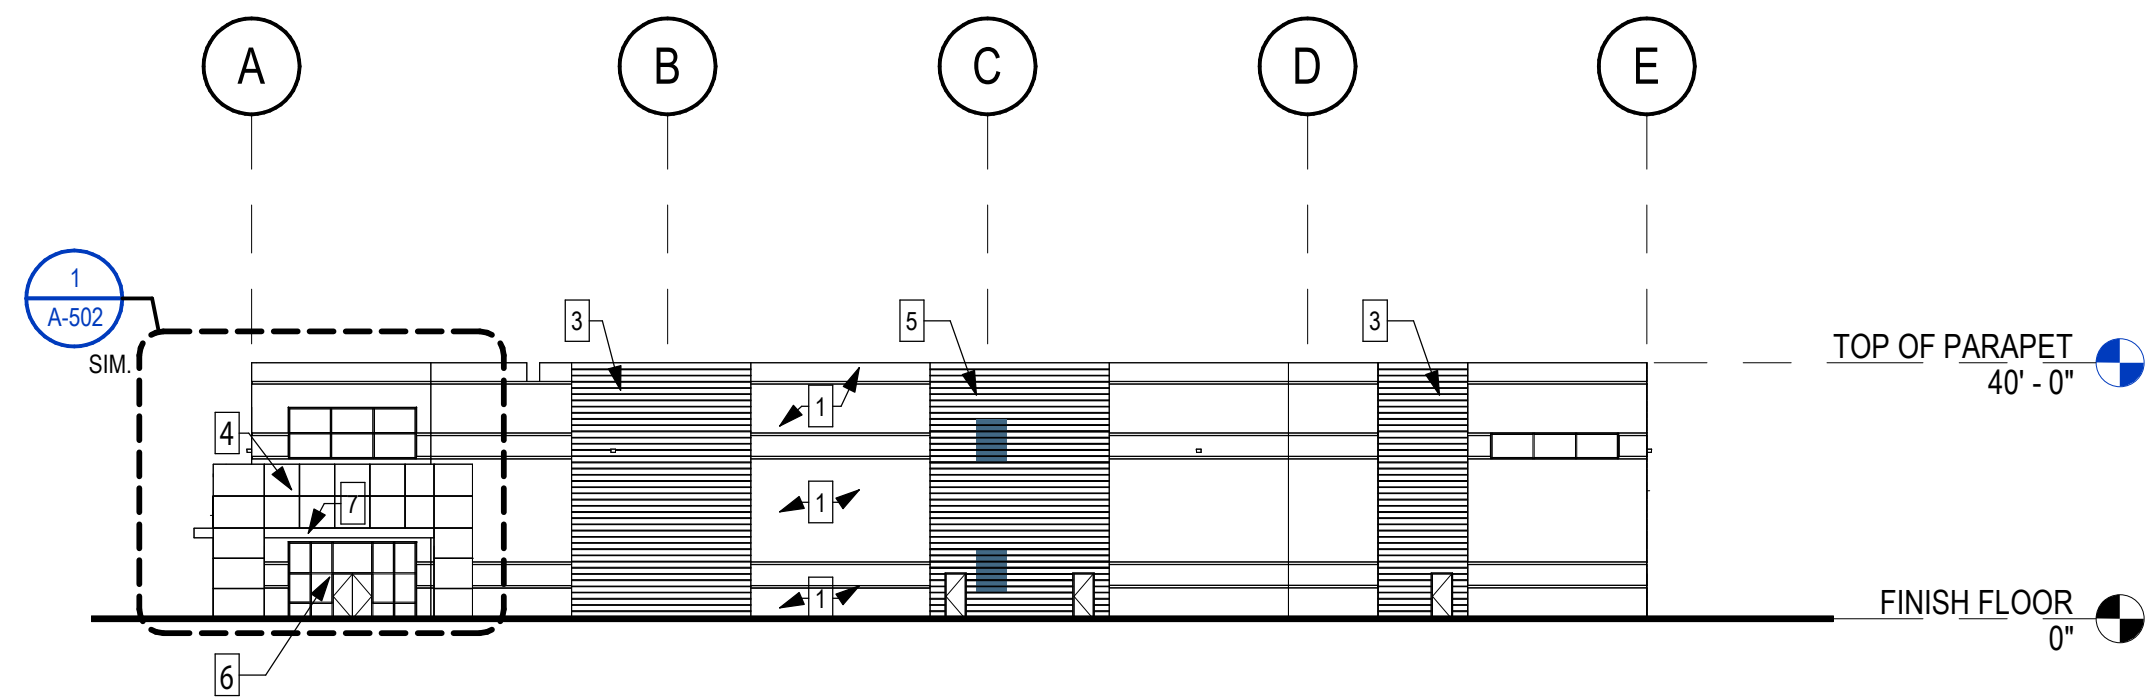

SOUTH ELEVATION

SCALE: 1" = 30'-0"

4

A-501

COLORS & MATERIALS

- | | |
|---|---|
| 1 | FIELD 1 - PPG0994-2 PITTSBURGH GRAY TILT PANEL |
| 2 | ACCENT 1 - PPG0994-4 HIPPO POTAMUS TILT PANEL |
| 3 | ACCENT 2 - PPG0994-6 HUSKY GRAY TILT PANEL |
| 4 | ACCENT 3 - PPG1160-4 KALEIDOSCOPE TILT PANEL |
| 5 | ACCENT 4 - PPG1160-6 CHINESE PORCELAIN TILT PANEL |
| 6 | CLEAR ANODIZED ALUMINUM STOREFRONT SYSTEM |
| 7 | METAL CANOPY - CLEAR ANODIZED ALUMINUM FINISH |

KEYNOTES

- | | |
|--------|--|
| 083.B | 9'X10' OVERHEAD SECTIONAL DOCK HIGH DOOR |
| 083.C2 | 20'X15' OVERHEAD COILING GRADE LEVEL DOOR |
| 285.B1 | BUILDING MOUNTED WALL PACK, SEE ELECTRICAL PLANS |

City of Mesa -
Administrative Review

Cityview cases ADM23-00243 and ADM23-00254

Re-Submittal of Corrections:

- Loading Dock Elevation Windows,
 - Overhead Door Canopies,
 - Panel "Arch" Relief
- 6/29/23

stamp

architect

AC MARTIN

444 S FLOWER STREET, SUITE 1200
LOS ANGELES, CA 90071 T 213 683 1900

consultant

project number 2203004

project architect DALE FURMAN

project manager EMA SHAHINIAN

project designer BANI DAVOD HESAR

revisions

no.	date	revision
1	2/22/23	INITIAL PLAN CHECK

project status

client / project

Cityview

mesa·az
PLANNING DIVISION: MEETS
WITH ADMINISTRATIVE
APPROVAL WITH STIPULATIONS

Germann
Industrial Park

E. Germann Rd. &
S. Ellsworth Rd.,
Mesa, AZ

sheet name

EXTERIOR
ELEVATIONS
BUILDING F

sheet number

A-501

plot date 3/21/2023 4:41:58 PM