


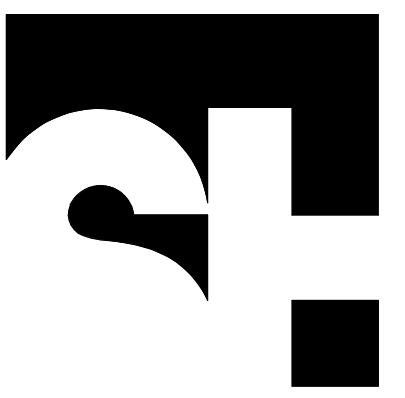

STENGEL-HILL
ARCHITECTURE

613 WEST MAIN STREET
LOUISVILLE, KENTUCKY 40202

502.893.1875

502.893.1876 fax

Civil Engineering



Structural Engineering




Mechanical/Electrical Engineering



Foodservice Design



ACADIA
HEALTHCARE

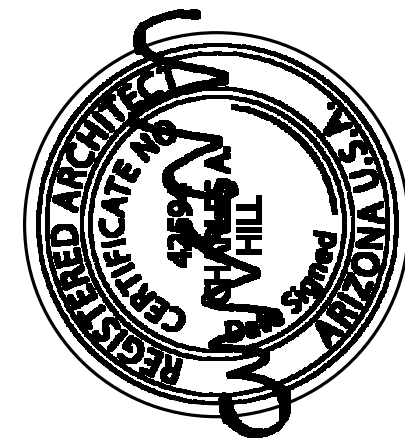


COMPOSITE FLOOR PLAN
NEW BEHAVIORAL HEALTH HOSPITAL
ACADIA HEALTHCARE COMPANY, INC.
MESA, ARIZONA

31 MAY 2022
AHC2105


A4.1

DESIGN REVIEW DRAWINGS - NOT FOR CONSTRUCTION

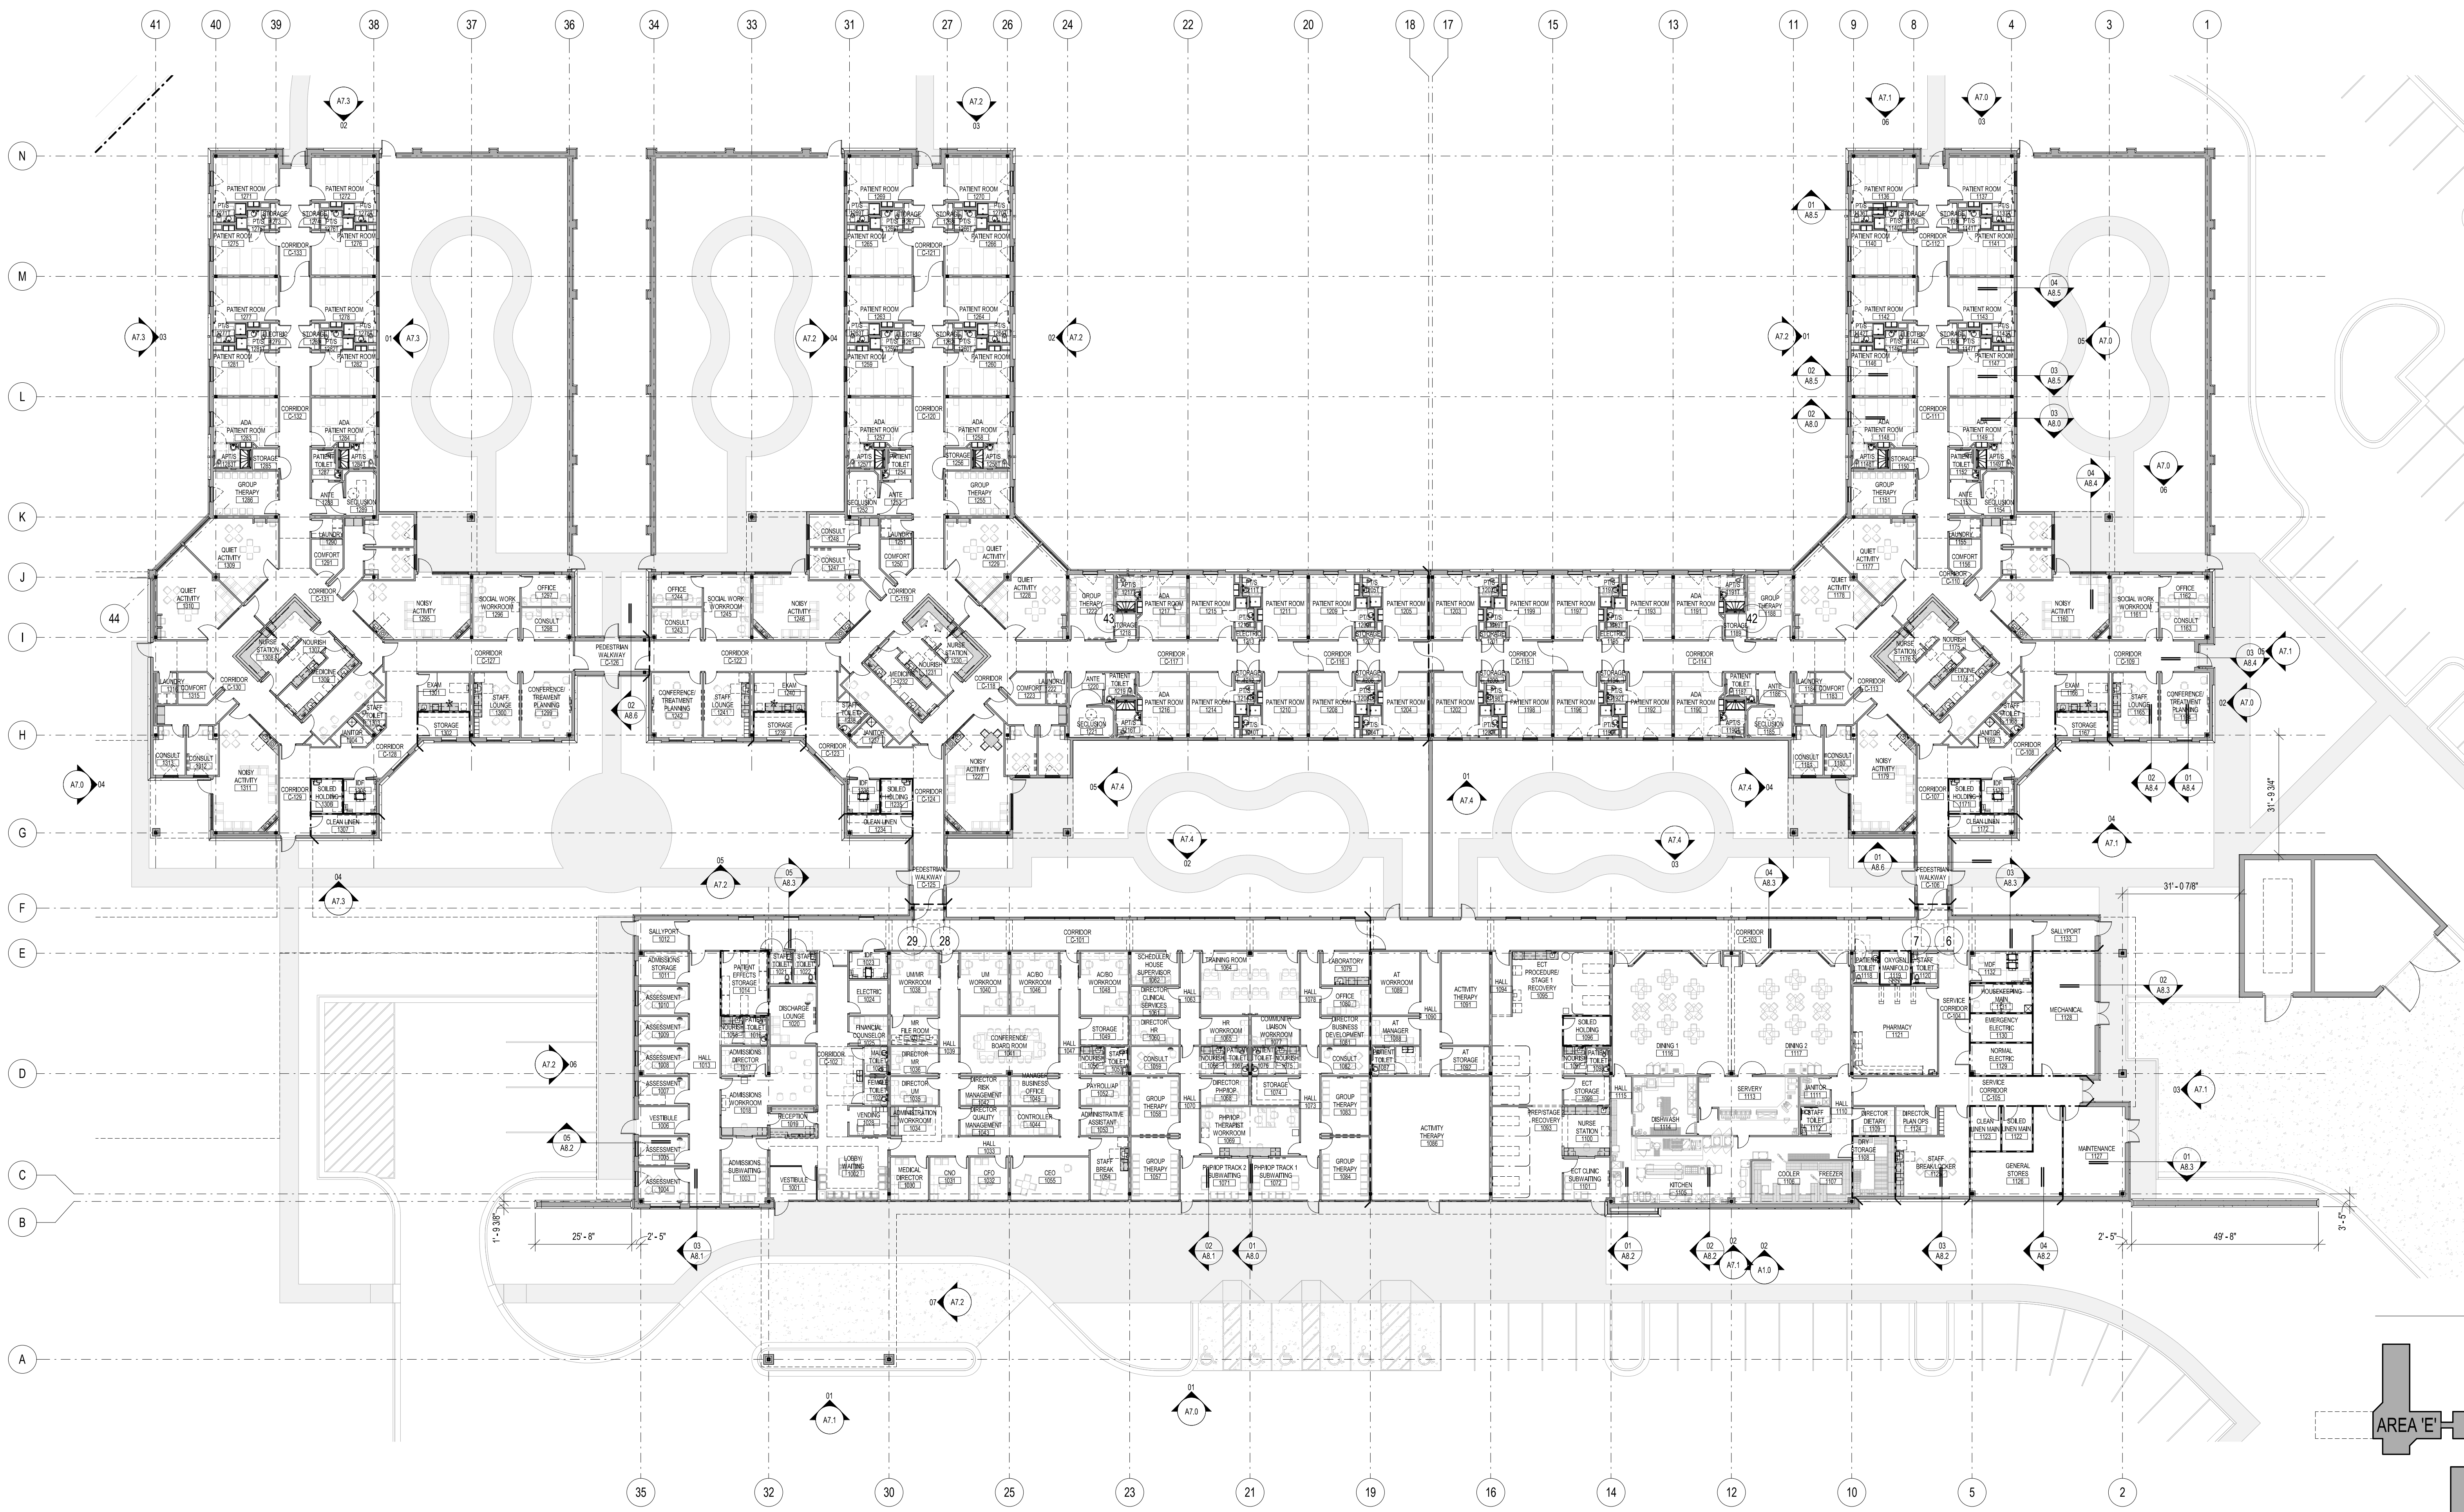

KEYPLAN

NOT TO SCALE

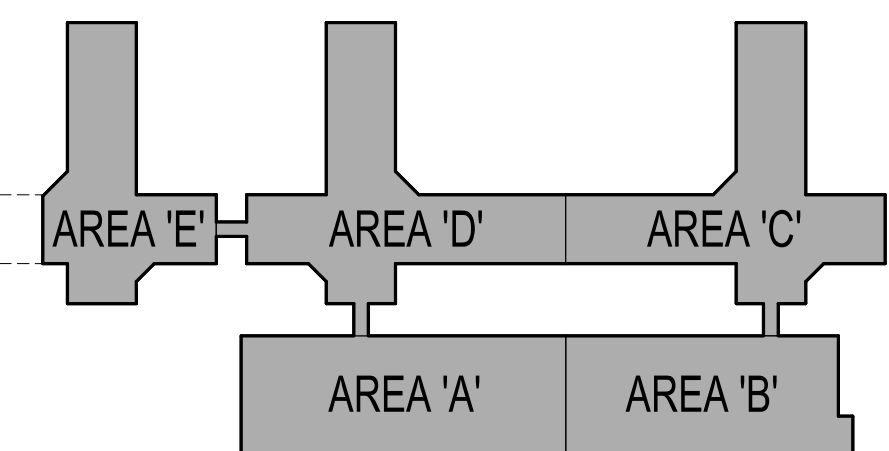




NEW BEHAVIORAL HEALTH HOSPITAL

01 COMPOSITE FLOOR PLAN

A4.1

1" = 20'-0"

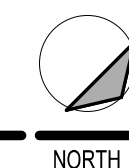

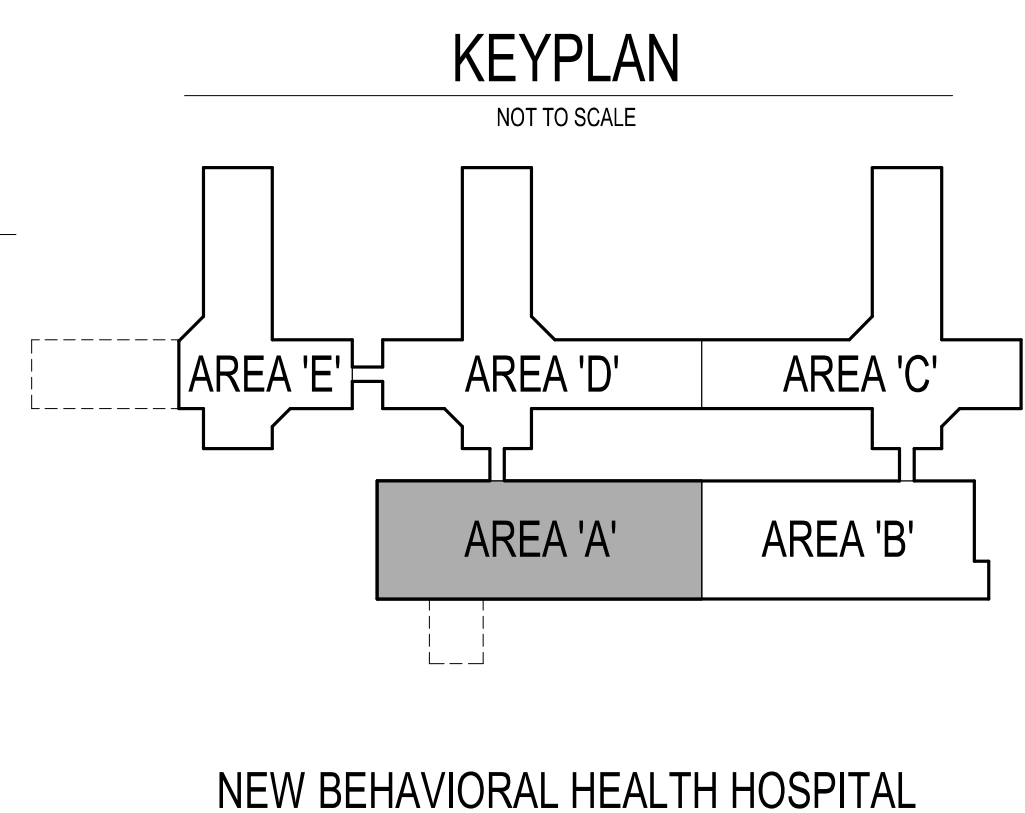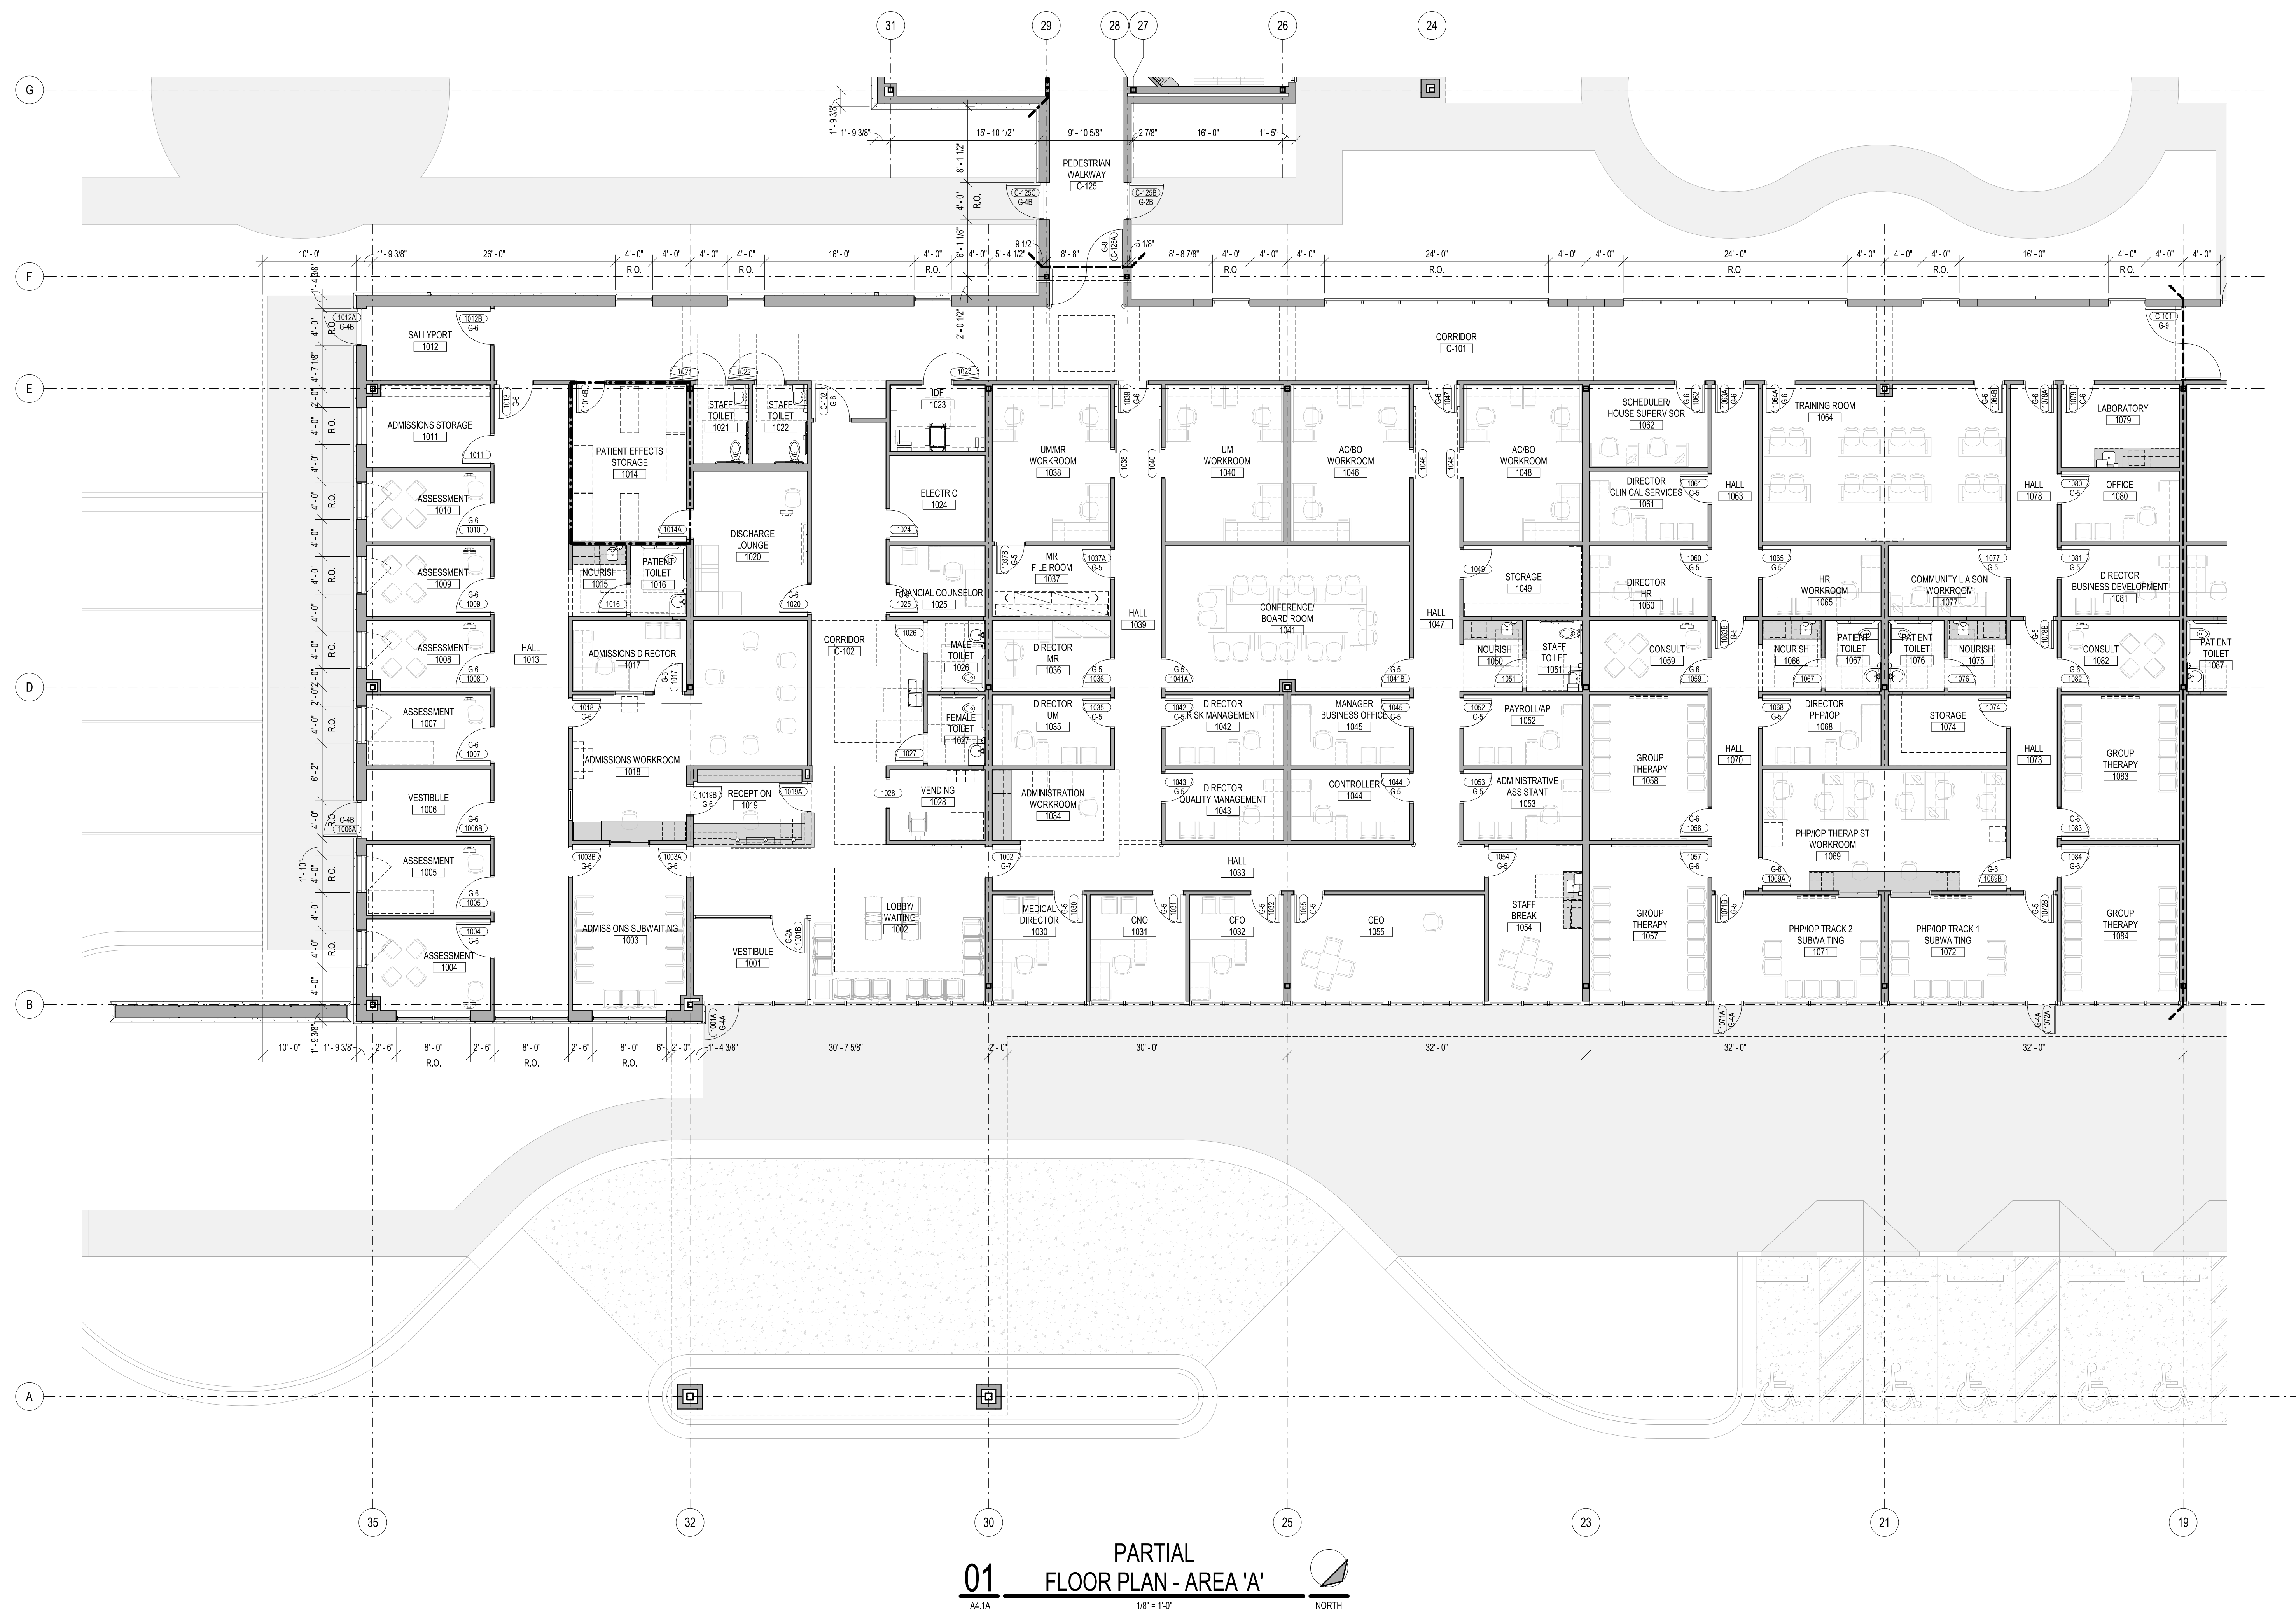

SYMBOL LEGEND

FLOOR PLAN SYMBOLS			
 PLAN NOTE	 EQUIPMENT TAG	 ROOM NUMBER	 DOOR/ROOM NUMBER

CEILING PLAN SYMBOLS			
 SUPPLY AIR DIFFUSER	 RETURN AIR GRILLE	 EXHAUST AIR GRILLE	 HUMIDISTAT/THERMOSTAT
 324 FLUORESCENT LIGHT	 154 FLUORESCENT LIGHT	 2M FLUORESCENT LIGHT	 SUPPLIED INDIRECT LIGHT
 RECESSED LIGHT	 SMOKE DETECTOR	 SPEAKER	 EXIT SIGN

PLUMBING SYMBOLS			
 LAUNDRY (SINK/LAUNDRIES)	 LAUNDRY (COUNTER/COUNTER MOUNTS)	 SINK (COUNTER/COUNTER MOUNTS)	 WATER CLOSET
 SCRUB SINK	 CLINICAL SINK	 MOP SINK	 ELECTRIC WATER COOLER

MEDICAL GAS SYMBOLS			
 AIR	 NITROGEN	 NITROUS OXIDE	 OXYGEN
 VACUUM BOTTLE GLIDE	 VACUUM	 O2 OUTLET	 PATIENT COUNCIL
 NITROGEN CRYSTAL CABINET	 LINE PRESSURE ALARM (NUMBER OF ALARMS)	 SHUT OFF VALVE BOX (NUMBER OF VALVES)	 MASTER ALARM PANEL

NURSE CALL SYMBOLS			
 ELAPSED TIME CLOCK	 DOME LIGHT	 EMERGENCY STATION (PULLCORD)	 EMERGENCY STATION (PUSHBUTTON)
 EMERGENCY STATION (PERMANENT PUSHBUTTON)	 STAFF/STATION	 MASTER STATION	 CODE BLUE
 STAFF PRESENCE	 ANNUNCIATOR PANEL	 INTERCOM	 CODE BLUE ANNUNCIATOR
 SINGLE PATIENT STATION	 SINGLE PATIENT STATION (NO TELEVISION)	 DOUBLE PATIENT STATION (TELEVISION)	 DOUBLE PATIENT STATION (NO TELEVISION)

ELECTRICAL SYMBOLS			
 ABOVE AS NOTED 10' AFF TELEPHONE RECEPTACLE	 ABOVE AS NOTED 10' AFF CUMULATIVE RECEPTACLE	 ABOVE AS NOTED 10' AFF JUNCTION BOX	 ABOVE AS NOTED SURGICAL WALL RECEPTACLE (NUMBER OF OUTLETS)
 ABOVE AS NOTED 10' AFF TELEPHONE OUTLET	 ABOVE AS NOTED 10' AFF TELEPHONE DATA OUTLET	 ABOVE AS NOTED 10' AFF DATA OUTLET	 ABOVE AS NOTED SURGICAL CEILING RECEPTACLE (NUMBER OF OUTLETS)

ABBREVIATION LEGEND

AS	Automatic Flush Valve	NO	Mid-Open-Arm or Closer
AI	Alphine System	HPK	Hotlink Privacy Lockset
AKS	Adjustable Keyswitch	IB	Ingress Blinds
AL	Aluminum	IS	Interlock Door Switch
AO	Automatic Operator	IS	Intrinsic Lockset
AP	Auto Pilot	IR	Infrared Facecut Sensor
CAH	Control Arm	IV	Clear View
CG	Corner Guard	KPO	Key Pad
CL	Closer	LRA	Ligature Resistant
CR	Classroom Lockset	MB	Manual Flush Valve
CRD	Card Reader	MS	Mandatory Keyswitch
CS	Combination Switch/Outlet	NO	Narrow-Clas Lite
DA	Door-Acting Door	OF	Off Lock
DE	Deadbolt	OP	Open Lock Indicator
DE	Delayed-Egress Door System	PA	Passage Latchset
DR	Door Release Button	PB	Panic Button
DS	Downspout	PO	Pocket Door
EG	Edge Guard	PH	Panic Hardware
EO	Electromagnetic Hold-Open	PP	Push Pin Door Hardware
EL	Electric Magnetic Lock	PPH	Push Pin Door
EM	Emergency Exit	PS	Privacy Lockset
ES	Electric Strike	RC	Room-Curtain Motor Detector
FB	Fire Bar	RM	Room Motion Detector
FE	Fire Extinguisher	RP	Recessed Door Pull
FEC	Fire Extinguisher/Cabinet	SB	Smoke Barrier
FG	Full-Clas Lite	SL	Electromagnetic Shair Lock
HI	Handrail Class C Interupter	SS	Stainless Steel
HO	Hold-Clas Lite	TL	Thimble Lock
HL	Holdlock Latchset	VCL	Volume Control
HM	Holdlock Metal	W	Wall Phone

STENGEL-HILL
ARCHITECTURE

613 WEST MAIN STREET
LOUISVILLE, KENTUCKY 40202

502.893.1875

502.893.1876 fax

Civil Engineering





Structural Engineering



Mechanical/Electrical Engineering

Foodservice Design

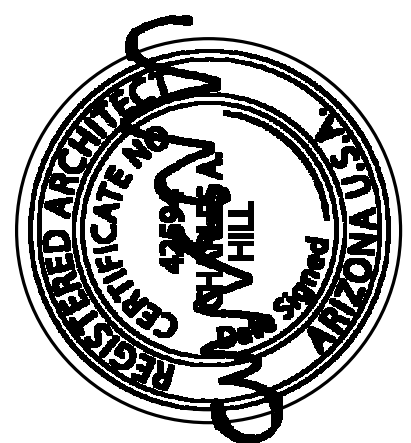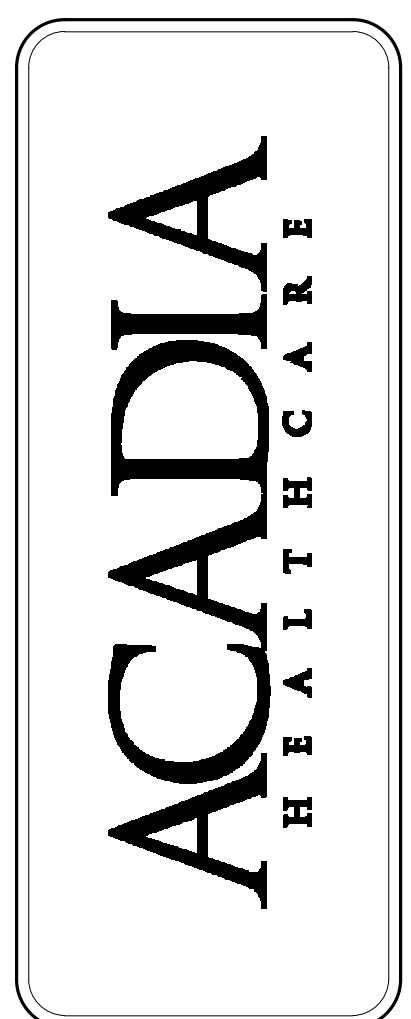

PARTIAL FLOOR PLAN - AREA 'A'
NEW BEHAVIORAL HEALTH HOSPITAL
ACADIA HEALTHCARE COMPANY, INC.
MESA, ARIZONA

NEW BEHAVIORAL HEALTH HOSPITAL
ACADIA HEALTHCARE COMPANY, INC.

MESA, ARIZONA


MESA, ARIZONA

31 MAY 2022
AHC2105

AHC2105

A4.1A

DESIGN REVIEW DRAWINGS - NOT FOR CONSTRUCTION

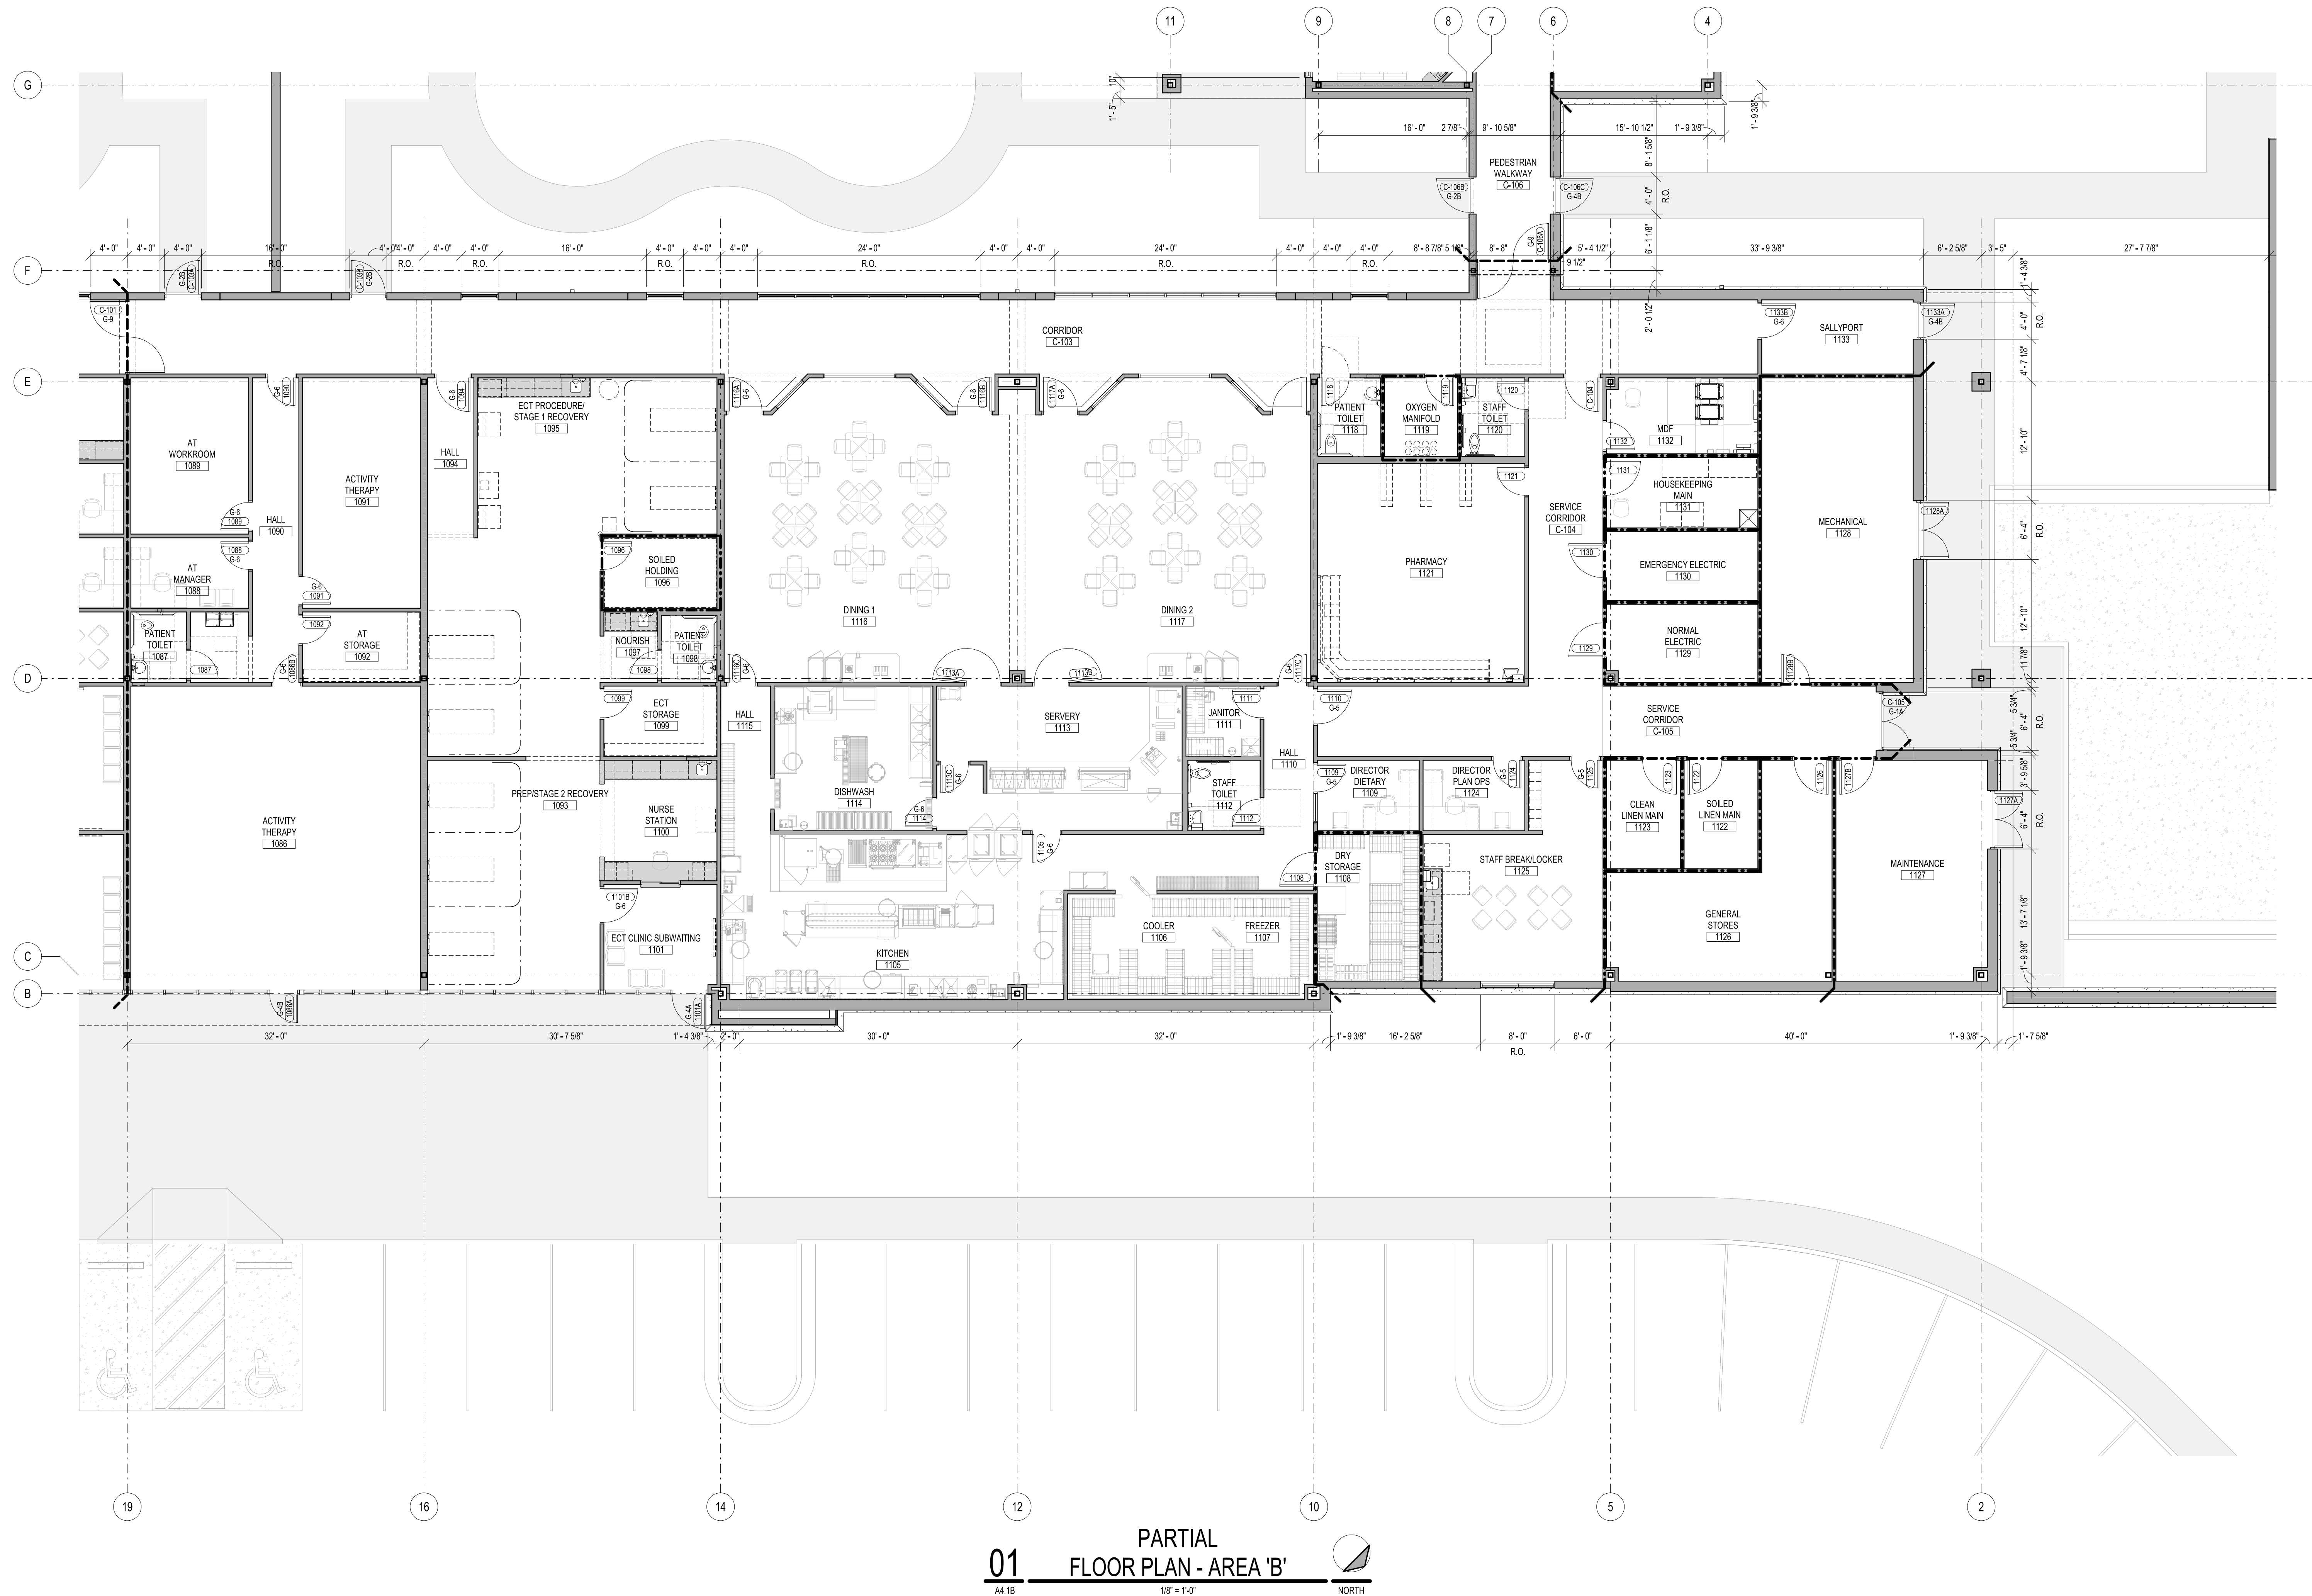



SYMBOL LEGEND

FLOOR PLAN SYMBOLS			
ALTER	ROOM	ROOM NAME/NUMBER	DOOR/DOOR NUMBER
PLAN NOTE	EQUIPMENT TAG	ROOM NAME/NUMBER	DOOR/DOOR NUMBER
CEILING PLAN SYMBOLS			
SUPPLY AIR DIFFUSER	RETURN AIR GRILLE	EXHAUST AIR GRILLE	HANDHEATH THERMOSTAT
2X FLUORESCENT LIGHT	1X FLUORESCENT LIGHT	3X FLUORESCENT LIGHT	SUSPENDED INDIRECT LIGHT
RECESSED LIGHT	SMOKE DETECTOR	SPEAKER	EXIT SIGN
PLUMBING SYMBOLS			
LAVATORY (WALL/MOUNTED)	LAVATORY (COUNTERTOP MOUNTED)	SINK (COUNTERTOP MOUNTED)	WATER CLOSET
SINK/SINK	CLINICAL SINK	MOP SINK	ELECTRIC WATER COOLER
MEDICAL GAS SYMBOLS			
AIR	NITROGEN	NITROUS OXIDE	OXYGEN
VACUUM BOTTLE BLUE	VACUUM	DEBRID OUTLET	PATIENT CONSOLE
NITROGEN CONTROL CABINET	LINE PRESSURE ALARM (NUMBER OF LINES)	SHUT-OFF VALVE BOX (NUMBER OF VALVES)	MASTER ALARM PANEL
NURSE CALL SYMBOLS			
ELAPSED TIME CLOCK	PHONE LIGHT	EMERGENCY STATION (PULL STATION)	EMERGENCY STATION (PULL STATION)
EMERGENCY STATION (PULL STATION)	STAFF OUTLET STATION	MASTER STATION	CODE BLUE
STAFF PRESENCE	ANNUNCIATOR PANEL	INTERCOM	CODE BLUE ANNUNCIATOR
SINGLE PATIENT STATION (PULL STATION)	SINGLE PATIENT STATION (PULL STATION)	DOUBLE PATIENT STATION (PULL STATION)	DOUBLE PATIENT STATION (PULL STATION)
ELECTRICAL SYMBOLS			
ABOVE AS NOTED	ABOVE AS NOTED	ABOVE AS NOTED	ABOVE AS NOTED
12" AFF DUPLEX RECEPTACLE	12" AFF DUPLEX RECEPTACLE	12" AFF JUNCTION BOX	12" AFF SURGICAL WALL RECEPTACLE (NUMBER OF OUTLETS)
12" AFF TELEPHONE OUTLET	12" AFF TELEPHONE/OUTLET	12" AFF DATA OUTLET	12" AFF SURGICAL CEILING RECEPTACLE (NUMBER OF OUTLETS)

ABBREVIATION LEGEND

AB Automatic Flush Bolts	HD Hubs-Open Arm on Closer
AI Alpha System	HPR Hospital Privacy Lockset
AKS Alternate Keyswitch	IB Integral Blinds
AL Aluminum	IL Inset Lock Door Switch
AO Automatic Operator	IN Institutional Lockset
AP Armor Plate	IR Infrared Facial Control
CAM Camera	KP Kick Plate
CG Corner Guard	KPD Keypad
CL Closer	LR Luggage Resistant
CR Classroom Lockset	MB Manual Flush Bolts
CRO Card Reader	MMS Momentary Keyswitch
CS Combination Switch/Outlet	NB Narrow-Blade Life
DA Double-Acting Door	OF Office Lockset
DB Deadbolt	OI Occupancy Indicator
DE Delayed-Egress Door System	PA Passage Latchset
DR Door Release Button	PB Panic Button
DS Downspout	PD Pocket Door
EG Edge Guard	PH Panic Hardware
EHD Electromagnetic Hold-Open	PP Push/Pull Door Hardware
EL Electromagnetic Lock	PHD Push/Pull
EM Emergency Circuit	PI Privacy Lockset
ES Electric Strike	RD Room-Curtain Motion Detector
FB Fire Barrier	RM Room Motion Detector
FE Fire Extinguisher	RP Recessed Door Pull
FEC Fire Extinguisher Cabinet	SB Smoke Barrier
FG Full-Glass	SL Electromagnetic Share Lock
GFI Ground Fault Circuit Interrupter	SR Storeroom Lockset
HG Half-Glass Lite	TT Thumbturn Lock
HL Hospital Latchset	VC Volume Control
HMI Hollow Metal	W Wall Phone

KEYPLAN

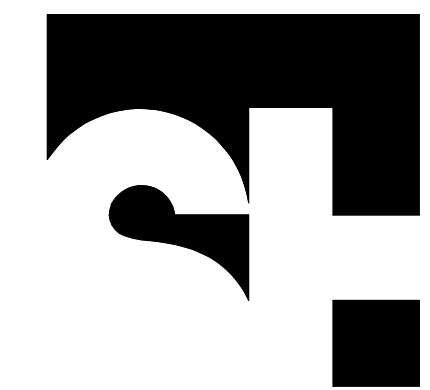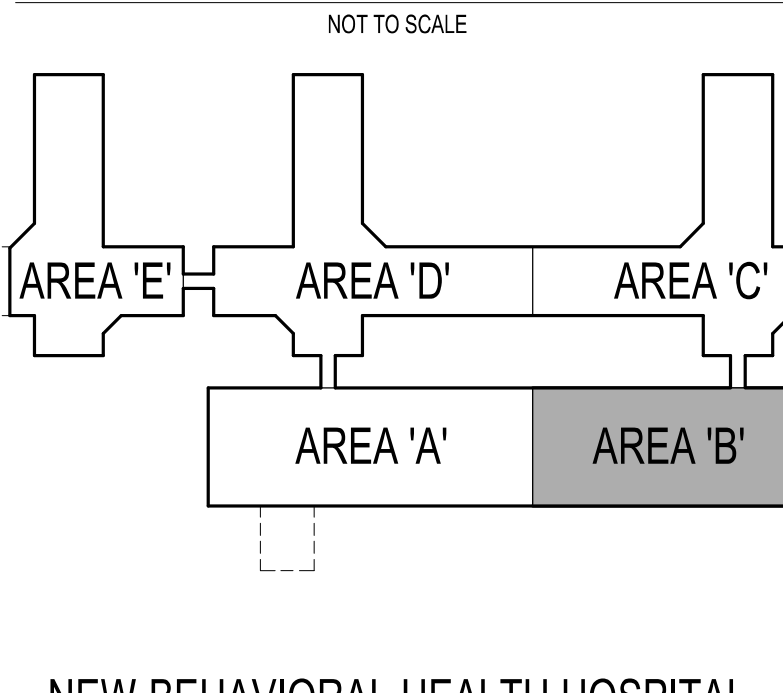

STENGEL-HILL
ARCHITECTURE

613 WEST MAIN STREET
LOUISVILLE, KENTUCKY 40202
502.893.1875
502.893.1876 fax

Civil Engineering



Structural Engineering



Structural Engineering, P.E.


Mechanical/Electrical Engineering



Foodservice Design



Foodservice Group
Experience the Difference

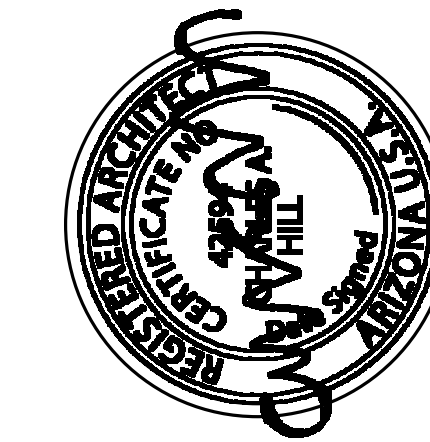


PARTIAL FLOOR PLAN - AREA 'B'
NEW BEHAVIORAL HEALTH HOSPITAL
ACADIA HEALTHCARE COMPANY, INC.
MESA, ARIZONA

31 MAY 2022
AHC2105


A4.1B

DESIGN REVIEW DRAWINGS - NOT FOR CONSTRUCTION

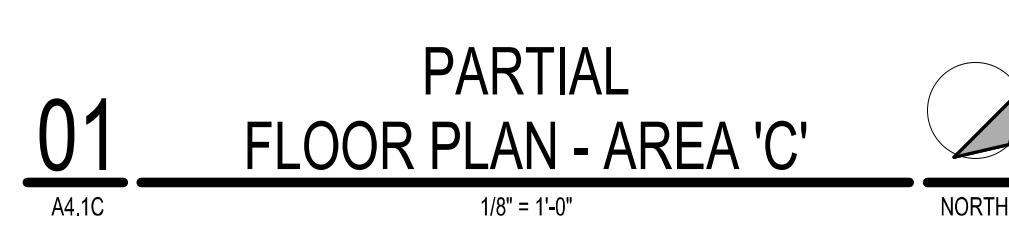

ABBREVIATION LEGEND



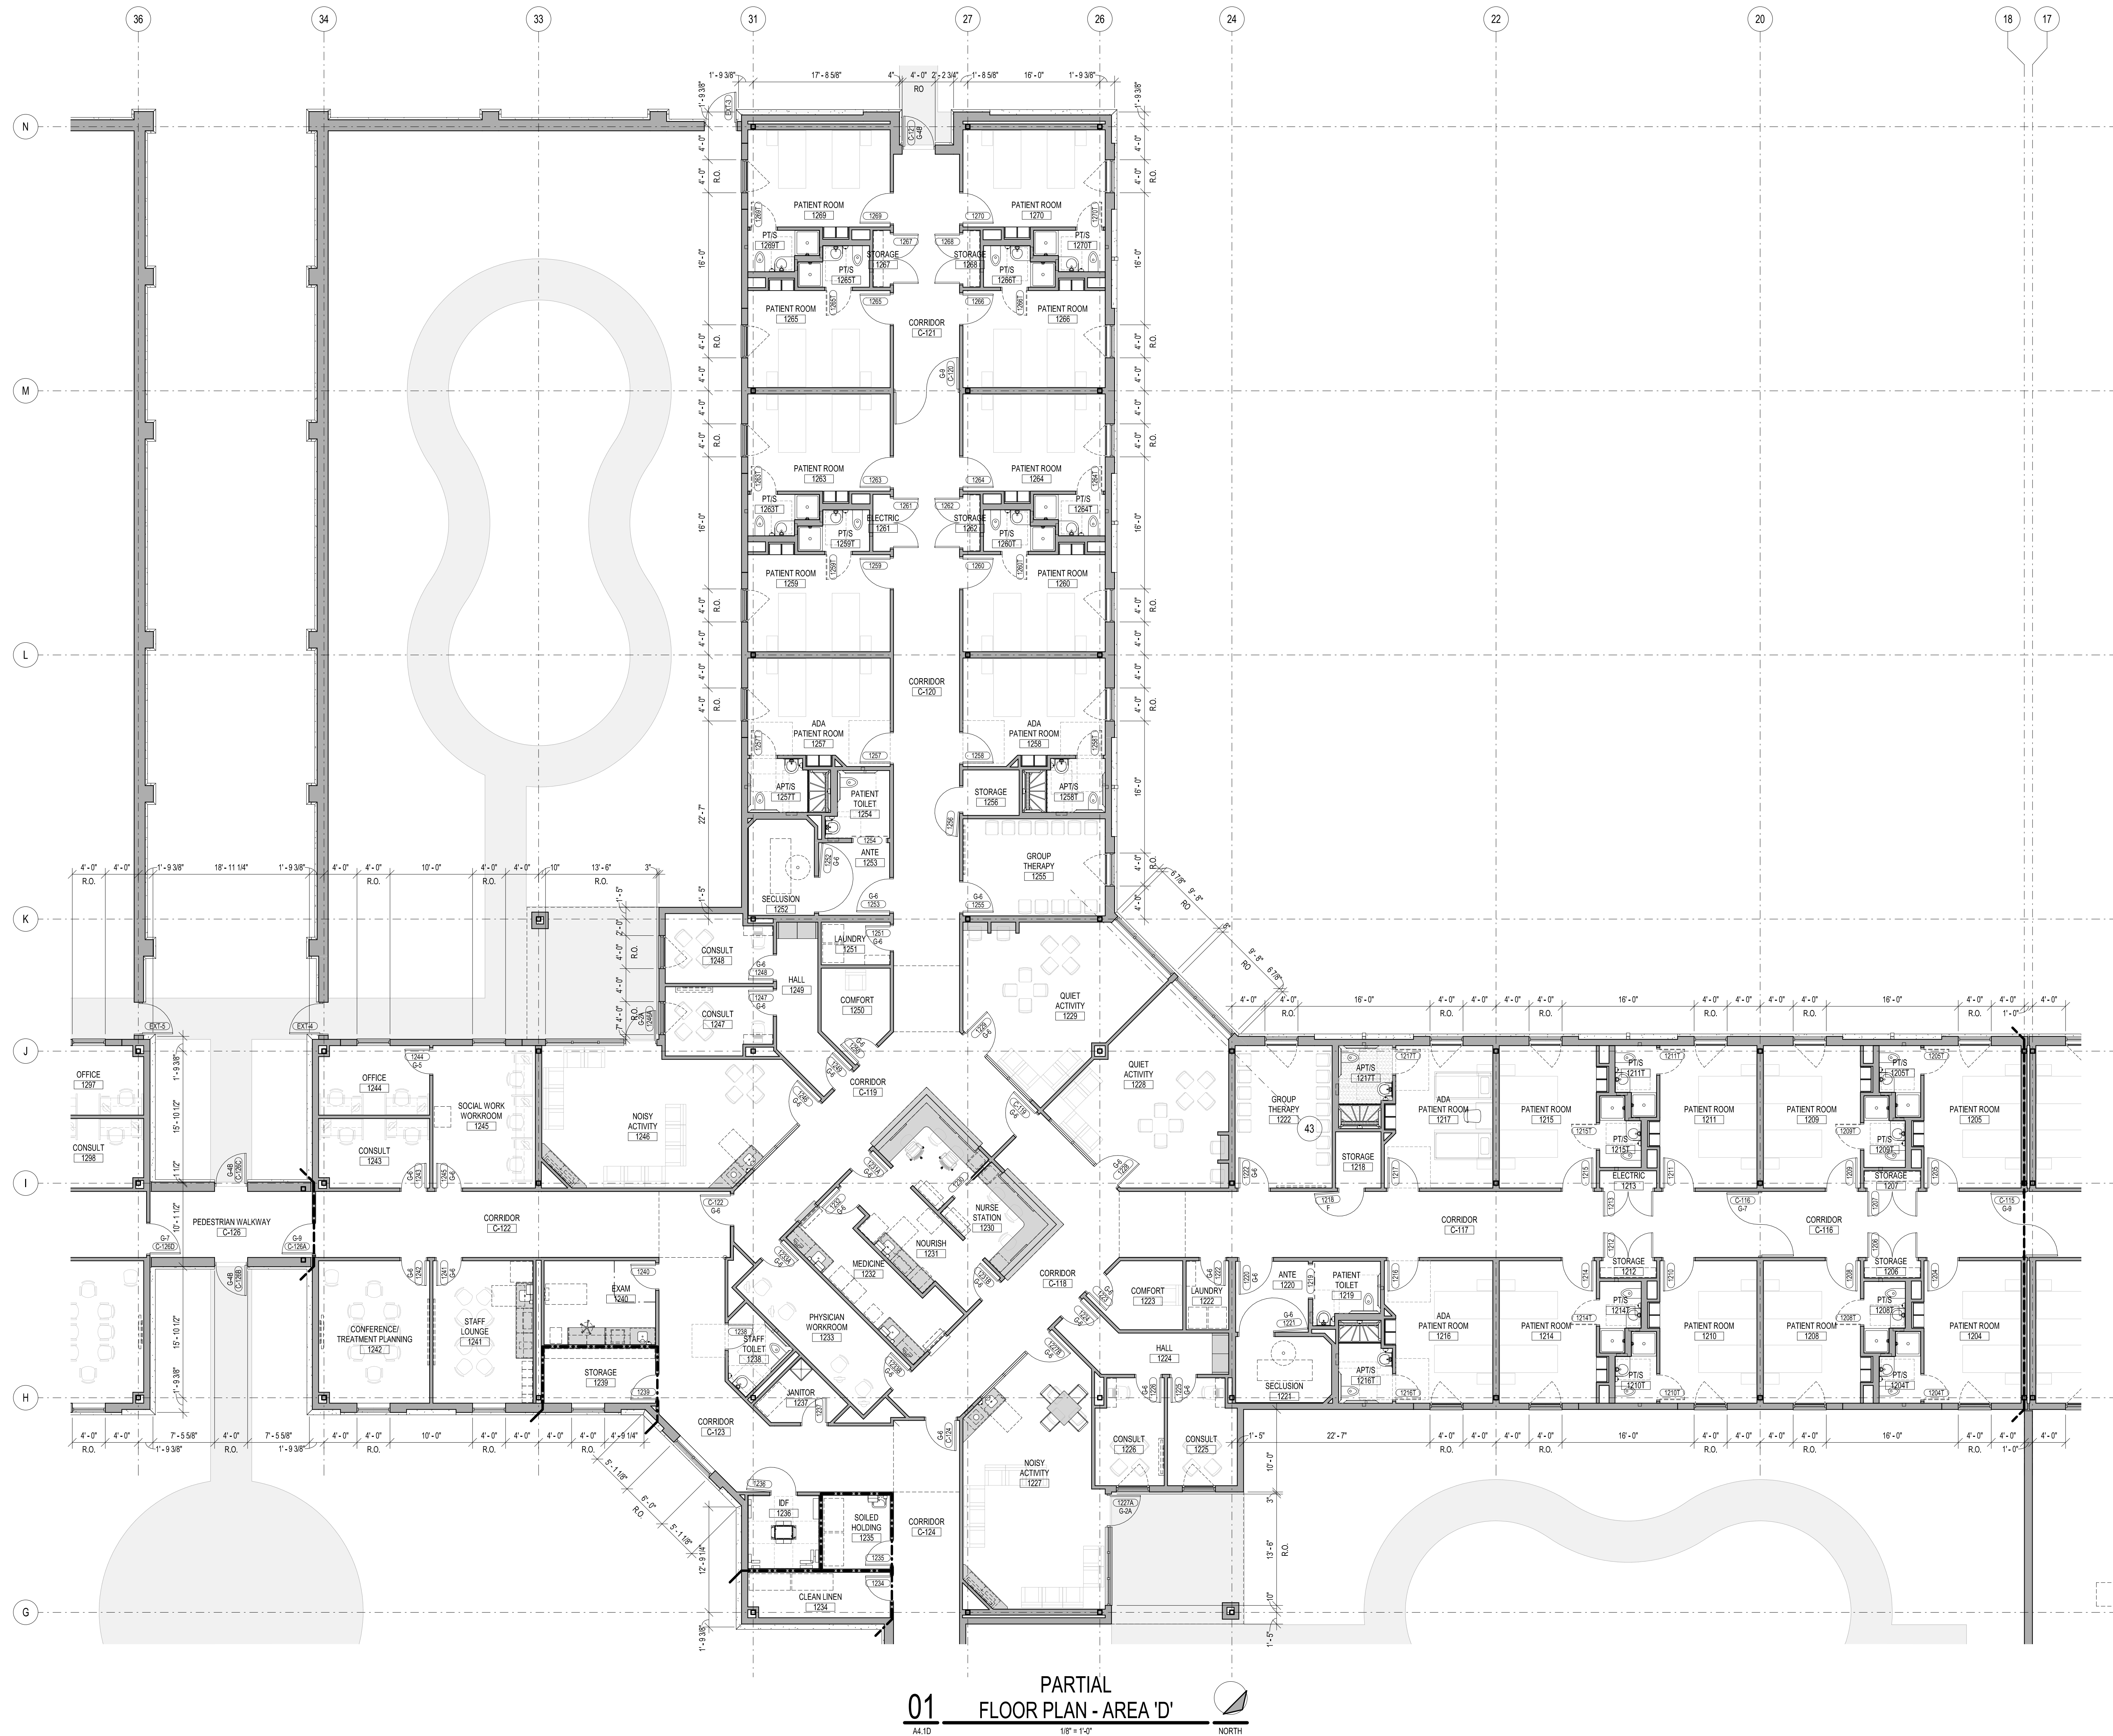

01 PARTIAL FLOOR PLAN - AREA 'D'

SYMBOL LEGEND

FLOOR PLAN SYMBOLS			
ALTER	105	ROOM	DOOR/DOOR NUMBER
PLAN NOTE	EQUIPMENT TAG	ROOM NAME/NUMBER	

CEILING PLAN SYMBOLS			
SUPPLY AIR DIFFUSER	RETURN AIR GRILLE	EXHAUST AIR GRILLE	HANDHEATH THERMOSTAT
2X2 FLUORESCENT LIGHT	1X4 FLUORESCENT LIGHT	2X4 FLUORESCENT LIGHT	SUSPENDED INCANDESCENT LIGHT
RECESSED LIGHT	SMOKE DETECTOR	SPEAKER	EXIT SIGN

PLUMBING SYMBOLS			
LABATORY SINK (WALL MOUNTED)	LABATORY SINK (COUNTER TOP MOUNTED)	WATER CLOSET	
SINK SINK	CLINICAL SINK	MOP SINK	ELECTRIC WATER COOLER

MEDICAL GAS SYMBOLS			
A	N	N2	O
AB	NR	NR	NR
S	V	C	P
VACUUM BOTTLE BLUE	VACUUM	CEILING OUTLET	PATIENT CONSOLE
NCC	LPA1	SVB1	MSA
NITROGEN CONTROL CABINET	LINE PRESSURE ALARM (NUMBER OF ALARMS)	SHUT-OFF VALVE BOX (NUMBER OF VALVES)	MASTER ALARM PANEL

NURSE CALL SYMBOLS			
ELAPSED TIME CLOCK	PHONE LIGHT	EMERGENCY STATION (PULLCORD)	EMERGENCY STATION (PUSHBUTTON)
EMERGENCY STATION (PUSHBUTTON)	STAFF STATION	MASTER STATION	CODE BLUE
STAFF PRESENCE	ANNUNCIATOR PANEL	INTERCOM	CODE BLUE ANNUNCIATOR
SINGLE PATIENT STATION (TIE LINE)	SINGLE PATIENT STATION (TIE LINE)	DOUBLE PATIENT STATION (TIE LINE)	DOUBLE PATIENT STATION (TIE LINE)


ELECTRICAL SYMBOLS			
ABOVE AS NOTED	ABOVE AS NOTED	ABOVE AS NOTED	ABOVE AS NOTED
12" AFF DUPLEX RECEPTACLE	12" AFF DUPLEX RECEPTACLE	12" AFF DUPLEX RECEPTACLE	12" AFF DUPLEX RECEPTACLE
12" AFF TELEPHONE OUTLET	12" AFF TELEPHONE OUTLET	12" AFF TELEPHONE OUTLET	12" AFF TELEPHONE OUTLET

ABBREVIATION LEGEND

AB	Automatic Flush Bolts	HO	Hold-Open Arm on Closer
AI	Alphabetic System	HPR	Hospital Privacy Lockset
AKS	Automatic Key Switch	IB	Integral Blinds
AL	Aluminum	IL	Interlock Door Switch
AO	Automatic Operator	IN	Institutional Lockset
AP	Armor Plate	IR	Infrared Facsimile Control
CAM	Camera	KP	Kick Plate
CG	Corner Guard	KPD	Keypad
CL	Closer	LR	Ligature Resistant
CR	Classroom Lockset	MB	Manual Flush Bolts
CRO	Card Reader	MMS	Momentary Key Switch
CS	Communication Switch/Outlet	NO	Narrow-Gloss Lile
DA	Double-Acting Door	OF	Office Lockset
DB	Deadbolt	OI	Occupancy Indicator
DE	Delayed-Egress Door System	PA	Passage Latchset
DR	Door Release Button	PB	Panic Button
DS	Dampers	PD	Pocket Door
EG	Edge Guard	PH	Panic Hardware
EHD	Electromagnetic Hold-Open	PP	Push/Pull Door Hardware
EL	Electromagnetic Lock	PHD	Push/Pull Lockset
EM	Emergency Circuit	PI	Privacy Lockset
ES	Electric Strike	RD	Room-Curtain Motion Detector
FB	Fire Barrier	RM	Room Motion Detector
FE	Fire Extinguisher	RP	Recessed Door Pull
FEC	Fire Extinguisher Cabinet	SB	Smoke Barrier
FG	Full-Glass	SL	Electromagnetic Shutter Lock
GFI	Ground Fault Circuit Interrupter	SR	Shower Lockset
HG	Half-Glass Lite	TT	Thumbturn Lock
HL	Hospital Latchset	VC	Vacuum Control
HMI	Hollow Metal	W	Wall Phone

KEYPLAN

NOT TO SCALE

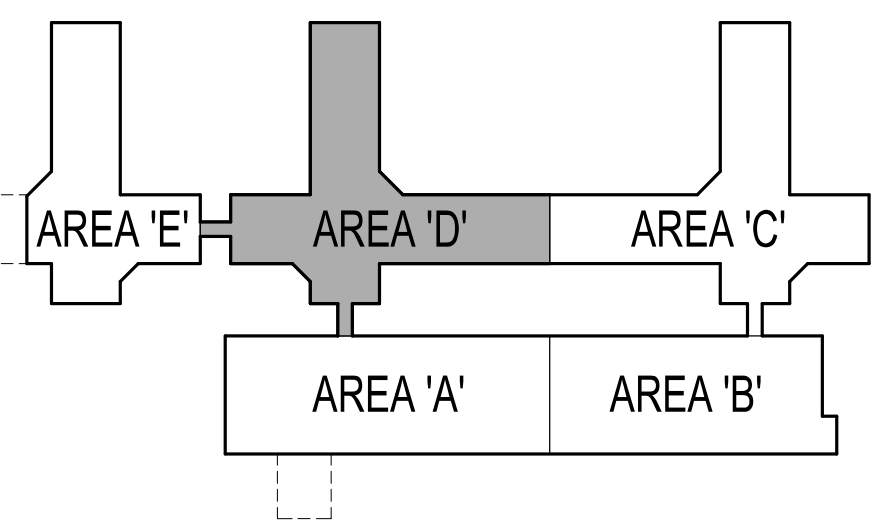

NEW BEHAVIORAL HEALTH HOSPITAL



STENGEL-HILL ARCHITECTURE

613 WEST MAIN STREET
LOUISVILLE, KENTUCKY 40202
502.893.1875
502.893.1876 fax

Civil Engineering



Structural Engineering





Mechanical/Electrical Engineering



Foodservice Design




Foodservice Group
Experience the Difference

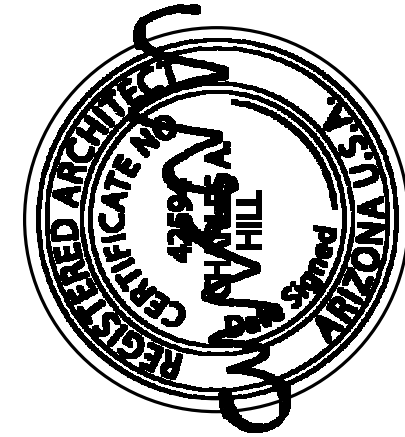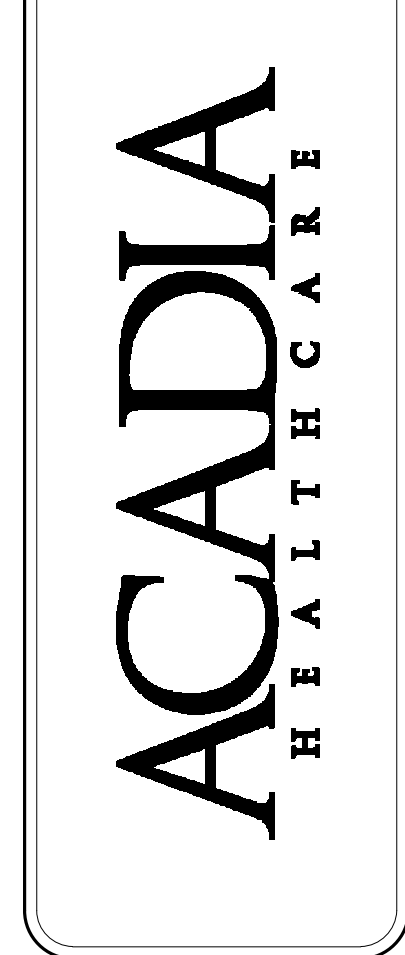

PARTIAL FLOOR PLAN - AREA 'D'
NEW BEHAVIORAL HEALTH HOSPITAL
ACADIA HEALTHCARE COMPANY, INC.
MESA, ARIZONA

31 MAY 2022
AHC2105

A4.1D

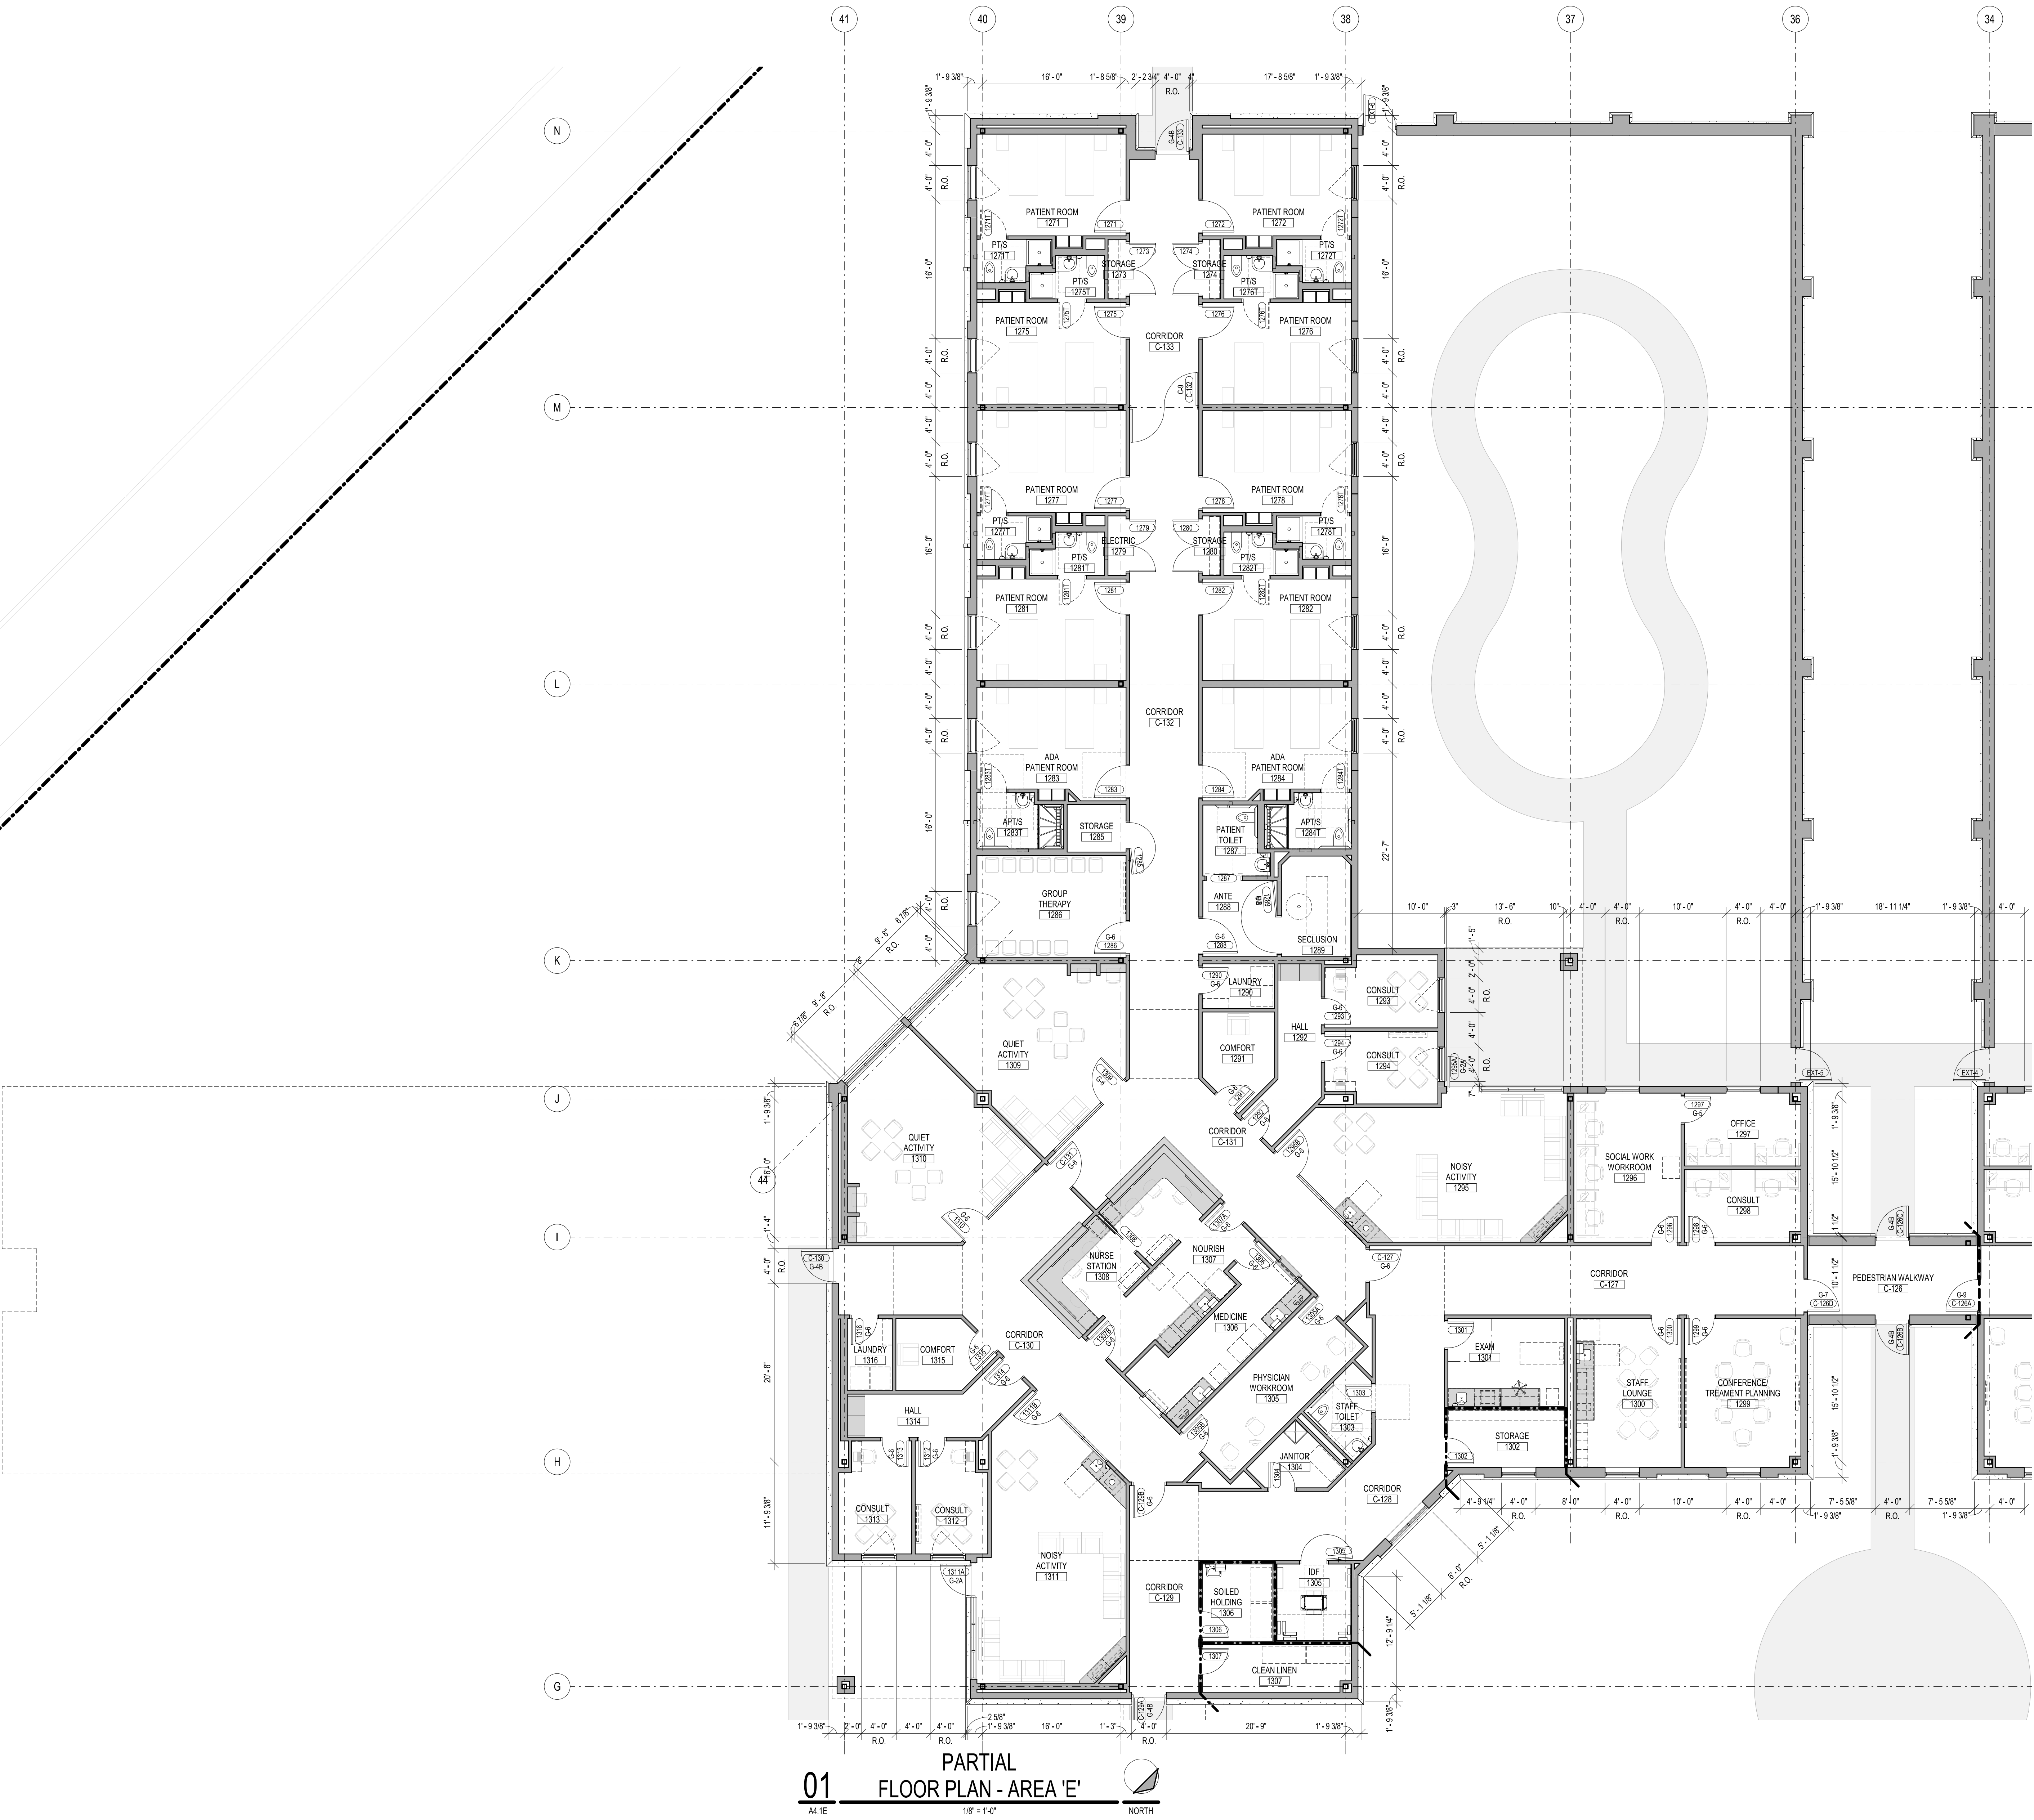

01 PARTIAL FLOOR PLAN - AREA 'E'

SYMBOL LEGEND

FLOOR PLAN SYMBOLS

ALTER	105	ROOM	106
PLAN NOTE	EQUIPMENT TAG	ROOM NAME/NUMBER	DOOR/DOOR NUMBER

CEILING PLAN SYMBOLS

SUPPLY AIR DIFFUSER	RETURN AIR GRILLE	EXHAUST AIR GRILLE	HANDHEATH THERMOSTAT
2X2 FLUORESCENT LIGHT	1X4 FLUORESCENT LIGHT	2X4 FLUORESCENT LIGHT	SUSPENDED INDIRECT LIGHT
RECESSED LIGHT	SMOKE DETECTOR	SPEAKER	EXIT SIGN

PLUMBING SYMBOLS

LABATORY (WALL MOUNTED)	LABATORY (COUNTERTOP MOUNTED)	LABATORY (COUNTERTOP MOUNTED)	WATER CLOSET
SINK/SINK	CLINICAL SINK	MOP SINK	ELECTRIC WATER COOLER

MEDICAL GAS SYMBOLS

A	N	N2	O
AIR	NITROGEN	NITROUS OXIDE	OXYGEN
S	V	O2/VIS	P
VACUUM BOTTLE BLUE	VACUUM	CEILING OUTLET	PATIENT CONSOLE
NCC	LPA1	SVB1	MSA
NITROGEN CONTROL CABINET	LINE PRESSURE ALARM (NUMBER OF LINES)	SHUT-OFF VALVE BOX (NUMBER OF VALVES)	MASTER ALARM PANEL

NURSE CALL SYMBOLS

ELAPSED TIME CLOCK	PHONE LIGHT	EMERGENCY STATION (PULLCORD)	EMERGENCY STATION (PUSHBUTTON)
EMERGENCY STATION (PUSHBUTTON)	STAFF/OUT STATION	MASTER STATION	CODE BLUE
STAFF PRESENCE	ANNUNCIATOR PANEL	INTERCOM	CODE BLUE ANNUNCIATOR
SINGLE PATIENT STATION (TELEPHONE)	SINGLE PATIENT STATION (PULLCORD)	DOUBLE PATIENT STATION (PULLCORD)	DOUBLE PATIENT STATION (PUSHBUTTON)

ELECTRICAL SYMBOLS

ABOVE AS NOTED	ABOVE AS NOTED	ABOVE AS NOTED	ABOVE AS NOTED
12" AFF DUPLEX RECEPTACLE	12" AFF DUPLEX RECEPTACLE	12" AFF DUPLEX RECEPTACLE	12" AFF DUPLEX RECEPTACLE
12" AFF TELEPHONE OUTLET	12" AFF TELEPHONE OUTLET	12" AFF TELEPHONE OUTLET	12" AFF TELEPHONE OUTLET

ABBREVIATION LEGEND

AB Automatic Flush Bolts	HO HMD-Open Arm on Closer
AI Alphone System	HPR Hospital Privacy Lockset
AKS Alternate Key Switch	IB Integral Blinds
AL Aluminum	IL Interlock Door Switch
AO Automatic Operator	IN Institutional Lockset
AP Armor Plate	IR Infrared Passout Control
CAM Camera	KP Kick Plate
CG Corner Guard	KPD Keypad
CL Closer	LR Luggage Resistant
CR Classroom Lockset	MB Manual Flush Bolts
CRO Card Reader	MMS Momentary Key Switch
CS Combination Switch/Outlet	NO Non-Open Glass Life
DA Double-Acting Door	OF Office Lockset
DB Deadbolt	OI Occupancy Indicator
DE Delayed-Egress Door System	PA Passage Latchset
DR Door Release Button	PB Panic Button
DS Downspout	PD Pocket Door
EG Edge Guard	PH Panic Hardware
EHD Electromagnetic Hold-Open	PP Push/Pull Door Hardware
EL Electromagnetic Lock	PHD Push/Pull
EM Emergency Circuit	PI Privacy Lockset
ES Electric Strike	RD Room-Curtain Motion Detector
FB Fire Barrier	RM Room Motion Detector
FE Fire Extinguisher	RP Recessed Door Pull
FEF Fire Extinguisher Cabinet	SB Smoke Barrier
FG Full-Glass	SL Electromagnetic Shutter Lock
GFI Ground Fault Circuit Interrupter	SR Storeroom Lockset
HG Half-Glass Lite	TT Thumbturn Lock
HL Hospital Latchset	VC Volume Control
HMI Hollow Metal	W Wall Phone

KEYPLAN

NOT TO SCALE

NEW BEHAVIORAL HEALTH HOSPITAL

STENGEL-HILL ARCHITECTURE

613 WEST MAIN STREET
LOUISVILLE, KENTUCKY 40202
502.893.1875
502.893.1876 fax

Civil Engineering

Structural Engineering

STRUCTURAL ENGINEERING, P.E.

Mechanical/Electrical Engineering

Foodservice Design

Foodservice Group
Experience the Difference

PARTIAL FLOOR PLAN - AREA 'E'

NEW BEHAVIORAL HEALTH HOSPITAL

ACADIA HEALTHCARE COMPANY, INC.

MESA, ARIZONA

31 MAY 2022

AHC2105

A4.1E


DESIGN REVIEW DRAWINGS - NOT FOR CONSTRUCTION

GENERAL NOTES

- ALL DIMENSIONS ARE FROM FINISH FACE OF WALL TO FINISH FACE OF WALL UNLESS OTHERWISE NOTED.
- SEALANT TYPICAL AT ALL INTERSECTING JOINTS OF ALL ASSEMBLIES. (REFERENCE SPECIFICATION SECTION 079200)
- PROVIDE CEMENTITIOUS FIREPROOFING MATERIAL AT ALL ASSEMBLIES NOTED WITHIN SPECIFICATION SECTION 078116.


SECTION KEYNOTES

- | | |
|-----------|--|
| 042100.A1 | FACE BRICK (TYPE AS INDICATED) |
| 042200.A6 | NOMINAL 4" X 8" X 16" CONCRETE MASONRY UNIT (REFER TO STRUCTURAL DRAWINGS) |
| 047000.A1 | ADHERED STONE VENEER |
| 047200.A1 | ARCHITECTURAL CAST STONE SILL |
| 047200.A6 | ARCHITECTURAL CAST STONE BAND |
| 054000.A2 | 6" METAL STUDS |
| 061643.A1 | 1/2" CONTINUOUS EXTERIOR SHEATHING BOARD |
| 061643.A3 | 5/8" EXTERIOR PARAPET SHEATHING BOARD |
| 072100.A2 | SPRAY-APPLIED CLOSED-CELL POLYURETHANE FOAM INSULATION (TYPE 3) |
| 072100.A3 | PROVIDE CURTAIN WALL SPANDREL INSULATION (TYPE 4) BEHIND ALL SPECIFIED LOCATIONS OF SPANDREL GLASS (REFERENCE SPECIFICATION SECTION 08000) |
| 072100.A5 | CAVITY WALL INSULATION (TYPE 5) |
| 072100.B2 | EXTRUDED POLYSTYRENE BOARD INSULATION (TYPE 1) |
| 072400.A1 | FORMED EIFS BAND/SILL |
| 072400.A2 | EXTERIOR INSULATION AND FINISH SYSTEM. PROVIDE CONTROL JOINTS (CJ) AND REVEALS (RV) AS INDICATED ON EXTERIOR ELEVATIONS |
| 072500.A1 | FLUID APPLIED WEATHER RESISTANT MEMBRANE |
| 074213.A1 | METAL WALL PANELS (TYPE AS INDICATED) |
| 075423.A5 | 60 MIL TPO MEMBRANE ROOFING TURNED UP UNDER COPING TO FACE OF METAL PANEL/BRICK OR EIFS |
| 077100.A5 | PREFINISHED ALUMINUM COPING SYSTEM |
| 084113.A1 | ALUMINUM FRAMED STOREFRONT/CURTAINWALL SYSTEM ANCHORED PER INSTALLER'S APPROVED DETAILS. REFER TO FRAME ELEVATIONS FOR STOREFRONT/CURTAINWALL TYPE |
| 085600.A1 | ALUMINUM FRAMED PSYCHIATRIC WINDOW |
| 086000.A1 | TRANSLUCENT GLASS. REFER TO FRAME ELEVATIONS FOR SPECIFIED GLAZING TYPE |
| 086000.A2 | SPANDREL GLASS. REFER TO FRAME ELEVATIONS FOR SPECIFIED GLAZING TYPE |
| 088000.A4 | OBSCURE GLASS. REFER TO FRAME ELEVATIONS FOR SPECIFIED GLAZING TYPE |
| 092900.A1 | 5/8" GYPSUM WALLBOARD. REFER TO PARTITION TYPES SHEET AS 3. |
| 092900.B8 | 5/8" PAINTED EXTERIOR GYPSUM BOARD SOFFIT |

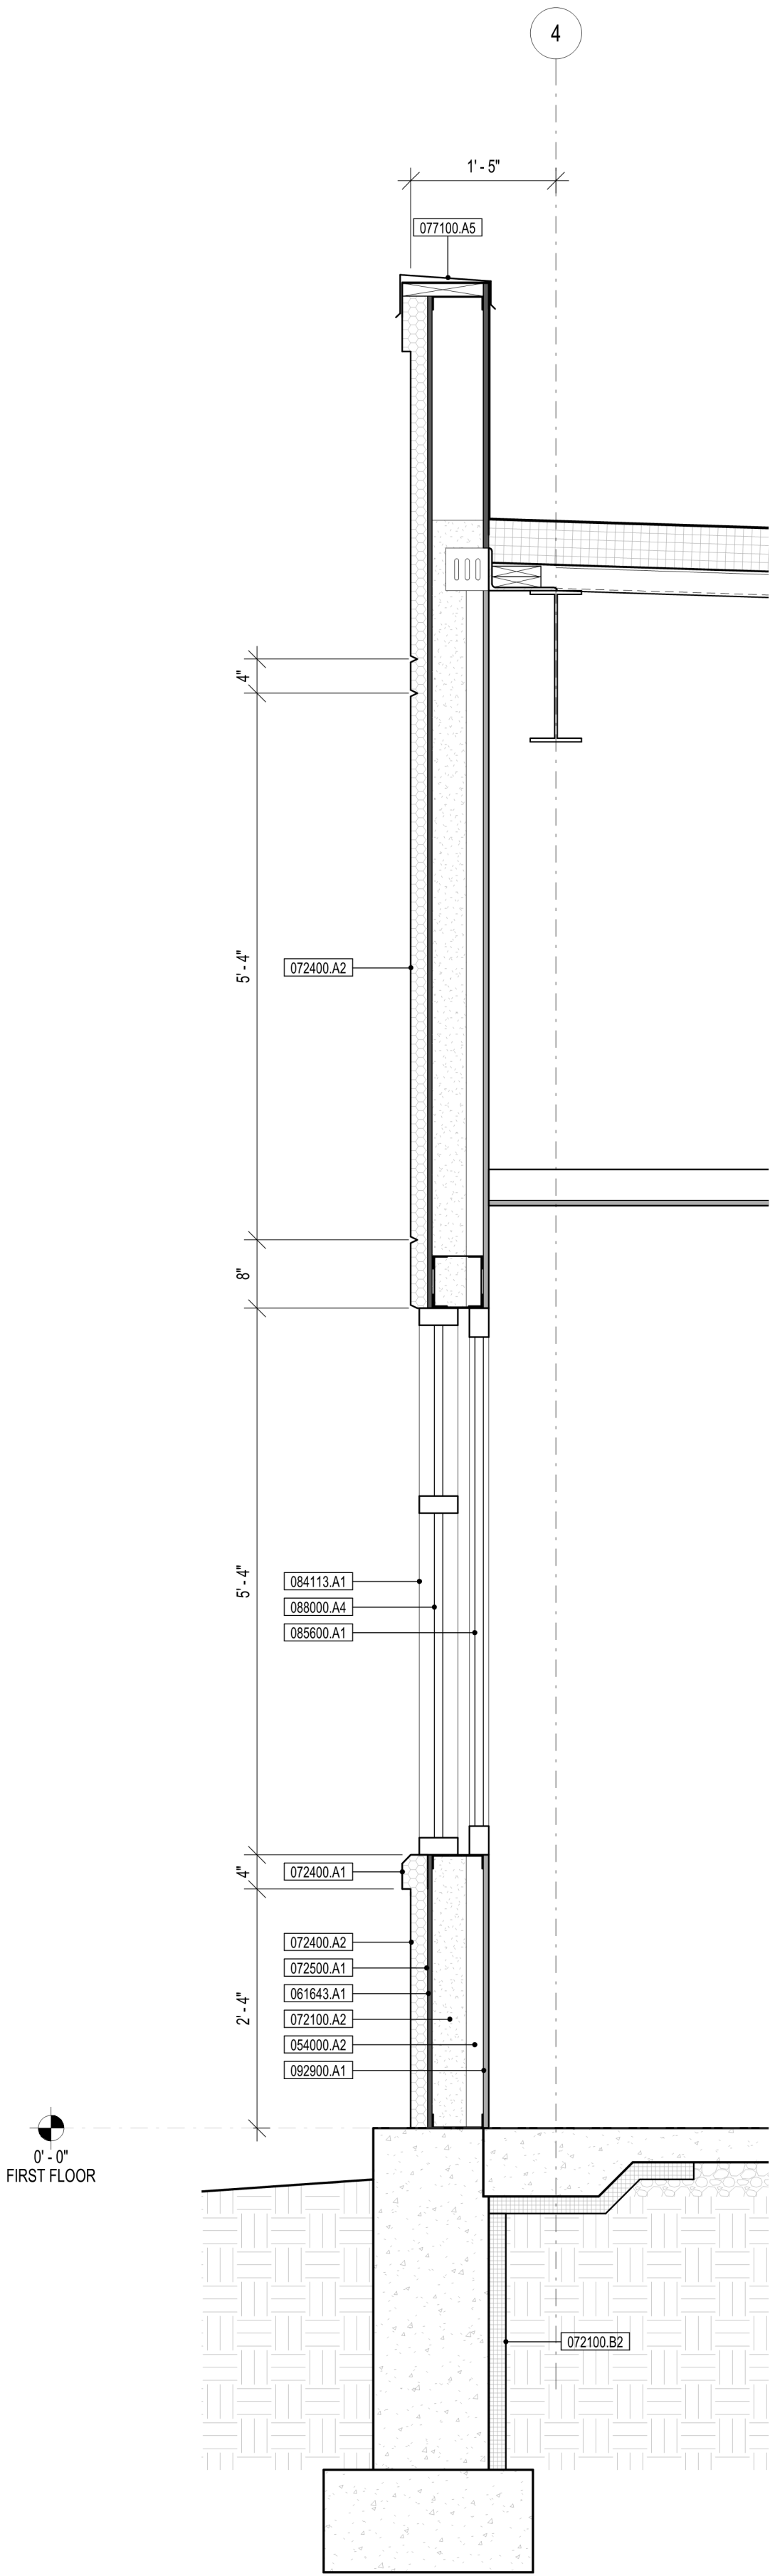


03 WALL SECTION

A8.0 3/4" = 1'-0"

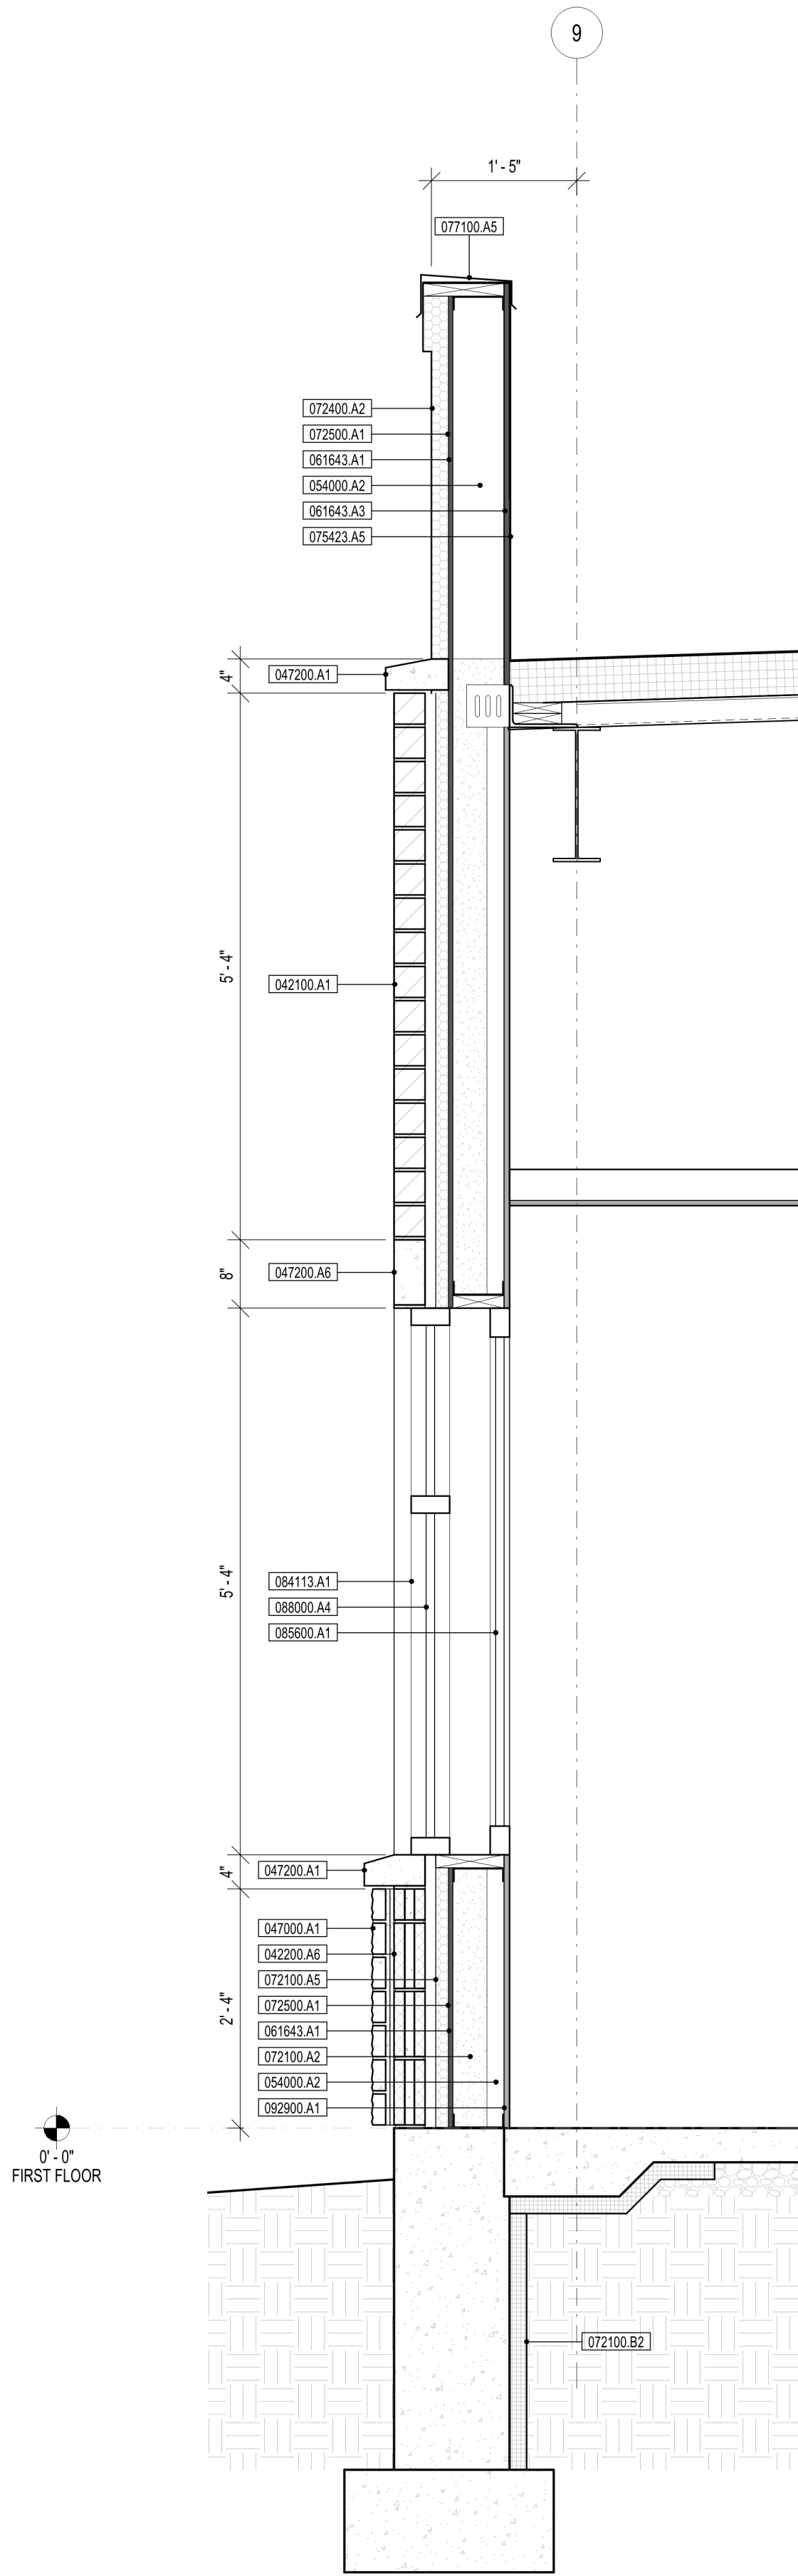


02 WALL SECTION

A8.0 3/4" = 1'-0"

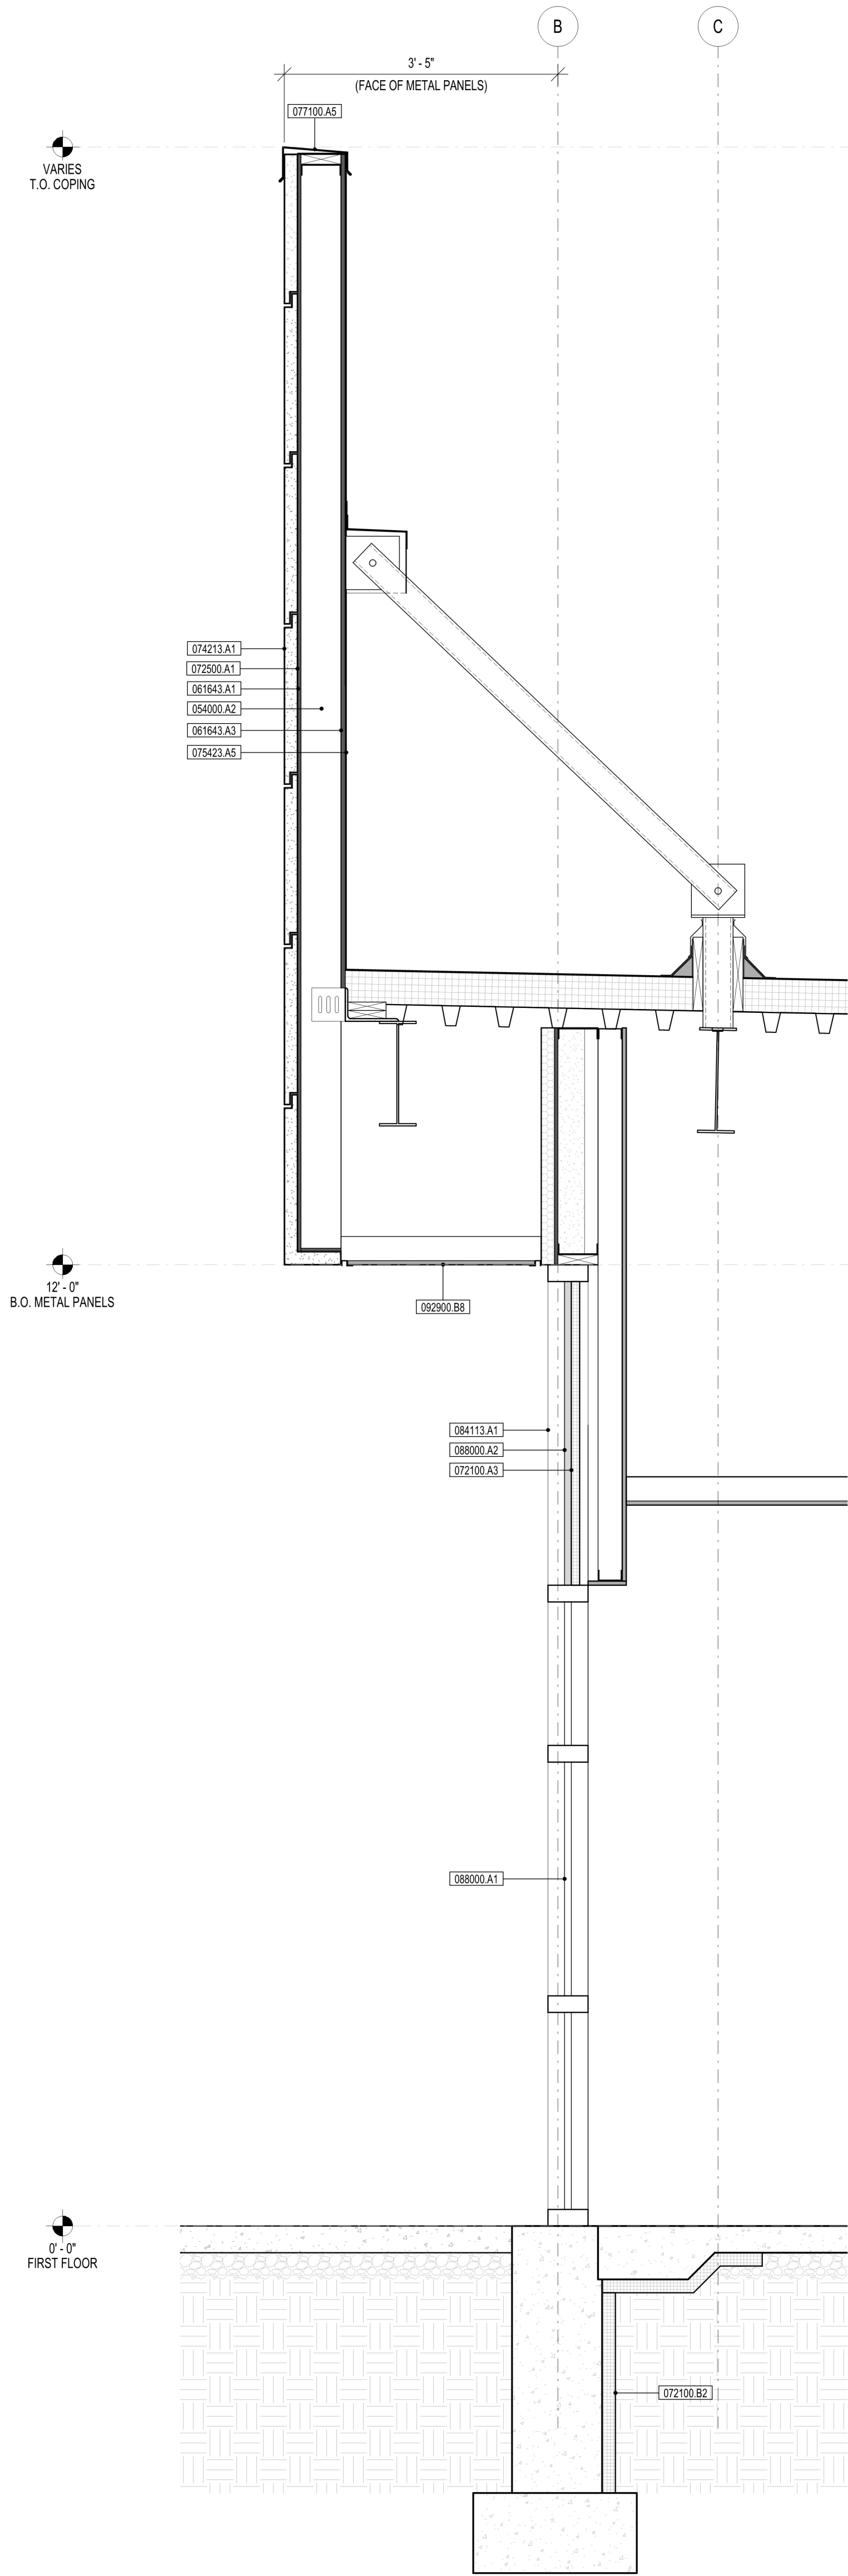

01 WALL SECTION

A8.0 3/4" = 1'-0"

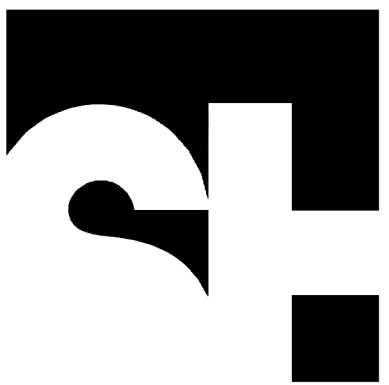

STENGEL-HILL
ARCHITECTURE

613 WEST MAIN STREET
LOUISVILLE, KENTUCKY 40202

502.893.1875
502.893.1876 fax

Civil Engineering





Structural Engineering



Mechanical/Electrical Engineering



Foodservice Design

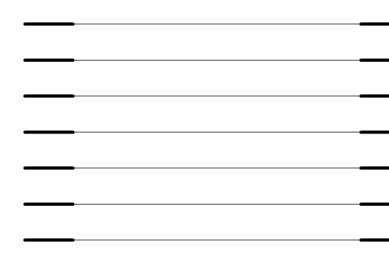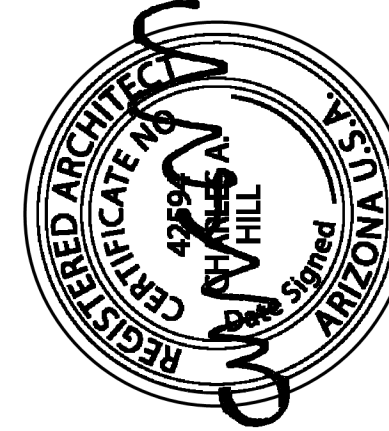

31 MAY 2022
AHC2105

A8.0

DESIGN REVIEW DRAWINGS - NOT FOR CONSTRUCTION




ROOF PLAN KEYNOTES

ROOF PLAN KEYNOTES

GENERAL NOTES

1. REFERENCE CIVIL, STRUCTURAL, MECHANICAL, PLUMBING, AND ELECTRICAL DRAWINGS FOR DELINEATION OF ALL ASSEMBLIES WITHIN THEIR RESPECTIVE PORTIONS OF WORK.
2. CONTRACTOR SHALL VERIFY FINAL CONFIGURATION OF ALL EQUIPMENT, INCLUDING CONTRACTOR FURNISHED CIVIL, STRUCTURAL, ARCHITECTURAL, MECHANICAL, PLUMBING, AND ELECTRICAL ITEMS ASSOCIATED WITH EQUIPMENT, WITH OWNER AND ARCHITECT PRIOR TO COMMENCEMENT OF CONSTRUCTION.
3. COORDINATE LOCATIONS OF MECHANICAL PLUMBING, AND/OR ELECTRICAL ROOF PENETRATIONS, CURBS, AND/OR EQUIPMENT WITH ARCHITECT AND MPE ENGINEER PRIOR TO COMMENCEMENT OF CONSTRUCTION.
4. TYPICAL ROOF SLOPE SHALL BE 1/4"1'12".
5. MINIMUM THICKNESS OF ROOF INSULATION SHALL BE 2" AT ROOF DRAINS. REFERENCE ROOF SYSTEM DIAGRAM BELOW.
6. EACH SCUPPER/DOWNSPOUT ASSEMBLY FOR PRIMARY ROOF DRAINAGE SHALL RECEIVE A THROUGH-WALL SCUPPER ASSEMBLY INSTALLED ADJACENT TO PRIMARY SCUPPER/DOWNSPOUT TO SERVE AS OVERFLOW.
7. PROVIDE SNOW GUARDS AT LOW SIDE OF ALL SHEET METAL ROOF, PER SPECIFICATION SECTION 07250.

ROOF SYSTEM DIAGRAMS

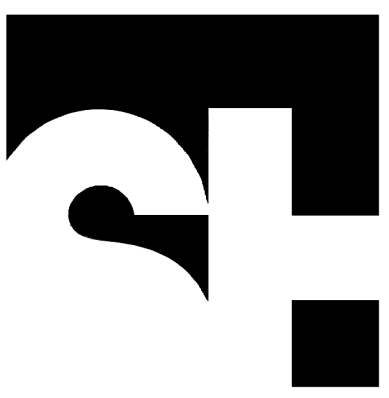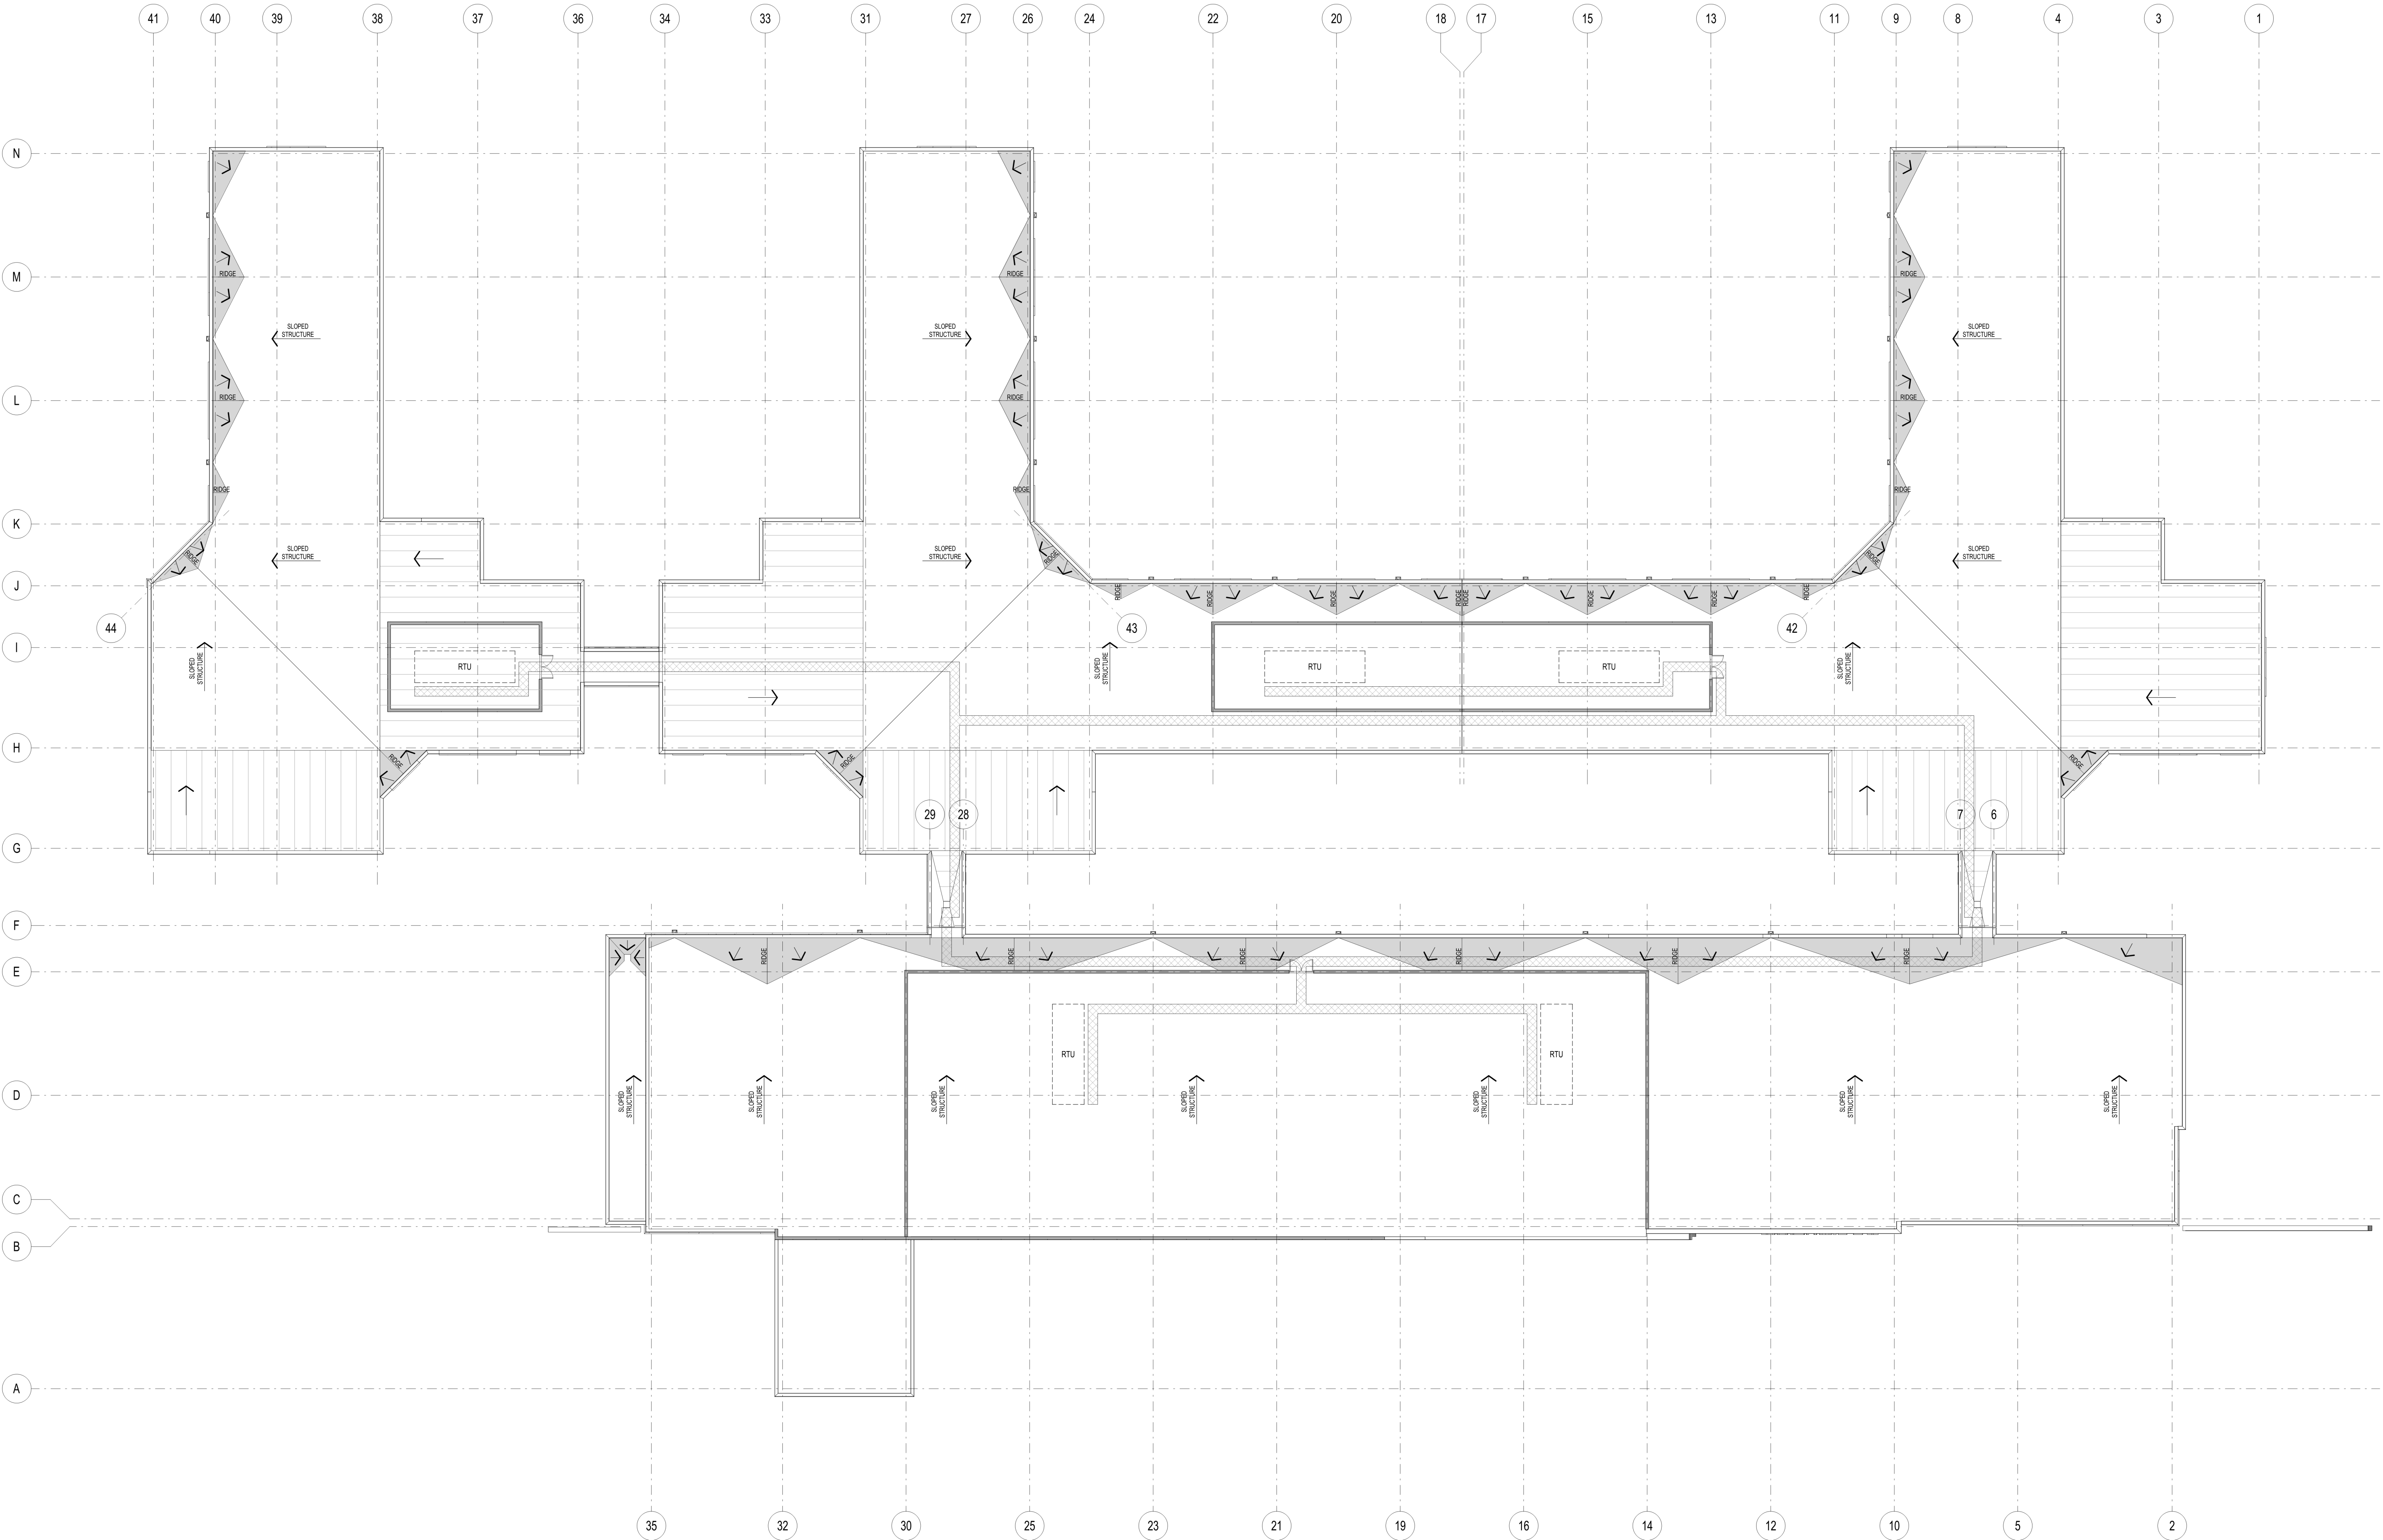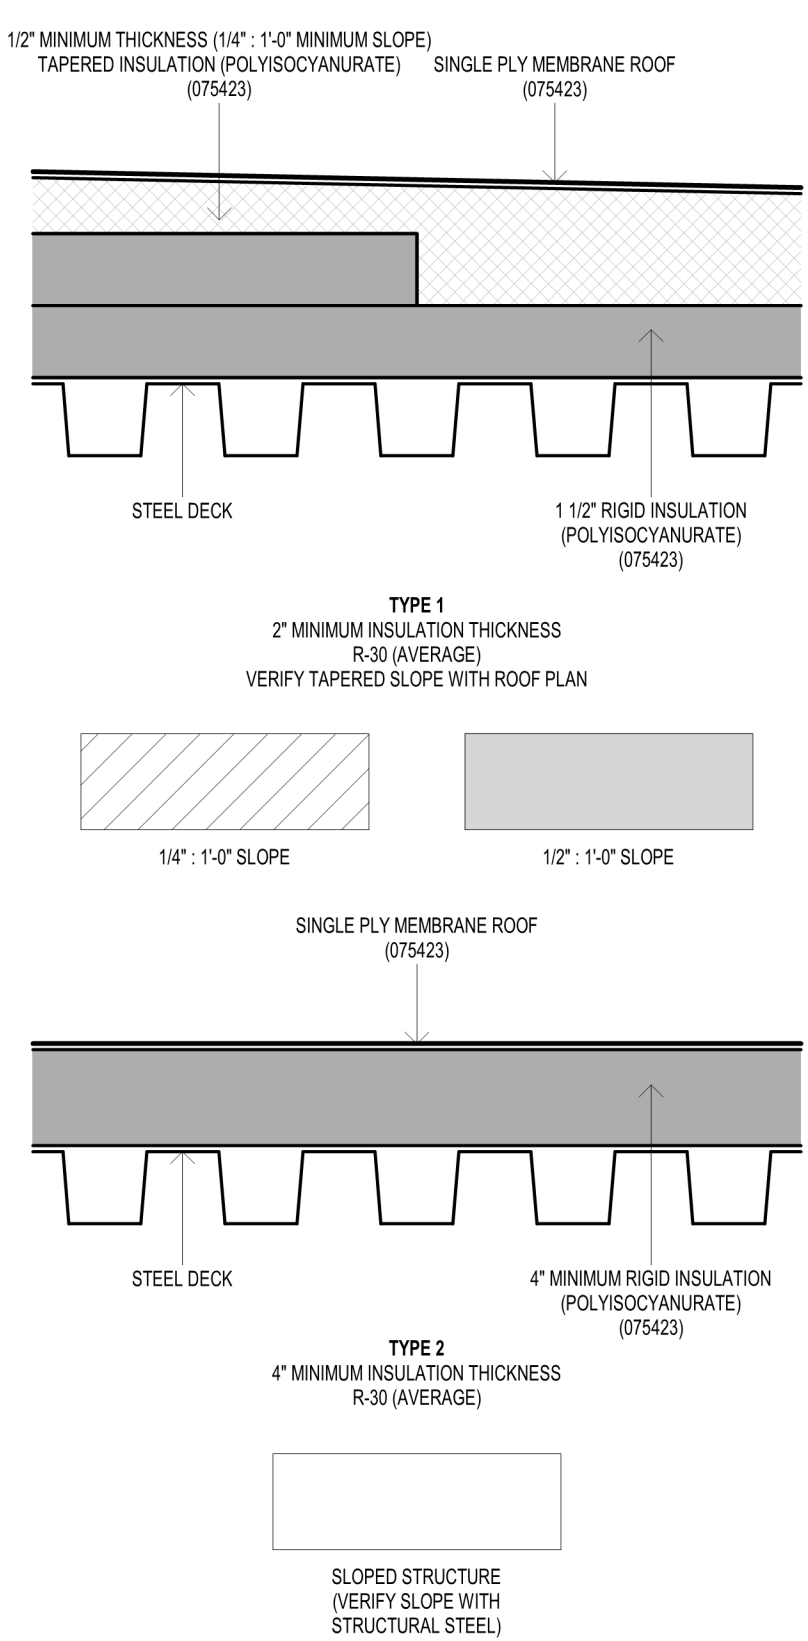

STENGEL HILL
ARCHITECTURE

613 WEST MAIN STREET
LOUISVILLE, KENTUCKY 40202

502.893.1875
502.893.1876 fax

Civil Engineering




Structural Engineering




Mechanical/Electrical Engineering



Foodservice Design

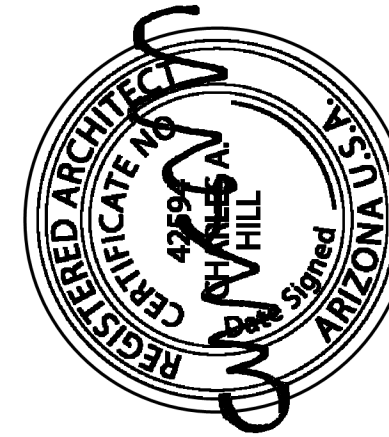

ROOF PLAN
NEW BEHAVIORAL HEALTH HOSPITAL
ACADIA HEALTHCARE COMPANY, INC.
MESA, ARIZONA

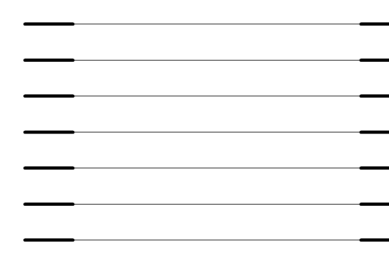

31 MAY 2022
AHC2105

DESIGN REVIEW DRAWINGS - NOT FOR CONSTRUCTION