

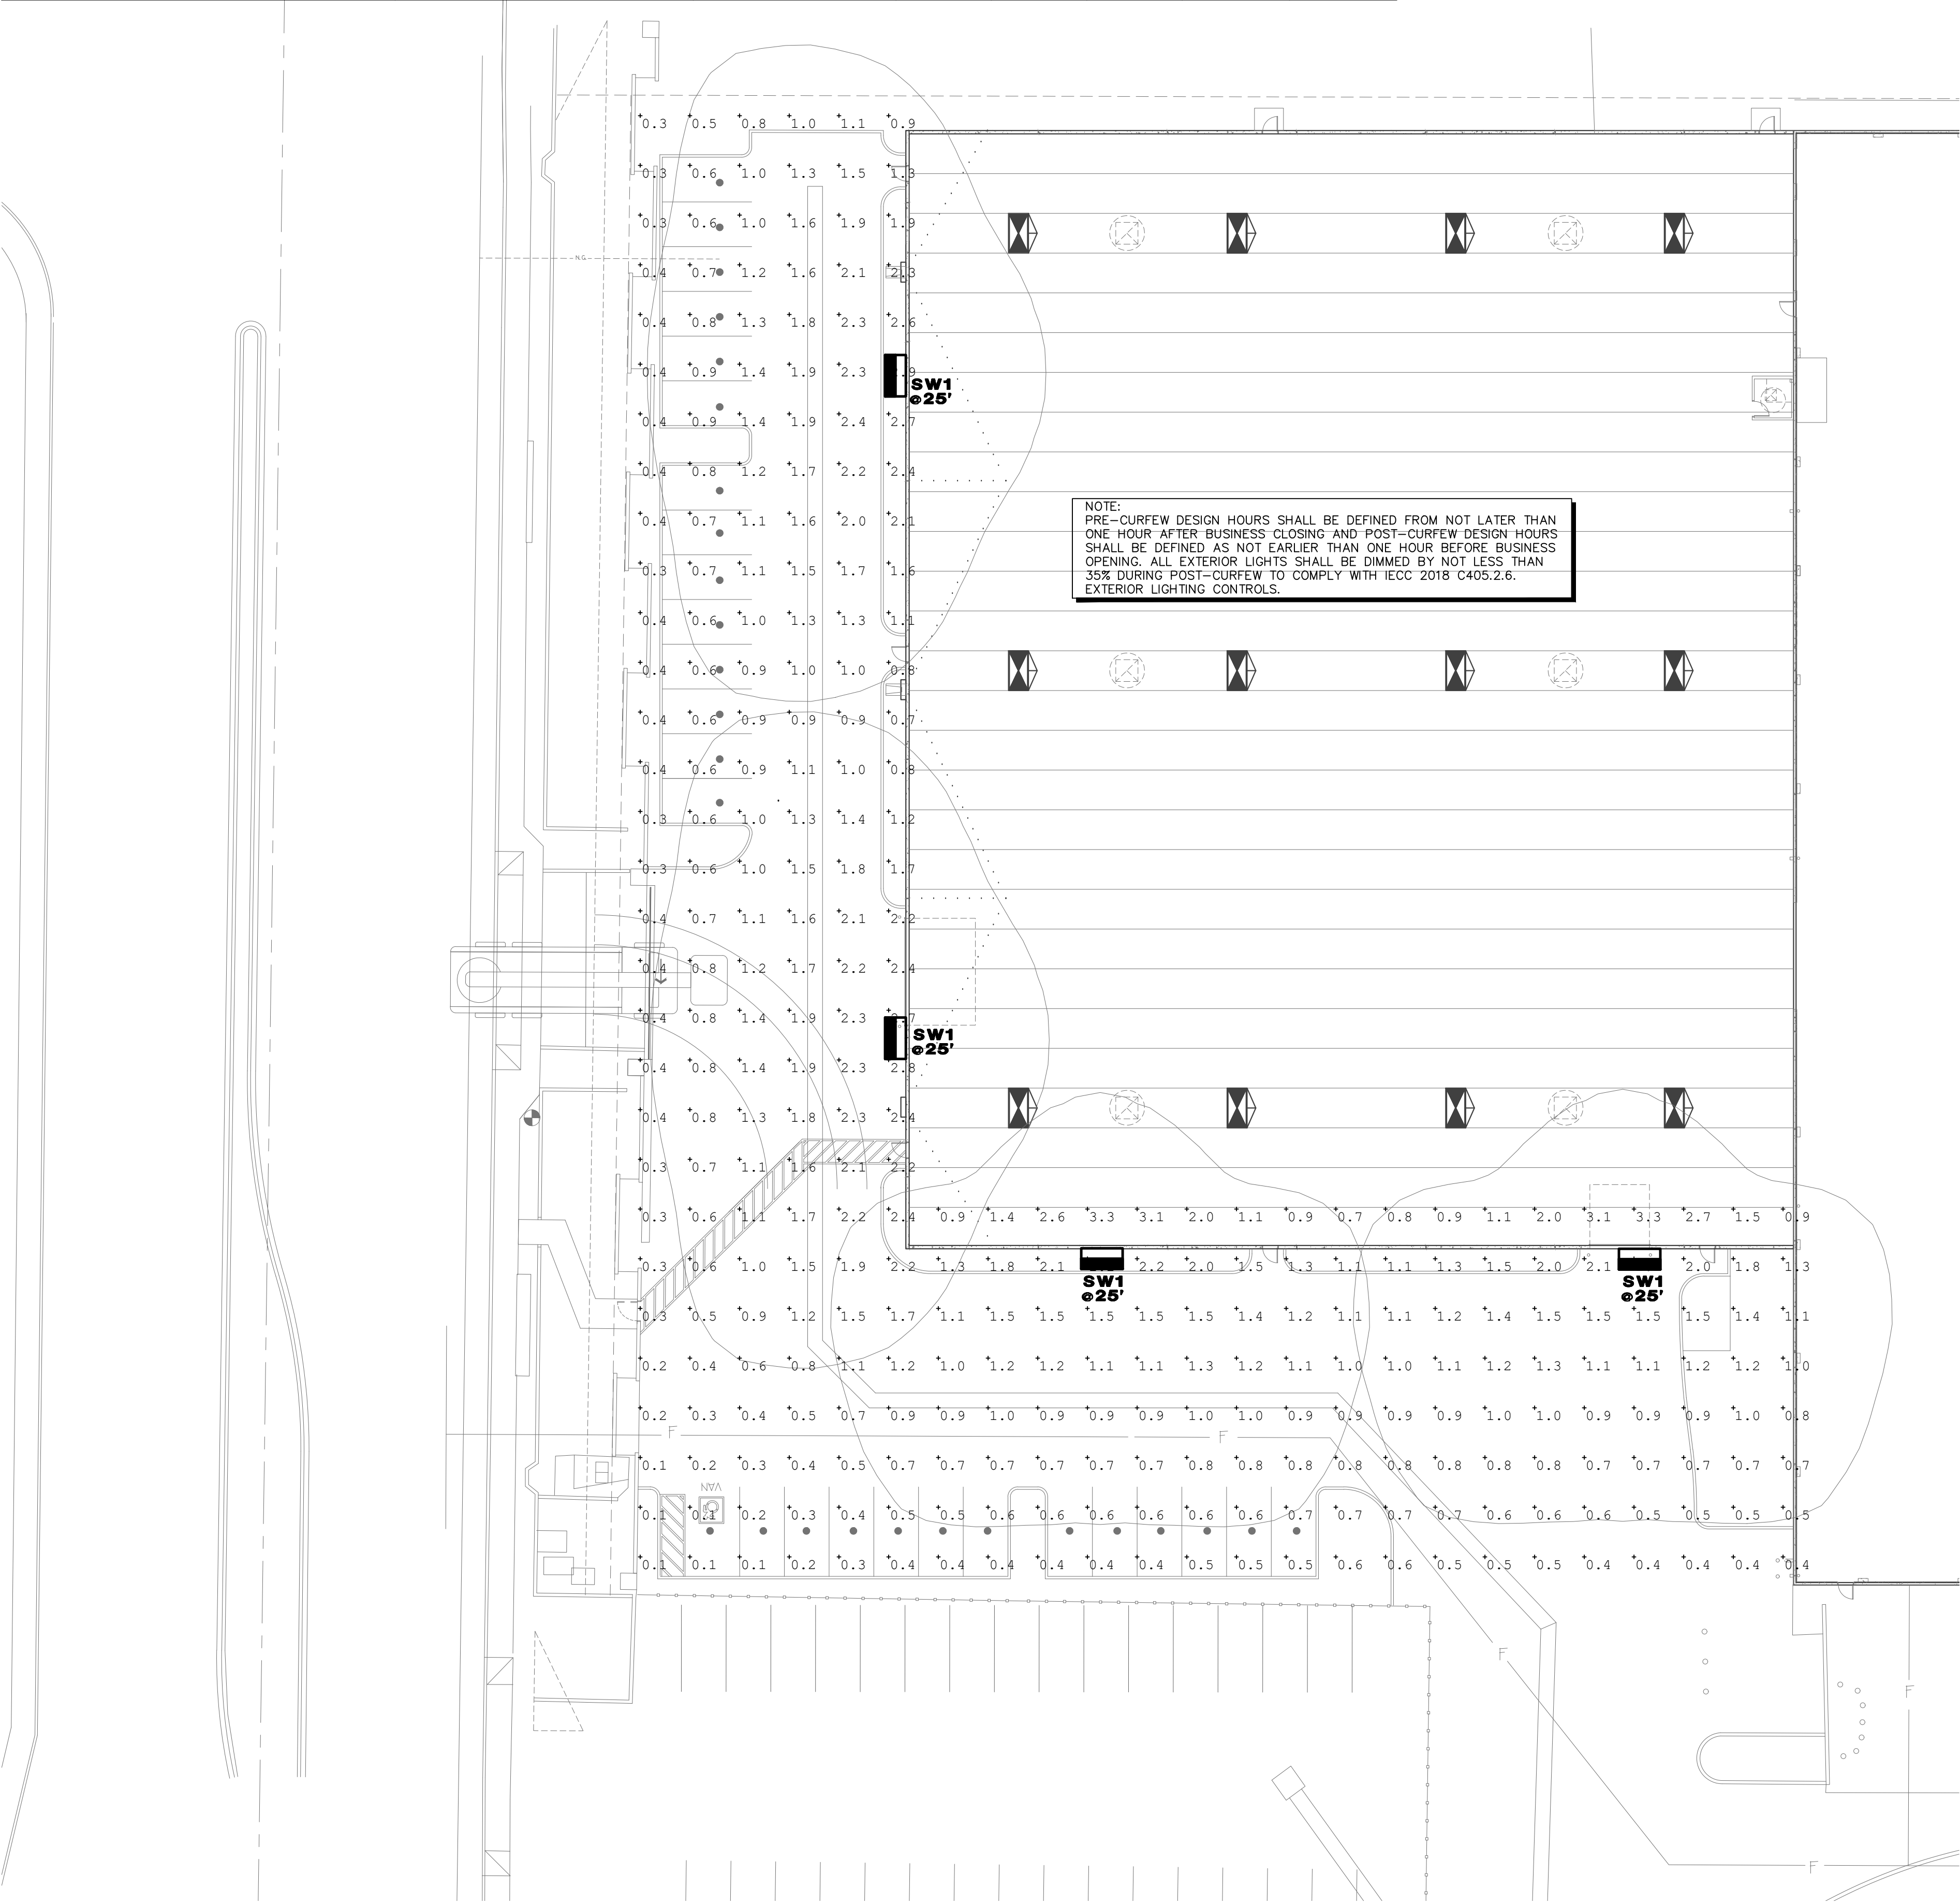


Luminaire Schedule									
Qty	Label	Symbol	Manufacturer	Description	MH	LLF	Lumens	Watts	Total Watts
2	SW1	■	U.S. ARCHITECTURAL LIGHTING	RZR-WM3-PLD-III-M-60LED-875mA-NW	25'	0.900	20637	161.9	323.8
2	SW2	■	U.S. ARCHITECTURAL LIGHTING	RZR-WM3-PLD-IV-FT-60LED-875mA-NW	25'	0.900	18658	161.9	323.8

Calculation Summary							
Label	CalcType	Units	Avg	Max	Min	Avg/Min	Max/Min
Site_Planar	Illuminance	Fc	1.10	3.3	0.1	11.00	33.00

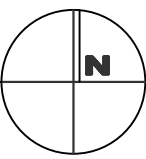


ELECTRICAL SITE PHOTOMETRICS - POST-CURFEW

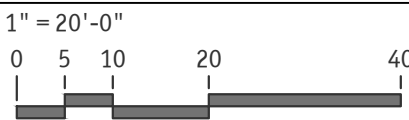

DESIGN CODES	
IECC: 2018	NEC: 2017

ELECTRICAL CONTRACTOR SHALL NOTIFY DESIGNER/ENGINEER PRIOR TO ANY DEVIATION FROM THIS SET OF ELECTRICAL DESIGN PLANS. ANY CHANGES TO THE DESIGN, IF APPROVED BY ENGINEER, WILL REQUIRE REVISIONS TO PLANS AND POSSIBLE ADDITIONAL SERVICE FEE.


**PRELIMINARY**  
**NOT FOR CONSTRUCTION**

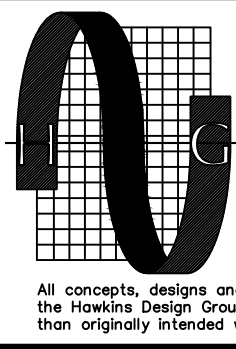

Project Contact/Designer: EDGAR RODRIGUEZ  
Project # 21406  
**HAWKINS DESIGN GROUP INC.**  
ELECTRICAL CONSULTING ENGINEERS  
140 WEST HARVEL ROAD  
GILBERT, ARIZONA 85233  
Ph: 480.813.9000 FAX: 480.813.9001  
EMAIL: email@hwdsg.com

All concepts, designs and data indicated on these drawings are the sole property of the Hawkins Design Group Inc., and shall not be used for any other purpose other than originally intended without written permission of the engineer.


IF DRAWING IS NOT PLOTTED AT 24 X 36 THEY ARE NOT FULL SIZE

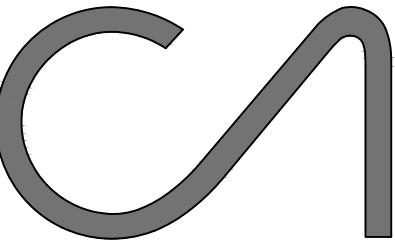

**CAWLEY**  
**ARCHITECTS**

730 N. 52nd St. Ste. 203  
Phoenix, Arizona 85008  
P 602.393.5060

CawleyArchitects.com

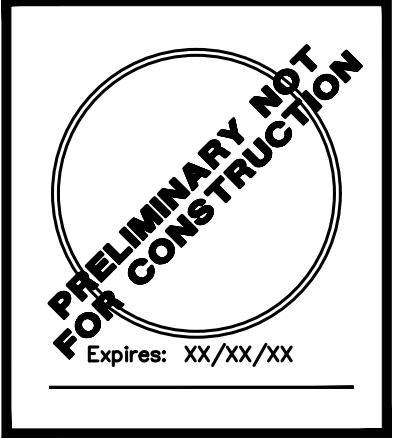

ARIZONA  
CORRUGATED  
CONTAINER  
ADDITION

225 S.DOBSON RD  
MESA, ARIZONA  
85202

DATE  
1ST DR SUBMITTAL  
06-20-2022

DRAWN BY: CRC



OWNERSHIP OF DOCUMENTS:  
This drawing, including the architectural concept, design, and data, is an instrument of service and shall remain the property of Cawley Architects Inc. This drawing is for use at the location described herein and shall not be used in other locations. Any other use or release of these drawings may result in civil damages.

DISCREPANCIES AND CONFLICTS:  
All discrepancies found in these documents or conflicts between these documents and field conditions shall be reported to Cawley Architects Inc. for resolution before the commencement of the work.


ELECTRICAL SITE  
PHOTOMETRICS - POST-CURFEW

DR3.0



Project: 21053

Luminaire Schedule									
Qty	Label	Symbol	Manufacturer	Description	MH	LLF	Lumens	Watts	Total Watts
2	SW1		U.S. ARCHITECTURAL LIGHTING	RZR-WM3-PLED-III-M-60LED-875mA-NW	25'	0.900	20637	161.9	323.8
2	SW2		U.S. ARCHITECTURAL LIGHTING	RZR-WM3-PLED-IV-FT-60LED-875mA-NW	25'	0.900	18658	161.9	323.8

Calculation Summary							
Label	CalcType	Units	Avg	Max	Min	Avg/Min	Max/Min
Site Planar	Illuminance	Fc	1.52	4.6	0.1	15.20	46.00

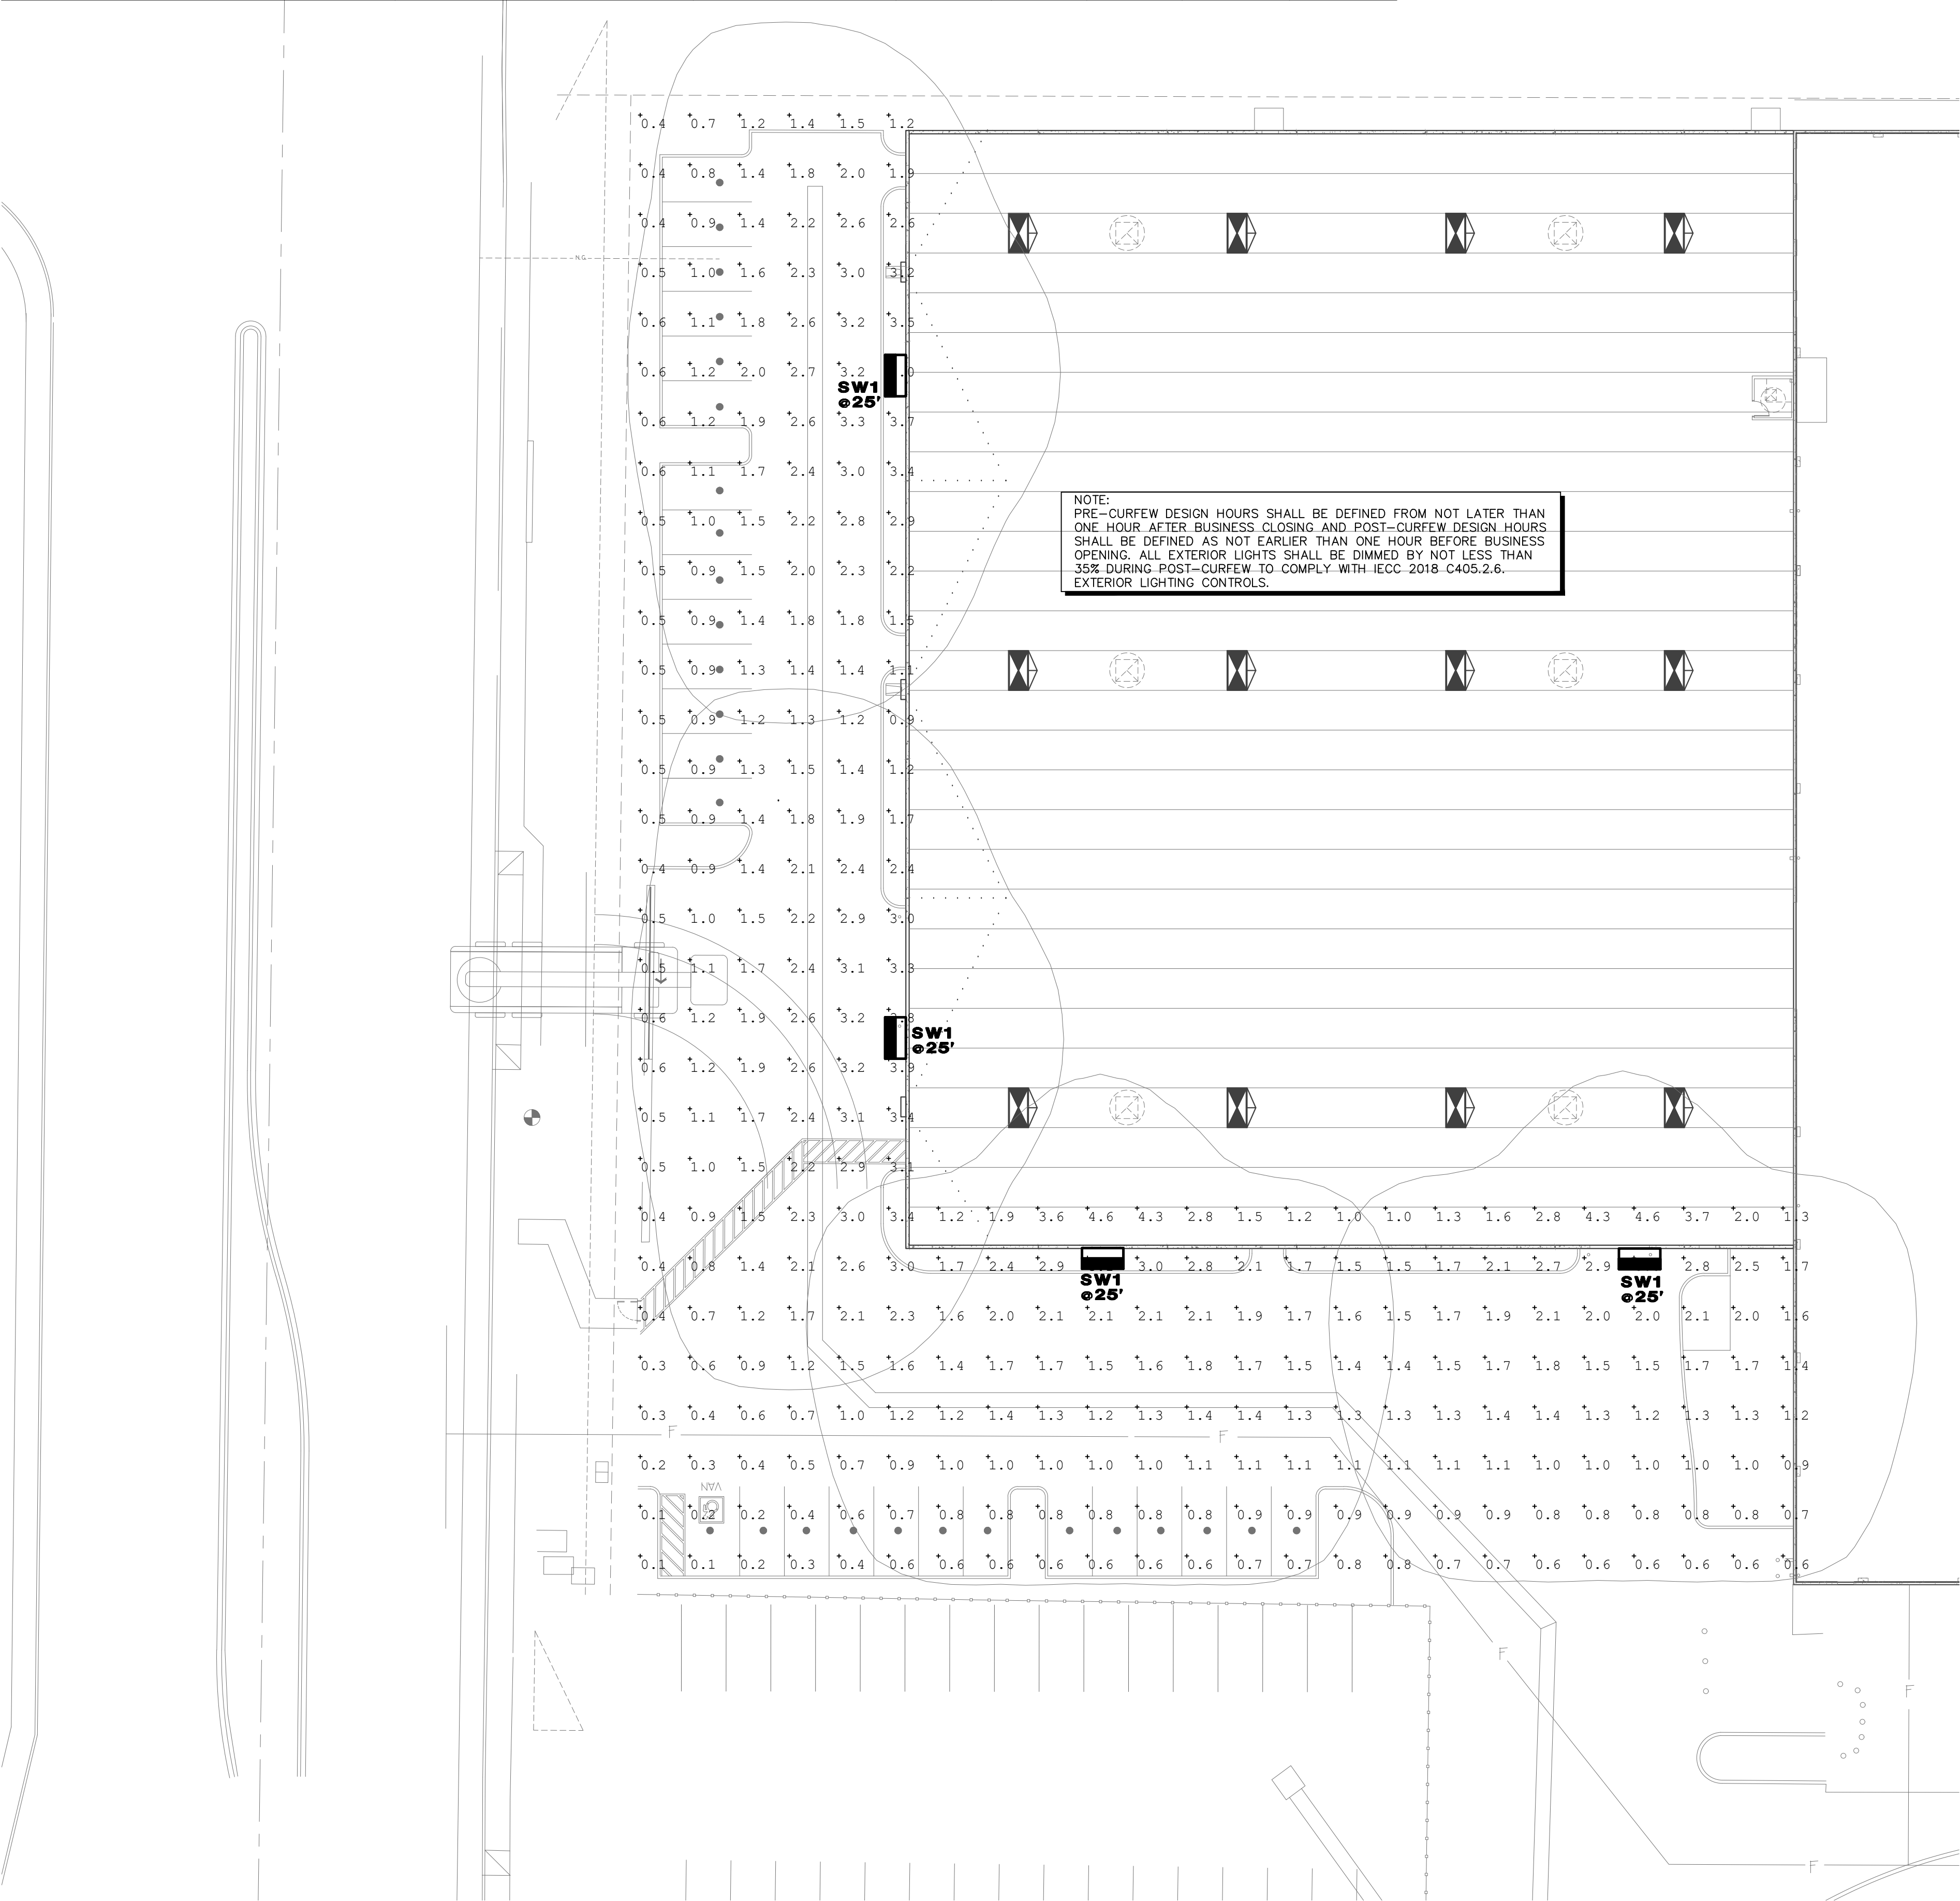


ELECTRICAL SITE PHOTOMETRICS - PRE-CURFEW

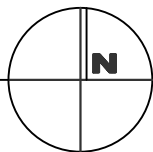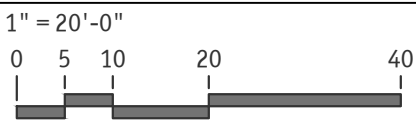

**PRELIMINARY**  
**NOT FOR CONSTRUCTION**

DESIGN CODES
IECC: 2018      NEC: 2017


ELECTRICAL CONTRACTOR SHALL NOTIFY DESIGNER/ENGINEER PRIOR TO ANY DEVIATION FROM THIS SET OF ELECTRICAL DESIGN PLANS. ANY CHANGES TO THE DESIGN, IF APPROVED BY ENGINEER, WILL REQUIRE REVISIONS TO PLANS AND POSSIBLE ADDITIONAL SERVICE FEE.

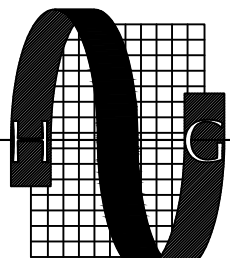

Project Contact/Designer: EDGAR RODRIGUEZ  
Project # 21406  
**HAWKINS DESIGN GROUP INC.**  
ELECTRICAL CONSULTING ENGINEERS  
140 WEST HARVEL ROAD  
CLUBB, ARIZONA 85233  
Ph. 480.813.9000 Fax. 480.813.9001  
EMAIL: email@hawkinsdsg.com

All concepts, designs and data indicated on these drawings are the sole property of the Hawkins Design Group, Inc., and shall not be used for any other purpose other than originally intended without written permission of the engineer.

IF DRAWING IS NOT PLOTTED AT 24 X 36 THEY ARE NOT FULL SIZE

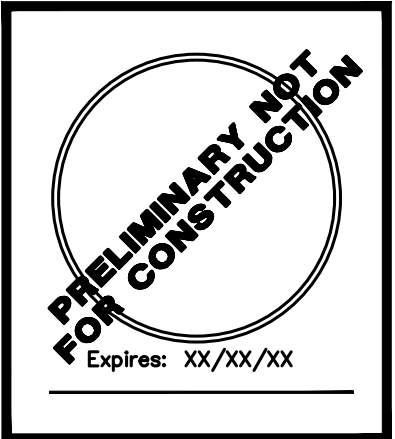

ARIZONA  
CORRUGATED  
CONTAINER  
ADDITION

225 S.DOBSON RD  
MESA, ARIZONA  
85202

DATE  
1ST DR SUBMITTAL  
06-20-2022

DRAWN BY: CRC

OWNERSHIP OF DOCUMENTS:  
This drawing, including the architectural concept, design, and data is an instrument of service and shall remain the property of Cawley Architects Inc. This drawing is for use at the location described herein and shall not be used in other locations. Any other use or release of these drawings may result in civil damages.

DISCREPANCIES AND CONFLICTS:  
All discrepancies found in these documents or conflicts between these documents and field conditions shall be reported to Cawley Architects Inc. for resolution before the commencement of the work.

ELECTRICAL SITE  
PHOTOMETRICS - PRE-CURFEW


Project: 21053

DR2.0



[illegible]

DESIGN CODES	
IECC: 2018	NEC: 2017
ELECTRICAL CONTRACTOR SHALL NOTIFY DESIGNER/ENGINEER PRIOR TO ANY DEVIATION FROM THIS SET OF ELECTRICAL DESIGN PLANS. ANY CHANGES TO THE DESIGN, IF APPROVED BY ENGINEER, WILL REQUIRE REVISIONS TO PLANS AND POSSIBLE ADDITIONAL SERVICE FEE.	



Project Contact/Designer: **EDGAR RODRIGUEZ**  
Project # **21406**

**HAWKINS DESIGN GROUP INC.**  
ELECTRICAL CONSULTING ENGINEERS  
1140 WEST HARVELL ROAD  
GILBERT, ARIZONA 85233  
PH. 480.813.9000 FAX. 480.813.9001  
EMAIL [email@hawkinscdg.com](mailto:email@hawkinscdg.com)

All concepts, designs and data indicated on these drawings are the sole property of the Hawkins Design Group Inc., and shall not be used for any other purpose other than originally intended without written permission of the engineer.