


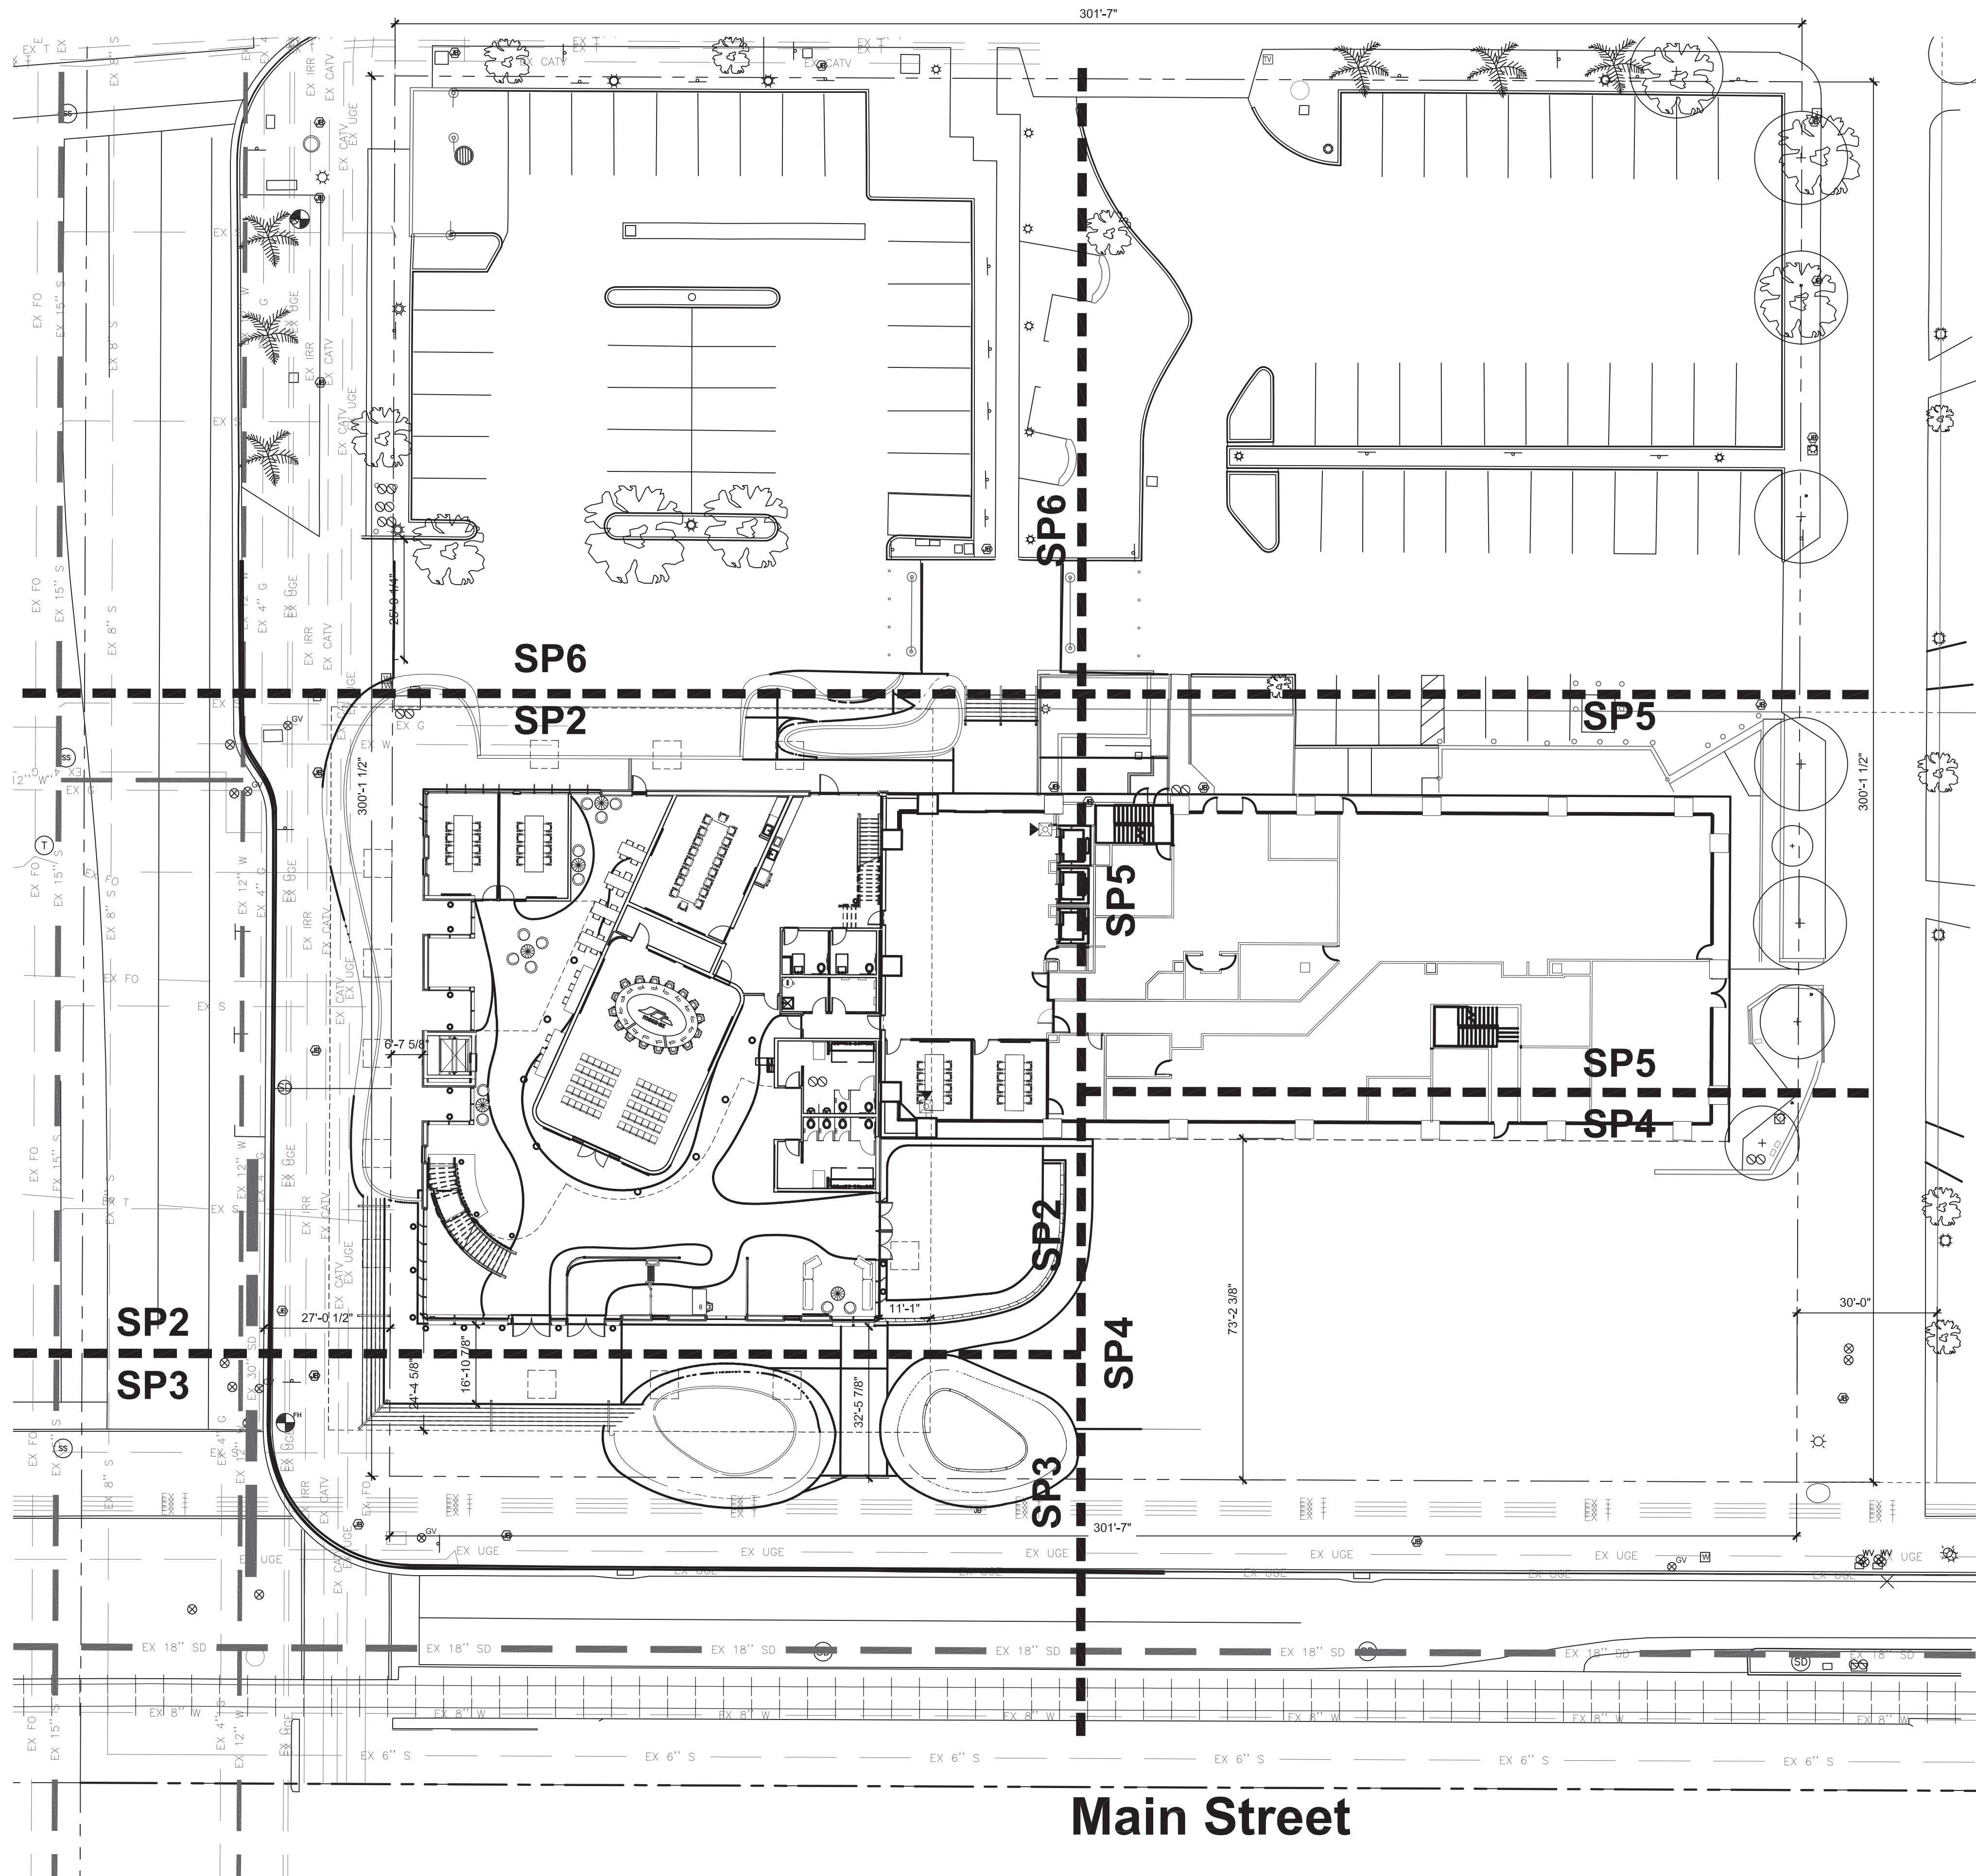


SURVEY LEGEND

- STREET LIGHT
- LIGHT POLE
- JUNCTION BOX
- POLE RISER
- ELECTRIC RISER
- ELECTRIC METER
- ELECTRIC TRANSFORMER
- ELECTRIC PULL BOX
- ELECTRIC POWER POLE
- DOWN GUY
- AIR CONDITIONING
- ELECTRIC MANHOLE
- TRAFFIC SIGNAL BOX
- TRAFFIC CAMERA
- TRAFFIC SIGNAL POLE
- TRAFFIC SIGNAL ARM
- FIRE DEPARTMENT CONNECTION
- WATER MANHOLE RECLAIMED
- WATER MAN HOLE
- FIRE HYDRANT
- BACKFLOW PREVENTOR
- WATER VALVE
- ANTI-SIPHON VALVE
- WATER METER
- RECLAIMED WATER VALVE
- POST INDICATOR VALVE
- STORM DRAIN MANHOLE
- DRYWELL
- CATV PEDESTAL
- CABLE TV PULL BOX
- CATV RISER
- IRRIGATION VALVE
- IRRIGATION MANHOLE
- IRRIGATION METER
- IRRIGATION STANDPIPE
- FIBER OPTIC PULLBOX
- FIBER OPTIC MAN HOLE
- SEWER CLEANOUT
- SEWER MANHOLE
- SEWER METER
- TELEPHONE MANHOLE
- TELEPHONE RISER
- GAS MANHOLE
- GAS METER
- GAS RISER/PIPE
- GAS VALVE
- GAS MARKER
- FENCE POST
- BOLLARD/GUARD POST
- PARKING METER
- SIGN
- GATE
- FLAG POLE
- MAILBOX
- MANHOLE
- WELL

- WATER LINE
- SEWER LINE
- STORM DRAIN LINE
- COMMUNICATION LINE
- CABLE TV LINE
- UNDERGROUND ELECTRIC
- OVERHEAD ELECTRIC
- UNDERGROUND TELEPHONE
- OVERHEAD TELEPHONE
- FIBER OPTIC LINE
- GAS LINE
- IRRIGATION LINE
- TRAFFIC LINE
- CHAIN LINK FENCE
- BARB WIRE FENCE LINE
- METAL FENCE LINE
- PROPERTY LINE
- PARCEL LINE
- LOT LINE
- RIGHT OF WAY LINE
- SECTION LINE
- CENTER LINE
- EASEMENT LINE
- TIE LINE

- M.C.R. MARICOPA COUNTY RECORDS
- APN: ASSESSORS PARCEL NUMBER
- R/W RIGHT OF WAY
- RLS REGISTERED LAND SURVEYOR
- LS LAND SURVEYOR
- PL PROPERTY LINE
- PC PROPERTY CORNER
- E/P EDGE OF PAVEMENT
- B/C BACK OF CURB
- BSL BUILDING SETBACK LINE
- PUE PUBLIC UTILITY EASEMENT
- VNAE VEHICLE NON-ACCESS EASEMENT
- (R1) BOOK _____, OF MAPS, PAGE _____, M.C.R.

Overall Construction Site Plan

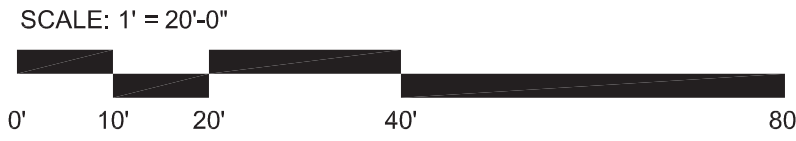

Not For Construction or Recording

CITY OF MESA ENGINEERING DEPARTMENT

Plaza Design MCP Council Chambers
20 E Main St
Mesa, AZ 85201

Overall Construction Site Plan

DRAWING
SP-1

DRAWN BY: Author
DESIGN BY: Checker
APPROVED BY: Approver

PHASE: DESIGN REVIEW
COM PROJECT #: LF0487CAP

SHEET
OF

CATALOG NUMBER:
A - XXXXX