


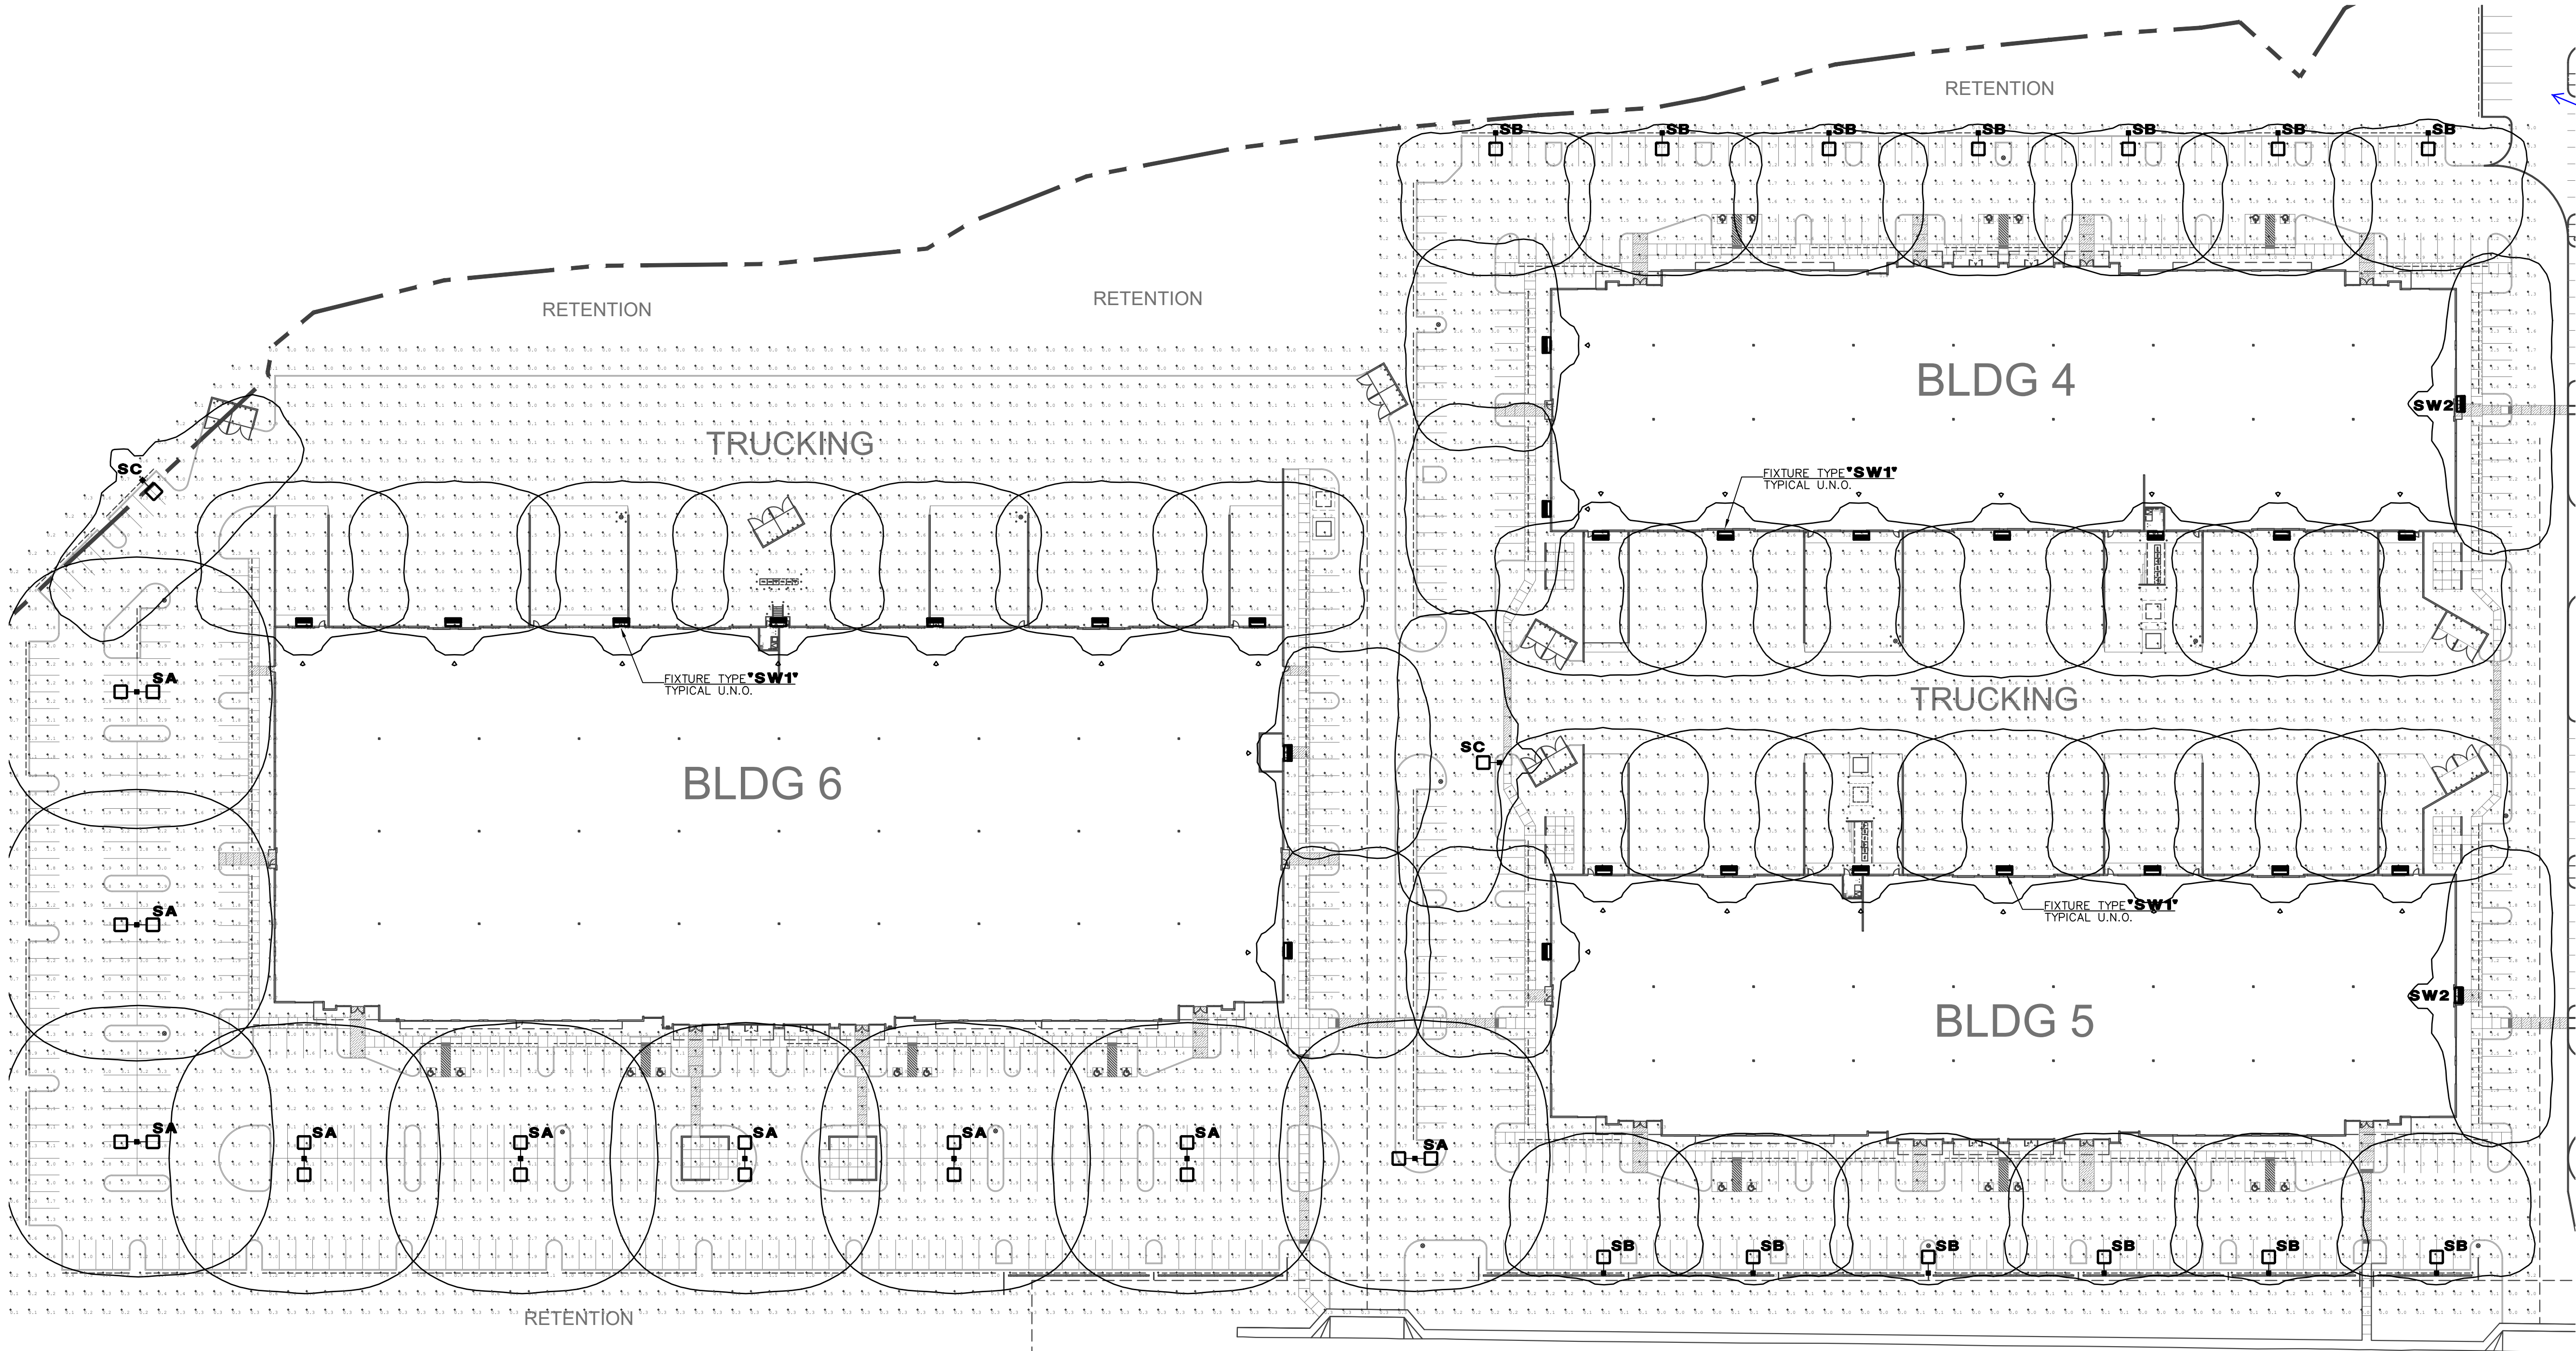

THIS DRAWING IS AN INSTRUMENT OF SERVICE AND IS THE PROPERTY OF BALMER ARCHITECTURAL GROUP INC. THIS DRAWING MAY NOT BE REPRODUCED NOR REPRODUCTION HEREOF USED, WITHOUT THEIR WRITTEN PERMISSION. © 2022 BALMER ARCHITECTURAL GROUP, INC. 2425 E. CAMELBACK RD., SUITE 775 PHOENIX, ARIZONA 85016 PH: 602-954-8718 FAX: 602-488-9680 E-MAIL: ADMIN@BAG-INC.COM

PRELIMINARY NOT FOR CONSTRUCTION

Expires: XX/XX/XX

ELECTRICAL SITE PHOTOMETRICS

SCALE: 1" = 50'-0"

NORTH

Luminaire Schedule										
Qty	Label	Symbol	Manufacturer	Description	MH	LLF	Lumens	Watts	Total Watts	BUG Rating
9	SA		HUBBELL OUTDOOR	VP-2-320L-145-4K7-5QW	25'	0.900	21867	150	2700	B5-U0-G3
13	SB		Beacon Products	VP-L-80L-180-4K7-4-BC	25'	0.900	14316	181.3	2356.9	B1-U0-G3
2	SC		Beacon Products	VP-2-72L-180-4K7-3	25'	0.900	21837	179.4	358.8	B2-U0-G4
26	SW1		Beacon Products	VP-2-72L-180-4K7-4P-WB	25'	0.900	21367	179.4	4664.4	B2-U0-G4
2	SW2		Beacon Products	VP-2-72L-180-4K7-3-WB	25'	0.900	21837	179.4	358.8	B2-U0-G4

Calculation Summary							
Label	CalcType	Units	Avg	Max	Min	Avg/Min	Max/Min
Site Planar	Illuminance	Fc	1.87	5.7	0.0	N.A.	N.A.


Mesa Grandview
PRELIMINARY SITE PLAN - OPTION 1
ELECTRICAL SITE PHOTOMETRIC PLAN

DR-100
39009
27APR21

PRELIMINARY
NOT FOR CONSTRUCTION

DESIGN CODES
IECC, 2018 NEC, 2017

ELECTRICAL CONTRACTOR SHALL NOTIFY DESIGNER/ENGINEER PRIOR TO ANY DEVIATION FROM THIS SET OF ELECTRICAL DESIGN PLANS. ANY CHANGES TO THE DESIGN, IF APPROVED BY ENGINEER, WILL REQUIRE REVISIONS TO PLANS AND POSSIBLE ADDITIONAL SERVICE FEE.

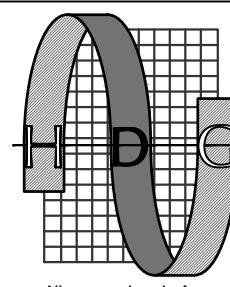

Project Contact/Designer: MINDY ADLER
Project # 22288

HAWKINS DESIGN GROUP INC.
ELECTRICAL CONSULTING ENGINEERS
1400 WEST HARWELL ROAD
GILBERT, ARIZONA 85233
PH: 480.613.9000 FAX: 480.613.9001
EMAIL: email@hawksdsg.com

All concepts, designs and data indicated on these drawings are the sole property of the Hawkins Design Group, Inc. and shall not be used for any other purpose other than originally intended without written permission of the engineer.

BALMER
architectural group

IF DRAWING IS NOT PLOTTED AT 24 X 36 THEY ARE NOT FULL SIZE