

COLOR AND FINISH LEGEND

- A

PAINTED STUCCO:
MFG: DUNN EDWARDS
COLOR: DE6376 LOOKING GLASS
- B

PAINT:
MFG: DUNN EDWARDS
COLOR: DE6370 CHARCOAL SMUDGE
- C

ALUMINUM STOREFRONT:
MANUF: KAWNEER
FINISH: CLEAR ANODIZED
- D

8X8X16 C.M.U. BLOCK:
MFG: SUPERLITE
SPEC: SPLIT FACE
COLOR: PAINTED DUNN EDWARDS
DE6357 BLACK TIE
- E

8X8X16 C.M.U. BLOCK:
MFG: SUPERLITE
SPEC: CENTER SCORED PAINTED
COLOR: DUNN EDWARDS
DE6369 LEGENDARY GRAY
- F

8X8X16 C.M.U. BLOCK:
MFG: SUPERLITE
SPEC: PAINTED DUNN EDWARDS
COLOR: DE6360 FOIL
- G


ROLL UP DOOR:
MFG: JANUS
COLOR: SILOUETTE GRAY

GENERAL NOTES

1. SEE FLOOR PLAN FOR DEPTHS OF ALL POP-OUTS and COLUMNS SHOWN ON EXTERIOR ELEVATIONS
2. ALL ROOF DRAINS and OVERFLOW DRAINS SHALL BE INTERNALIZED and NOT EXPOSED.
3. WALL-MOUNTED LIGHT FIXTURES SHALL BE CUT-OFF TYPE and SHALL NOT EXCEED 14'-0" ABOVE GRADE.
4. ALL HVAC UNITS SHOWN SHALL NOT EXCEED THE ADJACENT PARAPET HEIGHTS (TYP.).
5. G.C. TO VERIFY ALL LOUVER SIZES AND LOCATIONS WITH MECHANICAL PLANS.
6. KNOX BOX LOCATION SHALL BE COORDINATED AND APPROVED BY FIRE DEPARTMENT. KNOX BOX SHALL BE LOCATED AT RISER ROOM.


ELEVATION KEYNOTES

1. ADDRESS PER CITY OF MARICOPA REQUIREMENTS.
2. EXTERIOR LIGHT FIXTURE - SEE ELECTRICAL DRAWINGS.
3. LINE OF MECHANICAL EQUIPMENT BEYOND.
4. PROPOSED SIGN LOCATION. UNDER SEPARATE PERMIT; G.C. TO PROVIDE CONDUIT, WIRING, & BREAKER BACK TO ELECTRICAL PANEL.
5. F.D.C. LOCATION.
6. EM. LIGHT FIXTURE ON TOP OF DOOR HEAD. SEE ELECTRICAL.
7. H.M. DOOR SEE DOOR SCHEDULE; PAINT TO MATCH ADJACENT WALL.
8. LOADING DOC
9. G.C. TO PROVIDE J-BOX.
10. ROOF DRAIN/OVERFLOW.
11. FAUX WINDOW.
12. KNOXBOX.
13. ROLL UP DOOR.
14. ALUMINUM STOREFRONT.

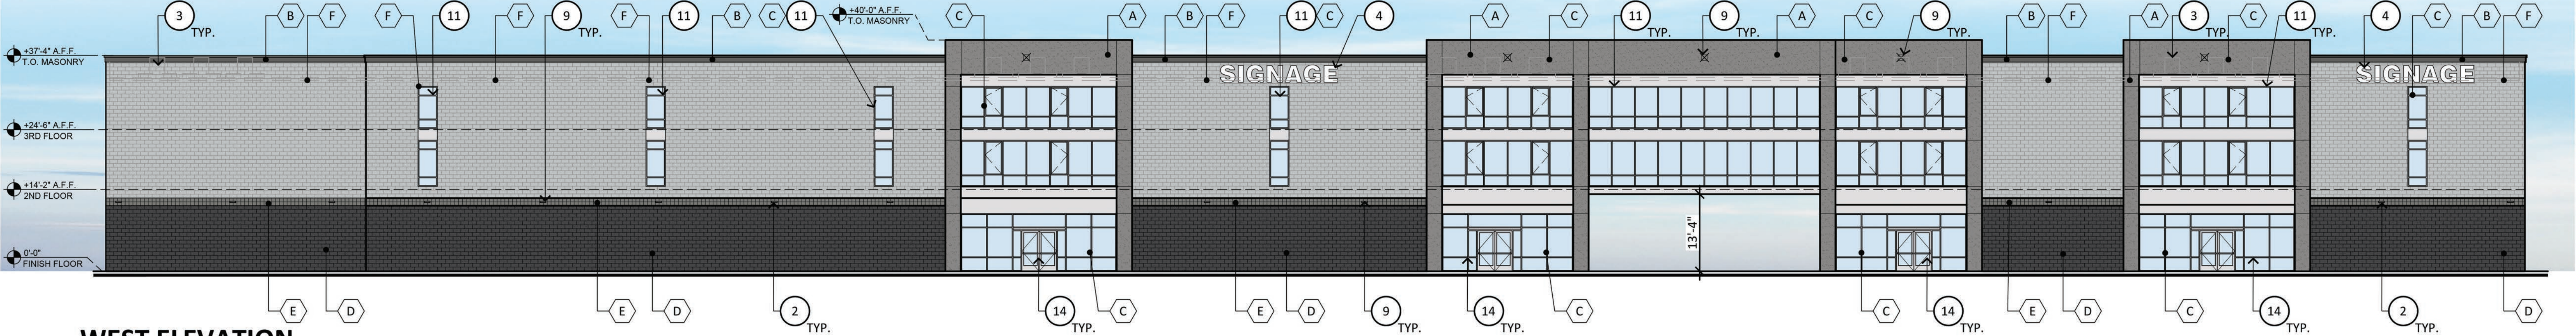


WEST ELEVATION

SCALE: N.T.S.

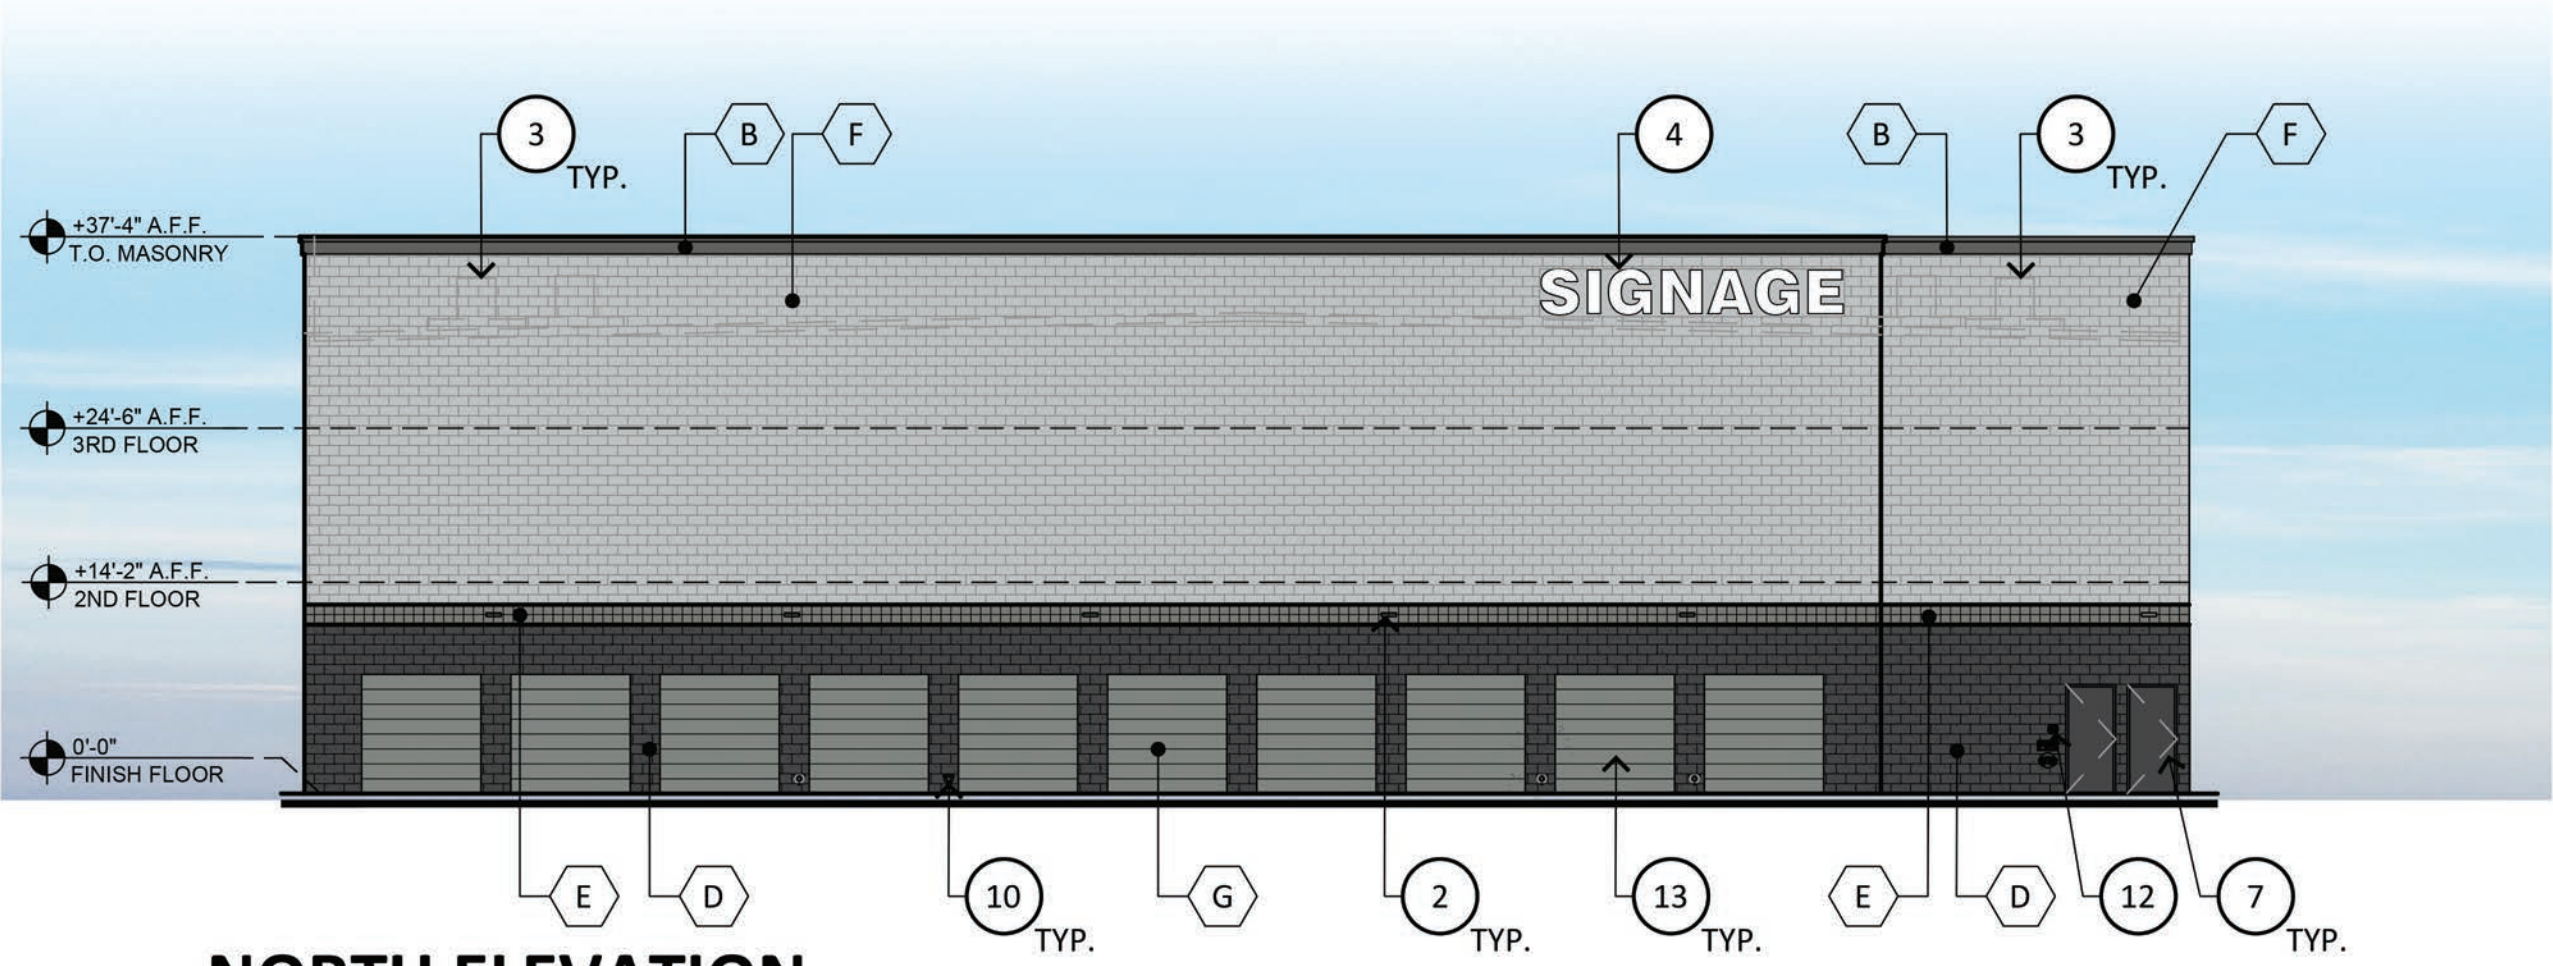


NORTH ELEVATION

SCALE: N.T.S.

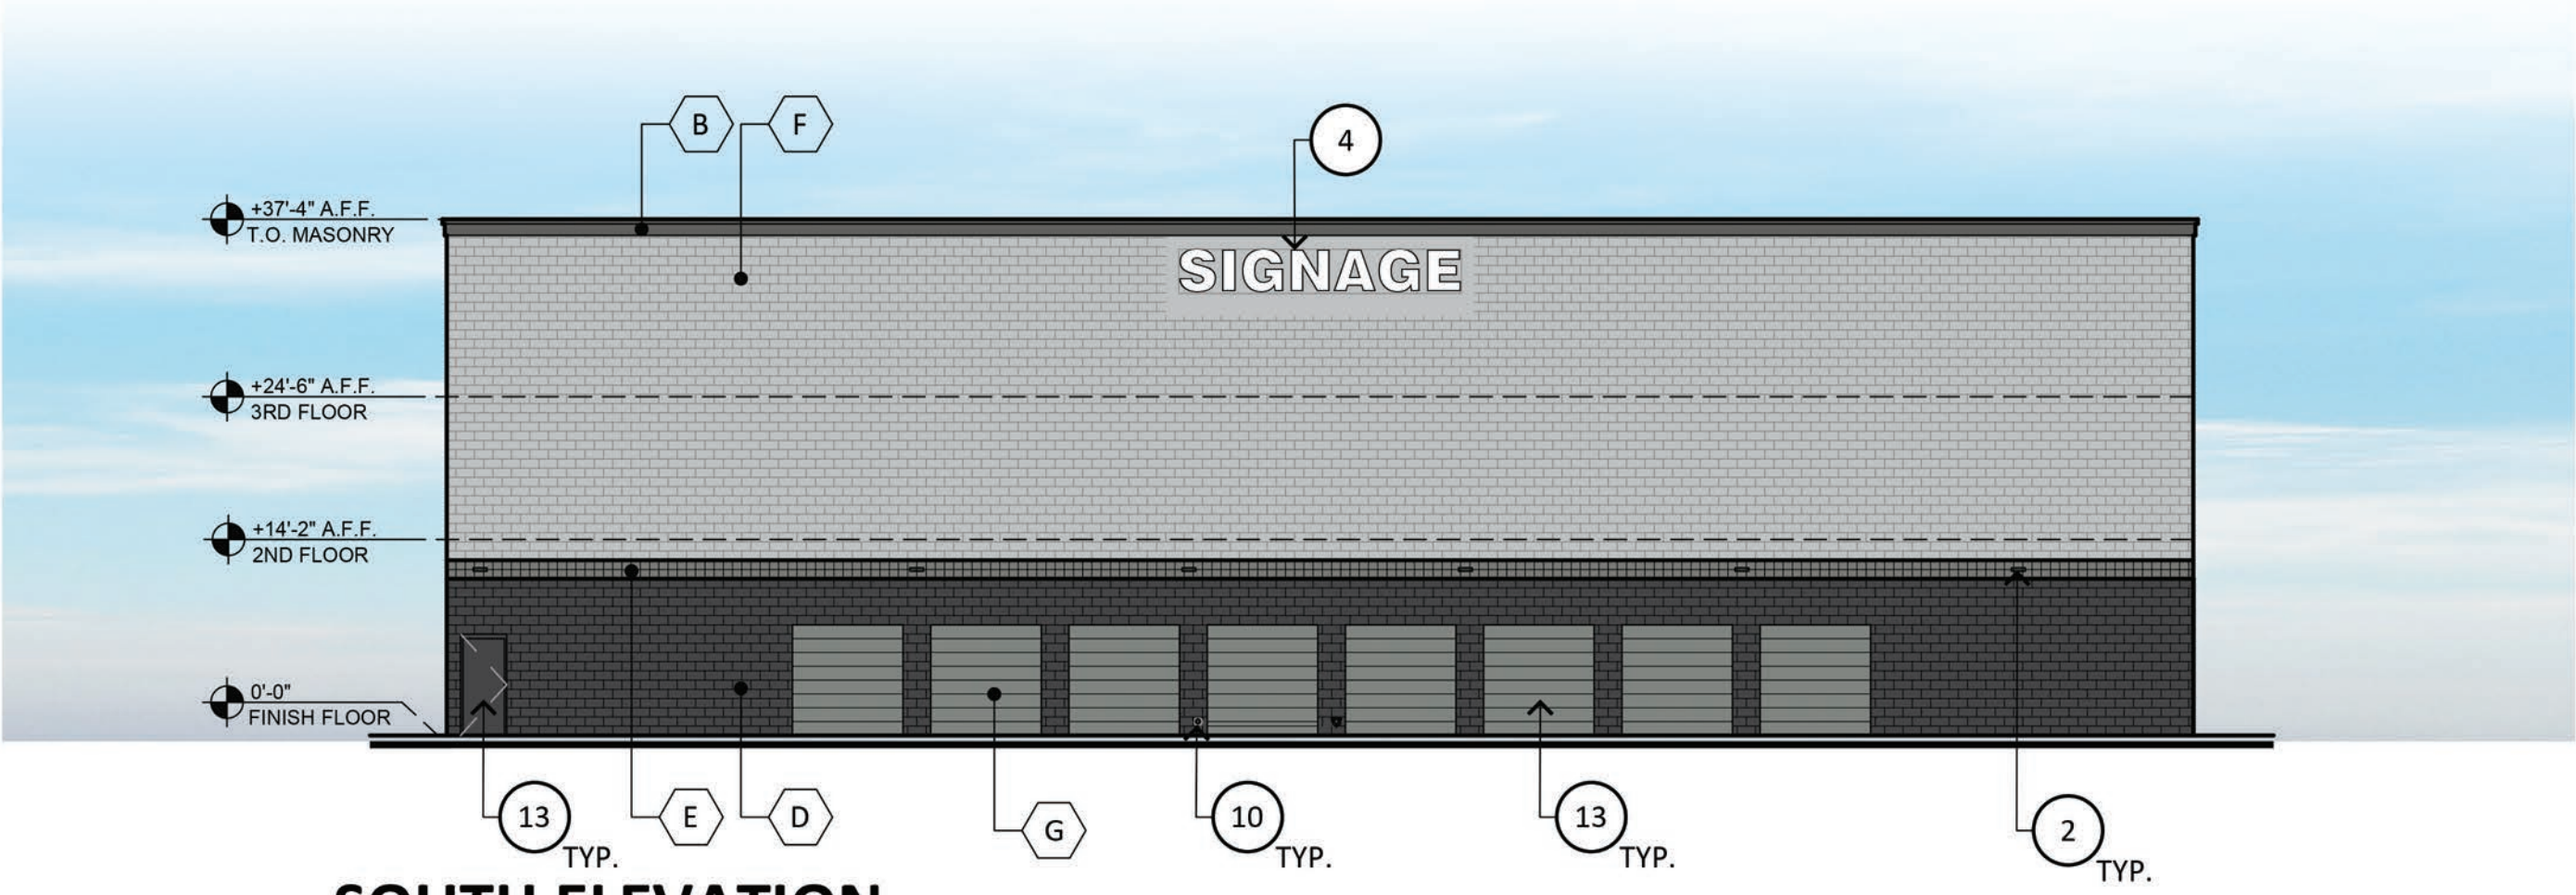

SOUTH ELEVATION

SCALE: N.T.S.

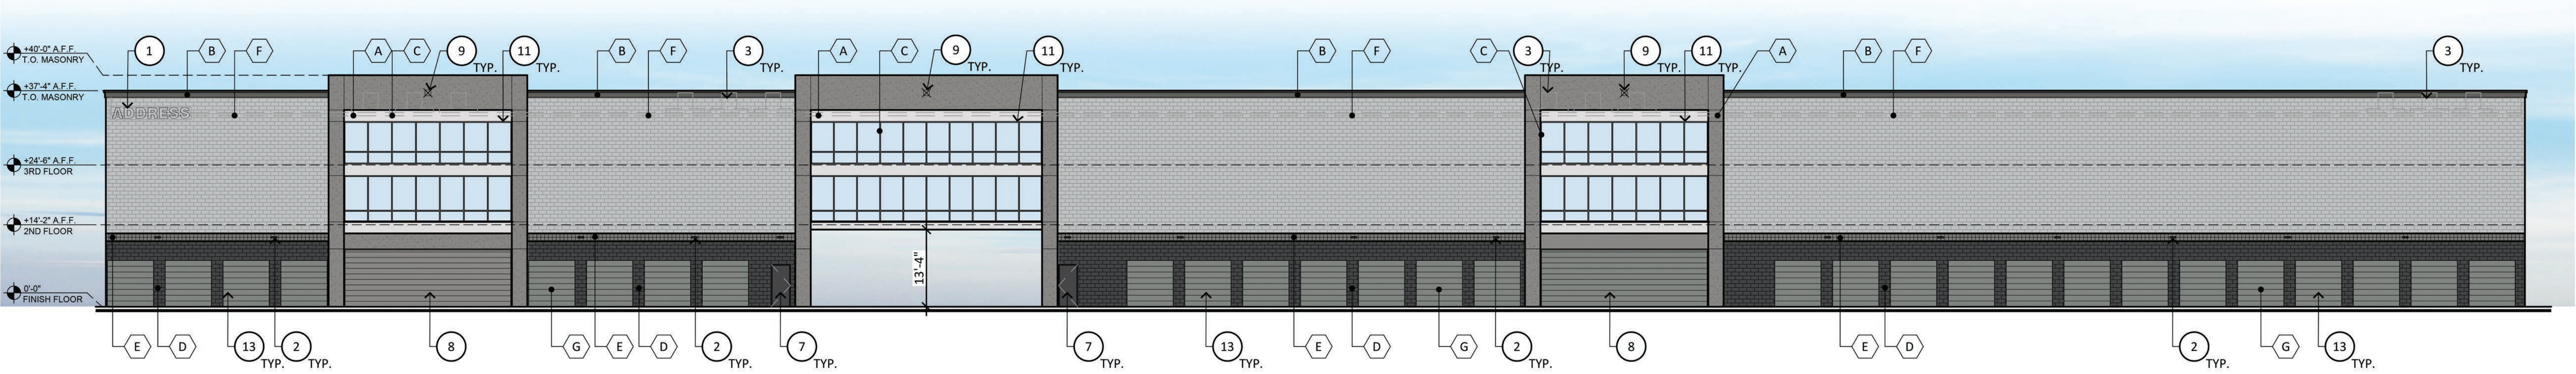

EAST ELEVATION

SCALE: N.T.S.



LEGACY GATEWAY SELF-STORAGE

SEC ELLSWORTH RD and SR 24
MESA, ARIZONA 85212
DATE: 10-20-2022 (PRELIMINARY)

EL-1

RKAA#21327.00

© 2021 RKAA
ARCHITECTS, INC. ALL
RIGHTS RESERVED.
THIS DRAWING IS AN
INSTRUMENT OF
SERVICE. IT IS THE
PROPERTY OF RKAA
ARCHITECTS, INC. AND
MAY NOT BE
DUPLICATED, USED OR
DISCLOSED WITHOUT
WRITTEN PERMISSION
OF THE ARCHITECT.

COLOR AND FINISH LEGEND

- A

PAINTED STUCCO:
MFG: DUNN EDWARDS
COLOR: DE6376 LOOKING GLASS
- B

PAINT:
MFG: DUNN EDWARDS
COLOR: DE6370 CHARCOAL SMUDGE
- C

ALUMINUM STOREFRONT:
MANUF: KAWNEER
FINISH: CLEAR ANODIZED
- D

8X8X16 C.M.U. BLOCK:
MFG: SUPERLITE
SPEC: SPLIT FACE
COLOR: PAINTED DUNN EDWARDS
DE6357 BLACK TIE
- E

8X8X16 C.M.U. BLOCK:
MFG: SUPERLITE
SPEC: CENTER SCORED PAINTED
COLOR: DUNN EDWARDS
DE6369 LEGENDARY GRAY
- F

8X8X16 C.M.U. BLOCK:
MFG: SUPERLITE
SPEC: PAINTED DUNN EDWARDS
COLOR: DE6360 FOIL
- G


ROLL UP DOOR:
MFG: JANUS
COLOR: SILOUETTE GRAY

GENERAL NOTES

1. SEE FLOOR PLAN FOR DEPTHS OF ALL POP-OUTS and COLUMNS SHOWN ON EXTERIOR ELEVATIONS
2. ALL ROOF DRAINS and OVERFLOW DRAINS SHALL BE INTERNALIZED and NOT EXPOSED.
3. WALL-MOUNTED LIGHT FIXTURES SHALL BE CUT-OFF TYPE and SHALL NOT EXCEED 14'-0" ABOVE GRADE.
4. ALL HVAC UNITS SHOWN SHALL NOT EXCEED THE ADJACENT PARAPET HEIGHTS (TYP.).
5. G.C. TO VERIFY ALL LOUVER SIZES AND LOCATIONS WITH MECHANICAL PLANS.
6. KNOX BOX LOCATION SHALL BE COORDINATED AND APPROVED BY FIRE DEPARTMENT. KNOX BOX SHALL BE LOCATED AT RISER ROOM.


ELEVATION KEYNOTES

1. ADDRESS PER CITY OF MARICOPA REQUIREMENTS.
2. EXTERIOR LIGHT FIXTURE - SEE ELECTRICAL DRAWINGS.
3. LINE OF MECHANICAL EQUIPMENT BEYOND.
4. PROPOSED SIGN LOCATION. UNDER SEPARATE PERMIT; G.C. TO PROVIDE CONDUIT, WIRING, & BREAKER BACK TO ELECTRICAL PANEL.
5. F.D.C. LOCATION.
6. EM. LIGHT FIXTURE ON TOP OF DOOR HEAD. SEE ELECTRICAL.
7. H.M. DOOR SEE DOOR SCHEDULE; PAINT TO MATCH ADJACENT WALL.
8. LOADING DOCK
9. G.C. TO PROVIDE J-BOX.
10. ROOF DRAIN/OVERFLOW.
11. FAUX WINDOW.
12. KNOXBOX.
13. ROLL UP DOOR.
14. ALUMINUM STOREFRONT.

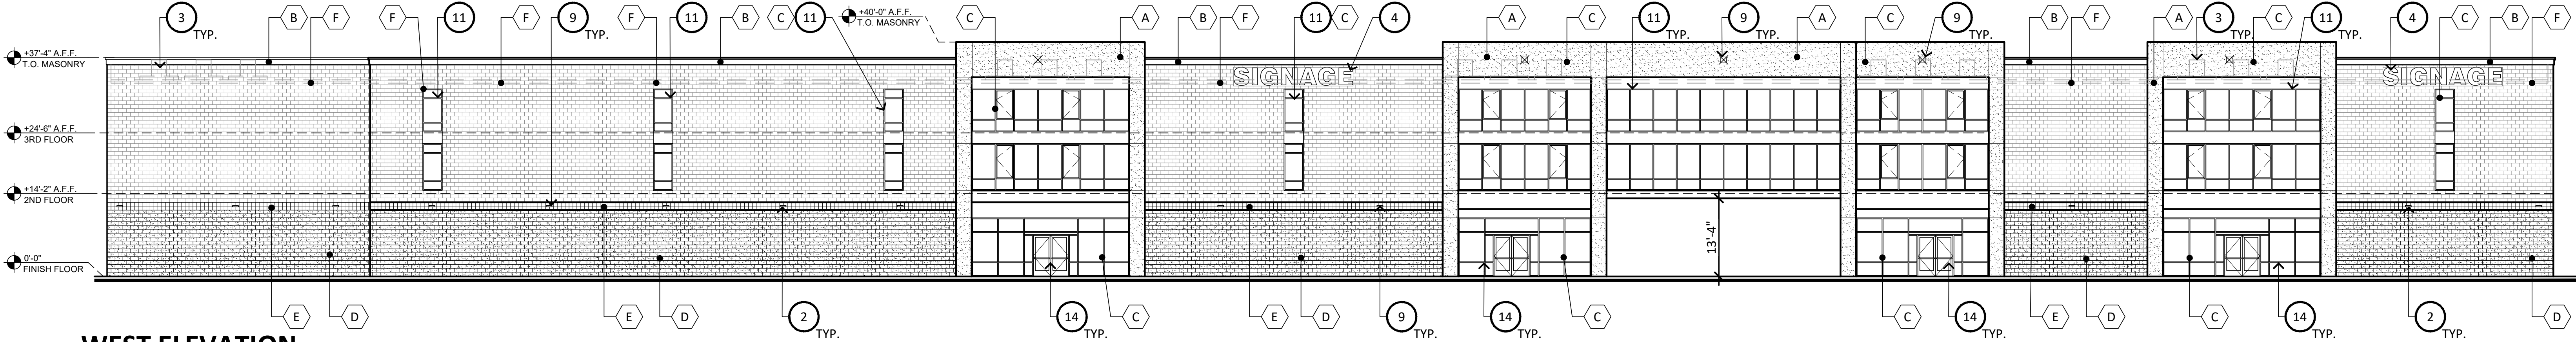


WEST ELEVATION

SCALE: N.T.S.

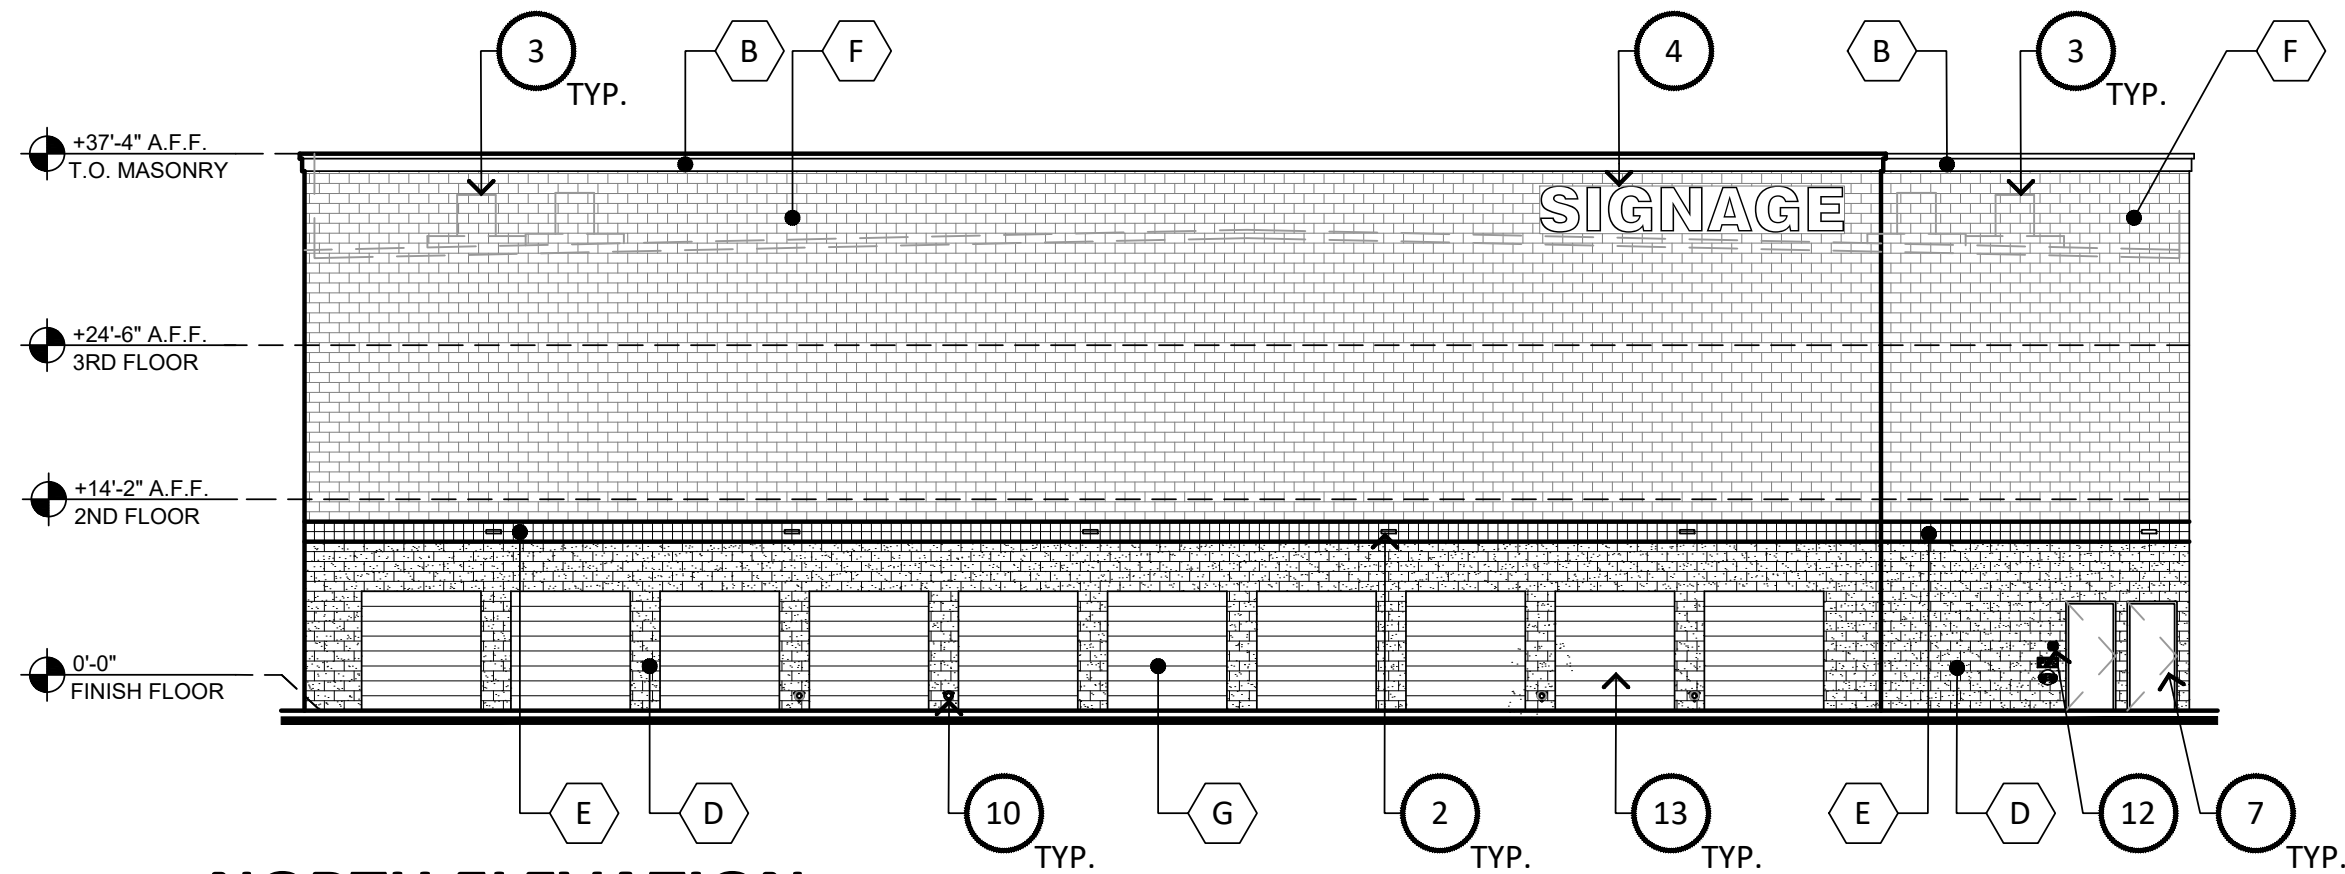


NORTH ELEVATION

SCALE: N.T.S.

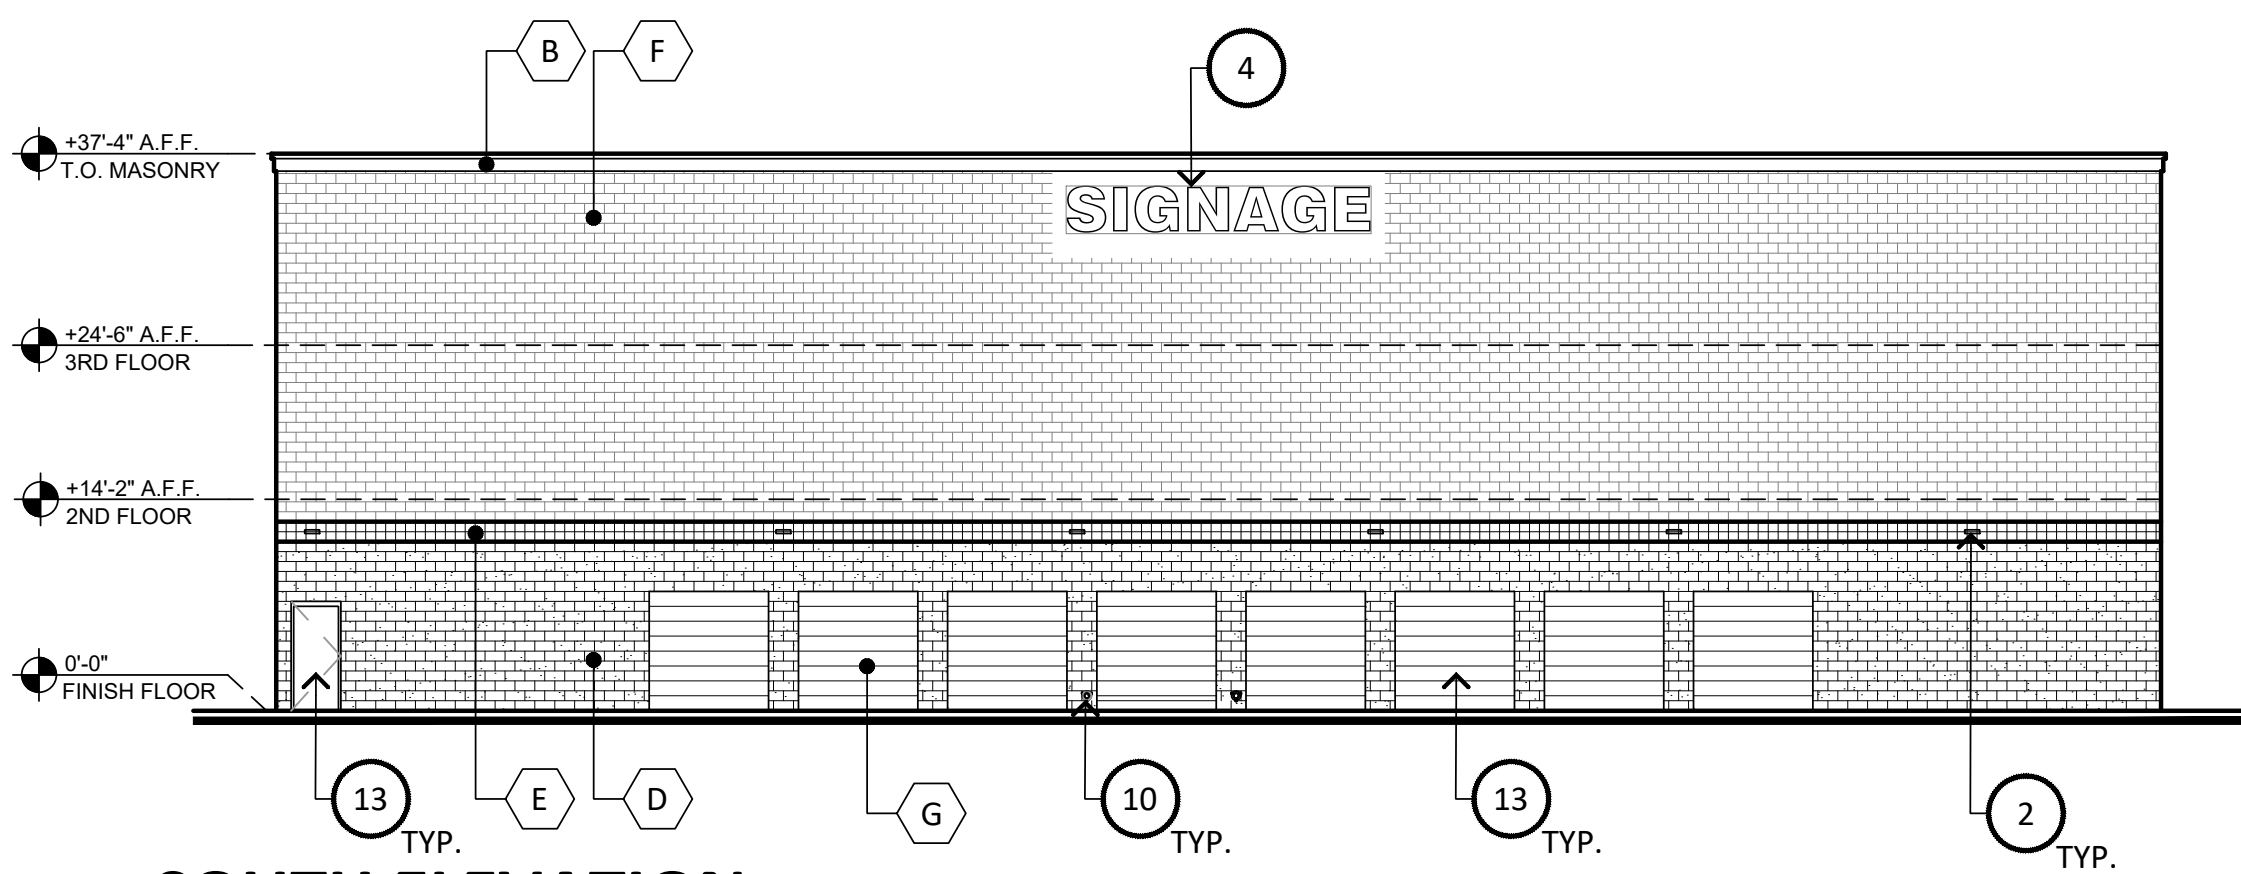

SOUTH ELEVATION

SCALE: N.T.S.

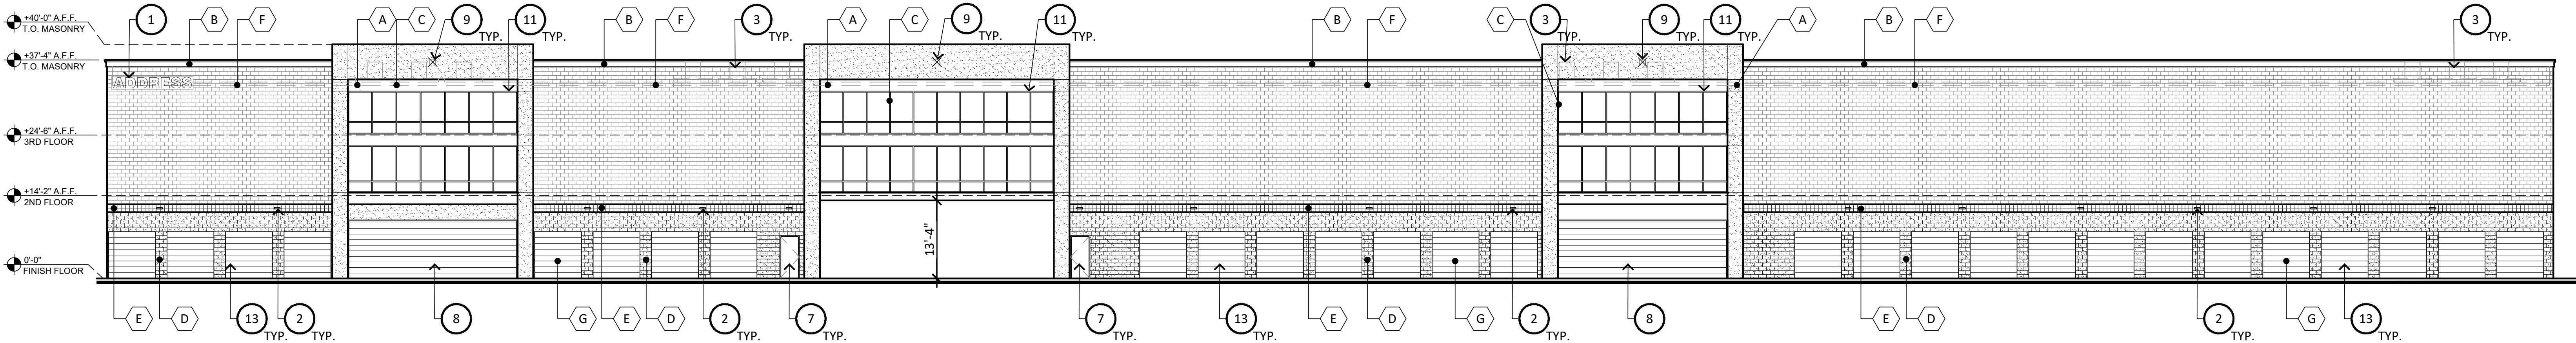

EAST ELEVATION

SCALE: N.T.S.



LEGACY GATEWAY SELF-STORAGE

SEC ELLSWORTH RD and SR 24
MESA, ARIZONA 85212
DATE: 10-20-2022 (PRELIMINARY)

EL-1

RKAA#21327.00

© 2021 RKAA
ARCHITECTS, INC. ALL
RIGHTS RESERVED.
THIS DRAWING IS AN
INSTRUMENT OF
SERVICE. IT IS THE
PROPERTY OF RKAA
ARCHITECTS, INC. AND
MAY NOT BE
DUPLICATED, USED OR
DISCLOSED WITHOUT
WRITTEN PERMISSION
OF THE ARCHITECT.