



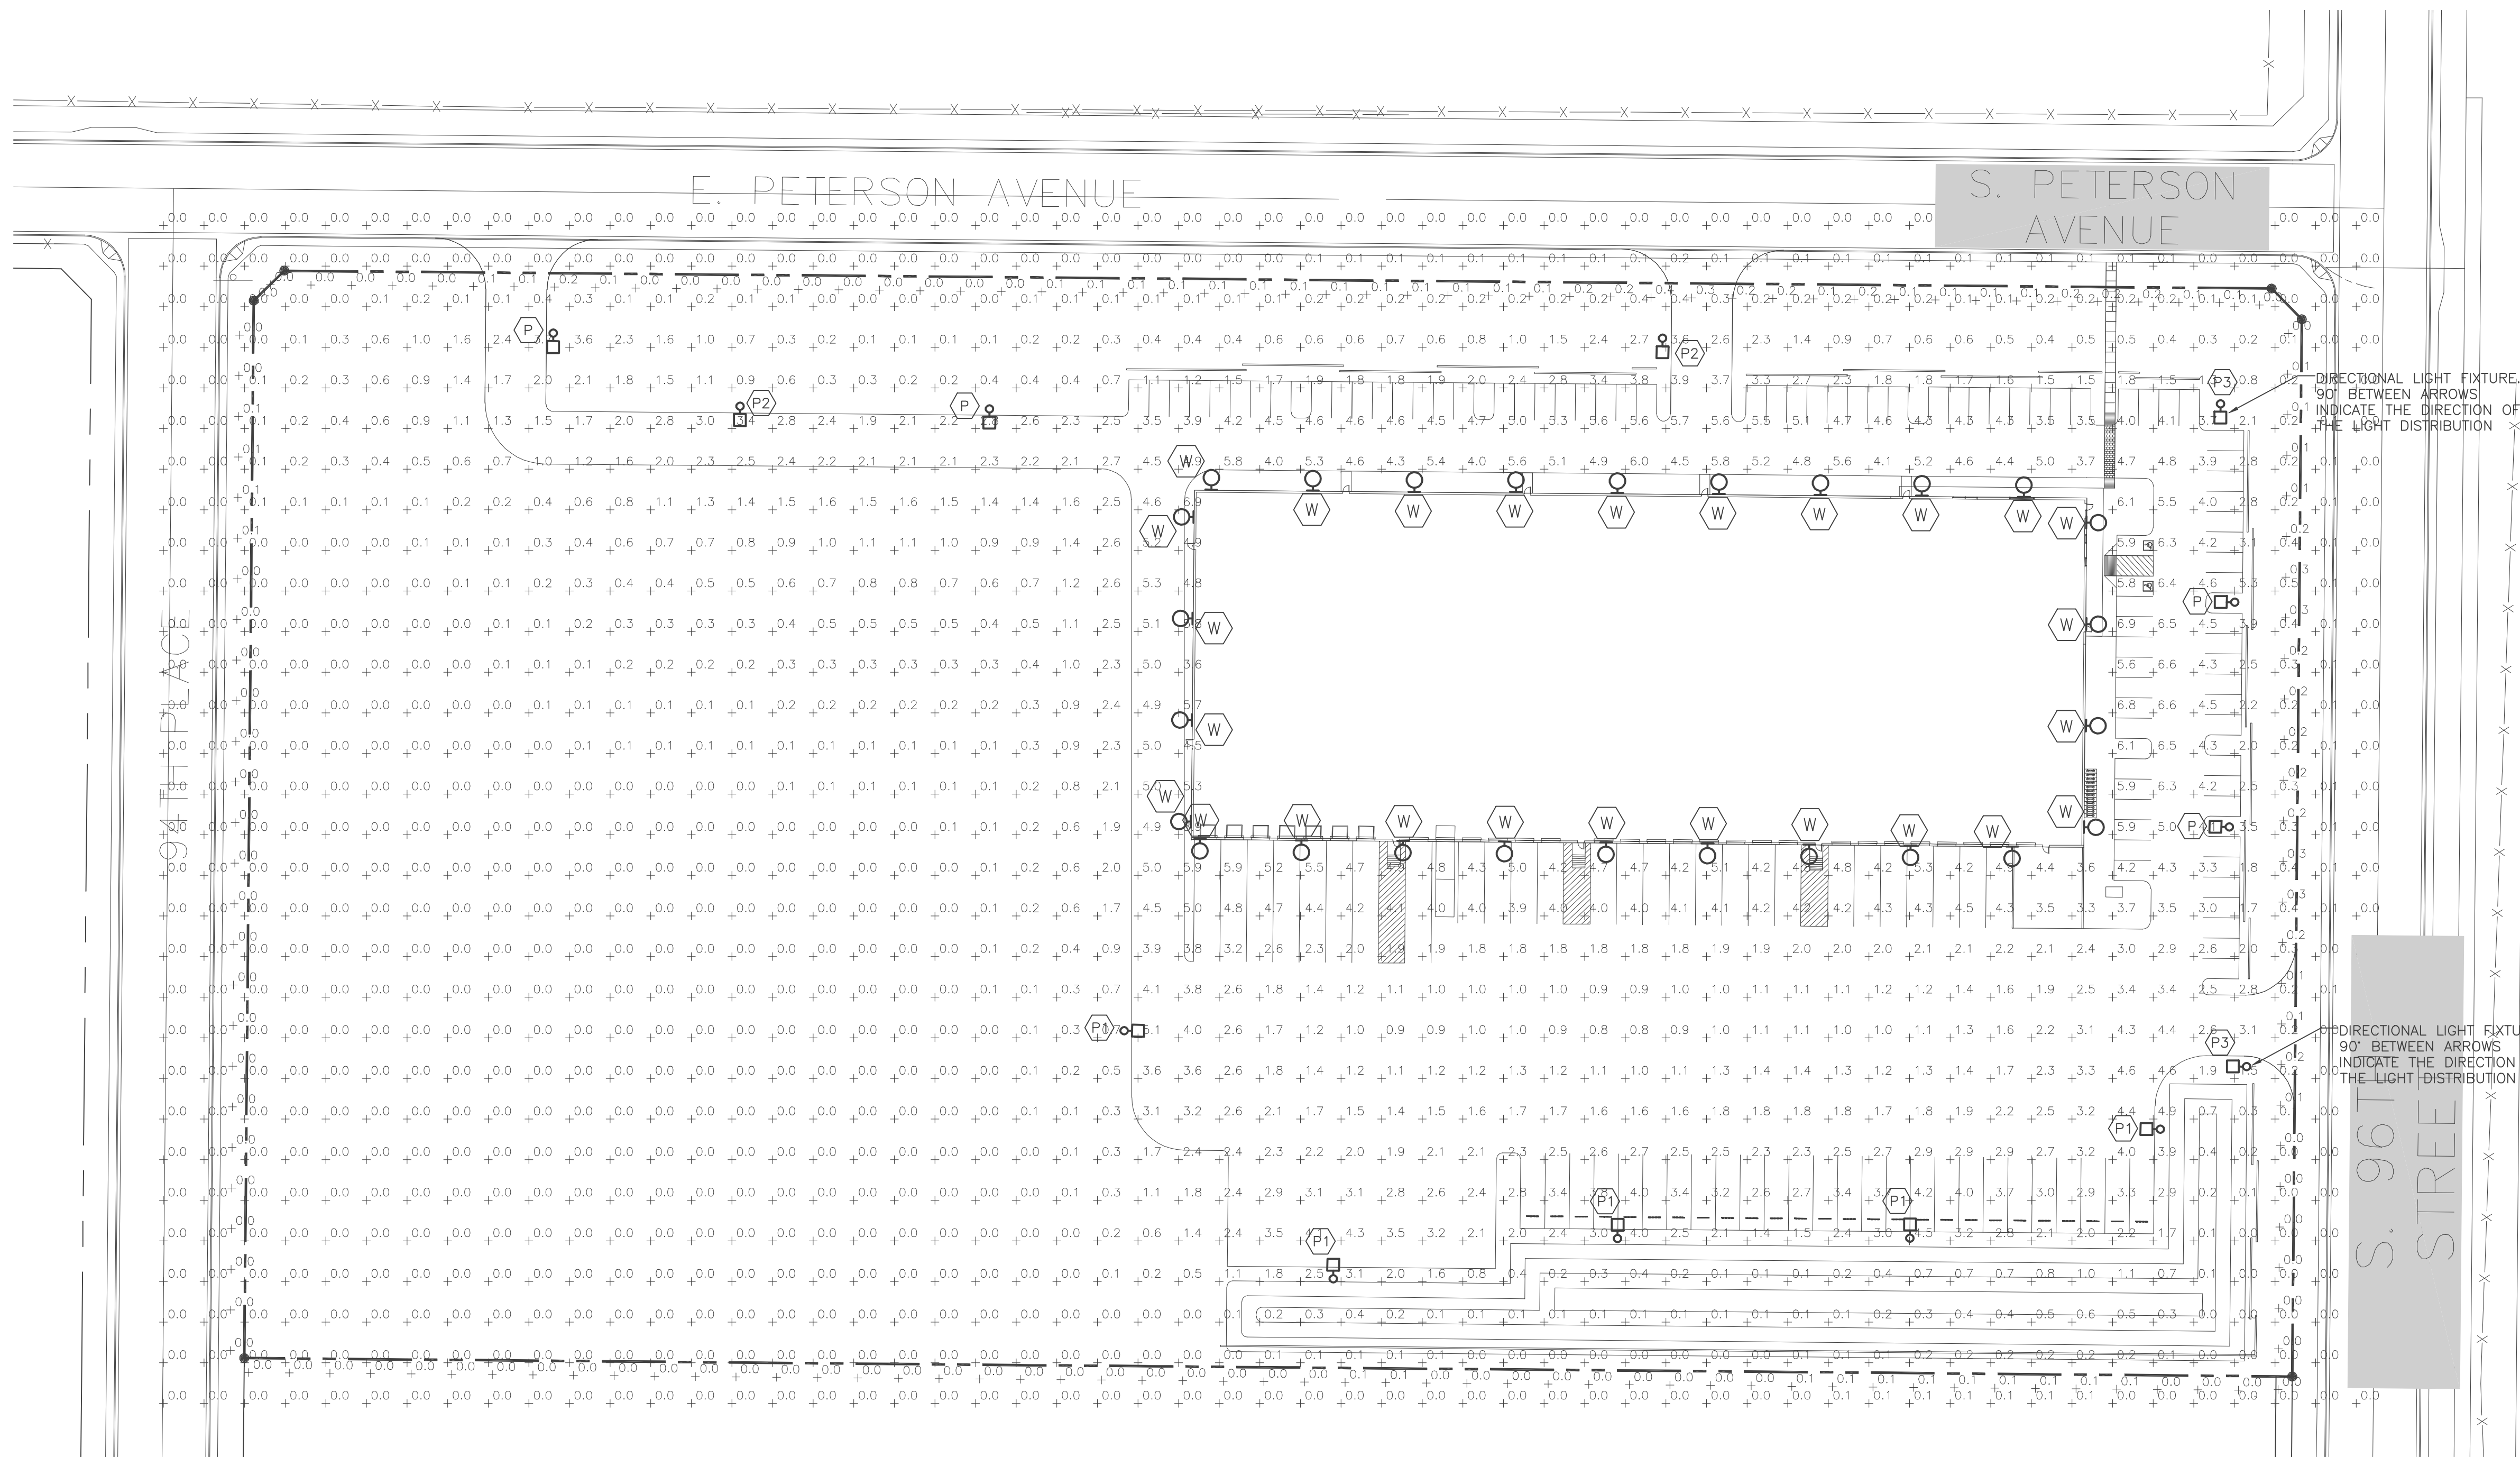


SITE LIGHTING PLAN
SCALE 1" = 50'-0"

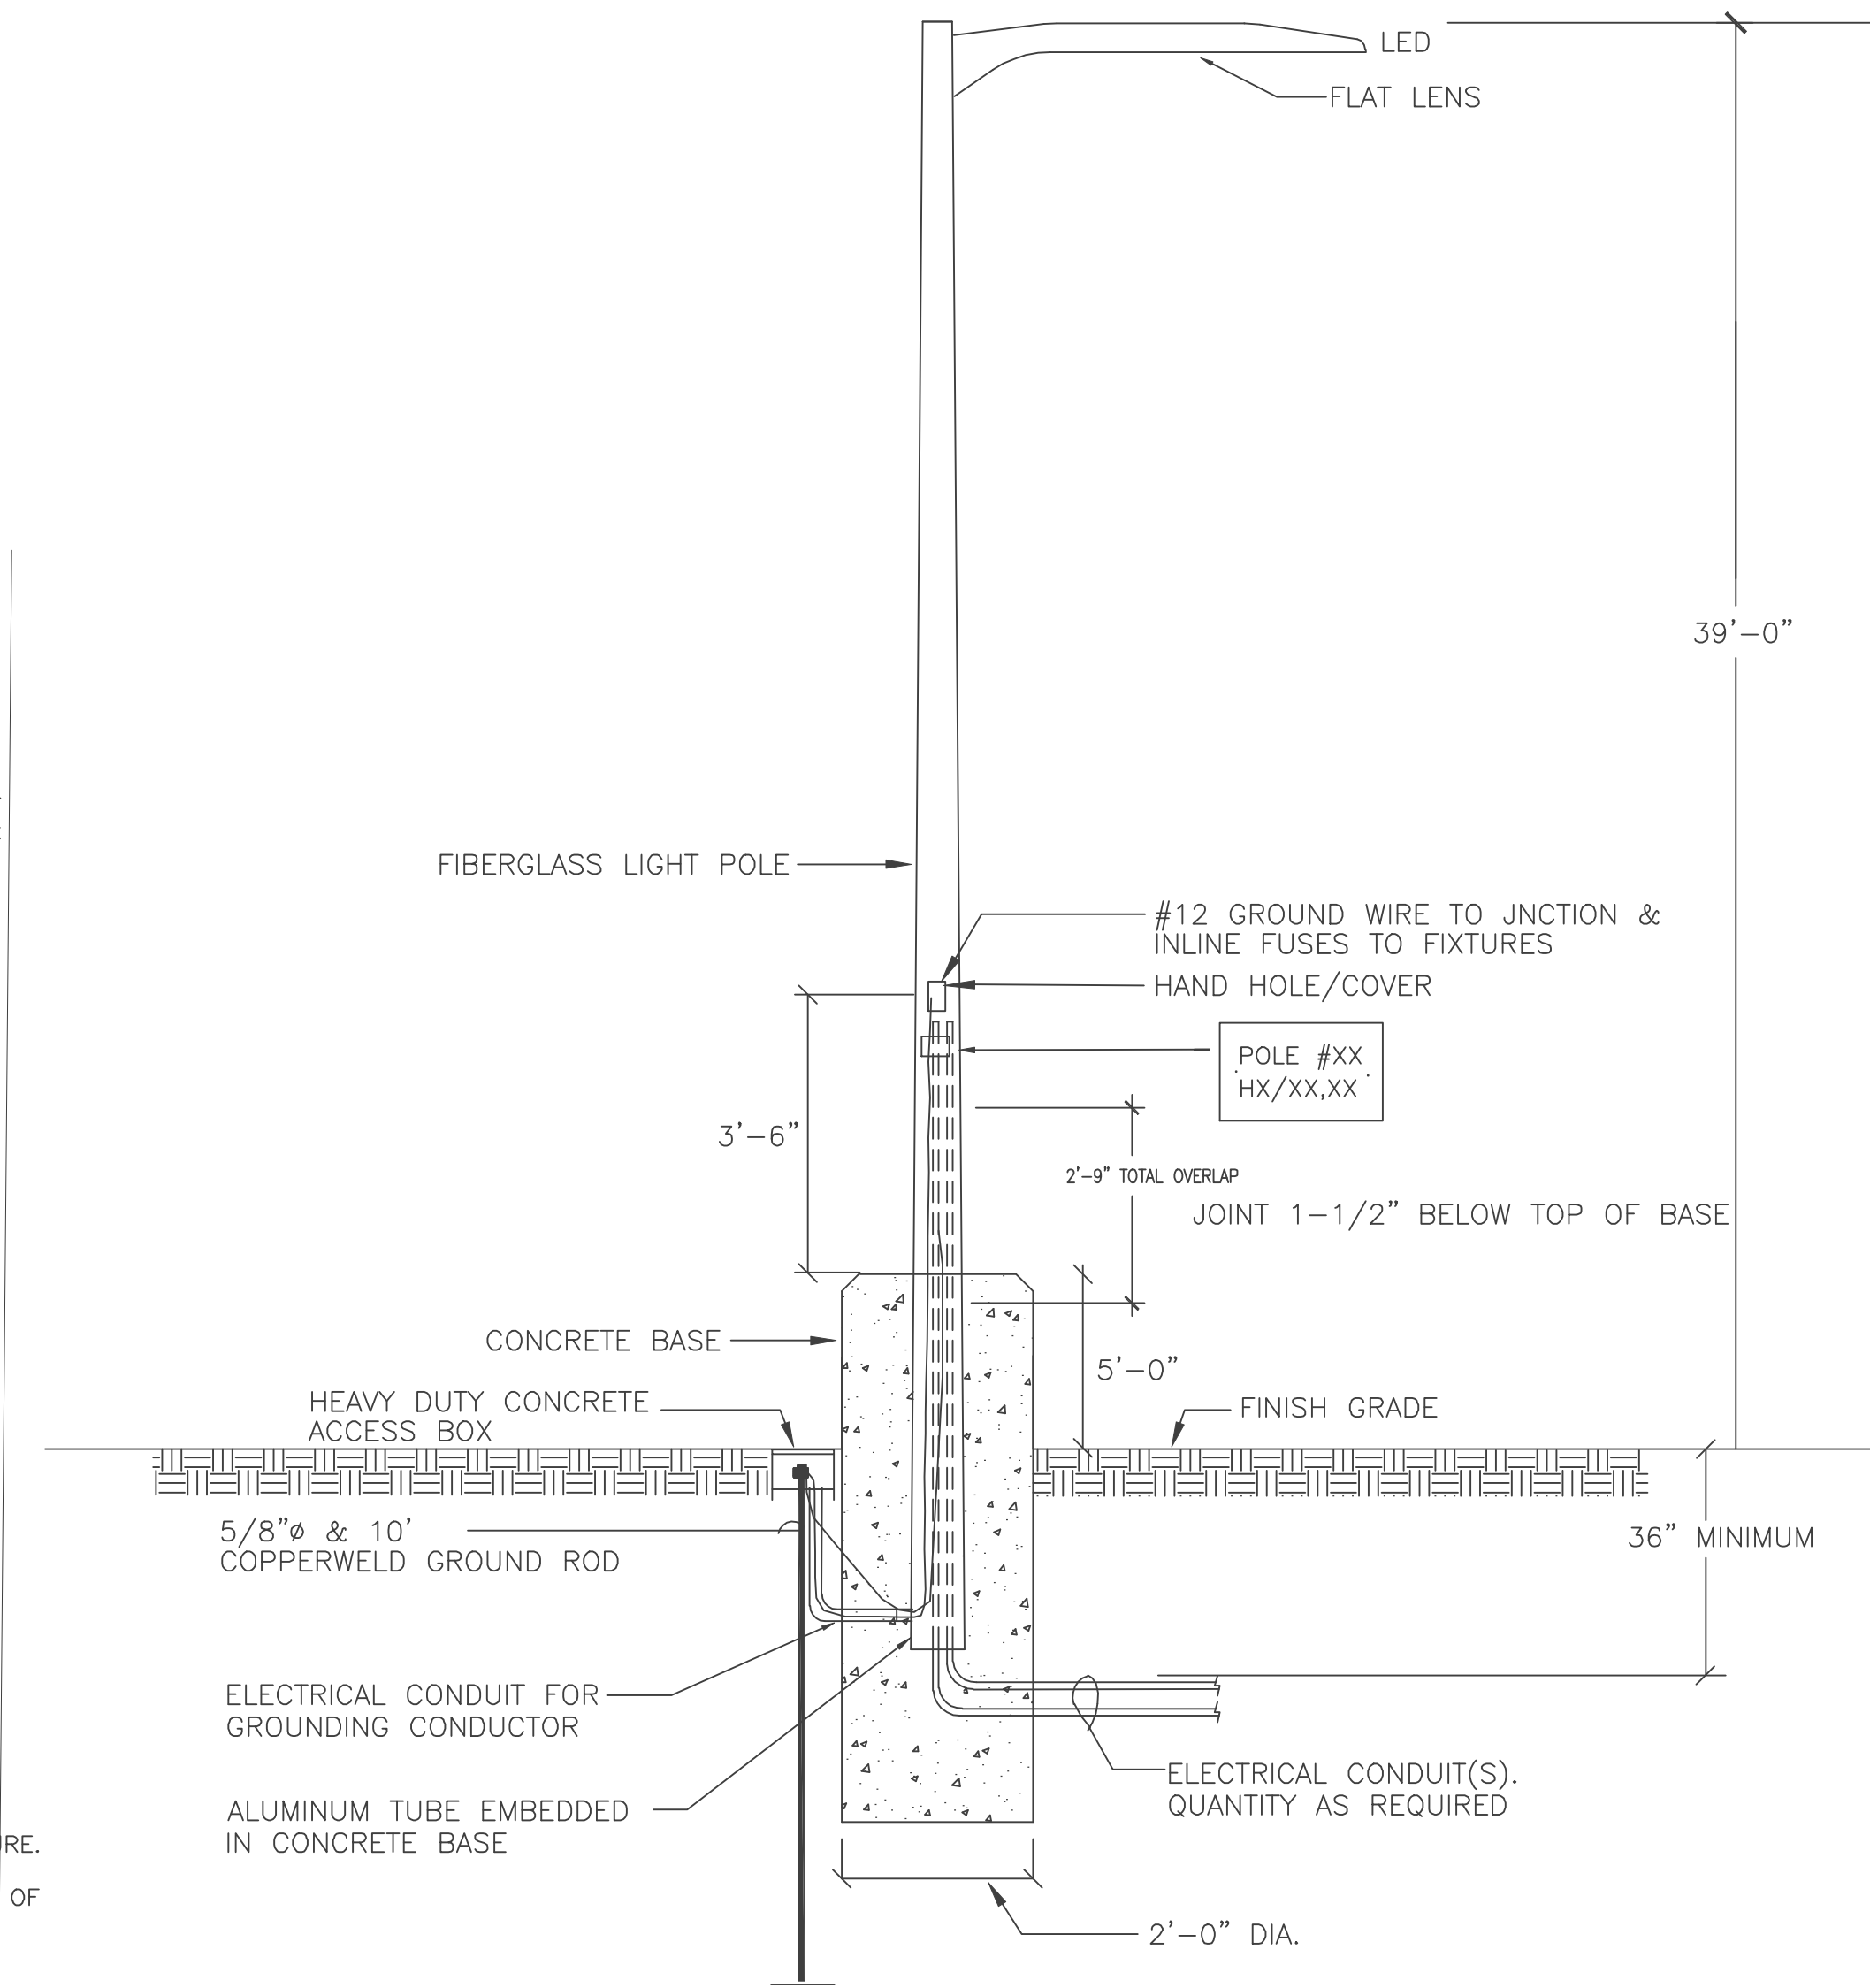

NOTE: PROVIDE CONCRETE J-BX AS REQUIRED.
THIS DETAIL IS FOR ELECTRICAL CONDUITS ROUTING ONLY.
SEE STRUCTURAL DRAWINGS 50.2 FOR DETAILS.

POLE DETAIL
SCALE: NTS

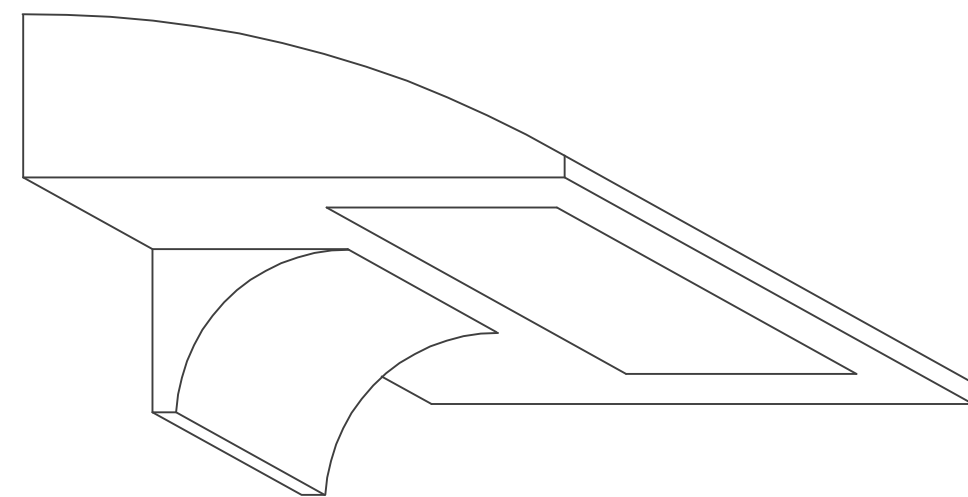

TYPICAL WALL PACK DETAIL
SCALE: NTS

FIXTURE DESCRIPTION	
(P)	COOPER GALLEON GLEON-SA6B-740-U-SL3-HSS-BZ, 249W TYPE 3 DISTRIBUTION. FIBERGLASS POLE 39'-0" ABOVE GRADE, WITH 5'-0" BASE.
(P1)	COOPER GALLEON GLEON-SA0B-740-U-SL4-HSS-BZ, 419W TYPE 4 DISTRIBUTION. FIBERGLASS POLE 39'-0" ABOVE GRADE, WITH 5'-0" BASE.
(P2)	COOPER GALLEON GLEON-SA6B-740-U-SL4-HSS-BZ, 249W TYPE 4 DISTRIBUTION. FIBERGLASS POLE 39'-0" ABOVE GRADE, WITH 5'-0" BASE.
(P3)	COOPER GALLEON GLEON-SA4B-740-U-SLR-HSS-BZ, 171W. FIBERGLASS POLE 39'-0" ABOVE GRADE, WITH 5'-0" BASE.
(W)	LSI INDUSTRIES MRW-LED-18L-SIL-FT-UNV-40-70-BRZ LED, 20' MOUNTING HEIGHT

ISSUED FOR QA

REVISION DATE:

ISSUE DATE: MAY 2022

ARCHITECT REFERENCE NO:

NO PART OF THIS DOCUMENT MAY BE USED OR COPIED IN WHOLE OR IN PART WITHOUT THE PRIOR WRITTEN CONSENT OF T.E.I.NC.

SITE PLAN
PROJECT NO:22-416



DRAWN: NV
CHECKED: AN7/JGM

NEW MDO BUILDING

NWC OF E. PEARIE AVE
& S.96TH ST
MESA, AZ

T.E., Inc.

830 N. RIVERSIDE DRIVE
MESA, AZ 85205
PHONE: 482-970-3763
FAX: 425-970-3756

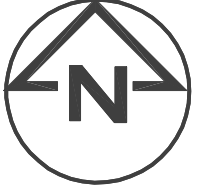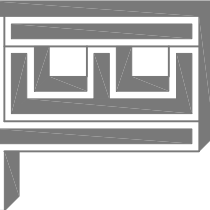

SE-1