



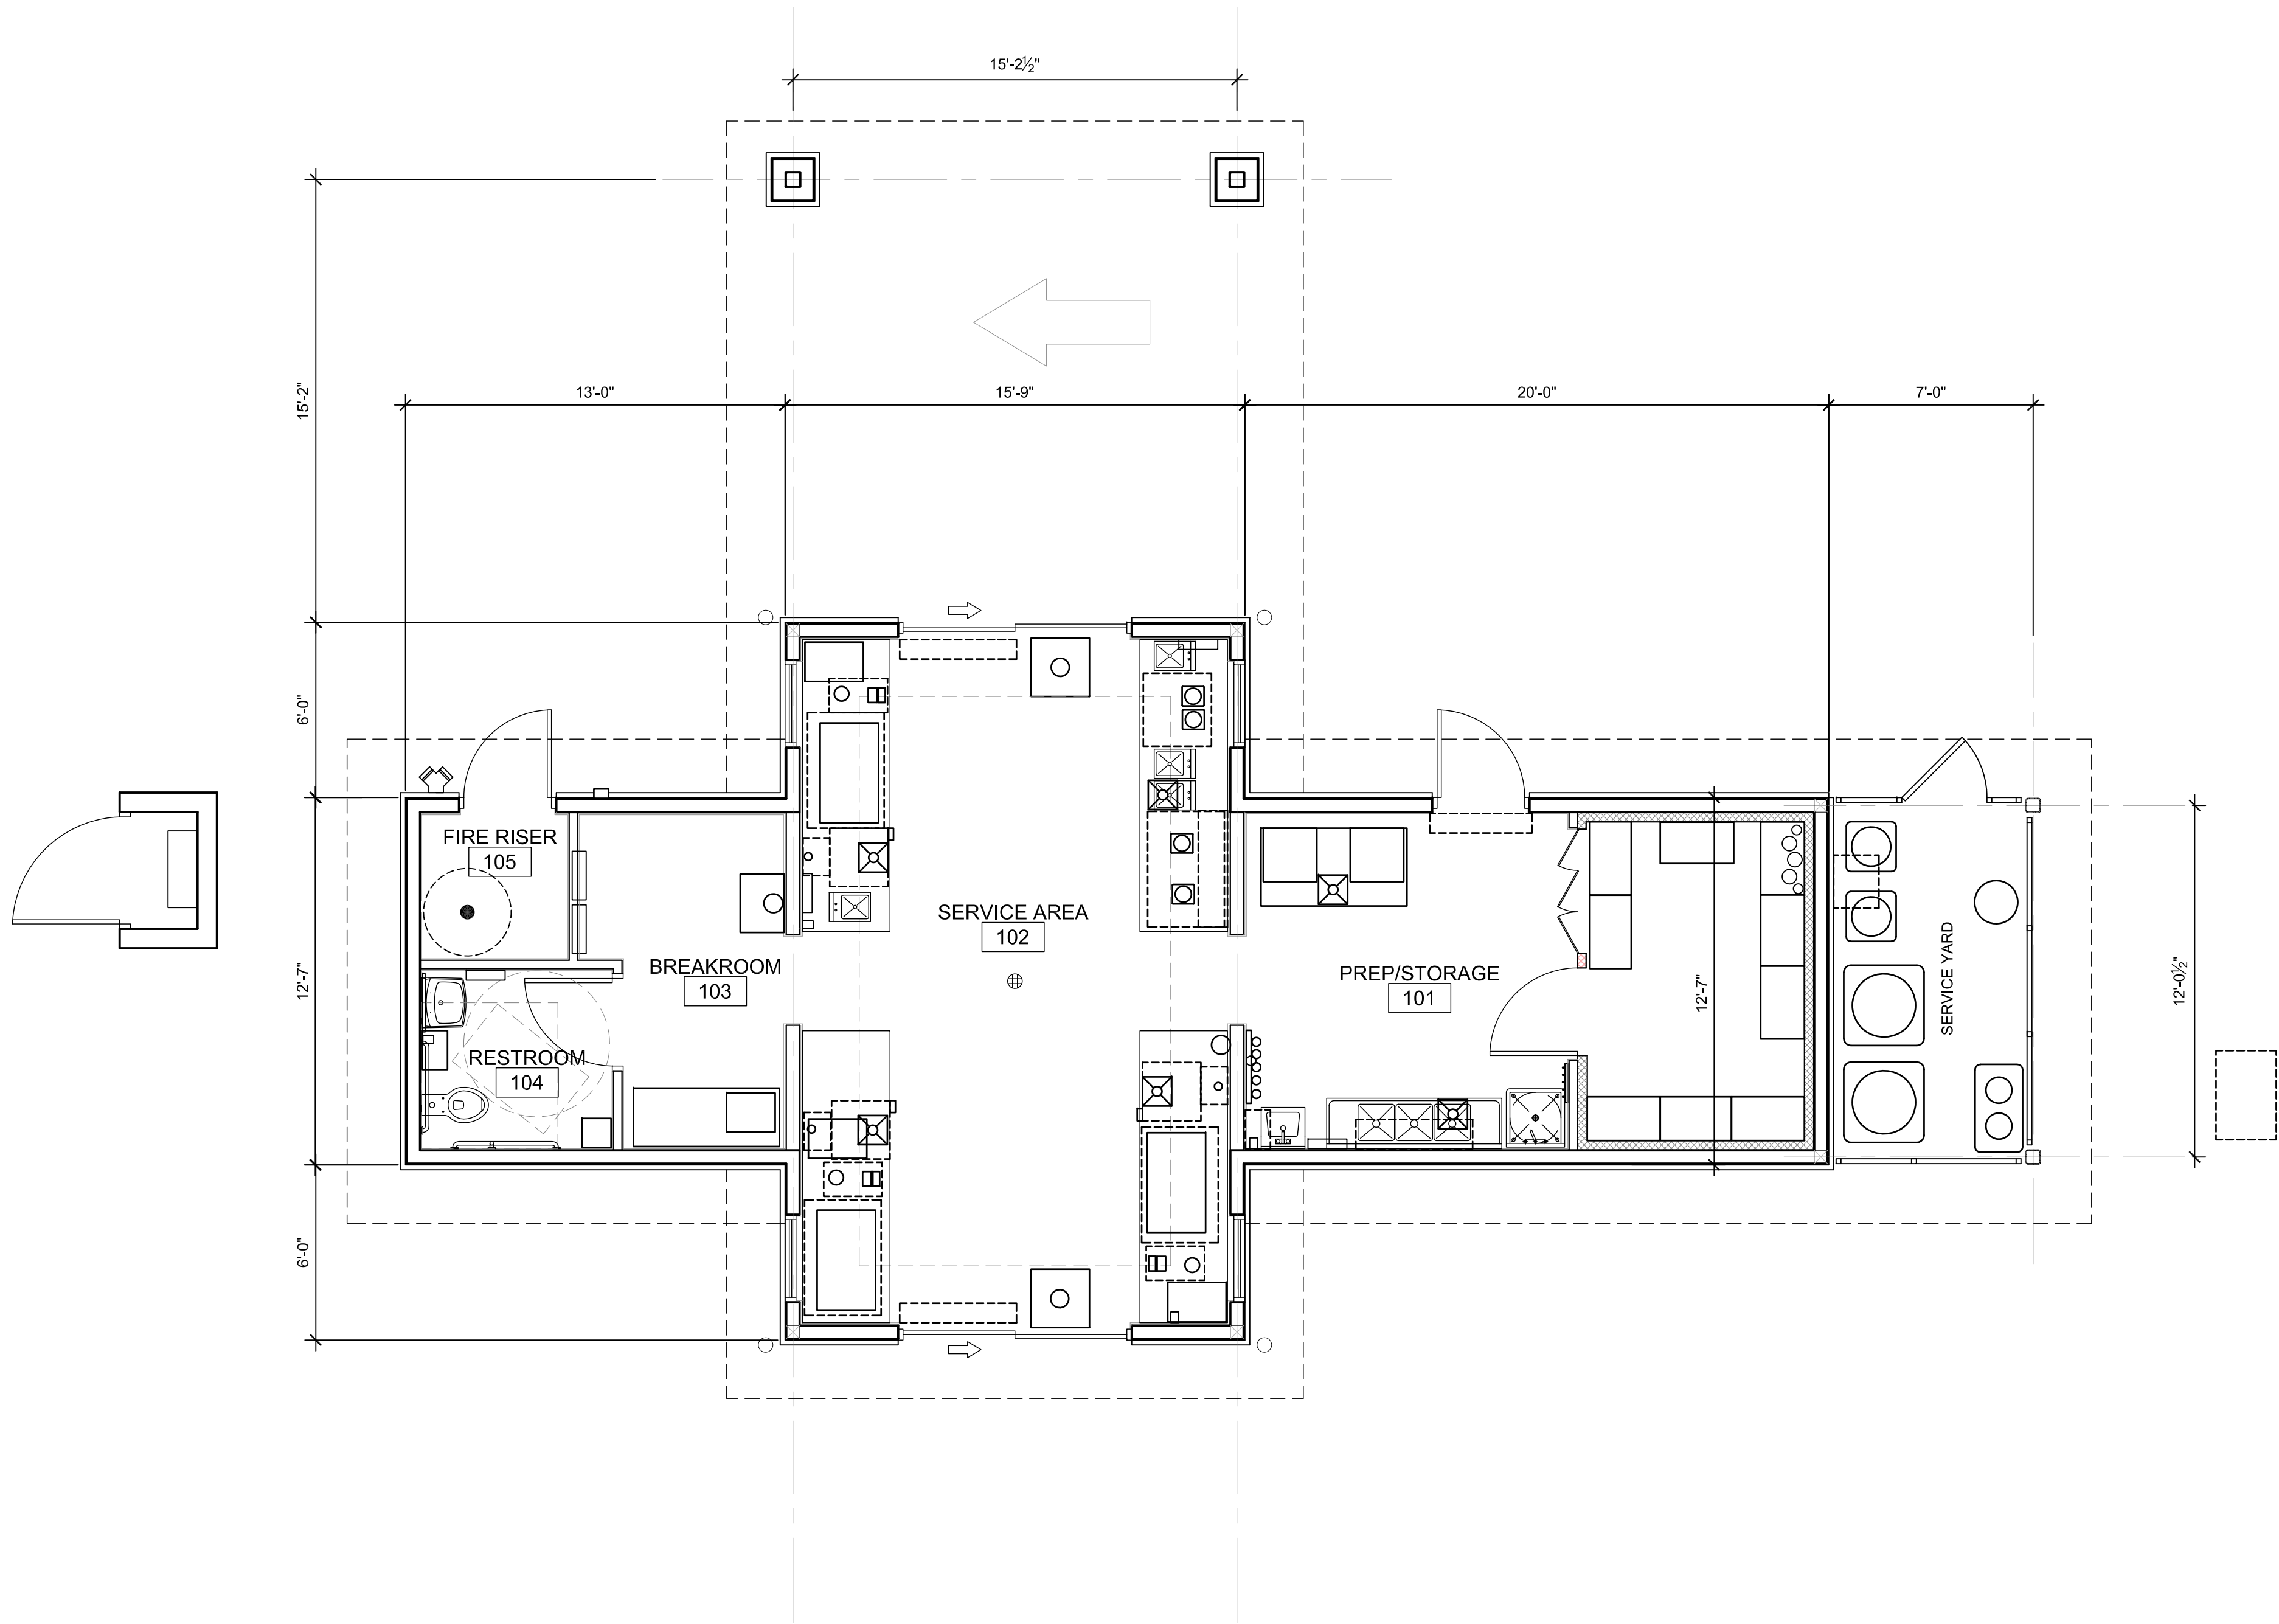

1 FLOOR PLAN

SCALE: 1/4" = 1'-0"

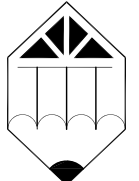

ARCHICON


Architecture & Interiors, L.C.

5055 E WASHINGTON STREET
SUITE 200
PHOENIX, ARIZONA 85034
(602) 222-4266
FAX (602) 279-4305
www.ARCHICON.COM

GRAVITY ENERGY DRINKS

16 W MCKELLIPS

N.E.C. W. MCKELLIPS RD & N. CENTER ST
MESA, ARIZONA 85201

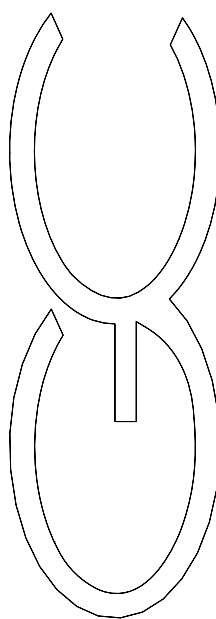

ENERGY DRINKS

PROJECT NUMBER: 2284400-03
PROJECT MANAGER: DEBBIE S.
DRAWN BY: DEBBIE S.
CHECKED BY: JEFF K

NO.	REVISION	DATE

SHEET DESCRIPTION
FLOOR PLAN



SHEET NO.
DR200
ISSUE DATE: 5 DEC 2022