


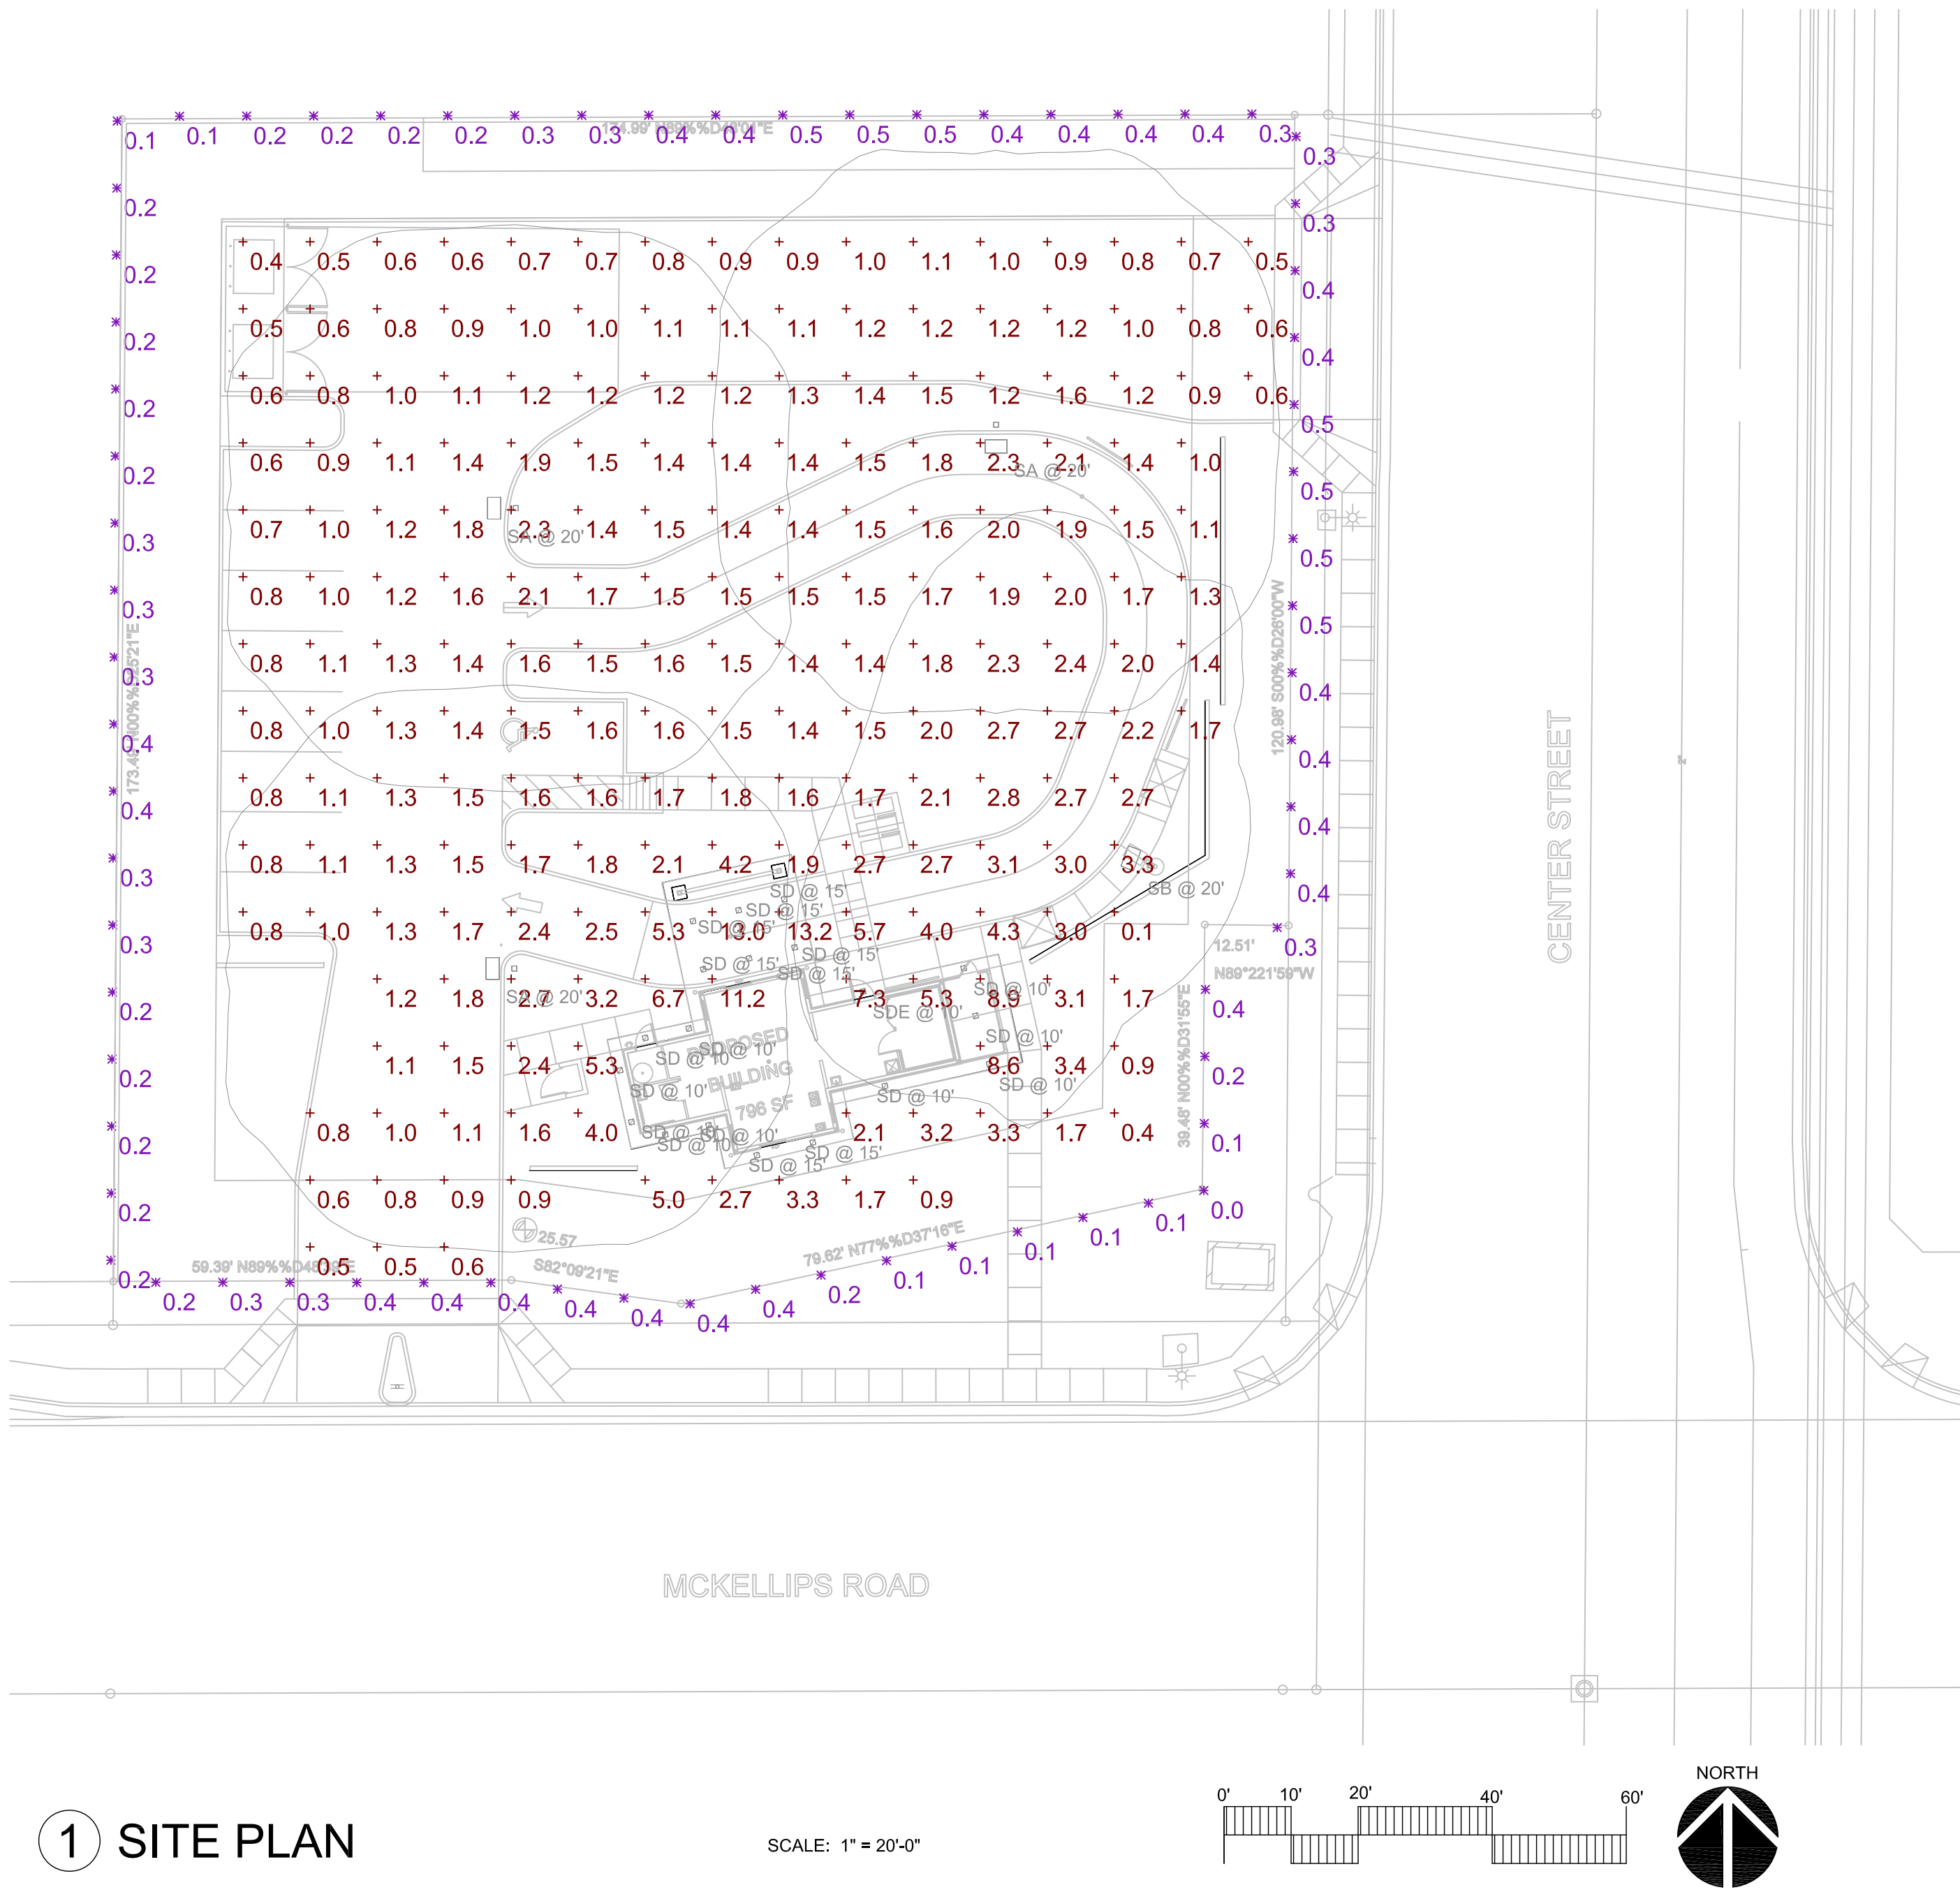

1 SITE PLAN

SCALE: 1" = 20'-0"

Statistics						
Description	Symbol	Avg	Max	Min	Max/Min	Avg/Min
PROPERTY LINE - FC @ 3' AFG	✕	0.3 fc	0.5 fc	0.0 fc	N/A	N/A
SITE - FC @ GRADE	+	1.9 fc	13.2 fc	0.1 fc	132.0:1	19.0:1


Schedule										
Symbol	Label	Quantity	Manufacturer	Catalog Number	Description	Lamp	Filename	Lumens Per Lamp	Light Loss Factor	Wattage
	SA	3	Lithonia Lighting	DSX0 LED P5 30K T5W MVOLT SPA (FINISH) / SSS 17.5' W/2.5' BASE	DSX0 LED P5 30K T5W MVOLT	LED - 3000K	DSX0_LED_P5_30K_T5 W_MVOLT.ies	11183	0.91	89
	SB	1	Lithonia Lighting	DSX0 LED P5 30K TFTM MVOLT SPA HS (FINISH) / SSS 17.5' W/2.5' BASE	DSX0 LED P5 30K TFTM MVOLT with houseside shield	LED - 3000K	DSX0_LED_P5_30K_TF TM_MVOLT_HS.ies	8465	0.91	89
	SD	17	TGS	TWSF 0818 C U (3000K)	THINTEK WAFER S	LED - 3000K	TWSF-0818-C-U (2700K)_IESNA2002.I ES	1427	0.91	17.5
	SDE	1	TGS	TWSF 0818 C U (3000K) 90016-H	THINTEK WAFER S W/EM BATTERY PACK	LED - 3000K	TWSF-0818-C-U (2700K)_IESNA2002.I ES	1427	0.91	17.5



ARCHICON
Architecture & Interiors, L.C.

5055 E WASHINGTON STREET
SUITE 200
PHOENIX, ARIZONA 85034
(602) 222-4266
FAX (602) 279-4305
www.ARCHICON.COM

GRAVITY ENERGY DRINKS
16 W MCKELLIPS
N.E.C. W. MCKELLIPS RD & N. CENTER ST
MESA, ARIZONA 85201

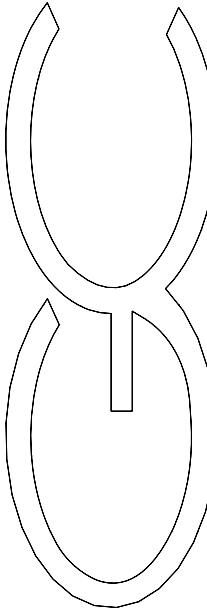

ENERGY DRINKS

PROJECT NUMBER: 2284400-03
PROJECT MANAGER: DEBBIE S.
DRAWN BY: DEBBIE S.
CHECKED BY: JEFF K

NO	REVISION	DATE

SHEET DESCRIPTION
PHOTOMETRIC PLAN



SHEET NO.

PH100

ISSUE DATE: 5 DEC 2022