



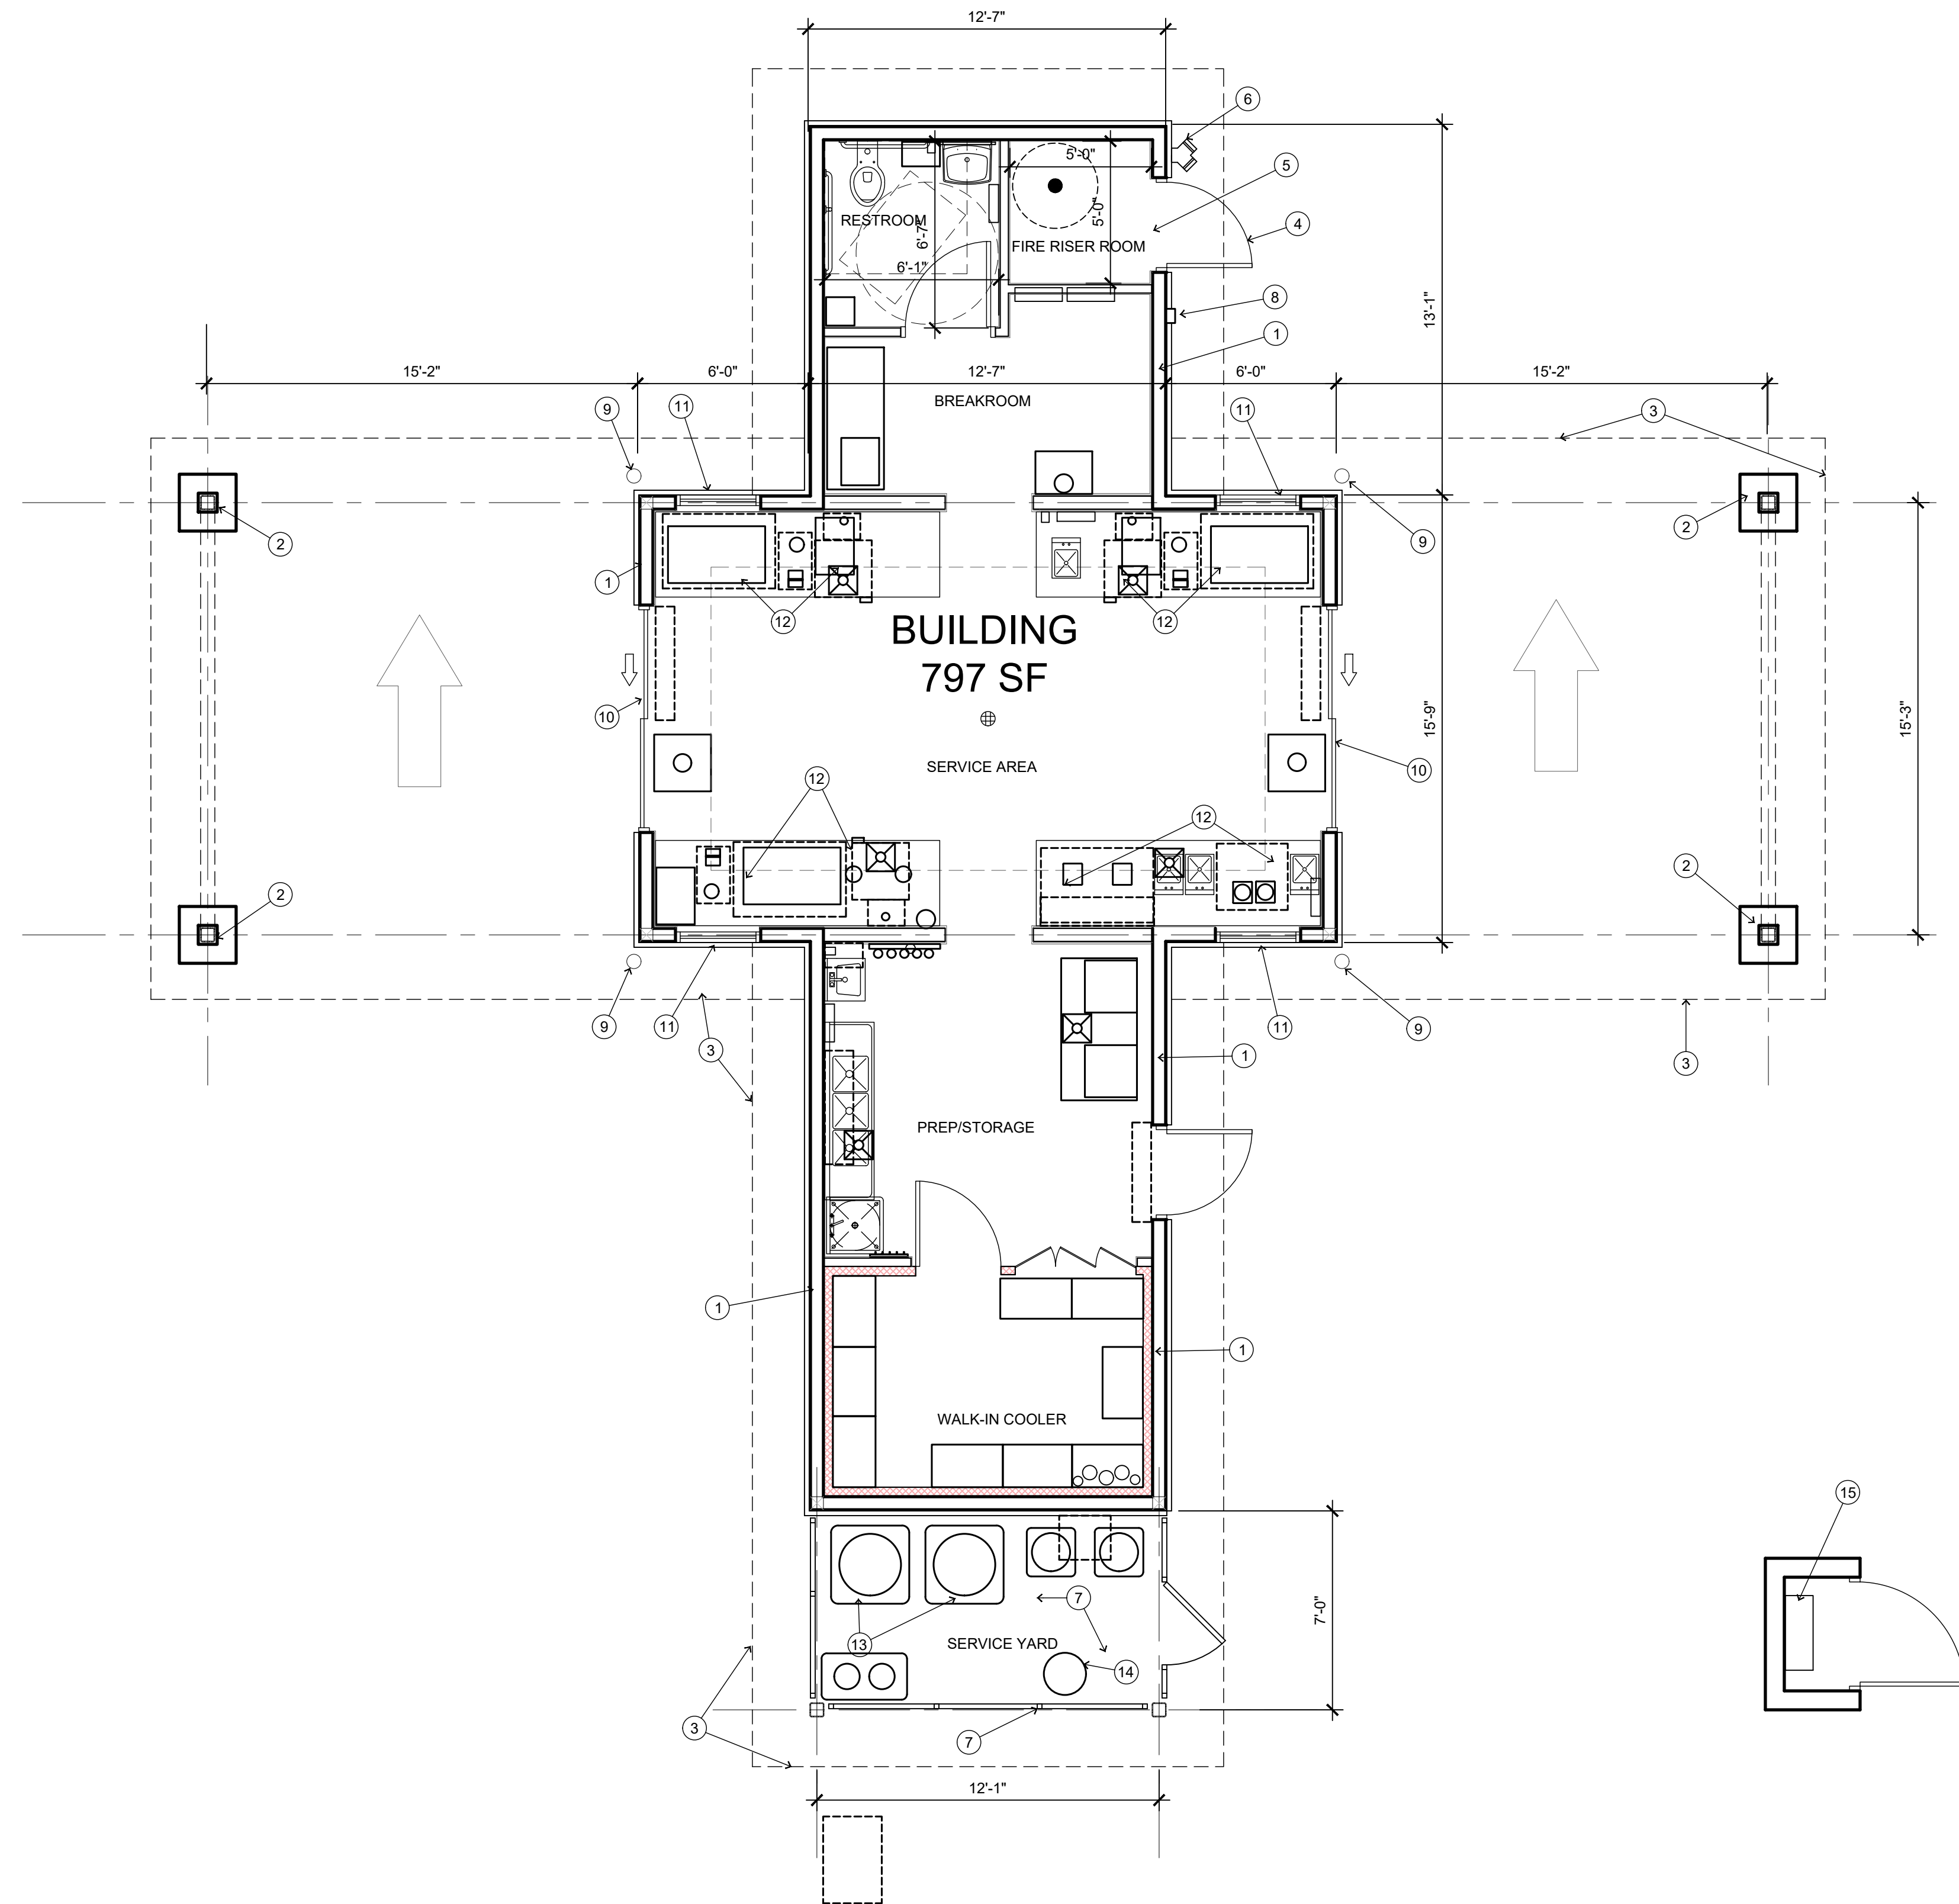


1 FLOOR PLAN

SCALE: 1/8" = 1'-0"

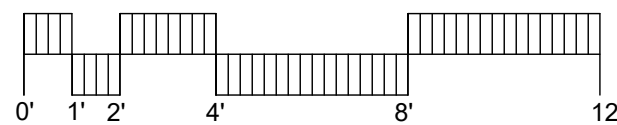

KEYNOTES

- 1 EXTERIOR WOOD STUD WALL WITH STONE VENEER AND STUCCO FINISH
- 2 CMU COLUMN WITH STONE VENEER AND STEEL COLUMN ABOVE
- 3 ROOF OVERHANG (DASHED)
- 4 HOLLOW METAL DOOR AND FRAME. PAINTED
- 5 FIRE RISER LOCATION
- 6 FIRE DEPARTMENT CONNECTION (F.D.C.)
- 7 PERFORATED METAL SCREENED MECHANICAL YARD
- 8 KNOX BOX LOCATION
- 9 6" DIA. STEEL BOLLARD
- 10 SLIDING GLASS DOOR
- 11 ALUMINUM WINDOW
- 12 KITCHEN EQUIPMENT
- 13 GROUND MOUNTED CONDENSER WITHIN SCREENED MECHANICAL YARD
- 14 CO2 TANK WITHIN SCREENED MECHANICAL YARD
- 15 400AMP MAIN ELECTRICAL SERVICE ENTRY SECTION IN CMU ENCLOSURE WITH DOOR. EXPOSED TO SKY. FULLY SCREENED. SEE SITE PLAN FOR LOCATION

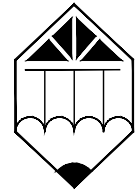

ARCHICON

Architecture & Interiors, L.C.

5055 E WASHINGTON STREET

SUITE 200


PHOENIX, ARIZONA 85034

(602) 222-4266

FAX (602) 279-4305

www.ARCHICON.COM

GRAVITY ENERGY DRINKS
10059 E SOUTHERN AVE
MESA, ARIZONA 85209

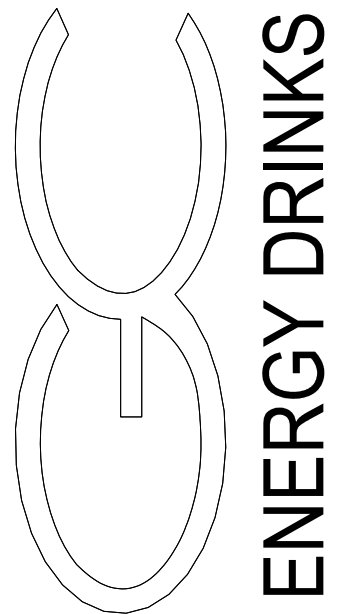

PROJECT NUMBER: 2284400-02
PROJECT MANAGER: DEBBIE S.
DRAWN BY: JEFF K
CHECKED BY: JEFF K

NO	REVISION	DATE

SHEET DESCRIPTION
FLOOR PLAN



SHEET NO.

DR200

ISSUE DATE: 22 AUG 2022