

WARE MALCOMB
Landscape Design for Commercial Real Estate

2777 E. Camelback Rd., Suite 325
Phoenix, AZ 85016
P 602.767.1001
F 602.767.2288



THE BRICKYARDS ON ELLSWORTH
9263 EAST WILLIS ROAD
MESA, ARIZONA 85212

PHOTOMETRIC SITE



REMARKS

PA / PM: MRH
DRAWN BY: CDS
JOB NO.: PHX22-0166-00

SHEET

PH1.0

 WILLIS ROAD

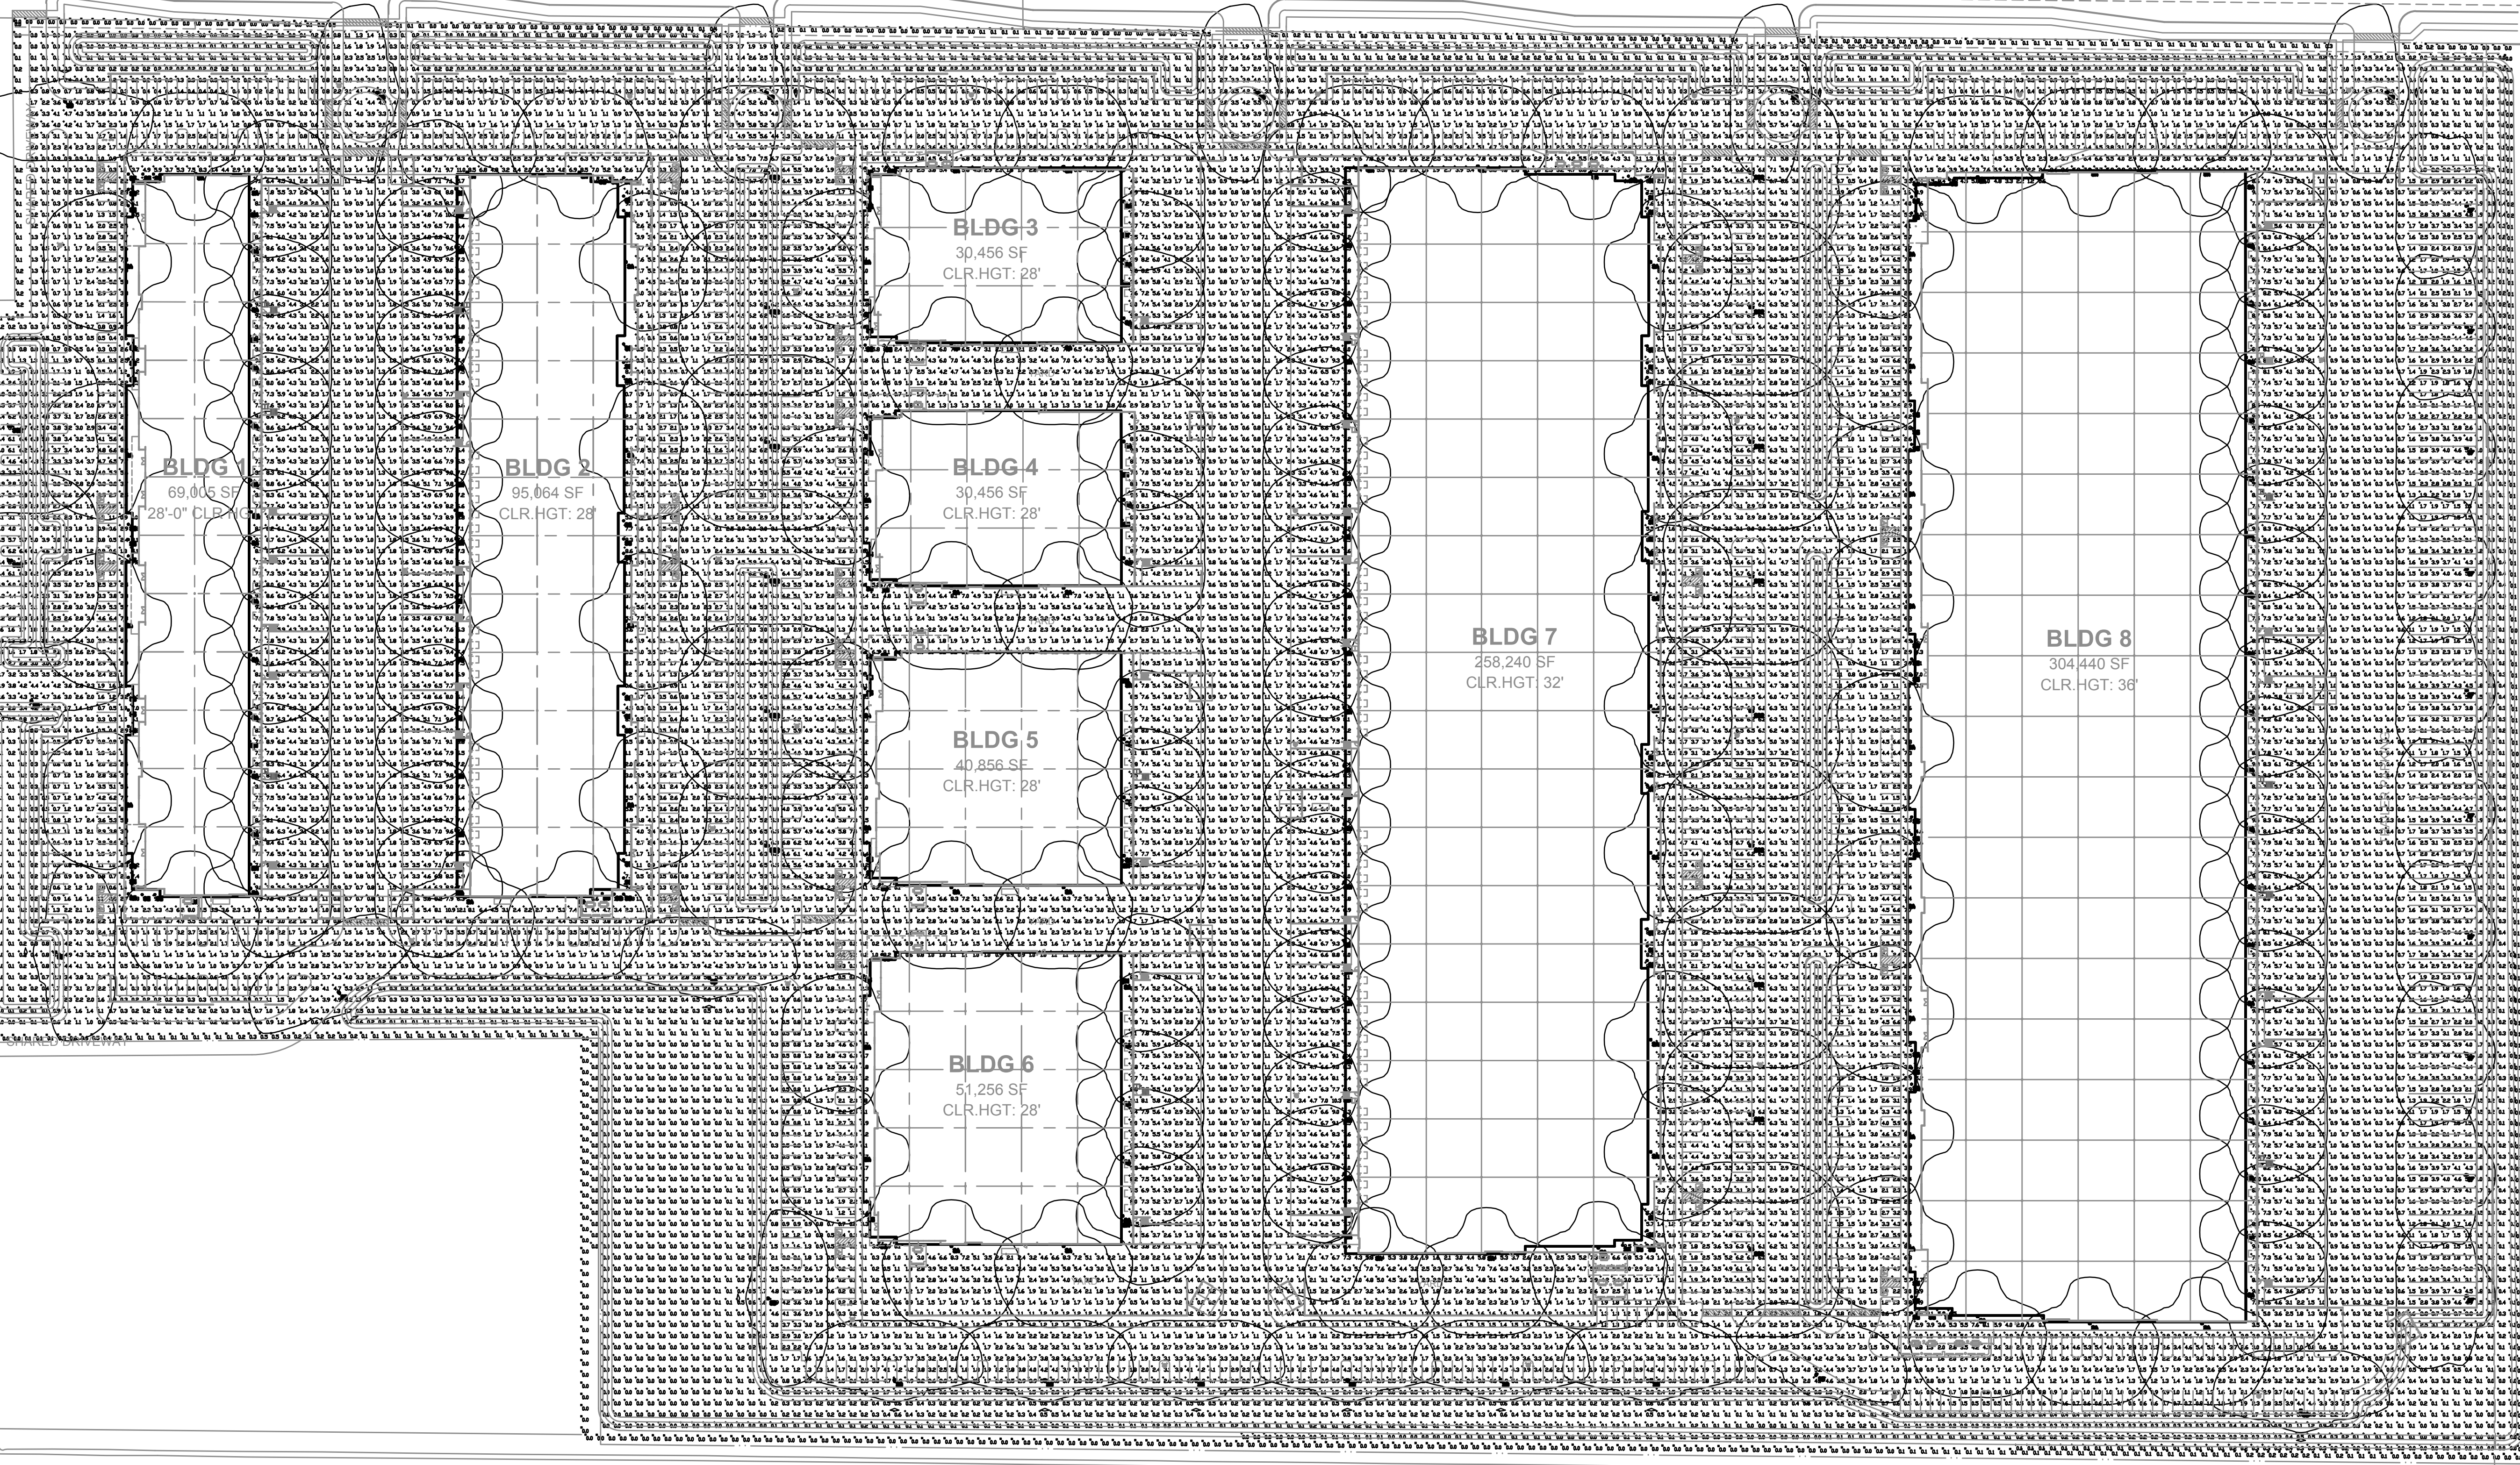

PHOTOMETRIC SITE PLAN
1"=80'-0"

Schedule		QTY	Manufacturer	Catalog	Description	Lamp	Number Lamps	Lamp Output	Intensity Multiplier	LLF	Total Output	Input Power
Symbol	Label											
	LA	138	LITHONIA	WDG4 LED P6 70CRI RFT 40K / WALL MOUNT AT 25'	WDG4 LED WITH P6 - PERFORMANCE PACKAGE, 4000K, 70CRI, FORWARD THROU OPTIC, MOUNTED AT 25'	LED 4000K	1	25586	1	0.91	25586	185.23
	SC2	17	LITHONIA	DSX1 LED P9 40K TSM HVOLT/ SSS 22.5' POLE DN 25' BASE	DSX1 LED P9 40K TSM HVOLT, MOUNTED AT 25'	LED 4000K	1	28633	1	0.91	57266	482
	SD	19	LITHONIA	DSX1 LED P9 40K TSM HVOLT HS/ SSS 22.5' POLE DN 25' BASE	DSX1 LED P9 40K TSM HVOLT with houseshield shield, MOUNTED AT 25'	LED 4000K	1	21708	1	0.91	21708	241
	SF	10	LITHONIA	DSX1 LED P9 40K TSM HVOLT HS/ SSS 22.5' POLE DN 25' BASE	DSX1 LED P9 40K TSM HVOLT with houseshield shield, MOUNTED AT 25'	LED 4000K	1	21533	1	0.91	21533	241
	SG	109	GOTHAM	EVD6 40/15 AR MVD LSS VOLT GZ10	EVD 6IN ROUND, 90 CRI, 4000K, 1500LM, MED WIDE DIST, CLEAR, SEMI-SPEC, MOUNTED AT 12'	LED 4000K	1	1418	1	0.91	1418	14.7
	EM	25	LITHONIA	AFF FCT	AFF premium FCT (Forward Throw), MOUNTED AT 10'	LED, Forward throw	1	451	1	1	451	5.48

Statistics		Avg	Max	Min	Max/Min	Avg/Min
Description	Symbol					
Calc Zone B2	+	2.4 Fc	121 Fc	0.0 Fc	N/A	N/A
PROPERTY LINE	X	0.1 Fc	0.8 Fc	0.0 Fc	N/A	N/A

7201 N. Dreamy Drive Drive
Suite 200
Phoenix, Arizona 85020
(602) 943.6116
Facsimile (602) 943.2507
www.mpcosult.com
Job No. 22144

ALL CONCEPTS, DESIGNS, AND DATA INDICATED ON THESE DOCUMENTS ARE THE SOLE PROPERTY OF THE PETERSON ASSOCIATES, INC. AND SHALL NOT BE USED FOR ANY OTHER PURPOSE THAN ORIGINALLY INTENDED WITHOUT THE WRITTEN PERMISSION OF THE ENGINEER.

