


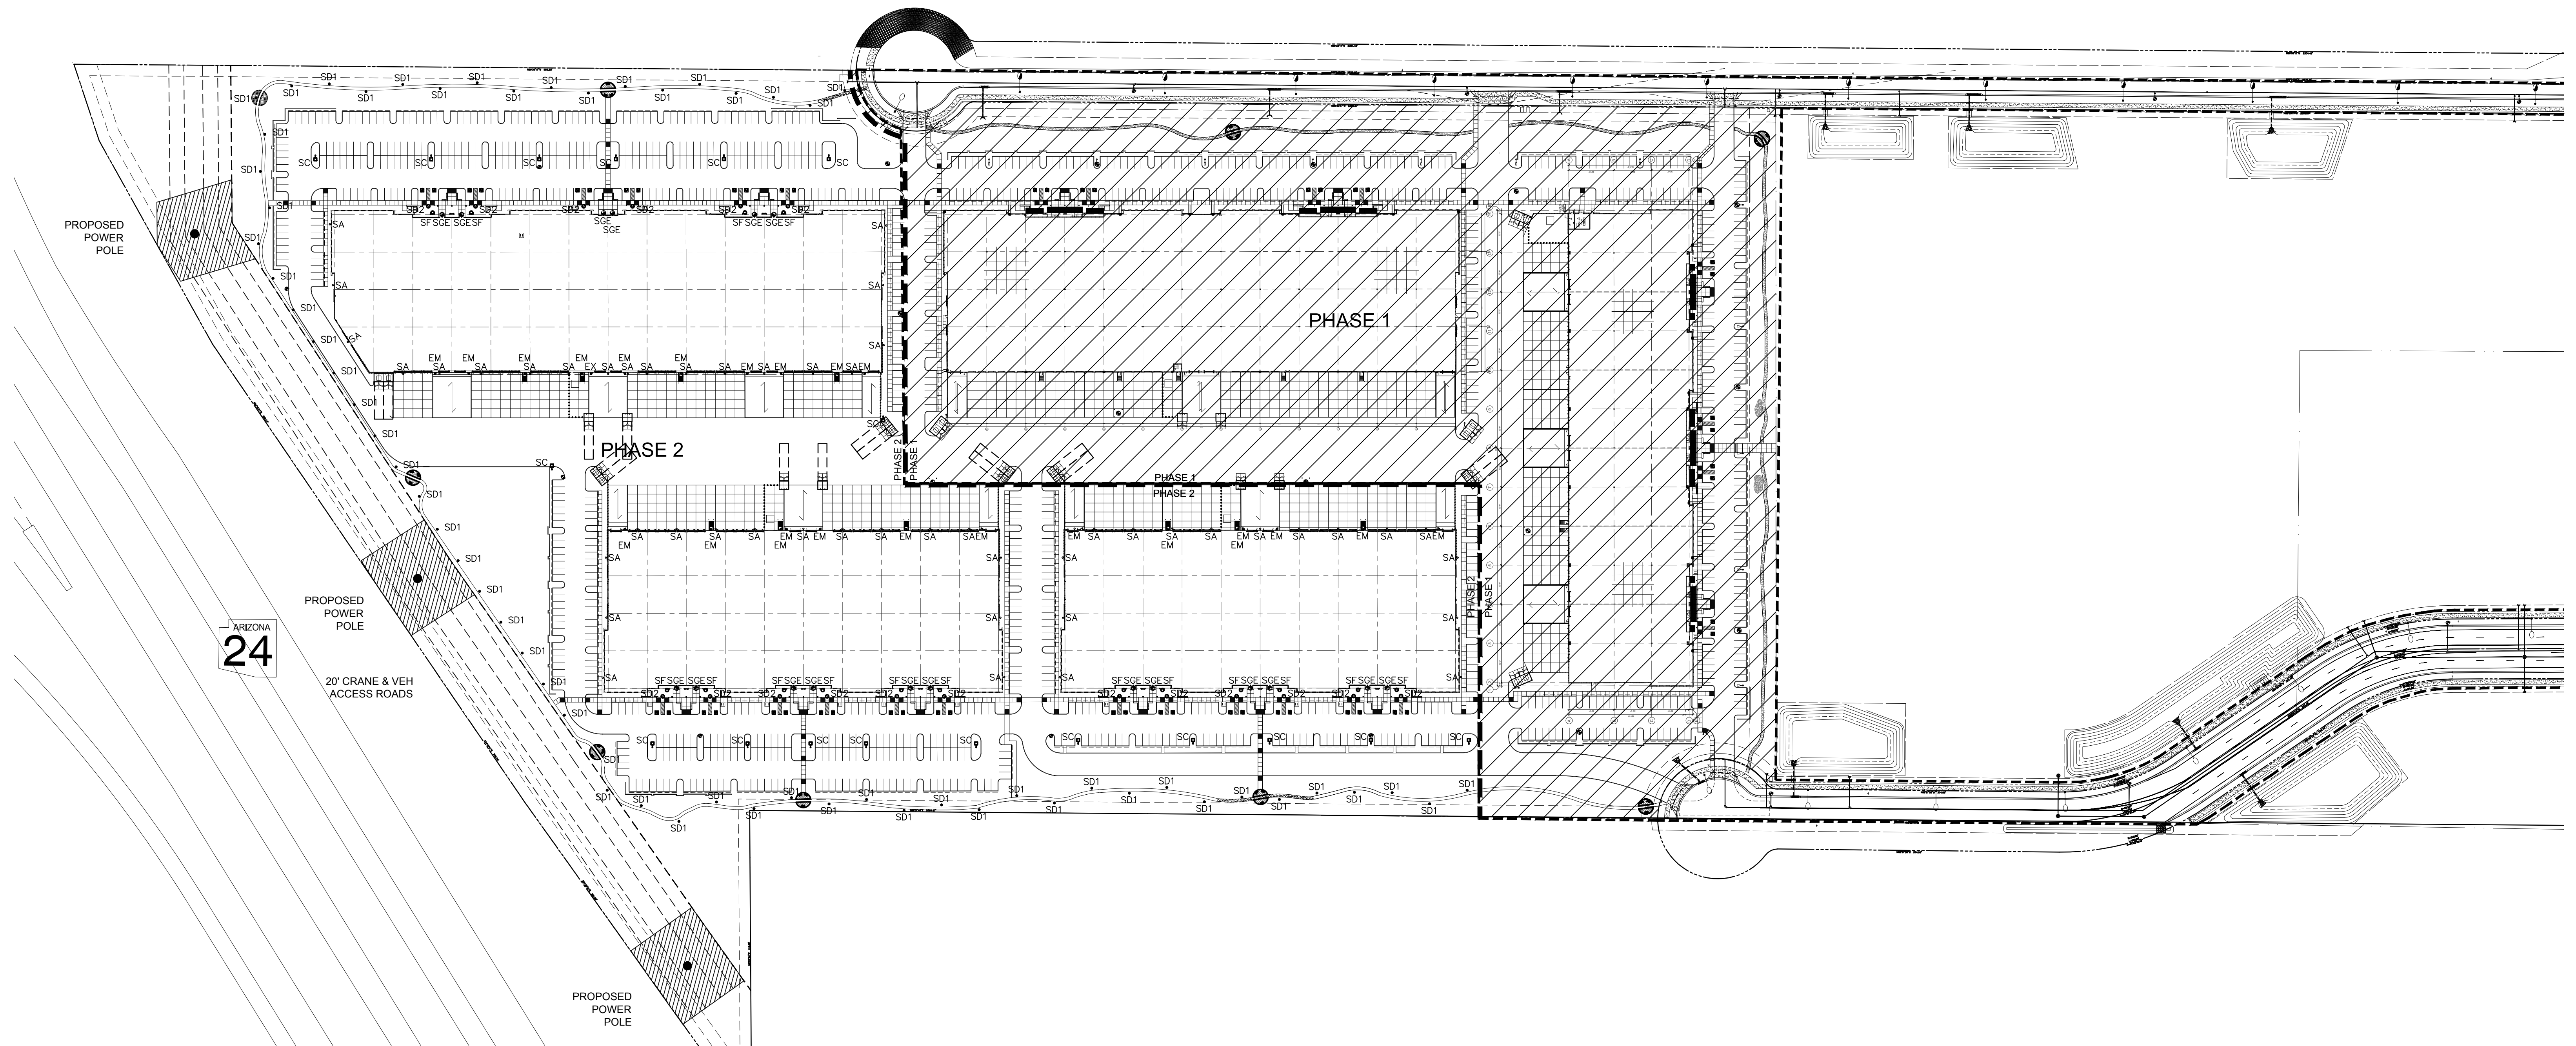

SITE LIGHTING PLAN

0 50' 100' 200'
SCALE: 1" = 100'


SIHI

VIEW 202 - PHASE 2

Ellsworth Road & Point 22 Blvd


Proposed Commerce Center
Mesa, Arizona

E0.1

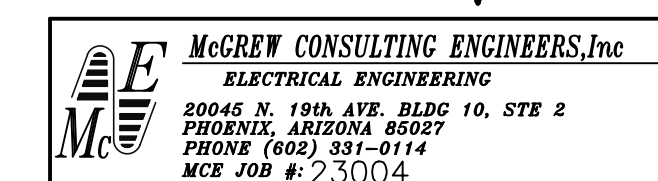

Butler Design Group, Inc
architects & planners

01-23-23
17093.200-ST02

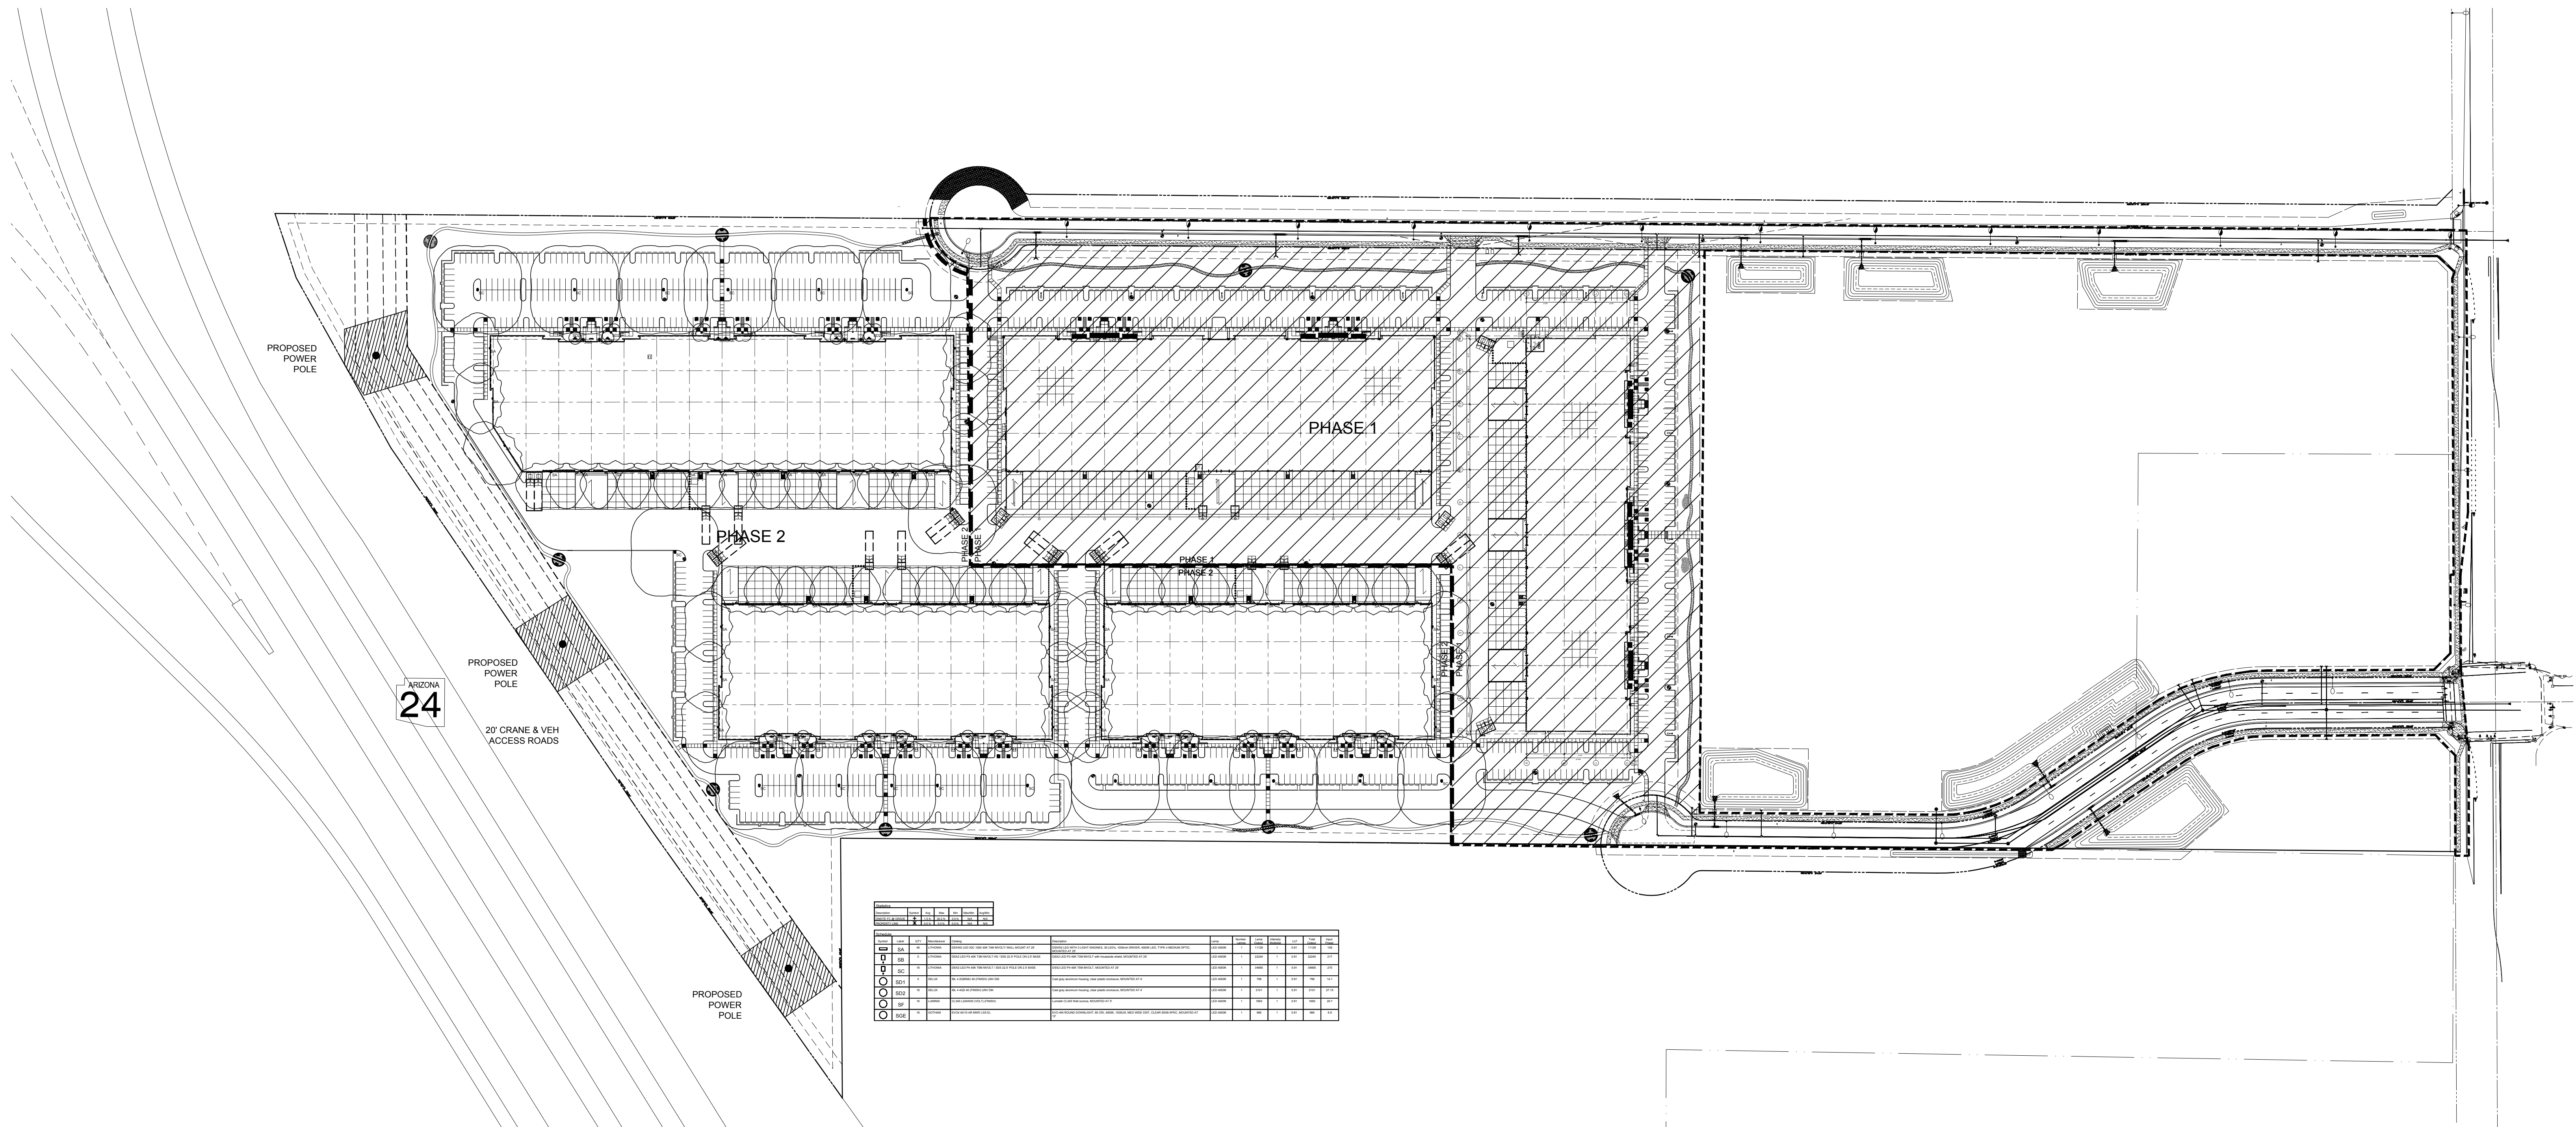

SITE PHOTOMETRIC PLAN

0 50' 100' 200'
SCALE: 1" = 100'

SIHI

VIEW 202 - PHASE 2

Ellsworth Road & Point 22 Blvd

Proposed Commerce Center
Mesa, Arizona

E0.2

McGREW CONSULTING ENGINEERS, Inc.
ELECTRICAL ENGINEERING
20045 N. 19TH AVE. BLDG 10, STE 2
PHOENIX, ARIZONA 85027
PHONE (602) 331-0114
MCE JOB # 23004



Butler Design Group, Inc.
architects & planners

01-23-23
17093.200-ST02

