



THIS DOCUMENT IS THE PROPERTY OF SKETCH ARCHITECTURE COMPANY. IT IS TO BE USED ONLY FOR THE PROJECT AND SITE SPECIFICALLY IDENTIFIED HEREON. IT IS NOT TO BE REPRODUCED, COPIED, OR TRANSMITTED IN ANY FORM OR BY ANY MEANS, ELECTRONIC OR MECHANICAL, INCLUDING PHOTOCOPYING, RECORDING, OR BY ANY INFORMATION STORAGE AND RETRIEVAL SYSTEM, WITHOUT THE WRITTEN PERMISSION OF SKETCH ARCHITECTURE COMPANY. ANY UNAUTHORIZED USE OF THIS DOCUMENT IS PROHIBITED AND WILL BE CONSIDERED A VIOLATION OF THE ARCHITECTURAL PROFESSIONAL SEAL AND LICENSE. SKETCH ARCHITECTURE COMPANY, 2454 EAST SOUTHERN AVENUE, MESA, ARIZONA 85205. TEL: 480.888.8022.

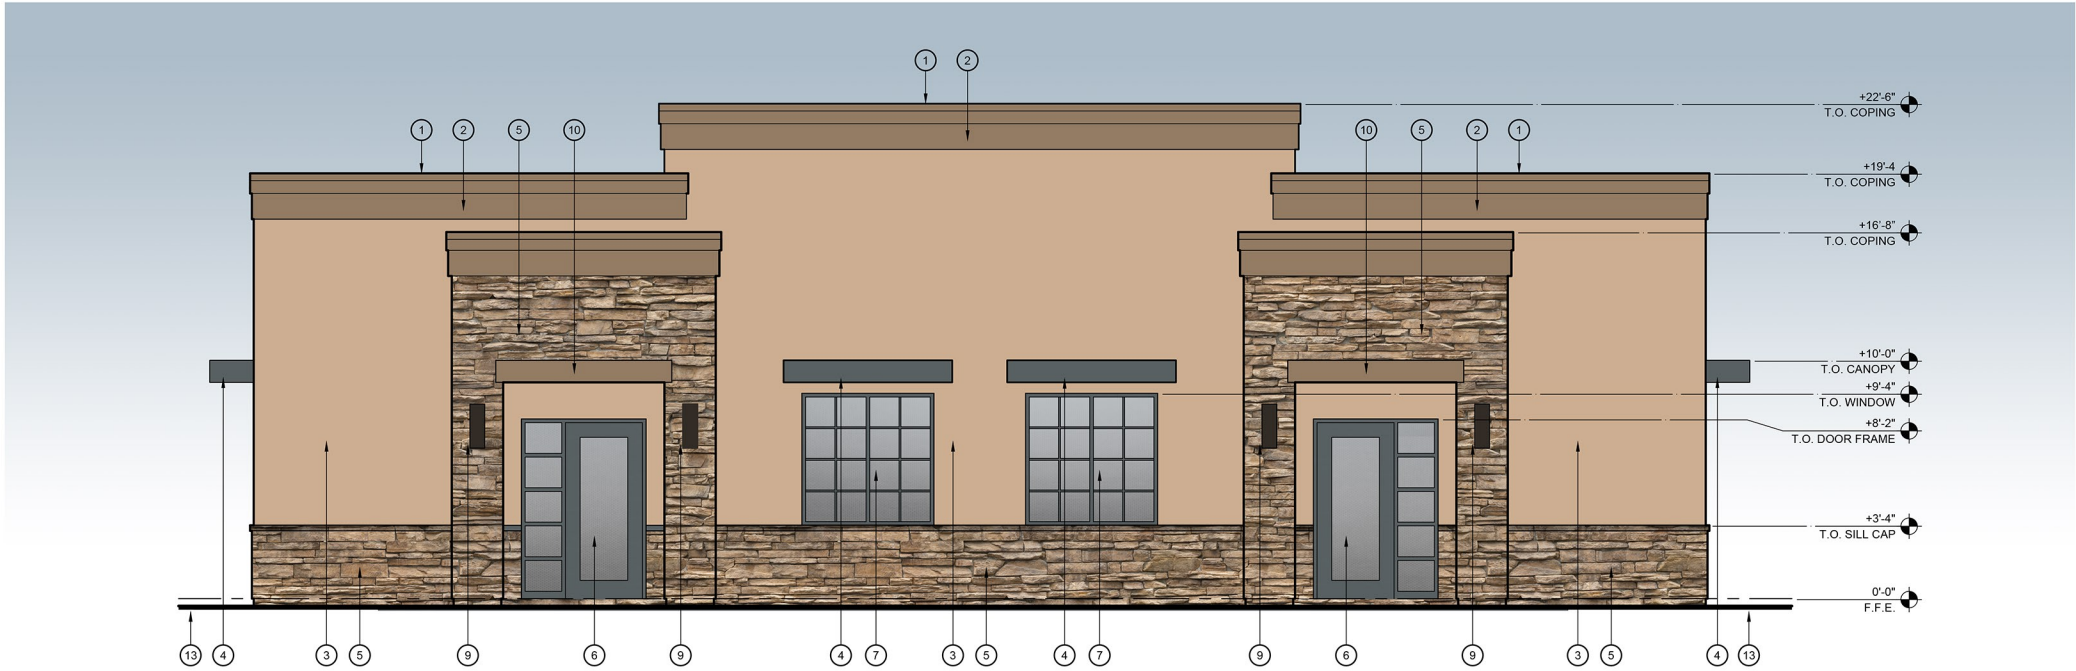

1 WEST EXTERIOR ELEVATION
SCALE: 1/4"= 1'-0"

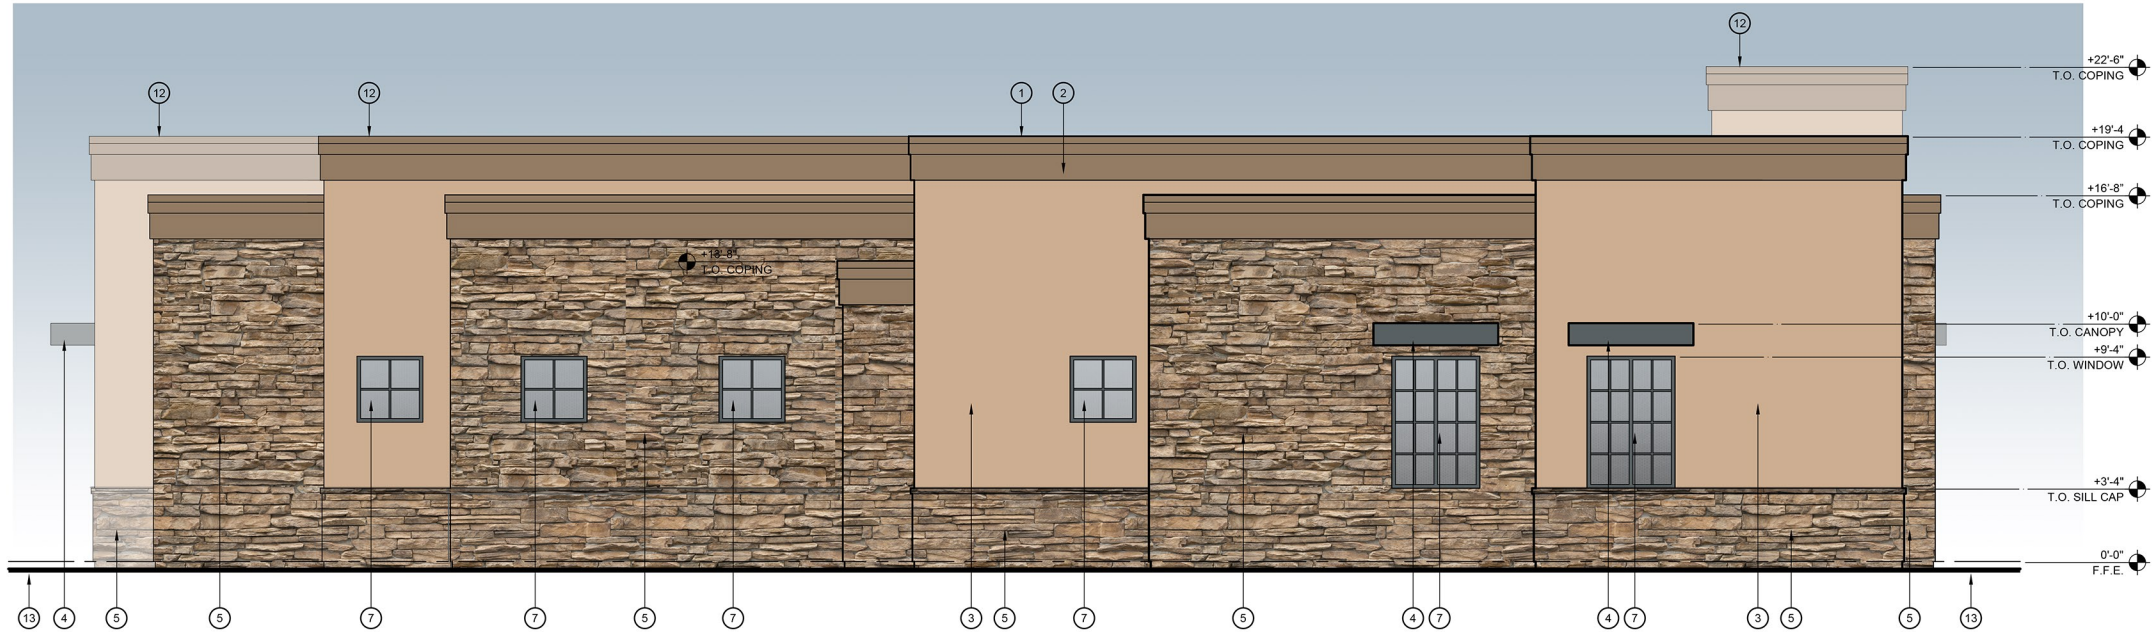

2 NORTH EXTERIOR ELEVATION
SCALE: 1/4"= 1'-0"

KEYNOTES

- 1 METAL COPING CAP AT TOP OF CORNICE WITH PRIMED & PAINTED FINISH "DE6125 CARVED WOOD"
- 2 E.I.F.S. ON PREFORMED CORNICE WITH PRIMED & PAINTED FINISH "DE6125 CARVED WOOD"
- 3 E.I.F.S. ON FIELD EXTERIOR WALLS WITH PRIMED & PAINTED FINISH "DE6116 DOVER PLAINS"
- 4 PREFABRICATED METAL CANOPY WITH PRIMED & PAINTED FINISH "DE6328 ANCHOR GRAY"
- 5 FAUX STONE VENEER - "SEDONA QUICK FIT WALNUT" WITH WIDER MATCHING LEDGESTONE WATER TABLE TOP CAP
- 6 ALUMINUM DOOR & SIDELIGHT STOREFRONT WITH ANODIZED FINISH TO MATCH "DE6328 ANCHOR GRAY" AND DUAL-PANE INSULATED GLAZING - SEE DOOR SCHEDULE & DOOR TYPE ELEVATIONS SHEET
- 7 ALUMINUM STOREFRONT WINDOWS WITH ANODIZED FINISH TO MATCH "DE6328 ANCHOR GRAY" AND DUAL-PANE INSULATED GLAZING - SEE WINDOW TYPE ELEVATIONS
- 8 HOLLOW METAL DOOR & FRAME WITH PRIMED AND PAINTED FINISH "DE6328 ANCHOR GRAY" - SEE DOOR SCHEDULE & DOOR TYPE ELEVATIONS SHEET
- 9 WALL-MOUNTED LIGHT SCONCE FIXTURE WITH DARK BRONZE ANODIZED FINISH - SEE ELECTRICAL DRAWINGS
- 10 E.I.F.S. OVER HEADER TRIM WITH PRIMED & PAINTED FINISH "DE6125 CARVED WOOD"
- 11 DOOR-MOUNTED SIGNAGE TO READ "FIRE SPRINKLER RISER ROOM"
- 12 PARAPET SHOWN BEYOND
- 13 FINISH GRADE - SEE CIVIL DRAWINGS
- 14 DOOR-MOUNTED SIGNAGE TO READ "ELECTRICAL SERVICE ENTRANCE ROOM"

NOTE: ALL ROOF & OVERFLOW DRAIN LEADERS ARE INTERNALIZED AT INTERIOR FACE OF EXTERIOR WALLS AND ARE NOT VISIBLE

TOTAL BLDG. EXTERIOR MATERIAL %

EXTERIOR INSULATION FINISH SYSTEM (E.I.F.S.)	=	2,663 SF	(45%)
FAUX STONE VENEER	=	2,593 SF	(44%)
ALUMINUM STOREFRONT DOOR & WDW. FRAMES	=	141 SF	(2%)
DOOR & WINDOW GLAZING	=	284 SF	(5%)
METAL CANOPIES, H.M. DOORS & FRAMES, COPING	=	241 SF	(4%)
TOTAL BUILDING	=	5,922 SF	(100%)

Sketch
Architecture Company
2454 East Southern Avenue, Mesa, Arizona 85205 | ph: 480.888.8022

FAMILY FIRST PHYSICIANS - BUILDING 2
2345 EAST SOUTHERN AVENUE, MESA, ARIZONA 85204



SAC Project Number
2021-3


WEST & NORTH
EXTERIOR
ELEVATIONS

A201

CONSTRUCTION OF BUILDING: ALL MATERIALS, FINISHES, ELEVATIONS, AND DETAILS ARE TO BE AS SHOWN ON THESE DRAWINGS. THE CONTRACTOR SHALL BE RESPONSIBLE FOR OBTAINING ALL NECESSARY PERMITS AND APPROVALS FROM THE LOCAL, STATE, AND FEDERAL AUTHORITIES. THE CONTRACTOR SHALL BE RESPONSIBLE FOR OBTAINING ALL NECESSARY PERMITS AND APPROVALS FROM THE LOCAL, STATE, AND FEDERAL AUTHORITIES. THE CONTRACTOR SHALL BE RESPONSIBLE FOR OBTAINING ALL NECESSARY PERMITS AND APPROVALS FROM THE LOCAL, STATE, AND FEDERAL AUTHORITIES.



1 EAST EXTERIOR ELEVATION
SCALE: 1/4"= 1'-0"

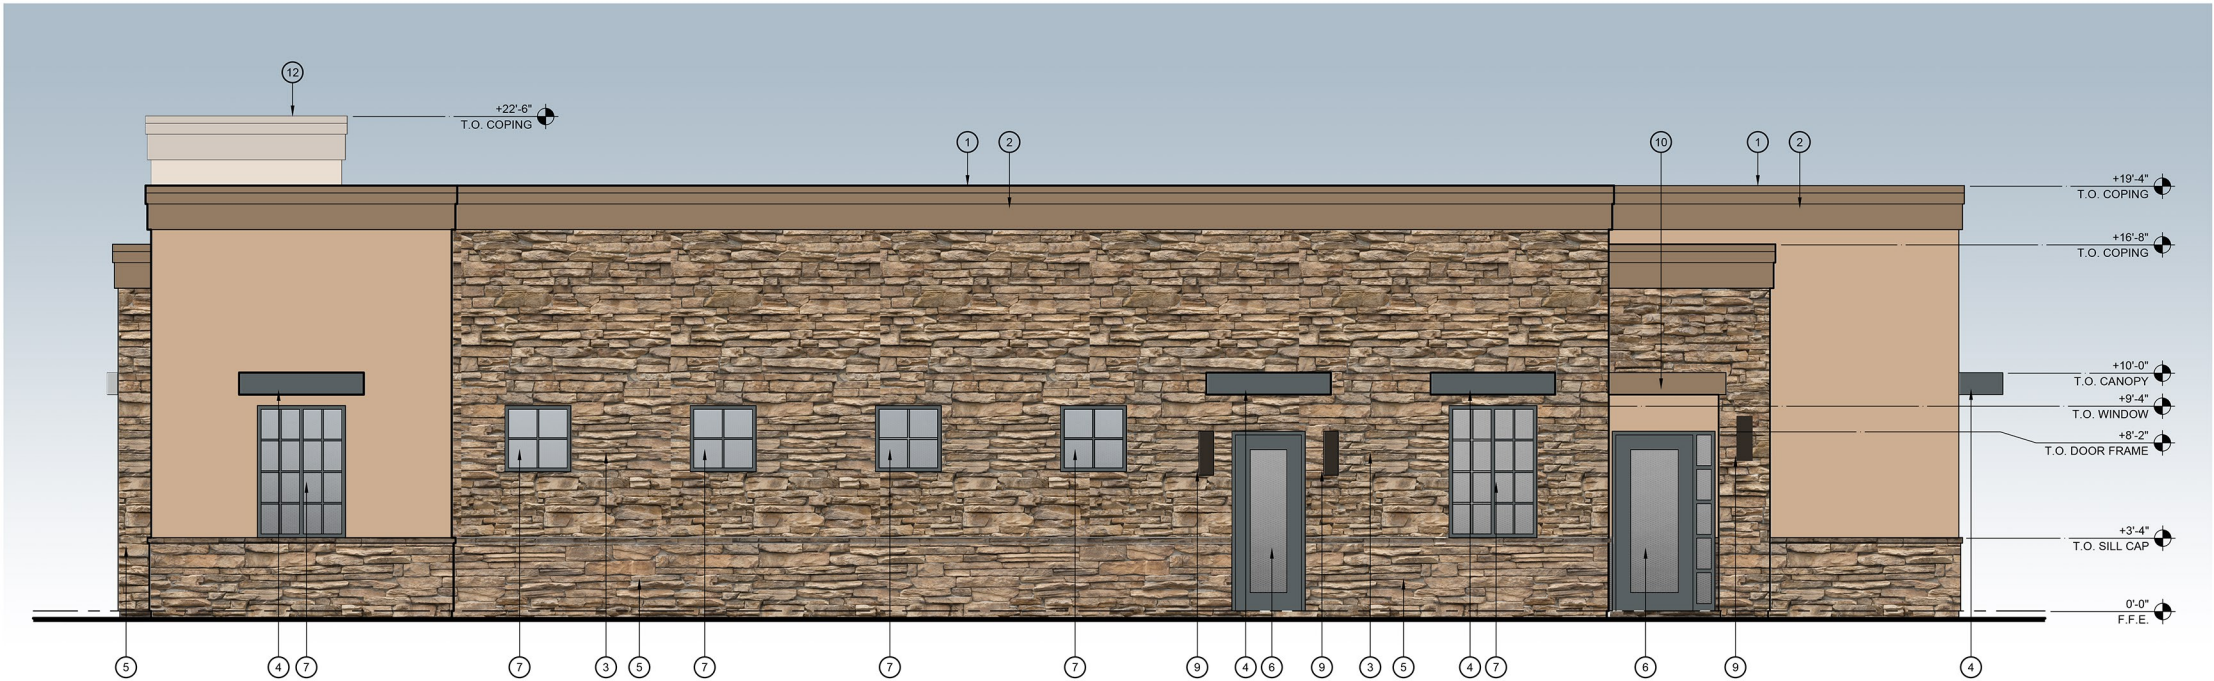

2 SOUTH EXTERIOR ELEVATION
SCALE: 1/4"= 1'-0"

KEYNOTES

- 1 METAL COPING CAP AT TOP OF CORNICE WITH PRIMED & PAINTED FINISH "DE6125 CARVED WOOD"
- 2 E.I.F.S. ON PREFORMED CORNICE WITH PRIMED & PAINTED FINISH "DE6125 CARVED WOOD"
- 3 E.I.F.S. ON FIELD EXTERIOR WALLS WITH PRIMED & PAINTED FINISH "DE6116 DOVER PLAINS"
- 4 PREFABRICATED METAL CANOPY WITH PRIMED & PAINTED FINISH "DE6328 ANCHOR GRAY"
- 5 FAUX STONE VENEER - "SEDONA QUICK FIT WALNUT" WITH WIDER MATCHING LEDGESTONE WATER TABLE TOP CAP
- 6 ALUMINUM DOOR & SIDELIGHT STOREFRONT WITH ANODIZED FINISH TO MATCH "DE6328 ANCHOR GRAY" AND DUAL-PANE INSULATED GLAZING - SEE DOOR SCHEDULE & DOOR TYPE ELEVATIONS SHEET
- 7 ALUMINUM STOREFRONT WINDOWS WITH ANODIZED FINISH TO MATCH "DE6328 ANCHOR GRAY" AND DUAL-PANE INSULATED GLAZING - SEE WINDOW TYPE ELEVATIONS
- 8 HOLLOW METAL DOOR & FRAME WITH PRIMED AND PAINTED FINISH "DE6328 ANCHOR GRAY" - SEE DOOR SCHEDULE & DOOR TYPE ELEVATIONS SHEET
- 9 WALL-MOUNTED LIGHT SCORCE FIXTURE WITH DARK BRONZE ANODIZED FINISH - SEE ELECTRICAL DRAWINGS
- 10 E.I.F.S. OVER HEADER TRIM WITH PRIMED & PAINTED FINISH "DE6125 CARVED WOOD"
- 11 DOOR-MOUNTED SIGNAGE TO READ "FIRE SPRINKLER RISER ROOM"
- 12 PARAPET SHOWN BEYOND
- 13 FINISH GRADE - SEE CIVIL DRAWINGS
- 14 DOOR-MOUNTED SIGNAGE TO READ "ELECTRICAL SERVICE ENTRANCE ROOM"

NOTE: ALL ROOF & OVERFLOW DRAIN LEADERS ARE INTERNALIZED AT INTERIOR FACE OF EXTERIOR WALLS AND ARE NOT VISIBLE

TOTAL BLDG. EXTERIOR MATERIAL %

EXTERIOR INSULATION FINISH SYSTEM (E.I.F.S.)	=	2,663 SF	(45%)
FAUX STONE VENEER	=	2,593 SF	(44%)
ALUMINUM STOREFRONT DOOR & WDW. FRAMES	=	141 SF	(2%)
DOOR & WINDOW GLAZING	=	284 SF	(5%)
METAL CANOPIES, H.M. DOORS & FRAMES, COPING	=	241 SF	(4%)
TOTAL BUILDING	=	5,922 SF	(100%)

Sketch
Architecture Company
2451 East Southern Avenue, Mesa, Arizona 85205 ph: 480.858.8015 fax: 480.858.8022

FAMILY FIRST PHYSICIANS - BUILDING 2
2345 EAST SOUTHERN AVENUE, MESA, ARIZONA 85204




SAC Project Number
2021-3


EAST & SOUTH
EXTERIOR
ELEVATIONS

A202

COPYRIGHT © 2021 BY SKETCH ARCHITECTURE COMPANY. ALL RIGHTS RESERVED. THIS DOCUMENT IS THE PROPERTY OF SKETCH ARCHITECTURE COMPANY. IT IS TO BE USED FOR THE PROJECT AND SITE SPECIFICALLY IDENTIFIED IN THE TITLE BLOCK. NO PART OF THIS DOCUMENT IS TO BE REPRODUCED OR TRANSMITTED IN ANY FORM OR BY ANY MEANS, ELECTRONIC OR MECHANICAL, INCLUDING PHOTOCOPYING, RECORDING, OR BY ANY INFORMATION STORAGE AND RETRIEVAL SYSTEM, WITHOUT THE WRITTEN PERMISSION OF SKETCH ARCHITECTURE COMPANY. THE PROJECT NAME, ADDRESS, AND DATE OF PREPARATION ARE TO BE FURNISHED BY THE CLIENT. THE PROJECT NAME, ADDRESS, AND DATE OF PREPARATION ARE TO BE FURNISHED BY THE CLIENT. THE PROJECT NAME, ADDRESS, AND DATE OF PREPARATION ARE TO BE FURNISHED BY THE CLIENT.

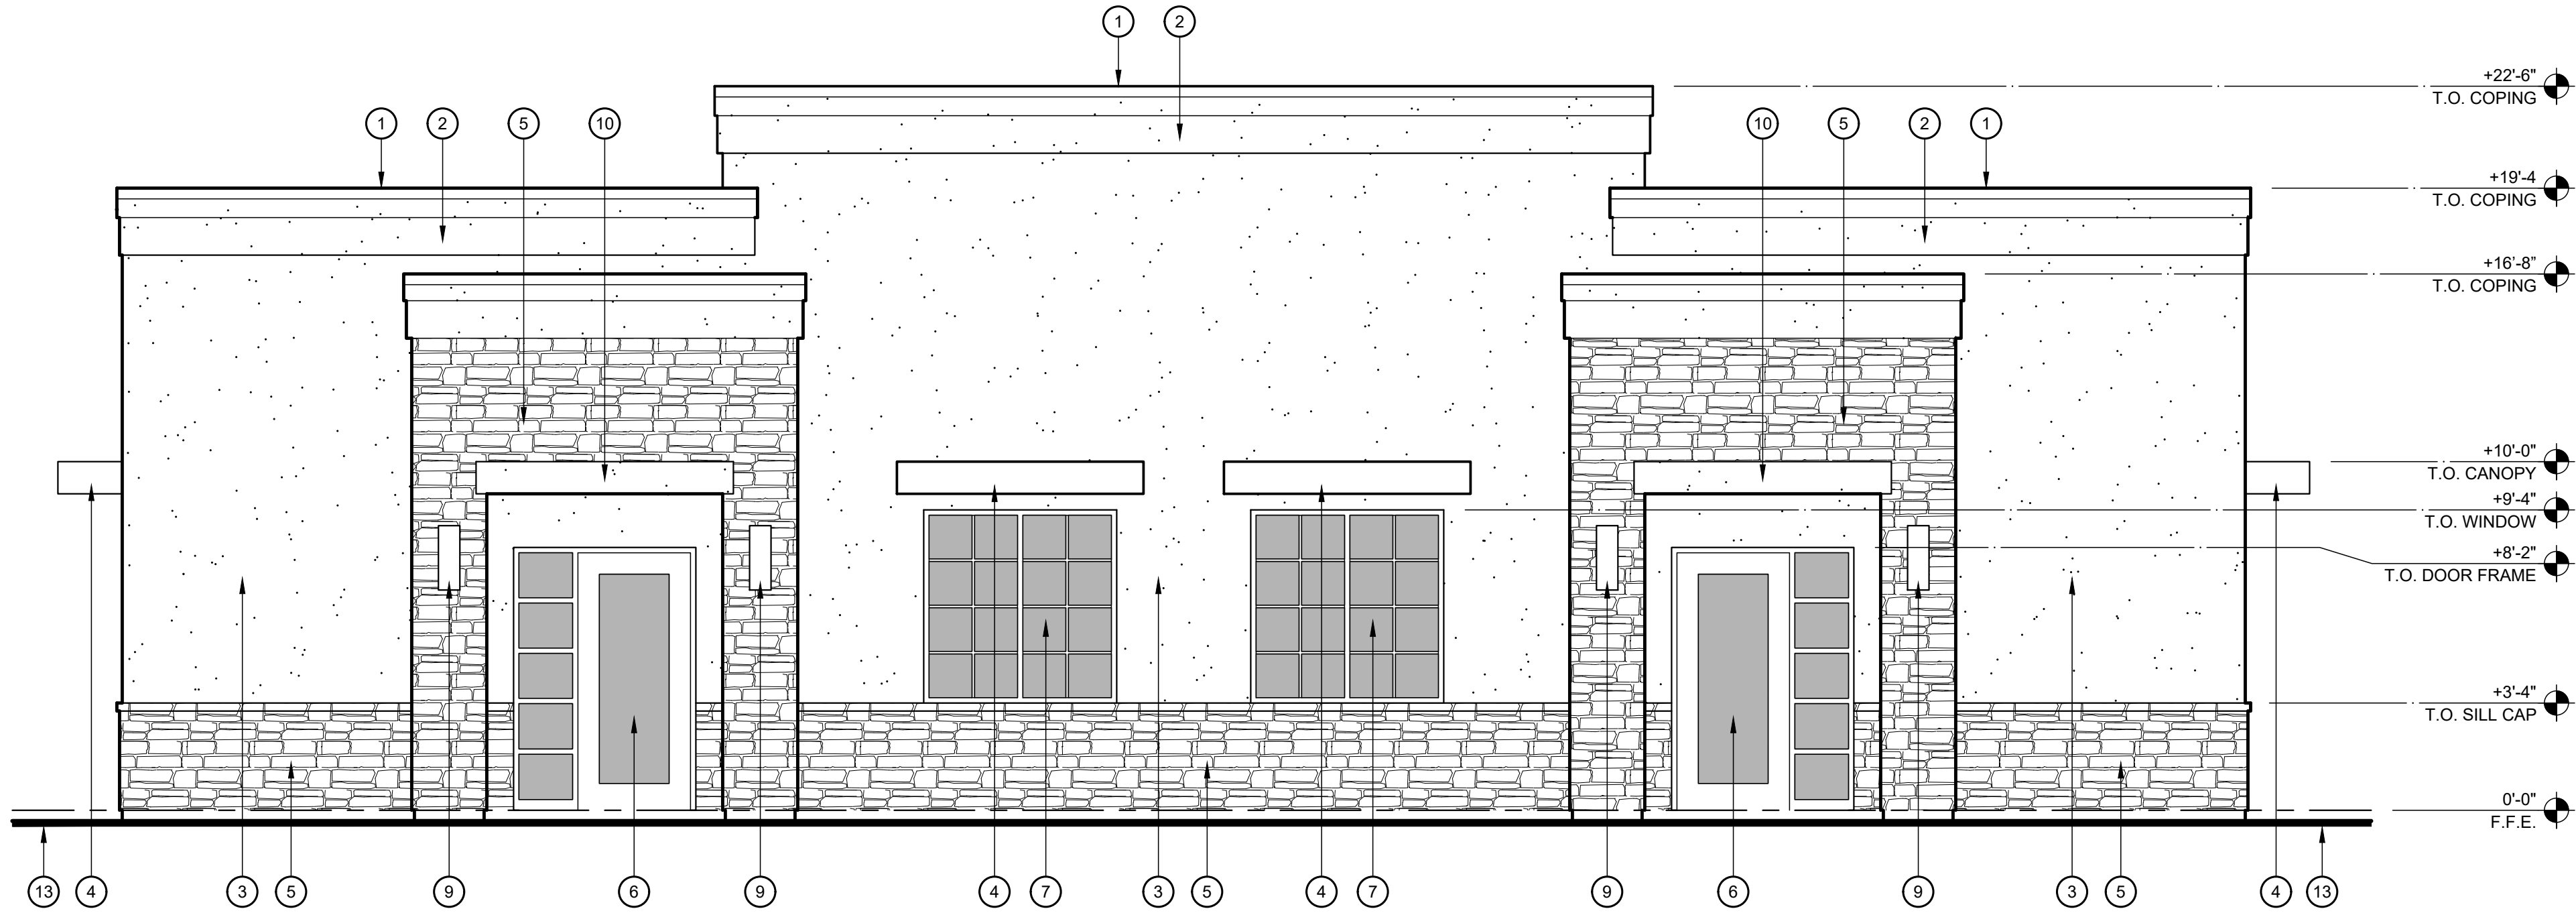

1 WEST EXTERIOR ELEVATION
SCALE: 1/4"= 1'-0"

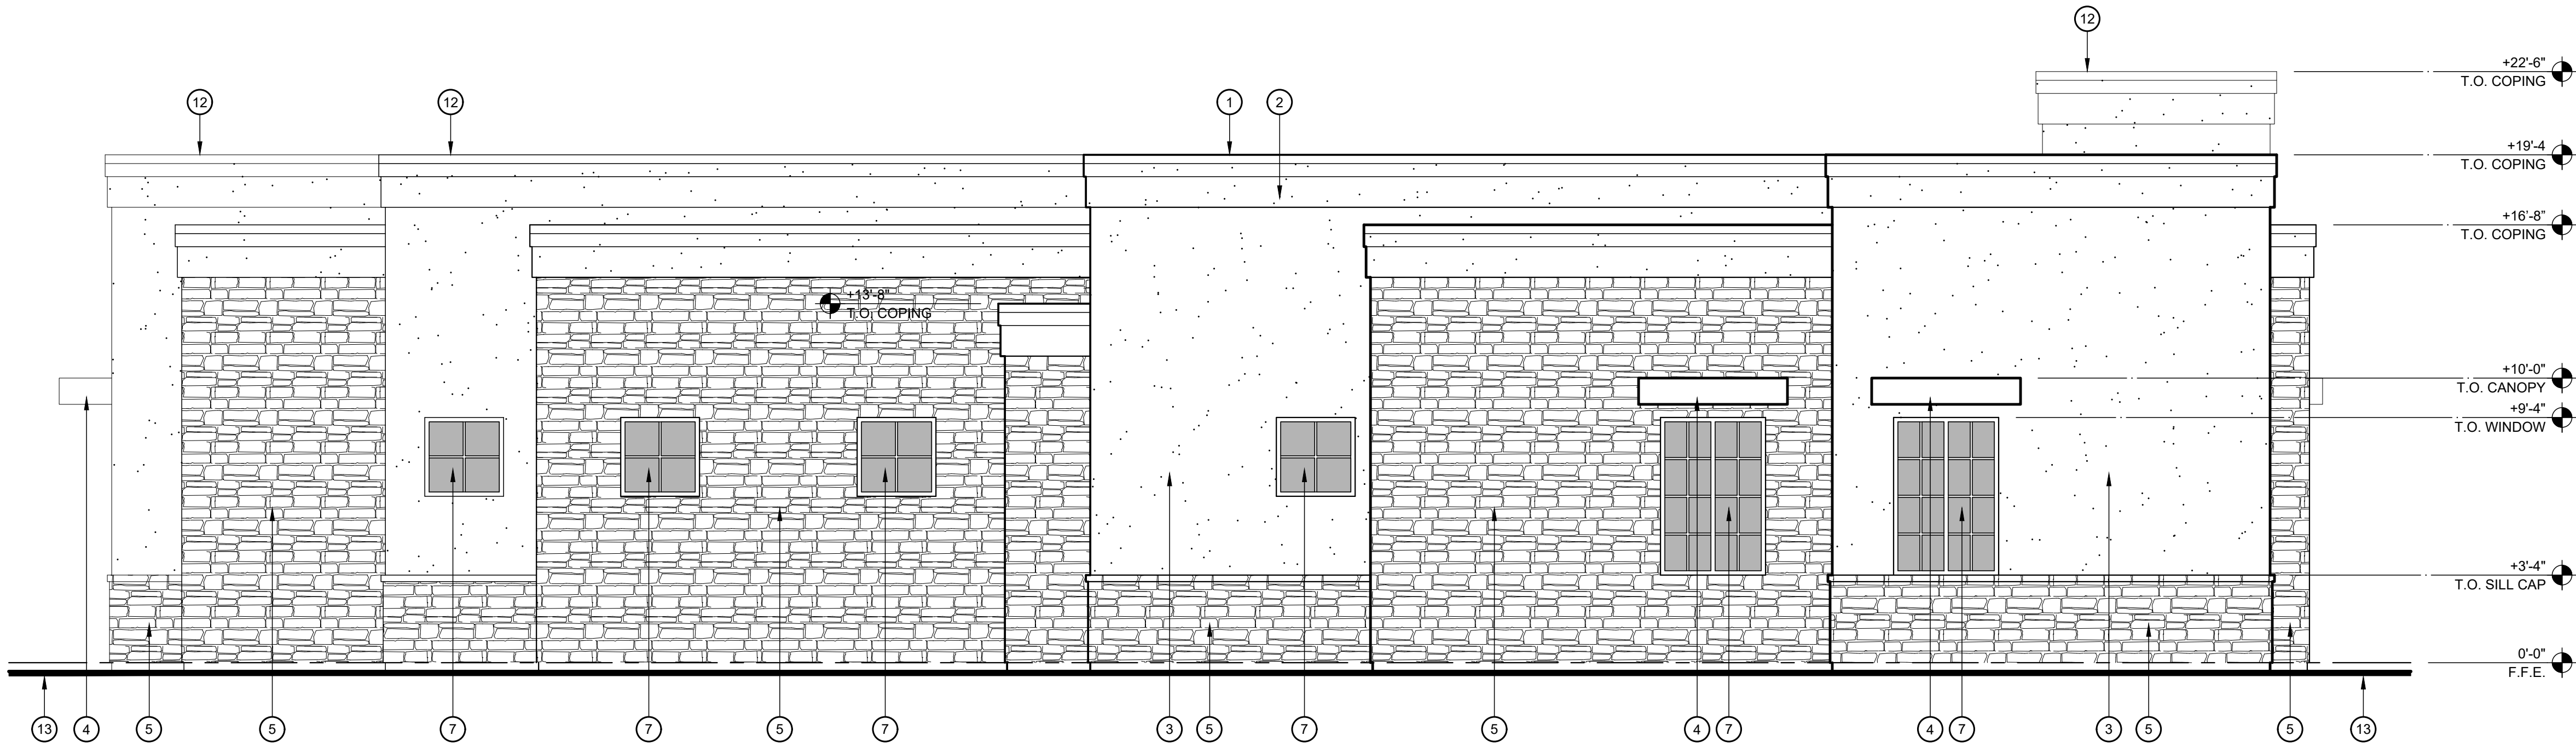

2 NORTH EXTERIOR ELEVATION
SCALE: 1/4"= 1'-0"

KEYNOTES

- METAL COPING CAP AT TOP OF CORNICE WITH PRIMED & PAINTED FINISH "DE6125 CARVED WOOD"
- E.I.F.S. ON PREFORMED CORNICE WITH PRIMED & PAINTED FINISH "DE6125 CARVED WOOD"
- E.I.F.S. ON FIELD EXTERIOR WALLS WITH PRIMED & PAINTED FINISH "DE6116 DOVER PLAINS"
- PREFABRICATED METAL CANOPY WITH PRIMED & PAINTED FINISH "DE6328 ANCHOR GRAY"
- FAUX STONE VENEER - "SEDONA QUICK FIT WALNUT" WITH WIDER MATCHING LEDGESTONE WATER TABLE TOP CAP
- ALUMINUM DOOR & SIDELIGHT STOREFRONT WITH ANODIZED FINISH TO MATCH "DE6328 ANCHOR GRAY" AND DUAL-PANE INSULATED GLAZING - SEE DOOR SCHEDULE & DOOR TYPE ELEVATIONS SHEET
- ALUMINUM STOREFRONT WINDOWS WITH ANODIZED FINISH TO MATCH "DE6328 ANCHOR GRAY" AND DUAL-PANE INSULATED GLAZING - SEE WINDOW TYPE ELEVATIONS
- HOLLOW METAL DOOR & FRAME WITH PRIMED AND PAINTED FINISH "DE6328 ANCHOR GRAY" - SEE DOOR SCHEDULE & DOOR TYPE ELEVATIONS SHEET
- WALL-MOUNTED LIGHT SCONCE FIXTURE WITH DARK BRONZE ANODIZED FINISH - SEE ELECTRICAL DRAWINGS
- E.I.F.S. OVER HEADER TRIM WITH PRIMED & PAINTED FINISH "DE6125 CARVED WOOD"
- DOOR-MOUNTED SIGNAGE TO READ "FIRE SPRINKLER RISER ROOM"
- PARAPET SHOWN BEYOND
- FINISH GRADE - SEE CIVIL DRAWINGS
- DOOR-MOUNTED SIGNAGE TO READ "ELECTRICAL SERVICE ENTRANCE ROOM"

NOTE: ALL ROOF & OVERFLOW DRAIN LEADERS ARE INTERNALIZED AT INTERIOR FACE OF EXTERIOR WALLS AND ARE NOT VISIBLE

TOTAL BLDG. EXTERIOR MATERIAL %

EXTERIOR INSULATION FINISH SYSTEM (E.I.F.S.)	=	2,663 SF	(45%)
FAUX STONE VENEER	=	2,593 SF	(44%)
ALUMINUM STOREFRONT DOOR & WDW. FRAMES	=	141 SF	(2%)
DOOR & WINDOW GLAZING	=	284 SF	(5%)
METAL CANOPIES, H.M. DOORS & FRAMES, COPING	=	241 SF	(4%)
TOTAL BUILDING	=	5,922 SF	(100%)

Sketch
Architecture Company
2044 East Southern Avenue, Mesa, Arizona 85205 ph 480.666.8016 fw 480.666.8032

FAMILY FIRST PHYSICIANS - BUILDING 2
2345 EAST SOUTHERN AVENUE, MESA, ARIZONA 85204



SAC Project Number
2021-3

WEST & NORTH
EXTERIOR
ELEVATIONS

A201



- ① METAL COPING CAP AT TOP OF CORNICE WITH PRIMED & PAINTED FINISH "DE6125 CARVED WOOD"
- ② E.I.F.S. ON PREFORMED CORNICE WITH PRIMED & PAINTED FINISH "DE6125 CARVED WOOD"
- ③ E.I.F.S. ON FIELD EXTERIOR WALLS WITH PRIMED & PAINTED FINISH "DE6116 DOVER PLAINS"
- ④ PREFABRICATED METAL CANOPY WITH PRIMED & PAINTED FINISH "DE6328 ANCHOR GRAY"
- ⑤ FAUX STONE VENEER - "SEDONA QUICK FIT WALNUT" WITH WIDER MATCHING LEDGESTONE WATER TABLE TOP CAP
- ⑥ ALUMINUM DOOR & SIDELIGHT STOREFRONT WITH ANODIZED FINISH TO MATCH "DE6328 ANCHOR GRAY" AND DUAL-PANE INSULATED GLAZING - SEE DOOR SCHEDULE & DOOR TYPE ELEVATIONS SHEET
- ⑦ ALUMINUM STOREFRONT WINDOWS WITH ANODIZED FINISH TO MATCH "DE6328 ANCHOR GRAY" AND DUAL-PANE INSULATED GLAZING - SEE WINDOW TYPE ELEVATIONS
- ⑧ HOLLOW METAL DOOR & FRAME WITH PRIMED AND PAINTED FINISH "DE6328 ANCHOR GRAY" - SEE DOOR SCHEDULE & DOOR TYPE ELEVATIONS SHEET
- ⑨ WALL-MOUNTED LIGHT SCENE FIXTURE WITH DARK BRONZE ANODIZED FINISH - SEE ELECTRICAL DRAWINGS
- ⑩ E.I.F.S. OVER HEADER TRIM WITH PRIMED & PAINTED FINISH "DE6125 CARVED WOOD"
- ⑪ DOOR-MOUNTED SIGNAGE TO READ "FIRE SPRINKLER RISER ROOM"
- ⑫ PARAPET SHOWN BEYOND
- ⑬ FINISH GRADE - SEE CIVIL DRAWINGS
- ⑭ DOOR-MOUNTED SIGNAGE TO READ "ELECTRICAL SERVICE ENTRANCE ROOM"

ITEM	QTY	UNIT	PRICE	TOTAL
1.00	1.00	sq. ft.	1.00	1.00
2.00	2.00	sq. ft.	2.00	2.00
3.00	3.00	sq. ft.	3.00	3.00
67.00	67.00	sq. ft.	67.00	67.00
68.00	68.00	sq. ft.	68.00	68.00</

EXTERIOR INSULATION FINISH SYSTEM (E.I.F.S.)	=	2,663 SF	(45%)
FAUX STONE VENEER	=	2,593 SF	(44%)
ALUMINUM STOREFRONT DOOR & WDW. FRAMES	=	141 SF	(2%)
DOOR & WINDOW GLAZING	=	284 SF	(5%)
METAL CANOPIES, H.M. DOORS & FRAMES, COPING	=	241 SF	(4%)
TOTAL BUILDING		5,922 SF	(100%)



SAC Project Number
2021-3

EAST & SOUTH
EXTERIOR
ELEVATIONS

A202