


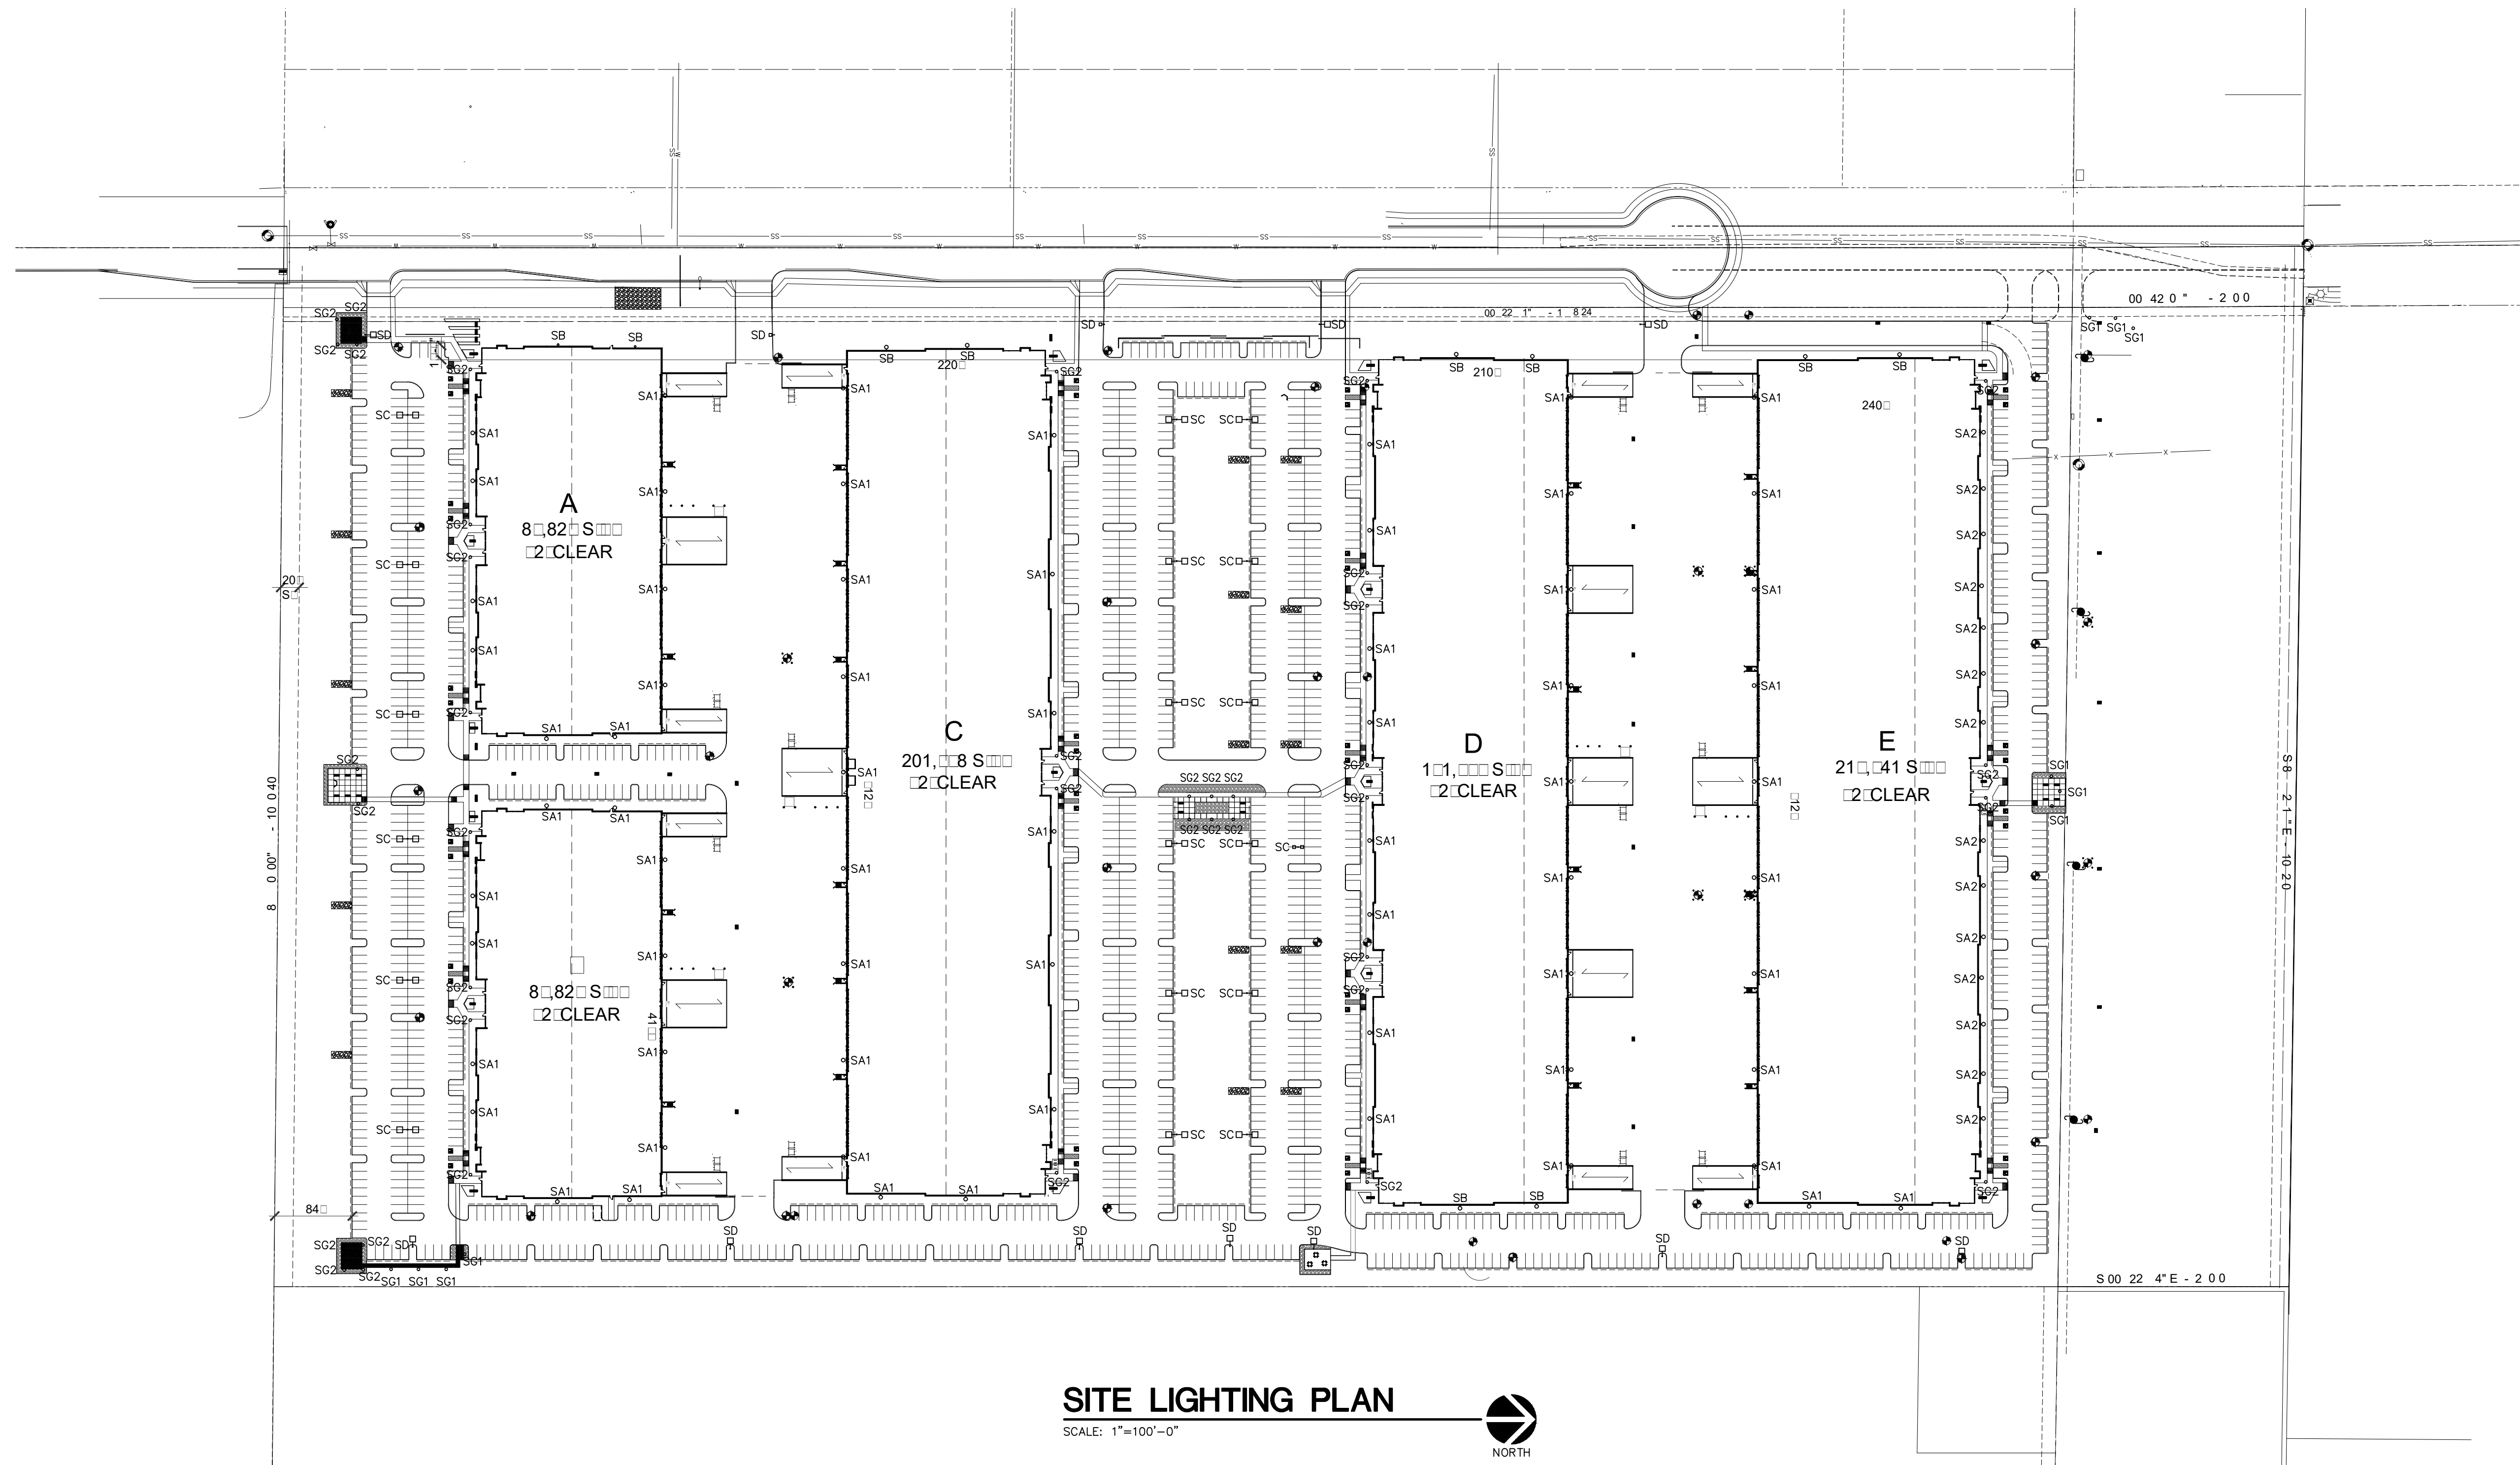

SITE LIGHTING PLAN

SCALE: 1"=100'-0"




Eisenberg Company
Full service commercial real estate

MET202


Elliot Road & Crimson Alignment
Mesa, Arizona

E0.1

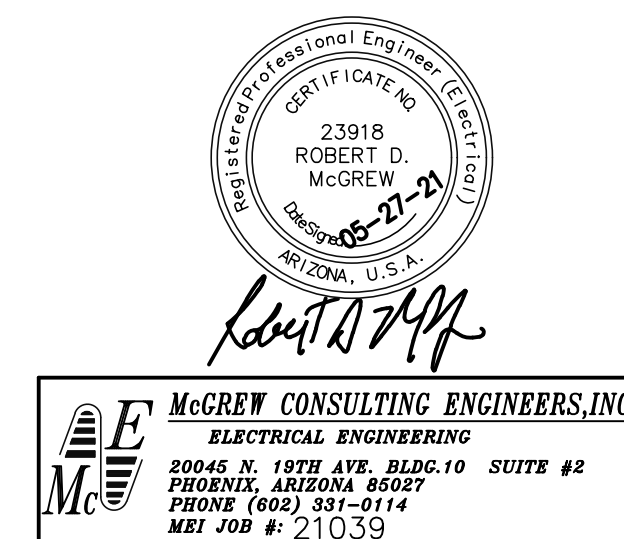

Butler Design Group, Inc.
architects & planners

05/27/21 R1
04-01-21
21000-ST08

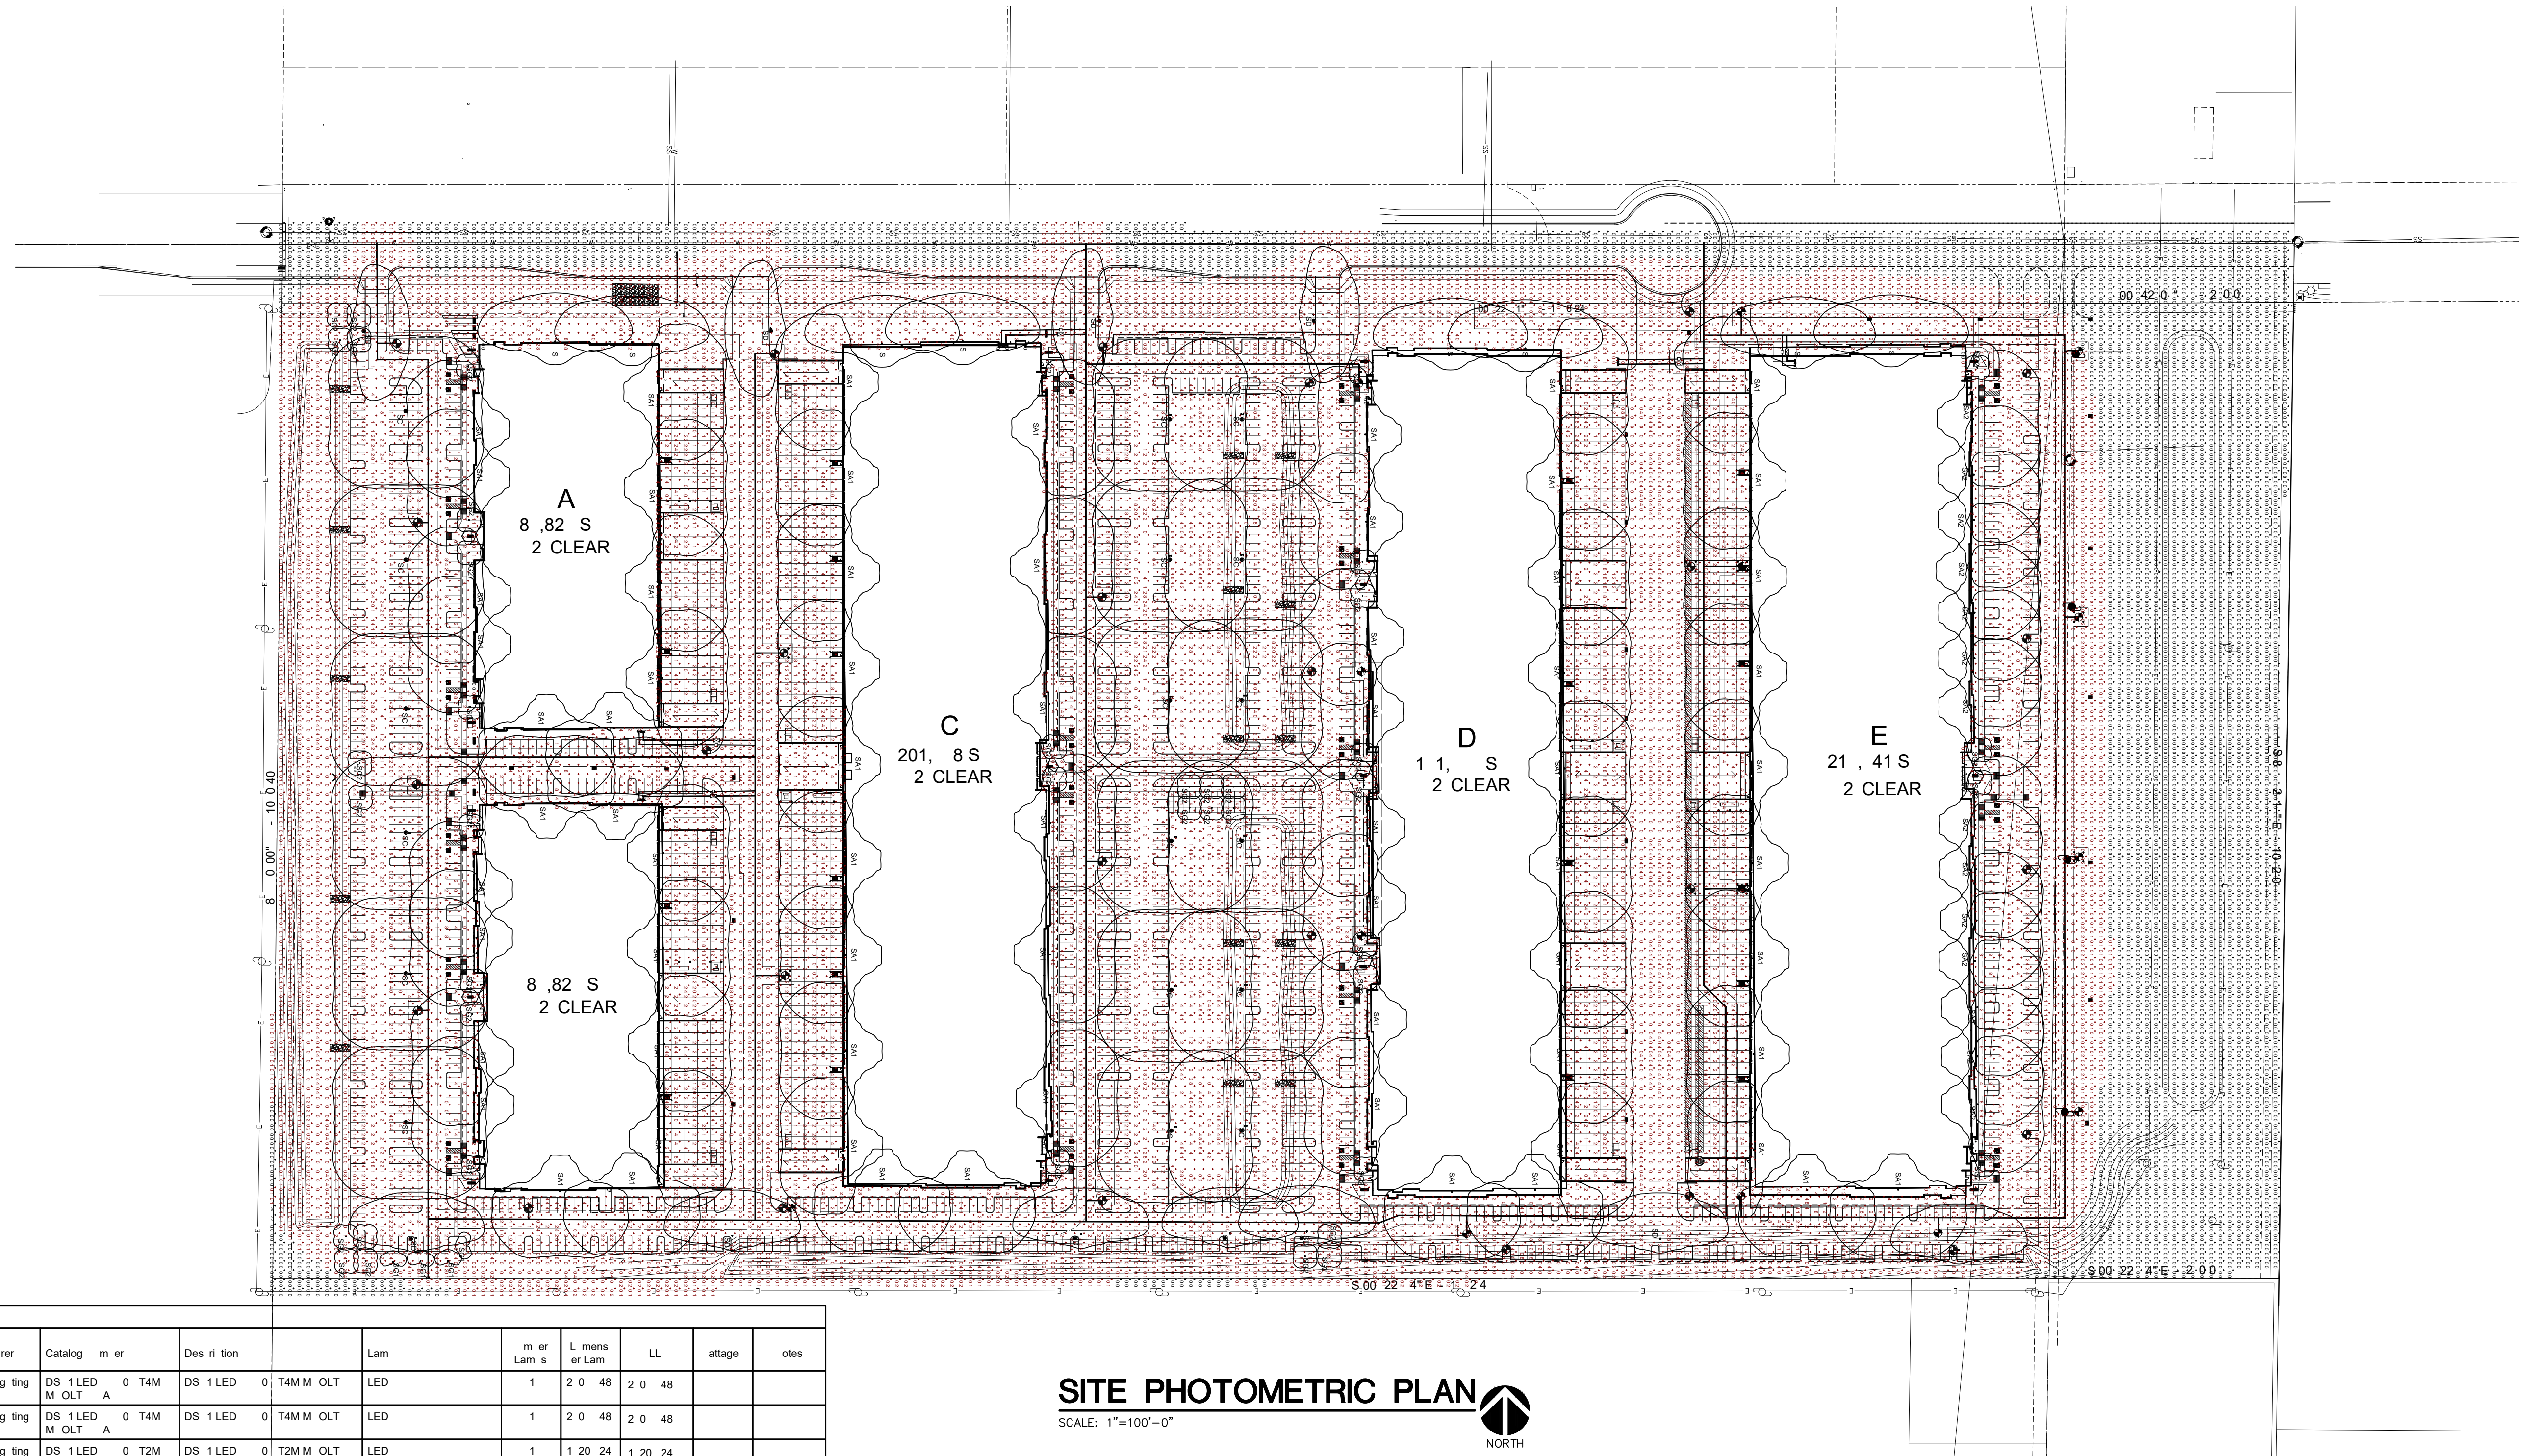

SITE PHOTOMETRIC PLAN
SCALE: 1"=100'-0"


Schedule											
Symbol	Label	T	Manufacturer	Catalog Number	Description	Lamp	Number of Lamps	Lumen per Lamp	LL	Attachment	Notes
SA1	SA1	1	Litonia Lighting	DS 1 LED 0 T4M M OLT A	DS 1 LED 0 T4M M OLT	LED	1	2048	2048		
SA2	SA2	14	Litonia Lighting	DS 1 LED 0 T4M M OLT A	DS 1 LED 0 T4M M OLT	LED	1	2048	2048		
S	S	1	Litonia Lighting	DS 1 LED 0 T2M M OLT A	DS 1 LED 0 T2M M OLT	LED	1	12024	12024		
SC	SC	18	Litonia Lighting	DS 1 LED 0 T M OLT SSS 22 O A2 ASE	DS 1 LED 0 T M OLT	LED	1	24048	24048		
SD	SD		Litonia Lighting	DS 0 LED 0 T2M M OLT SSS 22 O A2 ASE	DS 0 LED 0 T2M M OLT	LED	1	12	12		
SG1	SG1	18	Selection	IL 42 0M 0 IIS DM	Cast grade minimum singlear last in los re	LED	1	844	844		
SG2	SG2	0	Selection	IL 44 0 IIS DM	Cast grade minimum singlear last in los re	LED	1	21014	21014		

Statistics						
Description	Symbol	Ag	Ma	Min	Ma Min	Ag Min
C.O. SITE AT GRADE	+	1	4	0.0	A	A

Eisenberg Company
Full service commercial real estate

MET202
Elliot Road & Crimson Alignment
Mesa, Arizona

E0.2

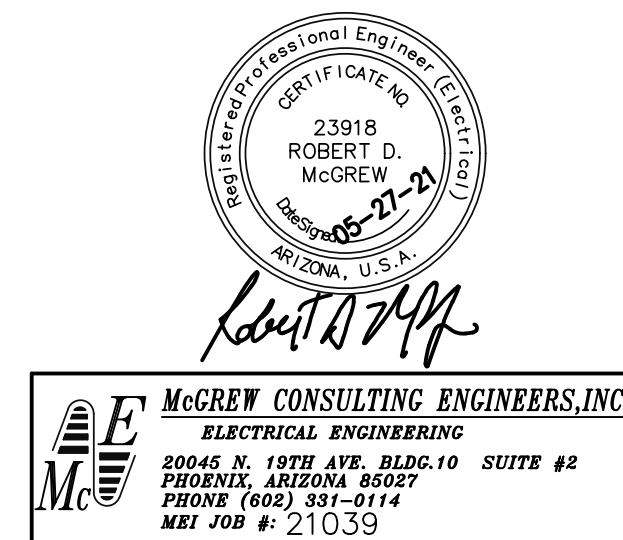

Butler Design Group, Inc.
architects & planners

05/27/21 R1
04-01-21
21000-ST08

